


ELEVATION - SERVICE ENTRANCE - LEASING OFFICE BUILDING

SCALE: NONE


4
E-11E-16

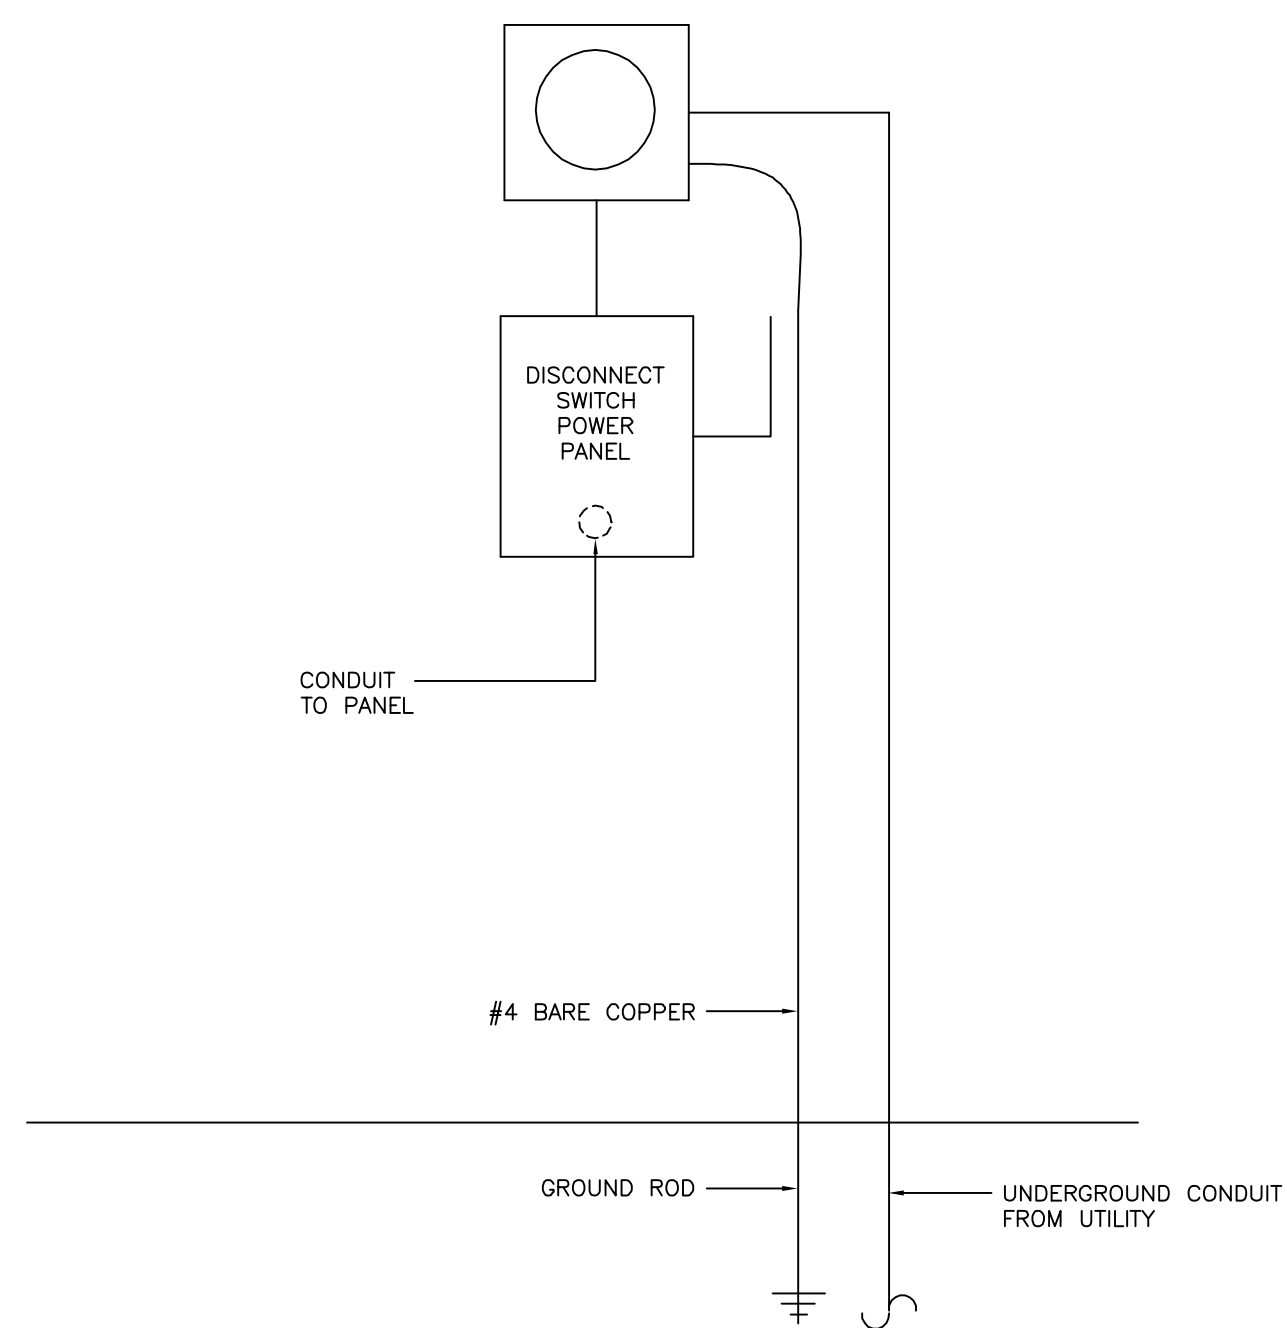


ELEVATION - SERVICE ENTRANCE - MAINTENANCE BUILDING

SCALE: NONE

5
E-11E-16

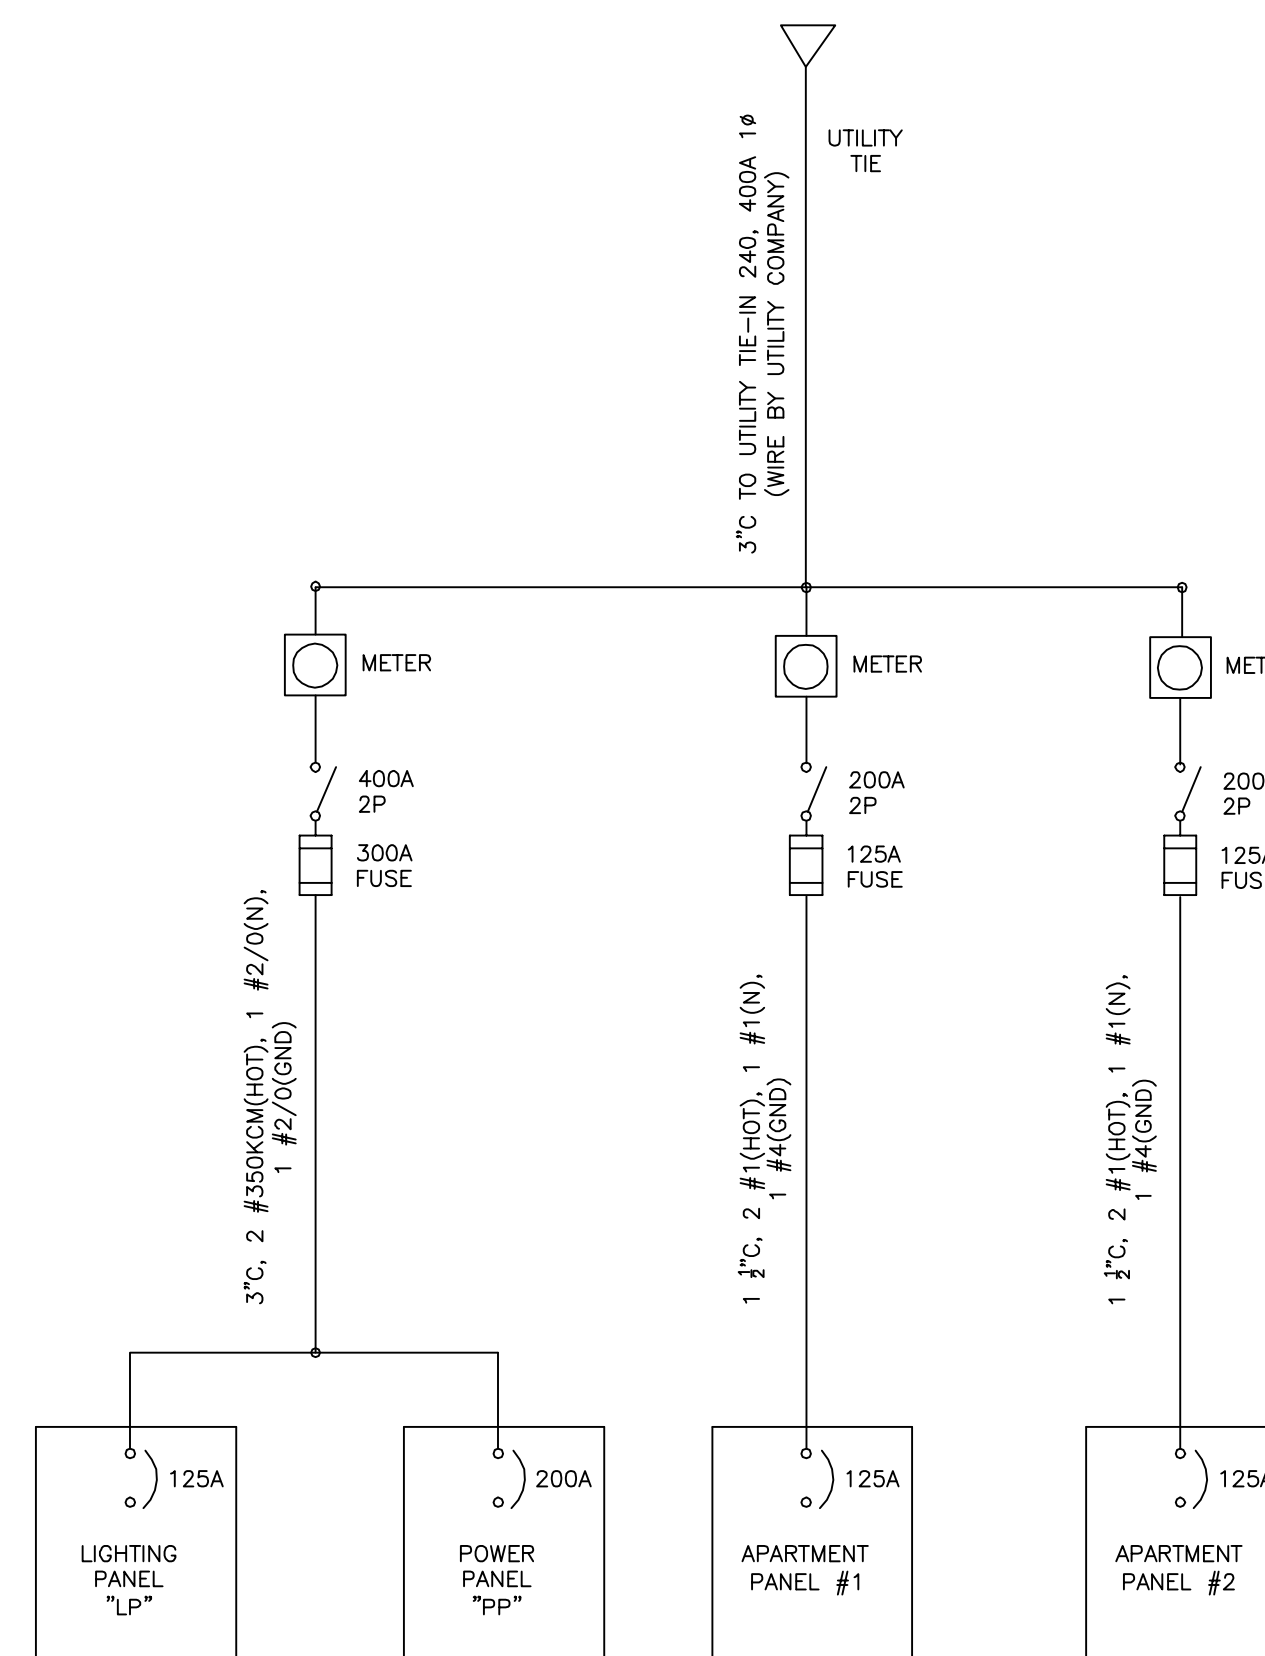

ONE LINE DIAGRAM - LEASING OFFICE BUILDING

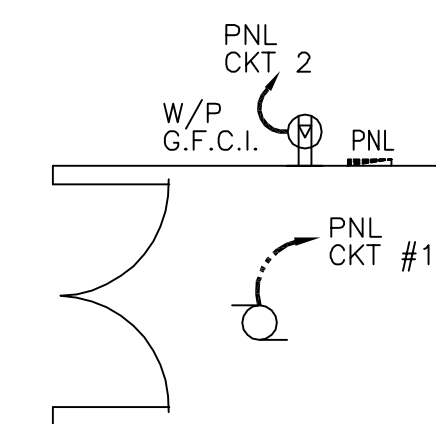

TYPICAL TRASH COMPACTOR POWER PLAN
SCALE: N.T.S.

THE BRYAN COMPANY

ISLAND PARK
APARTMENT COMMUNITY
SHREVEPORT, LA.

ISLAND PARK

DAMMON ENGINEERING, INC.
ARCHITECTS - ENGINEERS
819 ROBERT ROAD
SLIDELL, LA. 70458

SCALE: AS NOTED

FILE: -

JOB No.: -

DATE: 03-29-04

SHEET

E-16

OF -