

BLDG. SUMMARY
 1 - 1 BDRM HDCP SUITE
 8 - 1 BDRM SUITES
 1 - 2 BDRM SUITE

FLOOR PLAN BLDG. C

Note: Although every effort has been made in preparing these plans and checking them for accuracy, the contractor must check all dimensions, details and code requirements applicable in the area of construction and be responsible for same.


PLANS FOR:
Summerfield Retirement Community, LLC
 Brownsitch Rd. & Dauphine Street
 St. Tammany Parish, LA

LIVING AREA 7696 SQ. FT.
 COVERED ENTRY 44 SQ. FT.
 UNDER BEAM 7740 SQ. FT.


REVISIONS	BY
03/21/08	
08/28/08	

Drawn by
 Checked by
 Date 01/11/08
 Scale 3/16"=1'-0"
 Job No.


Sheet No.
C1

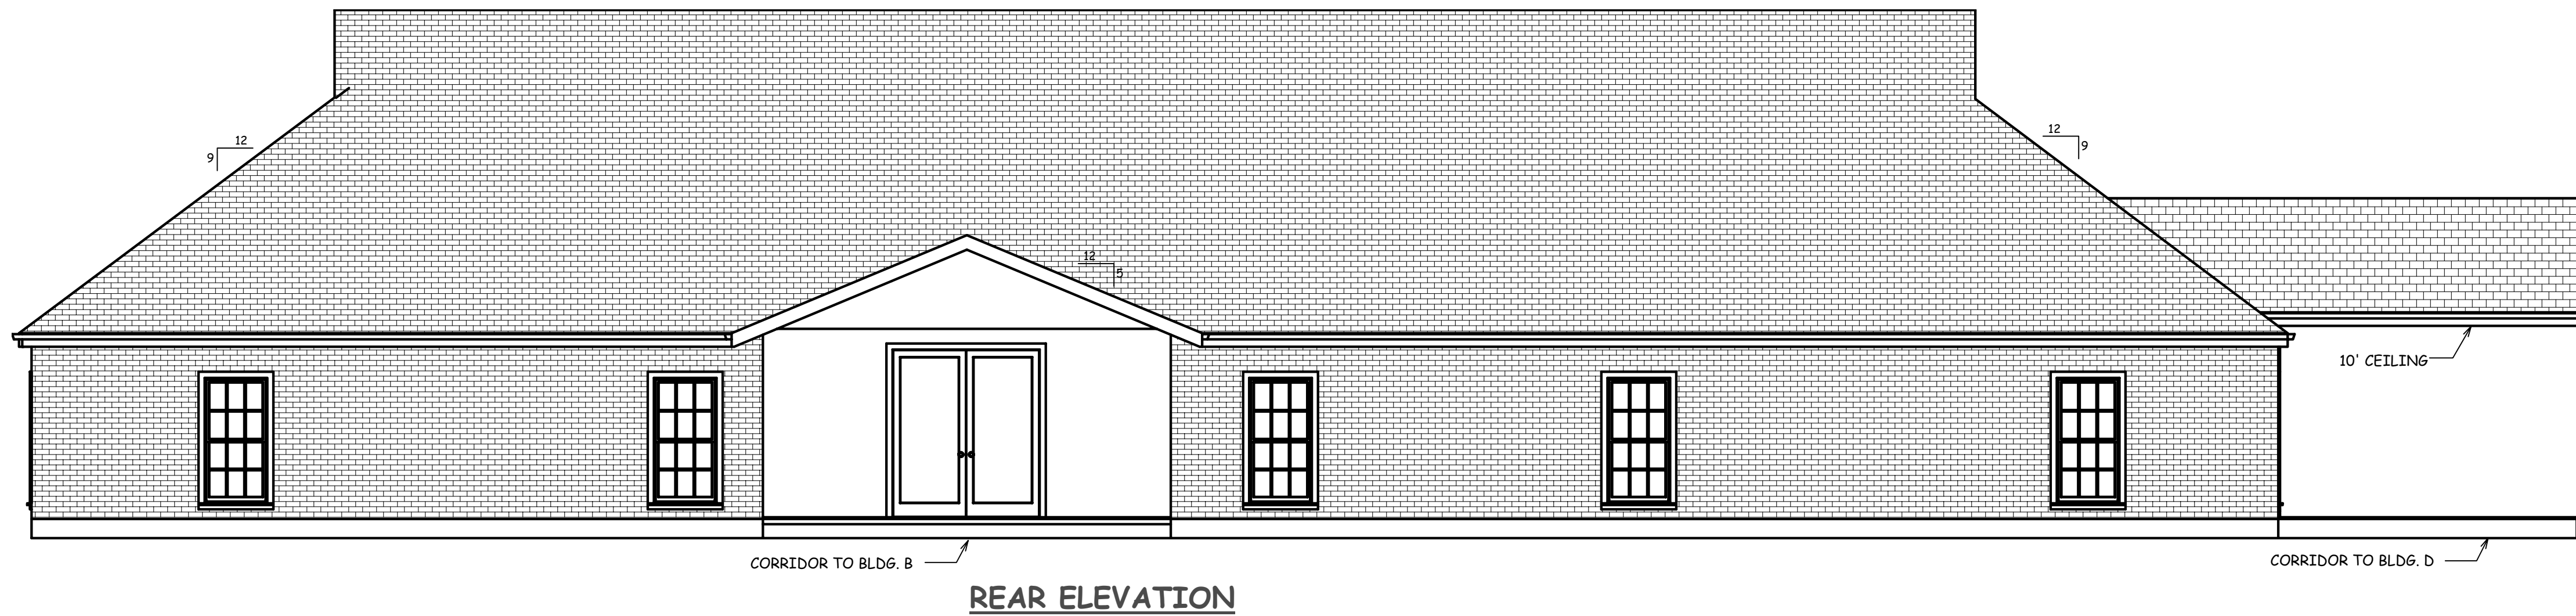


REAR ELEVATION

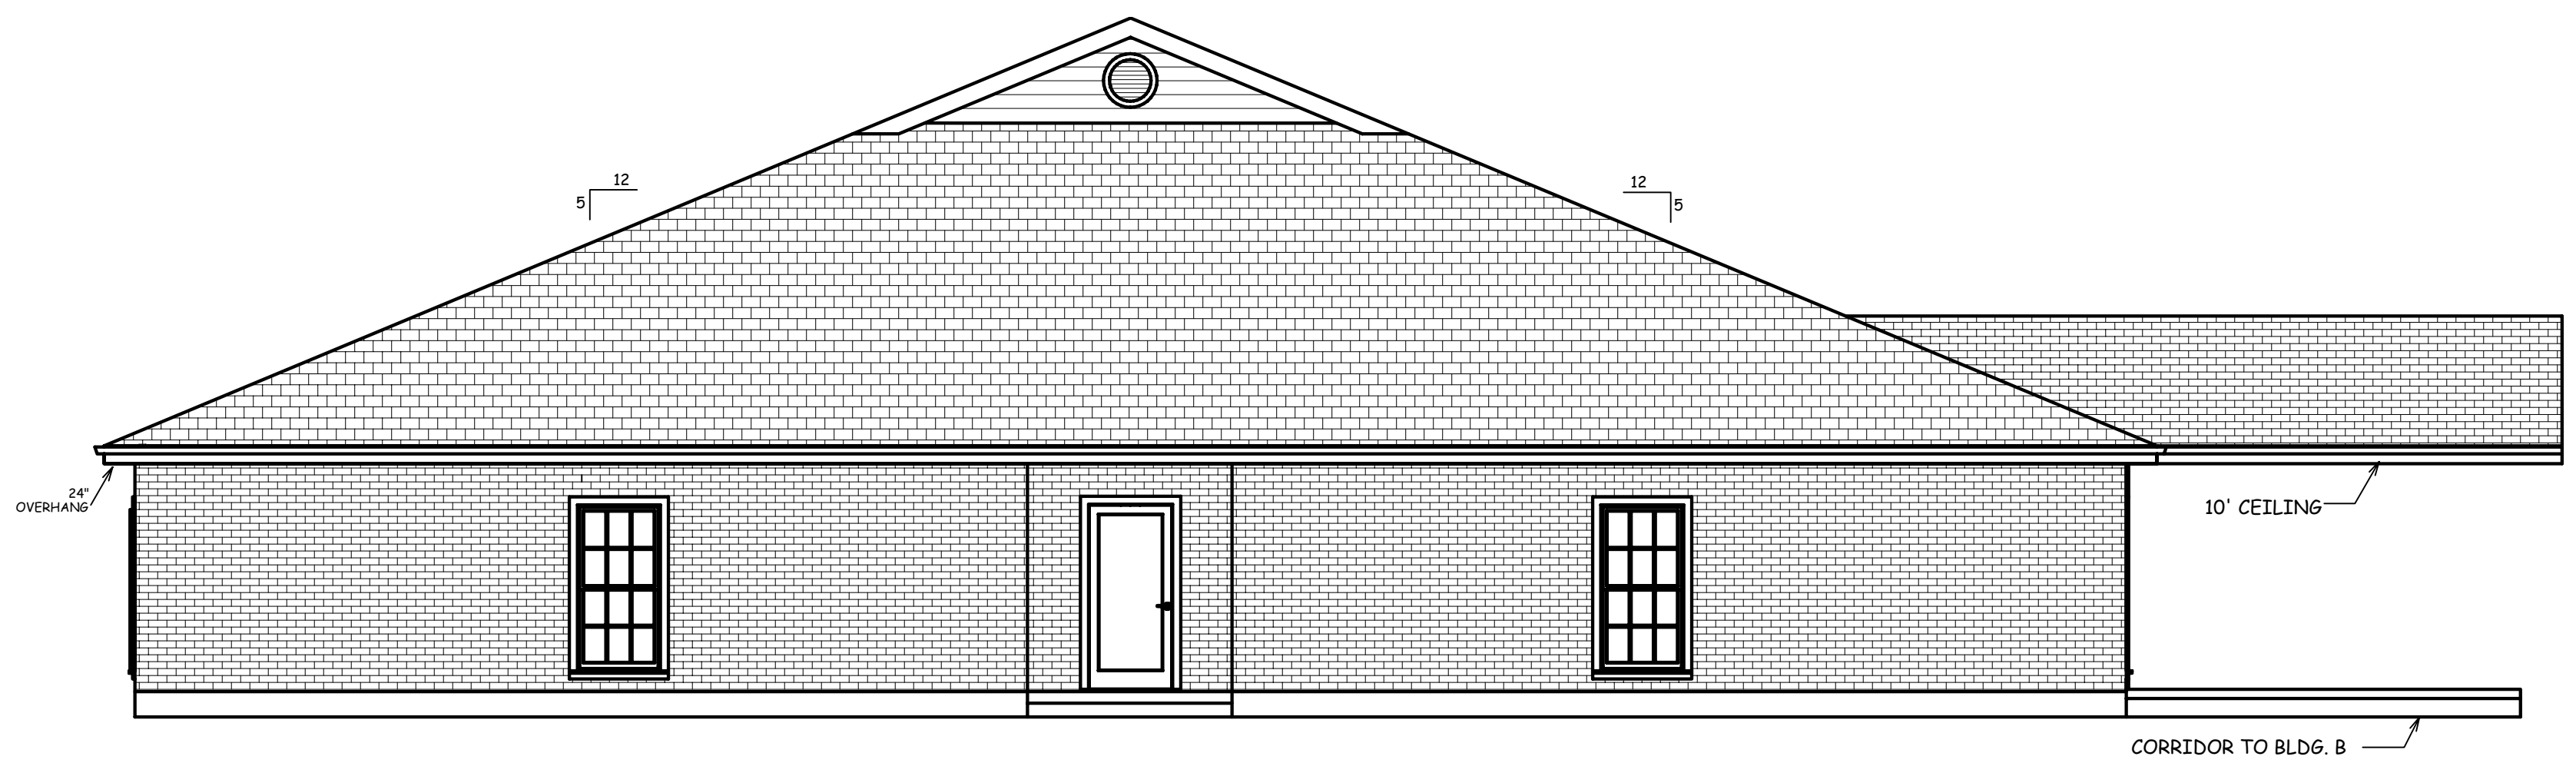

RIGHT SIDE ELEVATION

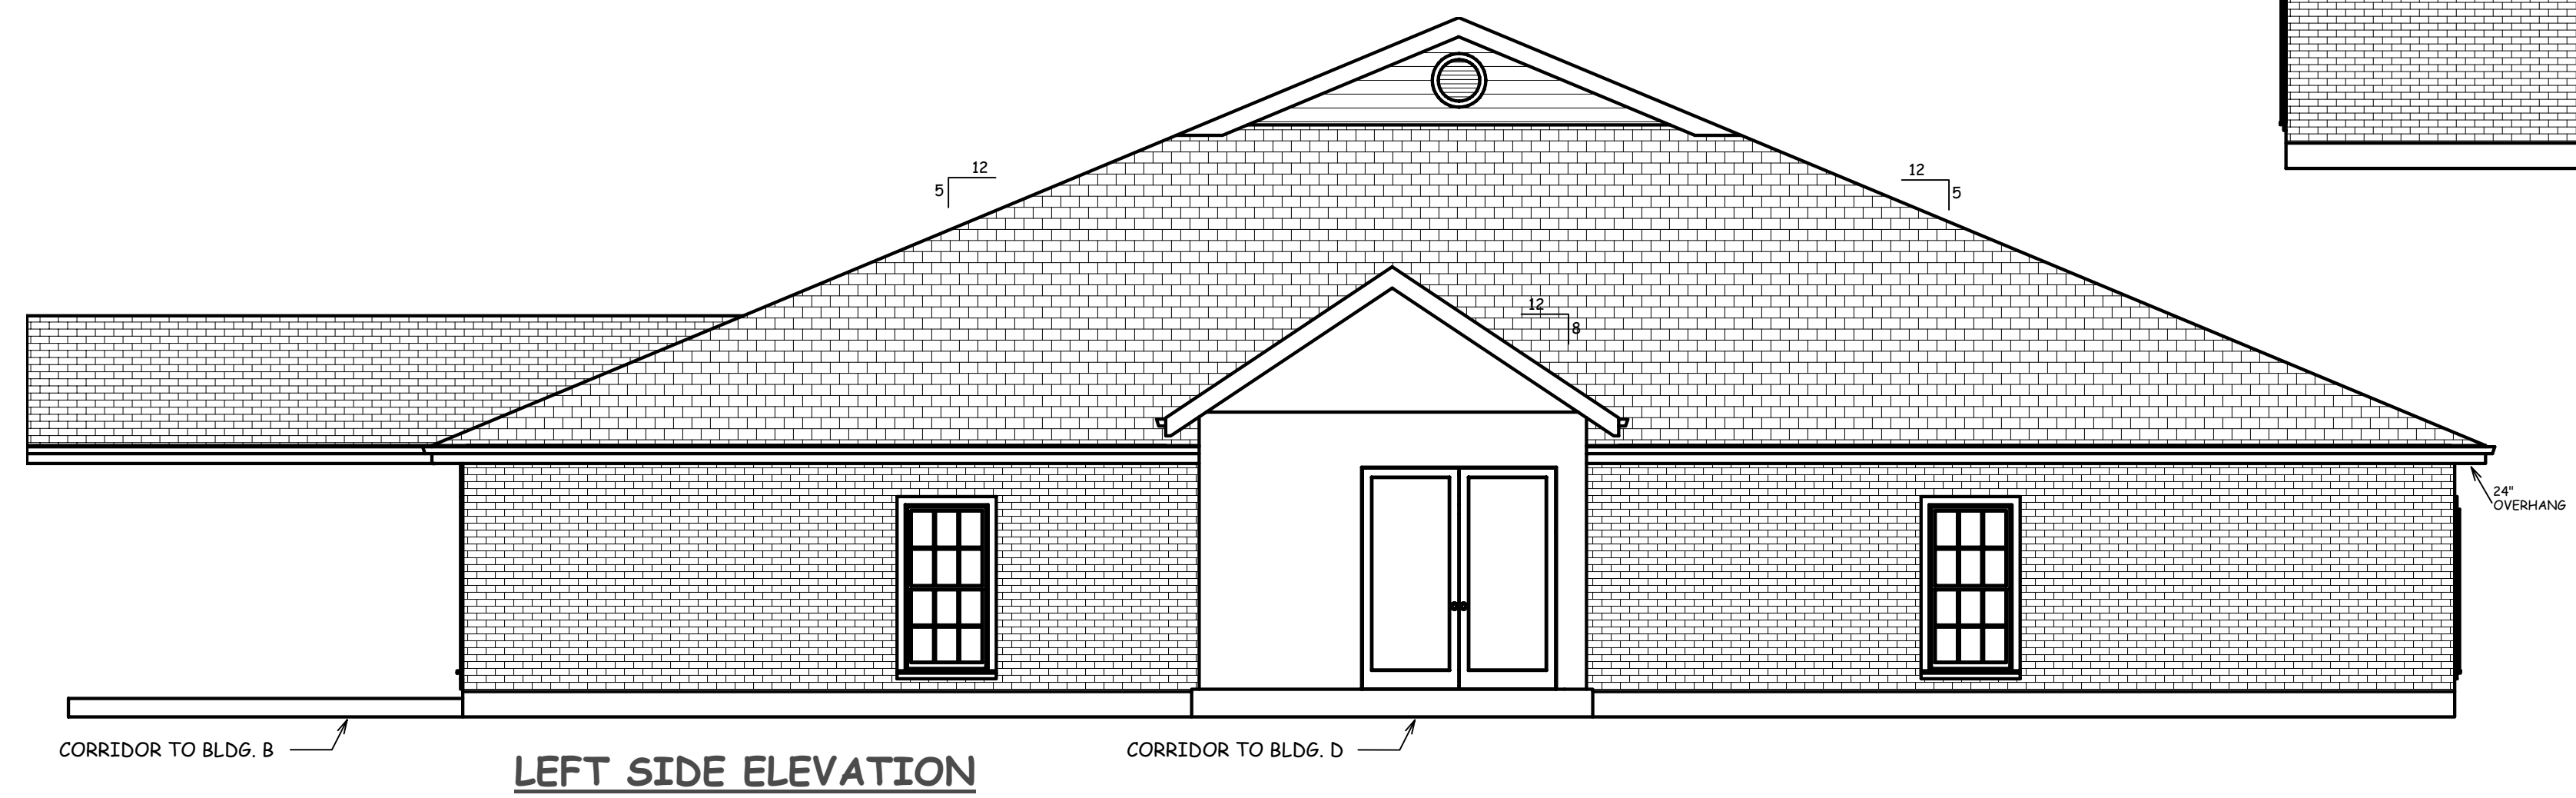

LEFT SIDE ELEVATION

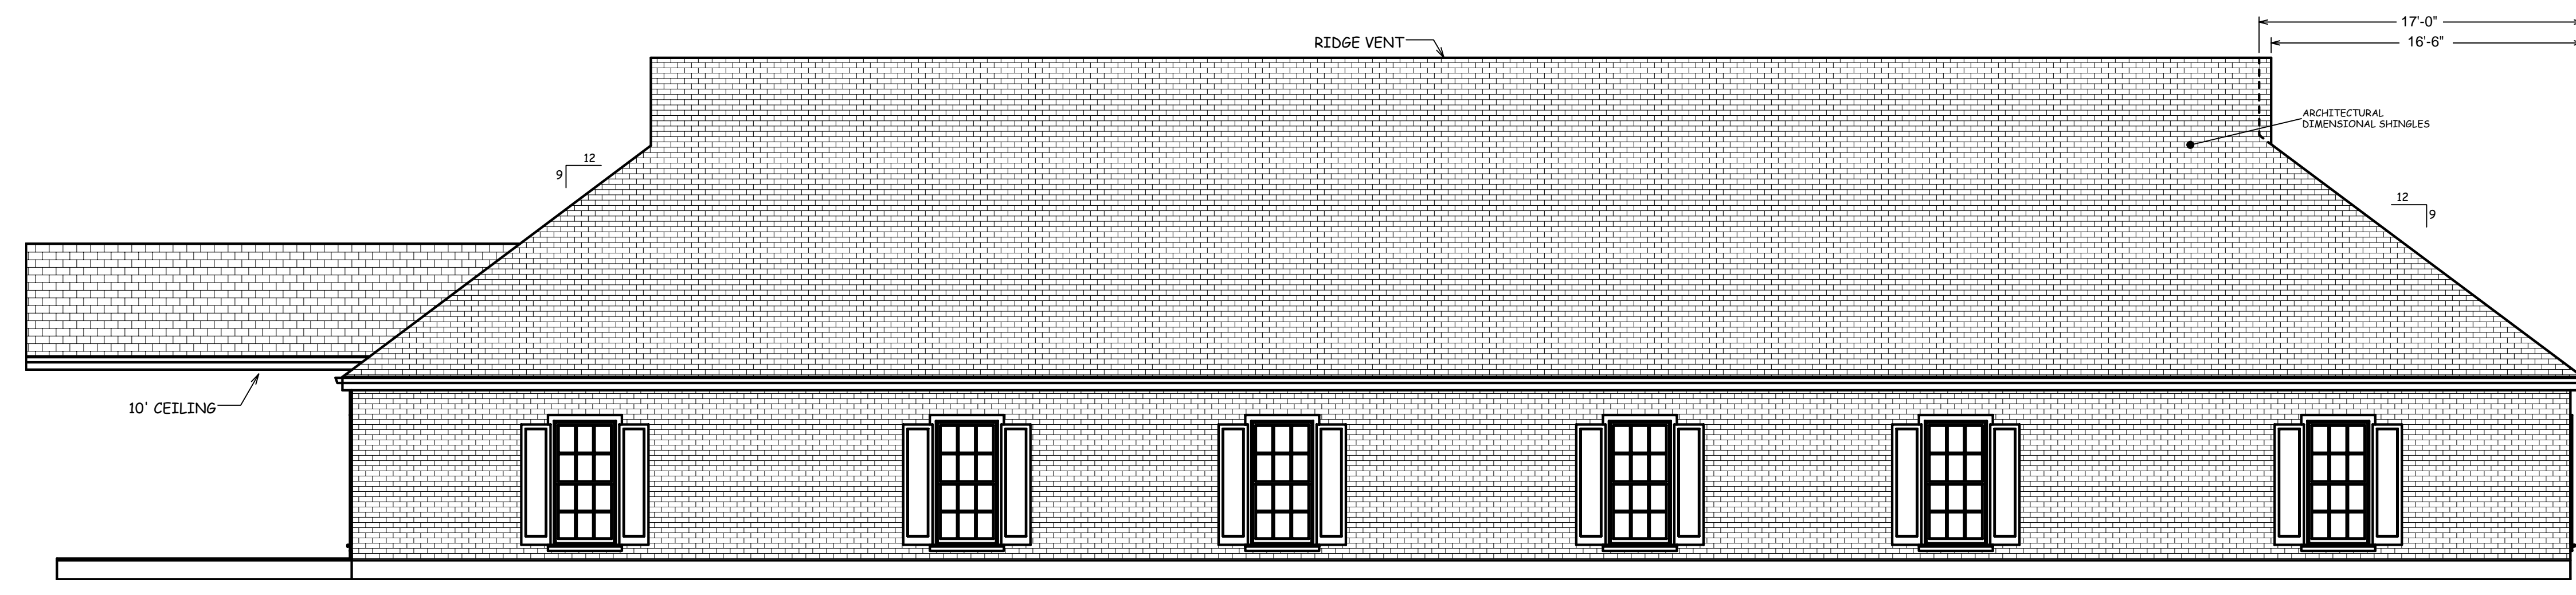

FRONT ELEVATION

Note: Although every effort has been made in preparing these plans and checking them for accuracy, the contractor must check all dimensions, details and code requirements applicable in the area of construction and be responsible for same.

PLANS FOR:
Summerfield Retirement Community, LLC
 Brownsitch Rd. & Dauphine Street
 St. Tammany Parish, LA


LIVING AREA - 7696 SQ. FT.
 COVERED ENTRY - 44 SQ. FT.
 UNDER BEAM - 7740 SQ. FT.

REVISIONS	BY
03/21/08	
08/28/08	

Drawn by
 Checked by
 Date: 01/11/08
 Scale: 3/16" = 1'-0"
 Job No.

Sheet No.
C2

LEGEND	
SYMBOL	DESCRIPTION
⊞	SINGLE POLE SWITCH
⊞	SINGLE POLE SWITCH W/DIMMER
⊞	SINGLE POLE SWITCH W/WP COVER
⊞	3-WAY SWITCH
⊞	4-WAY SWITCH
⊞	5-WAY SWITCH
⊞	120V DUPLEX RECEPTACLE
⊞	120V DUPLEX RECEPTACLE W/GFT
⊞	120V RECEPTACLE W/WATERPROOF COVER
⊞	240V RECEPTACLE
⊞	SURFACE MOUNT LIGHT FIXTURE
⊞	WALL MOUNTED LIGHT FIXTURE
⊞	RECESSED LIGHT FIXTURE-6" INCANDESCENT
⊞	OUTDOOR DUAL FLOOD LIGHT
⊞	FLOURESCENT STRIP LIGHT
⊞	FLOURESCENT FIXTURE - 2'x4'
⊞	FLOURESCENT FIXTURE - 1'x4'
⊞	CEILING FAN w/LIGHTS
⊞	FLUSH MOUNT INCANDESCENT LIGHT
⊞	RECESSED LIGHT/FAN
⊞	RECESSED HEAT/FAN
⊞	RECESSED HEAT/LIGHT/FAN
⊞	LIGHTING PANEL
⊞	TELEPHONE JACK
⊞	SMOKE DETECTOR
⊞	CABLE JACK
⊞	EMERGENCY CALL
⊞	DISCONNECT SWITCH
⊞	FIRE ALARM PULL STATION
⊞	EMERGENCY LIGHT w/BATTERY BACKUP
⊞	EXIT LIGHT w/BATTERY BACKUP
⊞	WATER HEATER - ELECTRIC

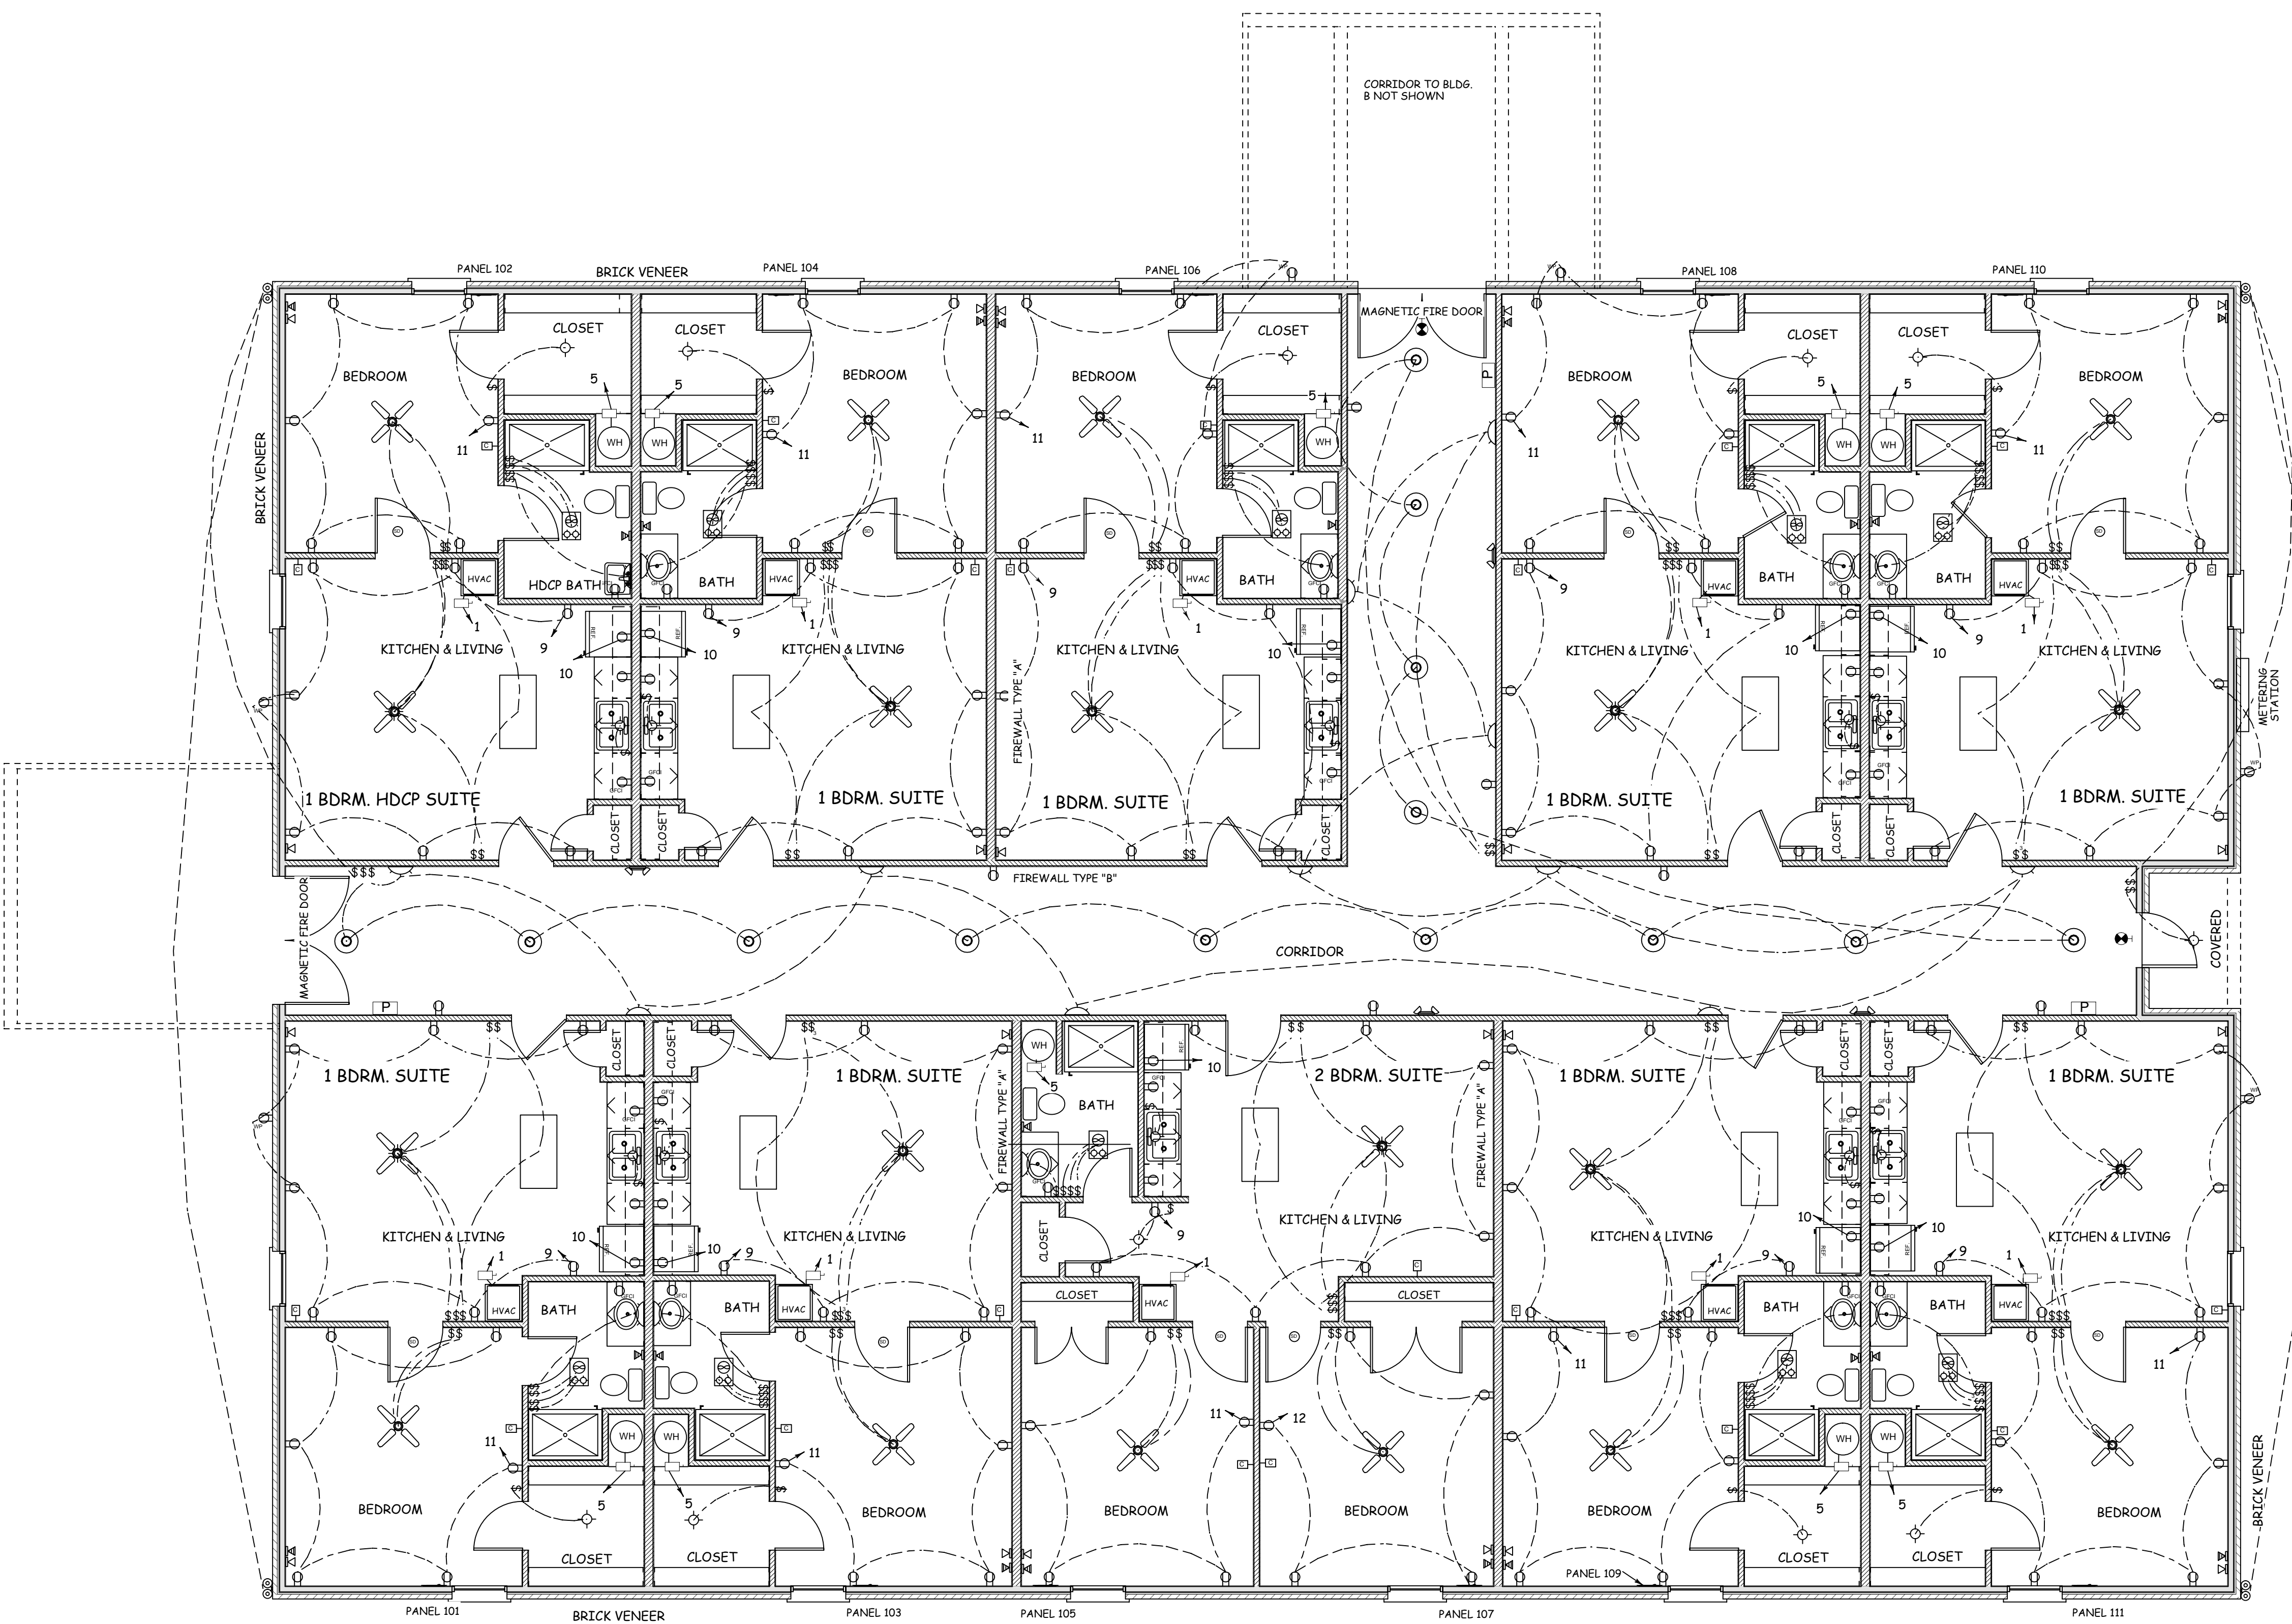

Note: Although every effort has been made in preparing these plans and checking them for accuracy, the contractor must check all dimensions, details and code requirements applicable in the area of construction and be responsible for same.

PLANS FOR:
Summerfield Retirement Community, LLC
 Brownswood Rd. & Dauphine Street
 St. Tammany Parish, LA

LIVING AREA 7696 SQ. FT.
 COVERED ENTRY 44 SQ. FT.
 UNDER BEAM 7740 SQ. FT.

REVISIONS	BY
03/21/08	
08/28/08	

PANEL TYPICAL STUDIO APARTMENT				VOLTAGE: 120/208v, 1ø, 3w			
LOCATION: NEAREST SERVICE ENTRANCE				80A MAIN BREAKER, 100A MAIN BUS			
CKT. NO.	LOAD DESCRIPTION	BREAKER AMP	LOAD (VA)	CKT. NO.	LOAD DESCRIPTION	BREAKER AMP	LOAD (VA)
1	FURNACE BLOWER	30	2	2	A/C CONDENSER	2	4
3	WATER HEATER	20	1	6	BATHROOM	1	20
5	LIGHTING	20	1	8	KITCHEN COUNTER	1	20
7	RECEPTACLES LIVING ROOM	20	1	10	REFRIGERATOR	1	20
9	SPARE	20	1	12	SPARE	1	20

TOTAL CONNECTED LOAD (VA) A_g= B_g=
 GROUND BUS GROUND WIRE (G)

PANEL TYPICAL ONE BEDROOM APARTMENT				VOLTAGE: 120/208v, 1ø, 3w			
LOCATION: NEAREST SERVICE ENTRANCE				80A MAIN BREAKER, 100A MAIN BUS			
CKT. NO.	LOAD DESCRIPTION	BREAKER AMP	LOAD (VA)	CKT. NO.	LOAD DESCRIPTION	BREAKER AMP	LOAD (VA)
1	FURNACE BLOWER	30	2	2	A/C CONDENSER	2	4
3	WATER HEATER	20	1	6	BATHROOM	1	20
5	LIGHTING	20	1	8	KITCHEN COUNTER	1	20
7	RECEPTACLES LIVING ROOM	20	1	10	REFRIGERATOR	1	20
9	RECEPTACLES BEDROOM 1	20	1	12	SPARE	1	20

TOTAL CONNECTED LOAD (VA) A_g= B_g=
 GROUND BUS GROUND WIRE (G)

PANEL TYPICAL TWO BEDROOM APARTMENT				VOLTAGE: 120/208v, 1ø, 3w			
LOCATION: NEAREST SERVICE ENTRANCE				80A MAIN BREAKER, 100A MAIN BUS			
CKT. NO.	LOAD DESCRIPTION	BREAKER AMP	LOAD (VA)	CKT. NO.	LOAD DESCRIPTION	BREAKER AMP	LOAD (VA)
1	FURNACE BLOWER	30	2	2	A/C CONDENSER	2	4
3	WATER HEATER	20	1	6	BATHROOM	1	20
5	LIGHTING	20	1	8	KITCHEN COUNTER	1	20
7	RECEPTACLES LIVING ROOM	20	1	10	REFRIGERATOR	1	20
9	RECEPTACLES BEDROOM 1	20	1	12	RECEPTACLES BEDROOM 2	1	20

TOTAL CONNECTED LOAD (VA) A_g= B_g=
 GROUND BUS GROUND WIRE (G)

Drawn by
 Checked by
 Date
 01/11/08
 Scale
 3/16"=1'-0"
 Job No.

Sheet No.
E4C