

BLDG. SUMMARY  
 1 - 1 BDRM HDCP SUITE  
 8 - 1 BDRM SUITES  
 1 - 2 BDRM SUITE

# FLOOR PLAN BLDG. E

Note: Although every effort has been made in preparing these plans and checking them for accuracy, the contractor must check all dimensions, details and code requirements applicable in the area of construction and be responsible for same.


PLANS FOR:  
**Summerfield Retirement Community, LLC**  
 Brownsitch Rd. & Dauphine Street  
 St. Tammany Parish, LA

LIVING AREA 7696 SQ. FT.  
 COVERED ENTRY 44 SQ. FT.  
 UNDER BEAM 7740 SQ. FT.


REVISIONS	BY
03/21/08	
08/28/08	

Drawn by  
 Checked by  
 Date 01/11/08  
 Scale 3/16"=1'-0"  
 Job No.


Sheet No.  
**E1**

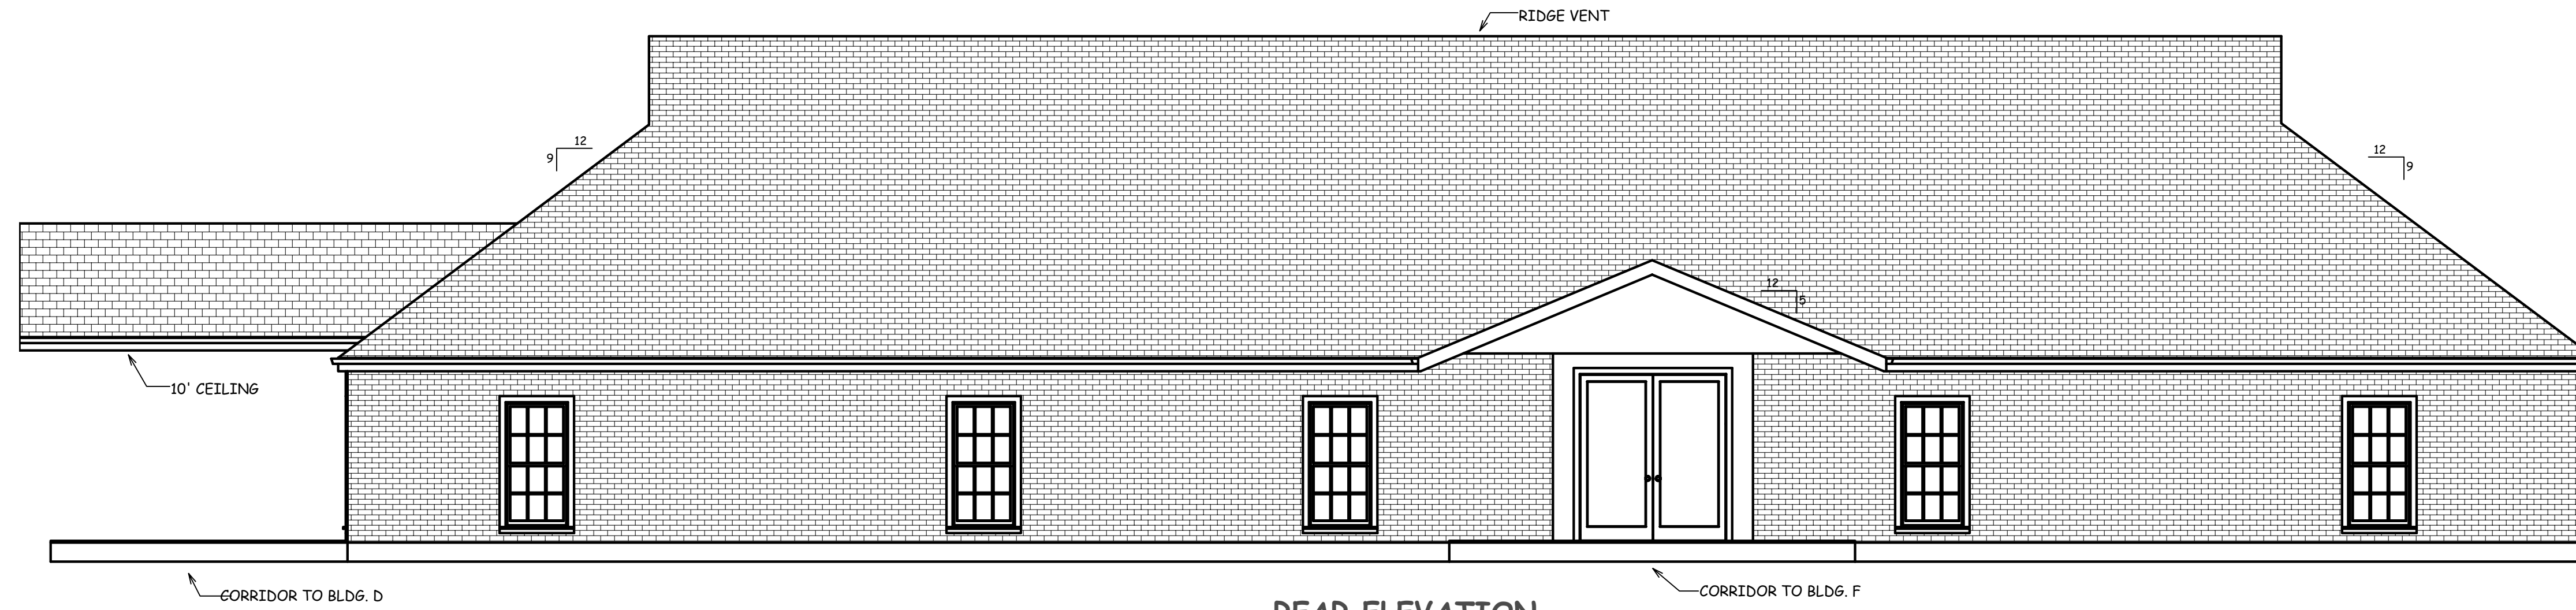


REAR ELEVATION

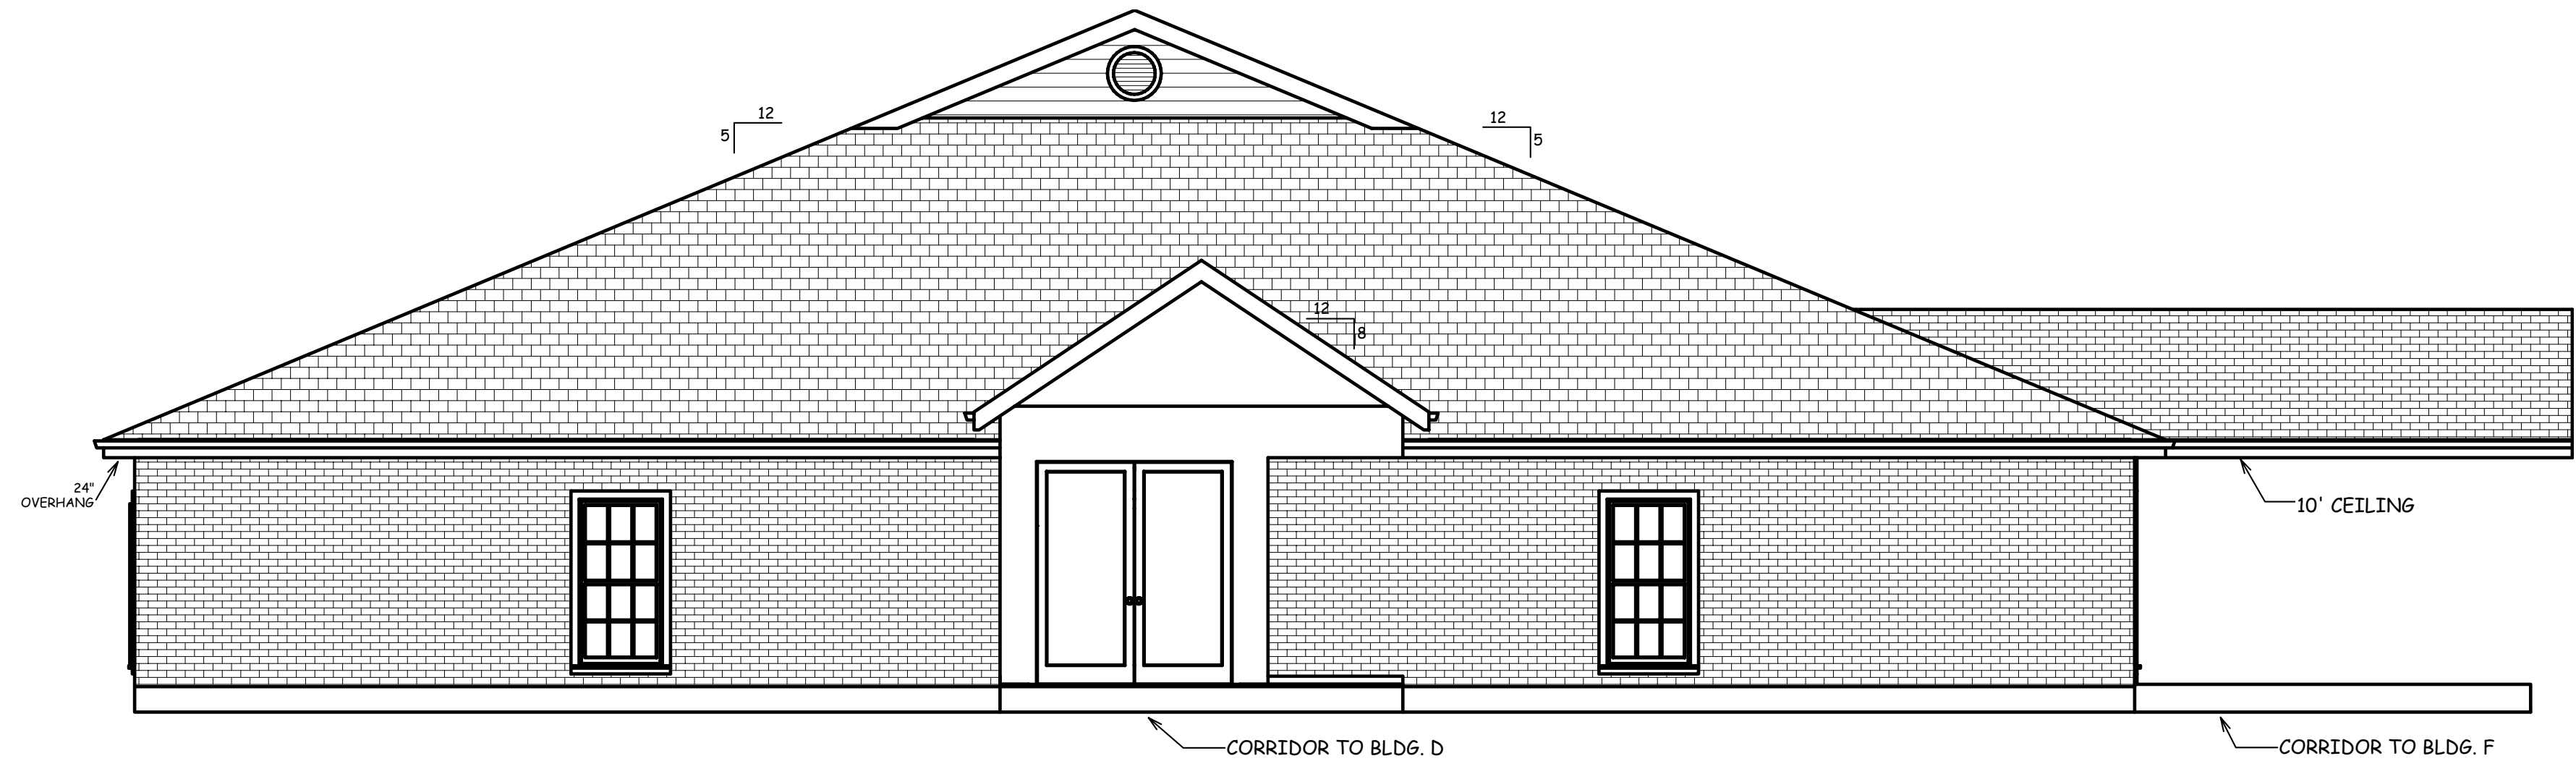

RIGHT SIDE ELEVATION

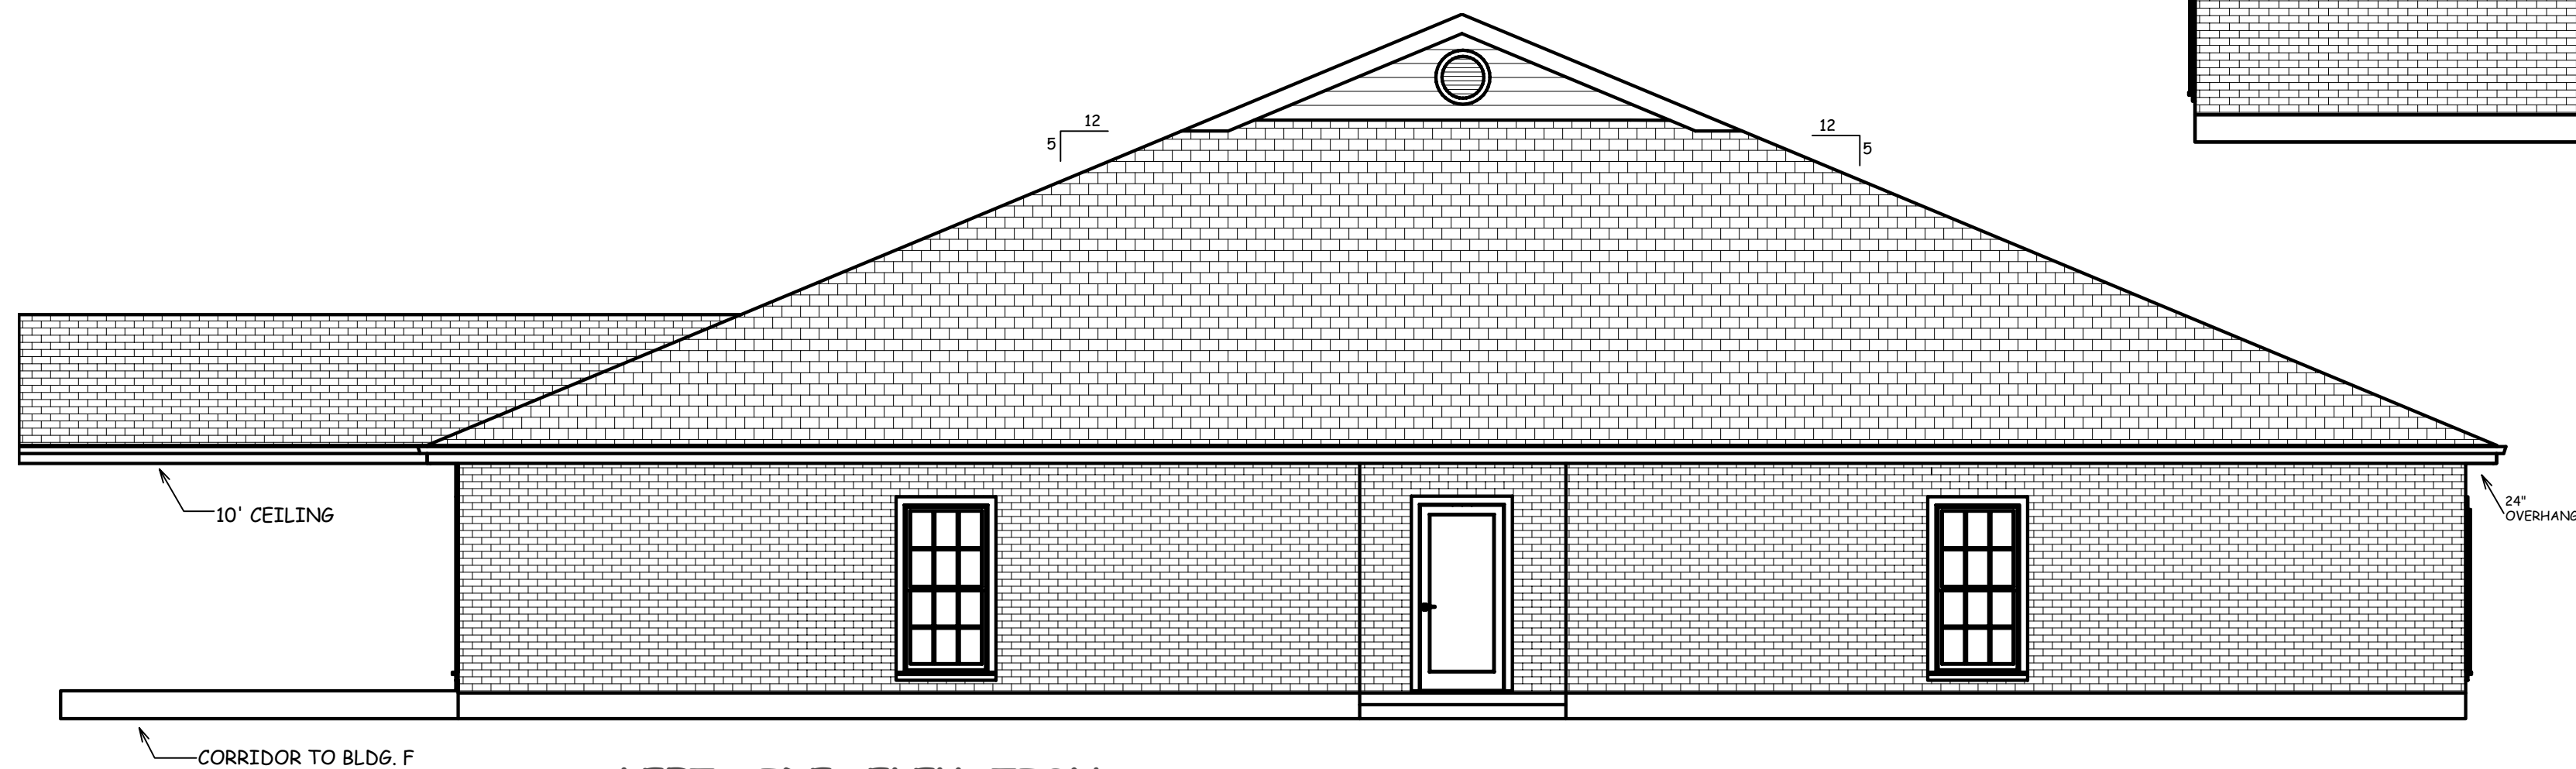

LEFT SIDE ELEVATION

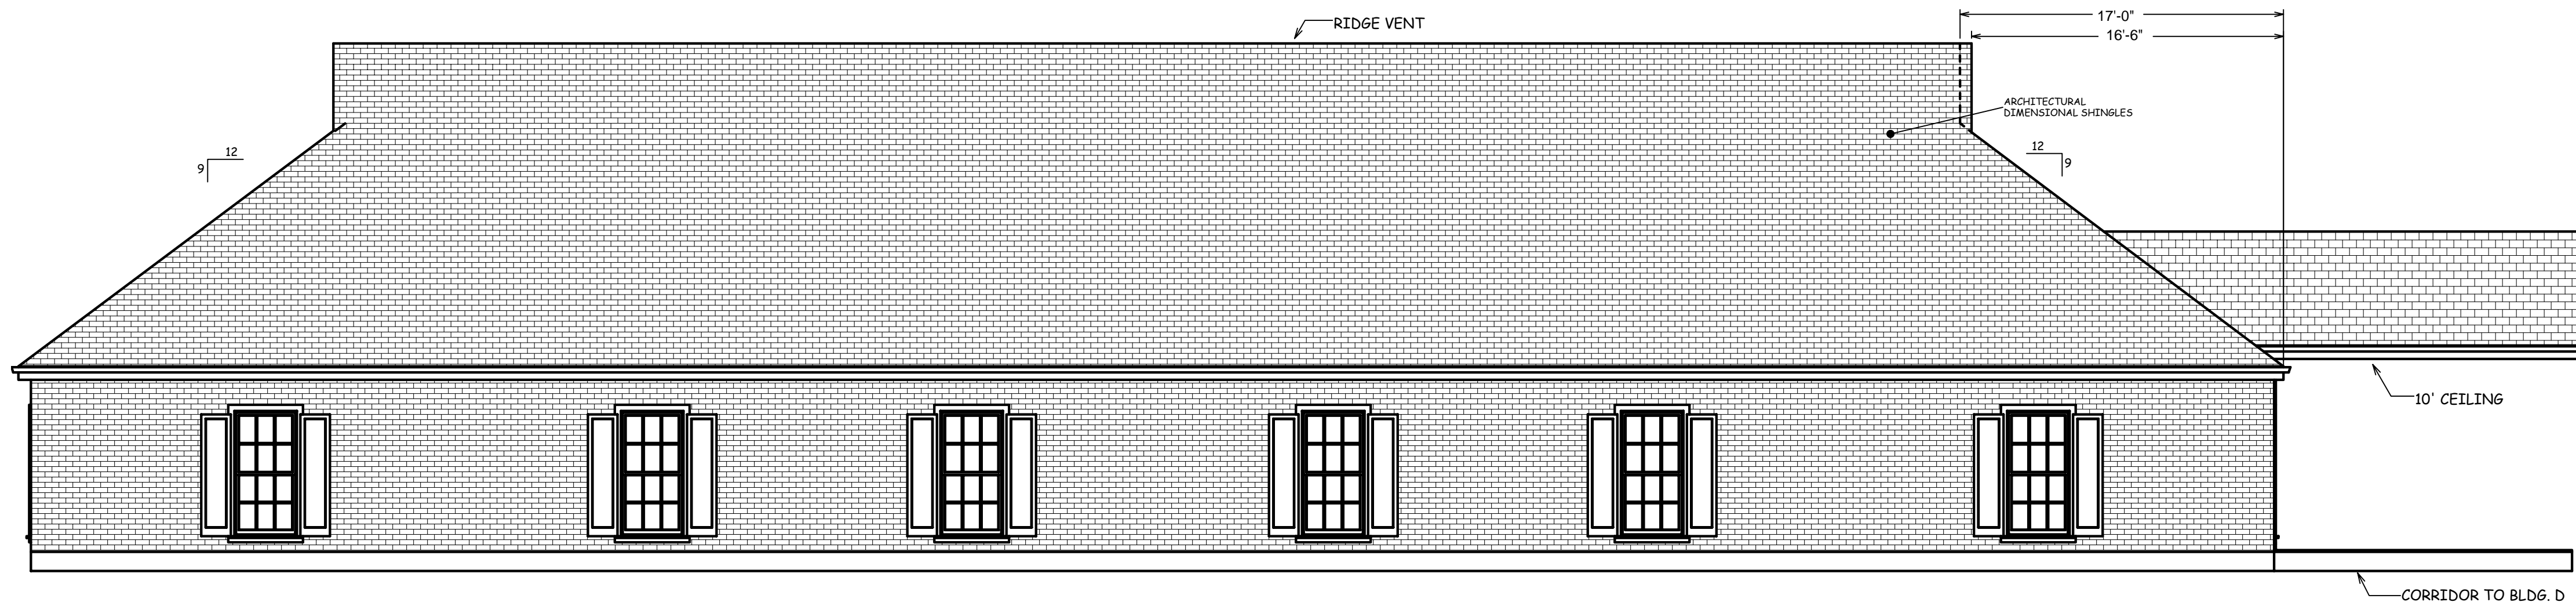

FRONT ELEVATION

Note: Although every effort has been made in preparing these plans and checking them for accuracy, the contractor must check all dimensions, details and code requirements applicable in the area of construction and be responsible for same.

PLANS FOR:  
**Summerfield Retirement Community, LLC**  
 Brownsuitch Rd. & Dauphine Street  
 St. Tammany Parish, LA


LIVING AREA 7696 SQ. FT.  
 COVERED ENTRY 44 SQ. FT.  
 UNDER BEAM 7740 SQ. FT.

REVISIONS	BY
03/21/08	
08/28/08	

Drawn by  
 Checked by  
 Date  
 01/11/08  
 Scale  
 3/16" = 1' - 0"  
 Job No.

Sheet No.

E2

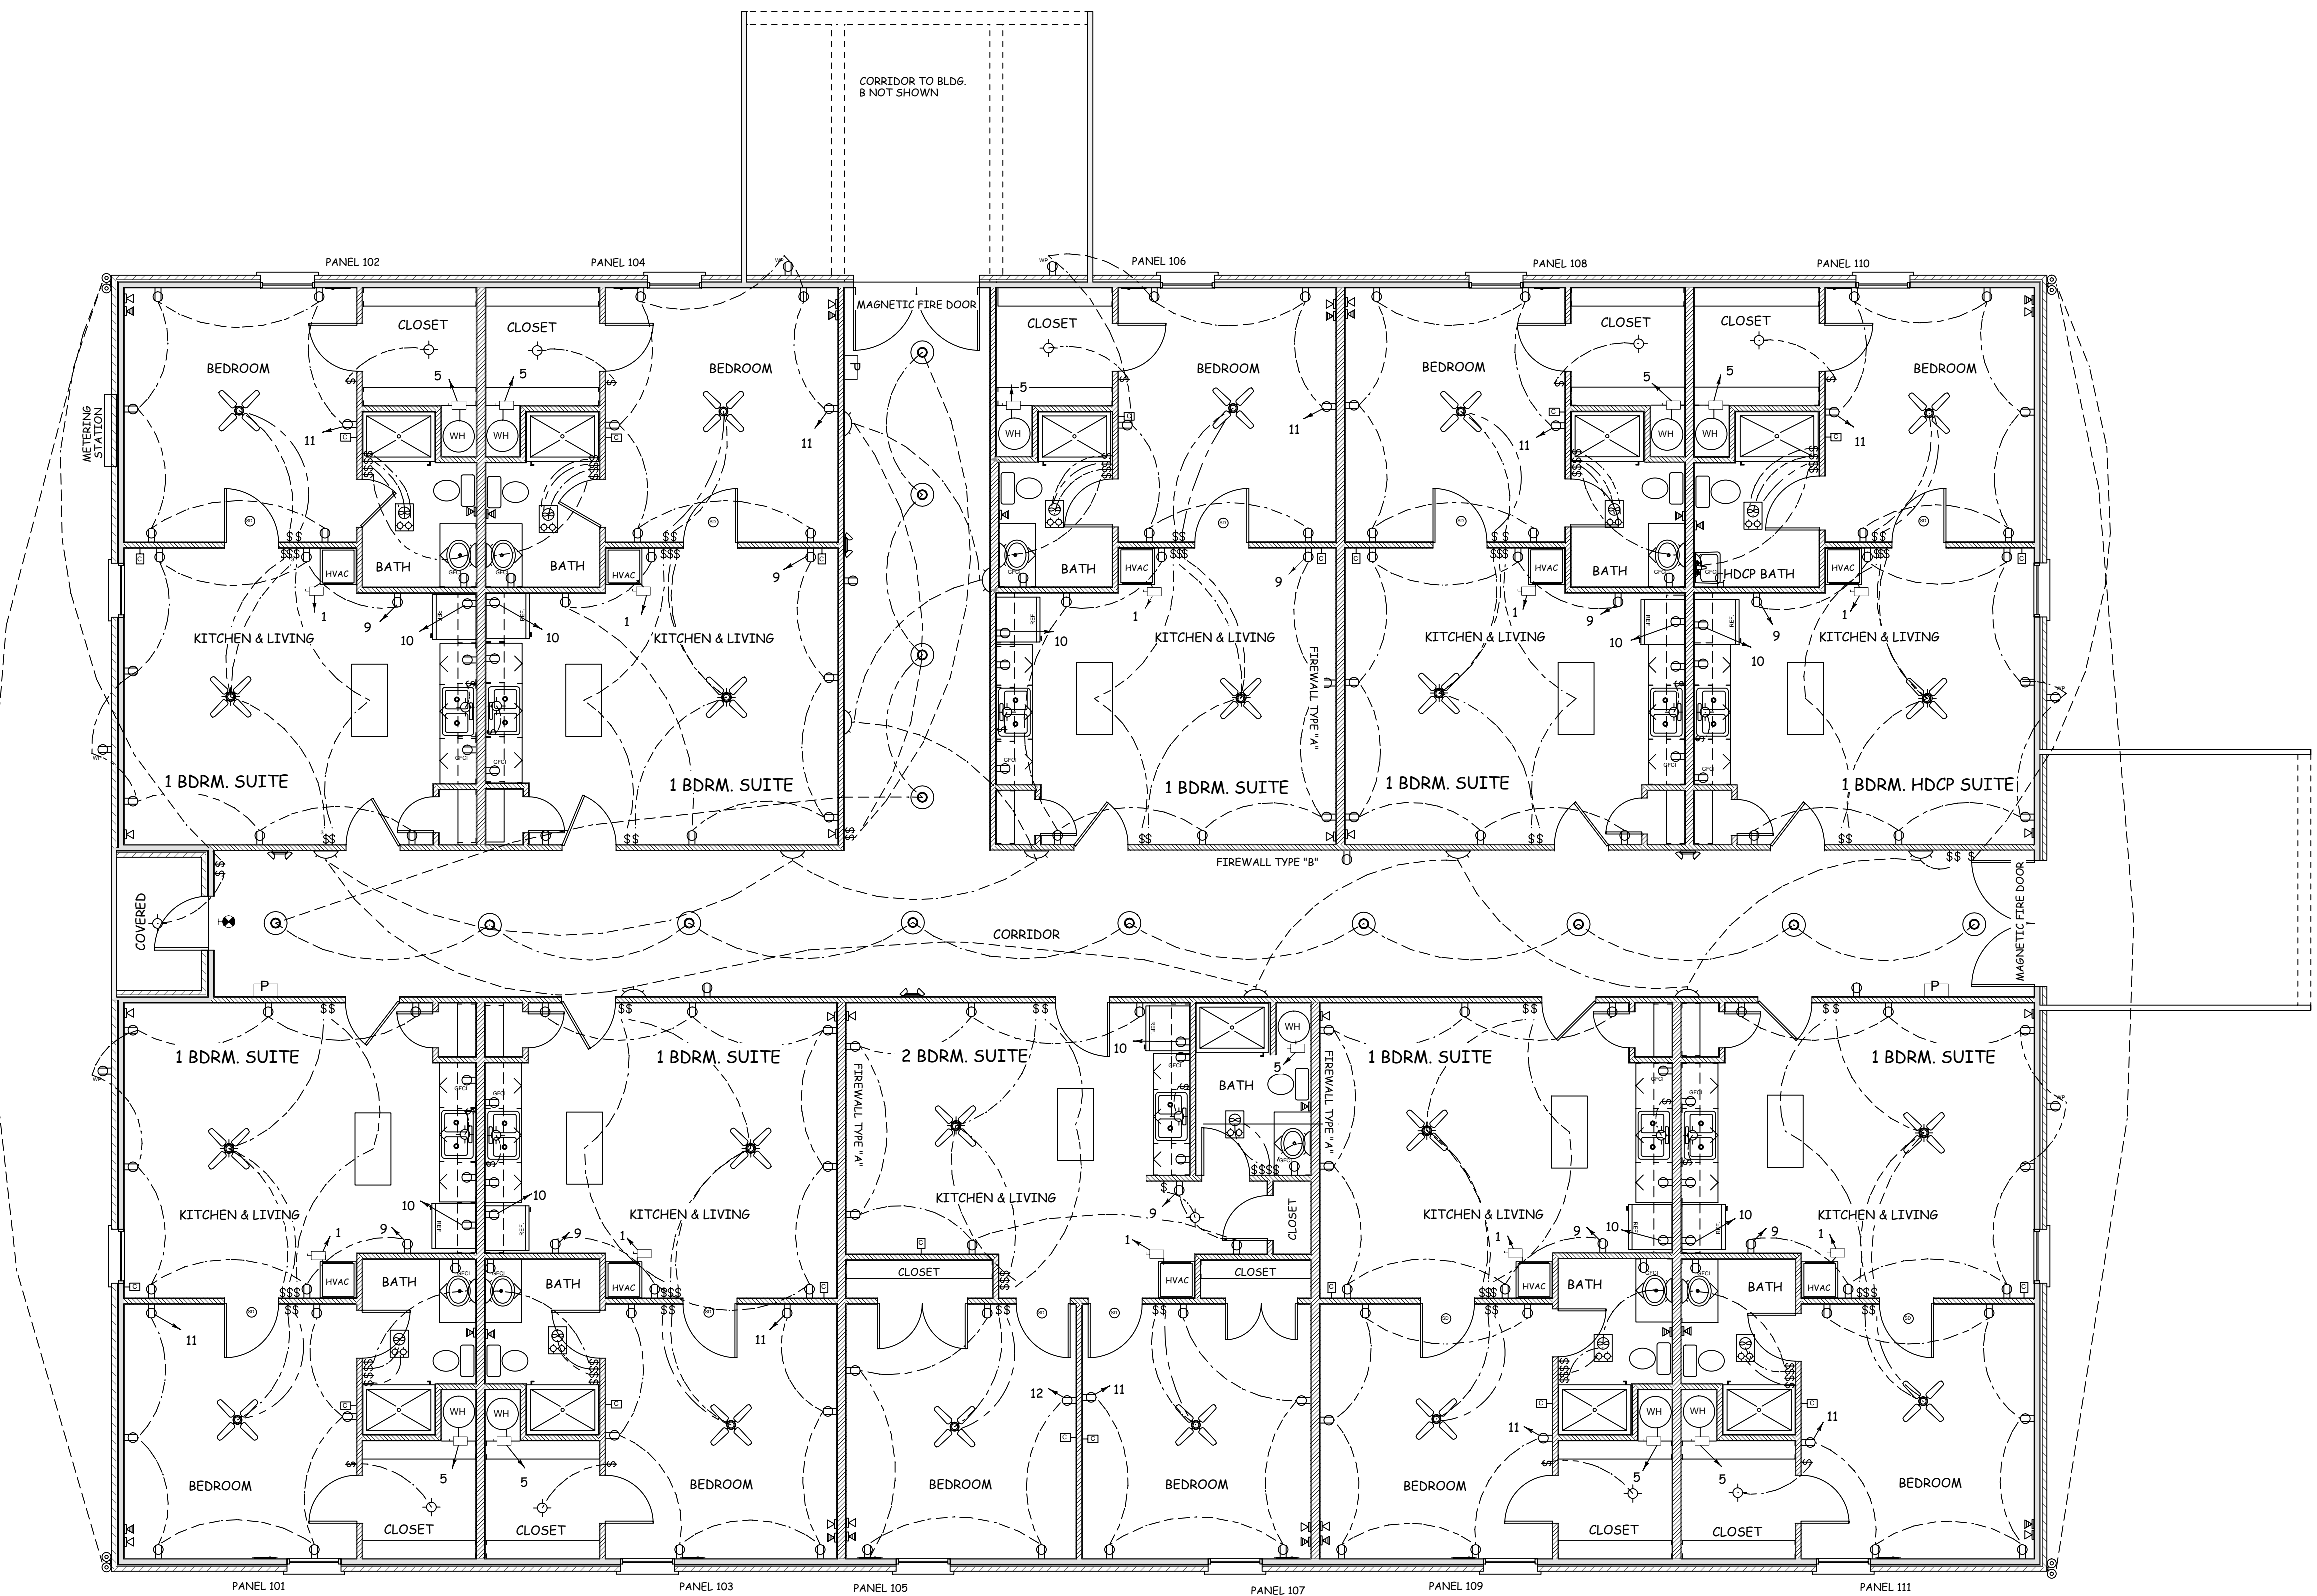

LEGEND	
SYMBOL	DESCRIPTION
⊞	SINGLE POLE SWITCH
⊞	SINGLE POLE SWITCH W/DIMMER
⊞	SINGLE POLE SWITCH W/WP COVER
⊞	3-WAY SWITCH
⊞	4-WAY SWITCH
⊞	5-WAY SWITCH
⊞	120V DUPLEX RECEPTACLE
⊞	120V DUPLEX RECEPTACLE W/6FT
⊞	120V RECEPTACLE W/WATERPROOF COVER
⊞	240V RECEPTACLE
⊞	SURFACE MOUNT LIGHT FIXTURE
⊞	WALL MOUNTED LIGHT FIXTURE
⊞	RECESSED LIGHT FIXTURE-6" INCANDESCENT
⊞	OUTDOOR DUAL FLOOD LIGHT
⊞	FLUORESCENT STRIP LIGHT
⊞	FLUORESCENT FIXTURE - 2' x 4'
⊞	FLUORESCENT FIXTURE - 1' x 4'
⊞	CEILING FAN w/LIGHTS
⊞	FLUSH MOUNT INCANDESCENT LIGHT
⊞	RECESSED LIGHT/FAN
⊞	RECESSED HEAT/FAN
⊞	RECESSED HEAT/LIGHT/FAN
⊞	LIGHTING PANEL
⊞	TELEPHONE JACK
⊞	SMOKE DETECTOR
⊞	CABLE JACK
⊞	EMERGENCY CALL
⊞	DISCONNECT SWITCH
⊞	FIRE ALARM PULL STATION
⊞	EMERGENCY LIGHT w/BATTERY BACKUP
⊞	EXIT LIGHT w/BATTERY BACKUP
⊞	WATER HEATER - ELECTRIC

Note: Although every effort has been made in preparing these plans and checking them for accuracy, the contractor must check all dimensions, details and code requirements applicable in the area of construction and be responsible for same.

PLANS FOR:  
**Summerfield Retirement Community, LLC**  
 Brownswood Rd. & Dauphine Street  
 St. Tammany Parish, LA

LIVING AREA 7696 SQ. FT.  
 COVERED ENTRY 44 SQ. FT.  
 UNDER BEAM 7740 SQ. FT.

REVISIONS	BY
03/21/08	
08/28/08	

PANEL TYPICAL STUDIO APARTMENT				VOLTAGE: 120/208v, 1ø, 3w			
LOCATION: FEEDER SOURCE: NEAREST SERVICE ENTRANCE				80A MAIN BREAKER, 100A MAIN BUS FLUSH MOUNTED W/EQUIPMENT GROUND BAR SQUARE D TYPE QO OR EQUAL			
CKT. NO.	LOAD DESCRIPTION	BREAKER AMP POLE	LOAD (VA)	80A	B0	LOAD (VA)	CKT. NO.
1	FURNACE BLOWER	30 2	--	⊞	⊞	--	2
3	WATER HEATER	20 1	--	⊞	⊞	--	4
5	LIGHTING	20 1	--	⊞	⊞	--	6
7	RECEPTACLES LIVING ROOM	20 1	--	⊞	⊞	--	8
9	SPARE	20 1	--	⊞	⊞	--	10
				⊞	⊞	--	12
TOTAL CONNECTED LOAD (VA)				GROUND BUS GROUND WIRE (G)			
A0=				B0=			

PANEL TYPICAL ONE BEDROOM APARTMENT				VOLTAGE: 120/208v, 1ø, 3w			
LOCATION: FEEDER SOURCE: NEAREST SERVICE ENTRANCE				80A MAIN BREAKER, 100A MAIN BUS FLUSH MOUNTED W/EQUIPMENT GROUND BAR SQUARE D TYPE QO OR EQUAL			
CKT. NO.	LOAD DESCRIPTION	BREAKER AMP POLE	LOAD (VA)	80A	B0	LOAD (VA)	CKT. NO.
1	FURNACE BLOWER	30 2	--	⊞	⊞	--	2
3	WATER HEATER	20 1	--	⊞	⊞	--	4
5	LIGHTING	20 1	--	⊞	⊞	--	6
7	RECEPTACLES LIVING ROOM	20 1	--	⊞	⊞	--	8
9	RECEPTACLES BEDROOM 1	20 1	--	⊞	⊞	--	10
11	SPARE	20 1	--	⊞	⊞	--	12
TOTAL CONNECTED LOAD (VA)				GROUND BUS GROUND WIRE (G)			
A0=				B0=			

PANEL TYPICAL TWO BEDROOM APARTMENT				VOLTAGE: 120/208v, 1ø, 3w			
LOCATION: FEEDER SOURCE: NEAREST SERVICE ENTRANCE				80A MAIN BREAKER, 100A MAIN BUS FLUSH MOUNTED W/EQUIPMENT GROUND BAR SQUARE D TYPE QO OR EQUAL			
CKT. NO.	LOAD DESCRIPTION	BREAKER AMP POLE	LOAD (VA)	80A	B0	LOAD (VA)	CKT. NO.
1	FURNACE BLOWER	30 2	--	⊞	⊞	--	2
3	WATER HEATER	20 1	--	⊞	⊞	--	4
5	LIGHTING	20 1	--	⊞	⊞	--	6
7	RECEPTACLES LIVING ROOM	20 1	--	⊞	⊞	--	8
9	RECEPTACLES BEDROOM 1	20 1	--	⊞	⊞	--	10
11	RECEPTACLES BEDROOM 2	20 1	--	⊞	⊞	--	12
TOTAL CONNECTED LOAD (VA)				GROUND BUS GROUND WIRE (G)			
A0=				B0=			

Drawn by  
 Checked by  
 Date  
**01/11/08**  
 Scale  
**3/16"=1'-0"**  
 Job No.

Sheet No.  
**E6E**