

UNIT SUMMARY
 6 - 1 BDRM. UNITS
 2 - 1 BDRM. HDPC. UNITS
 4 - 2 BDRM. UNITS
 4 - STUDIO UNITS
 16 TOTAL UNITS

NOTES:
 1. 9' CEILINGS, UNLESS NOTED OTHERWISE
 2. TOP OF WINDOW R. O. @ 86"

FLOOR PLAN BLDG. G

PLANS FOR:
Summerfield Retirement Community, LLC
 Brownsitch Rd. & Dauphine Street
 St. Tammany Parish, LA


REVISIONS

NO.	DATE	BY
01	08/28/08	


Drawn by: _____
 Checked by: _____
 Date: 03/26/08
 Scale: _____
 Job No.: _____

Sheet No.
G1

Note: Although every effort has been made in preparing these plans and checking them for accuracy, the contractor must check all dimensions, details and code requirements applicable in the area of construction and be responsible for same.

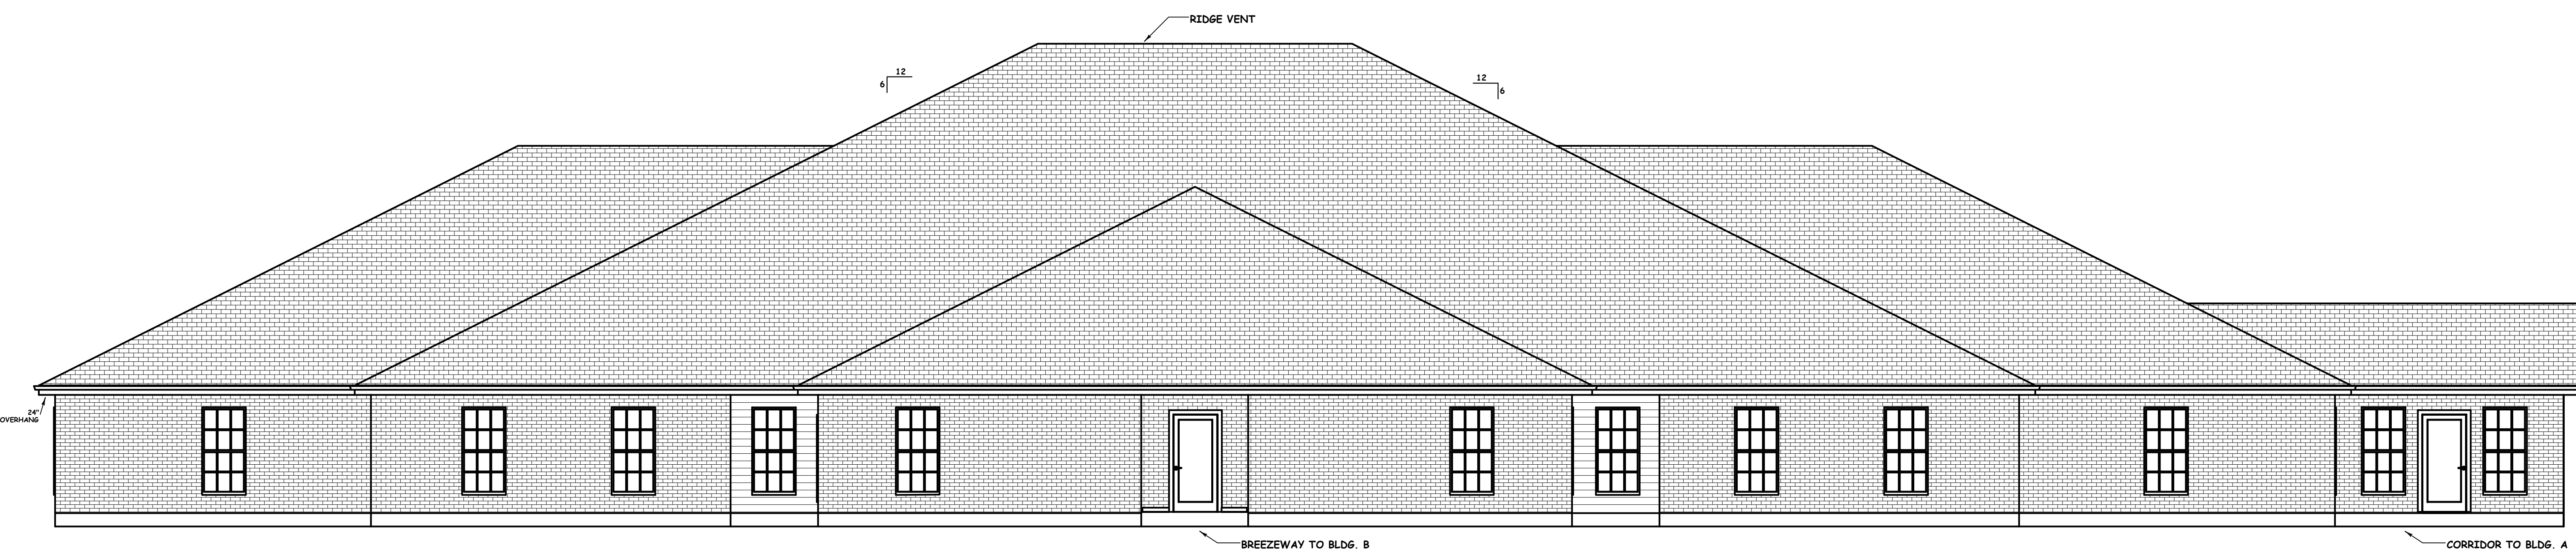

RIGHT SIDE ELEVATION

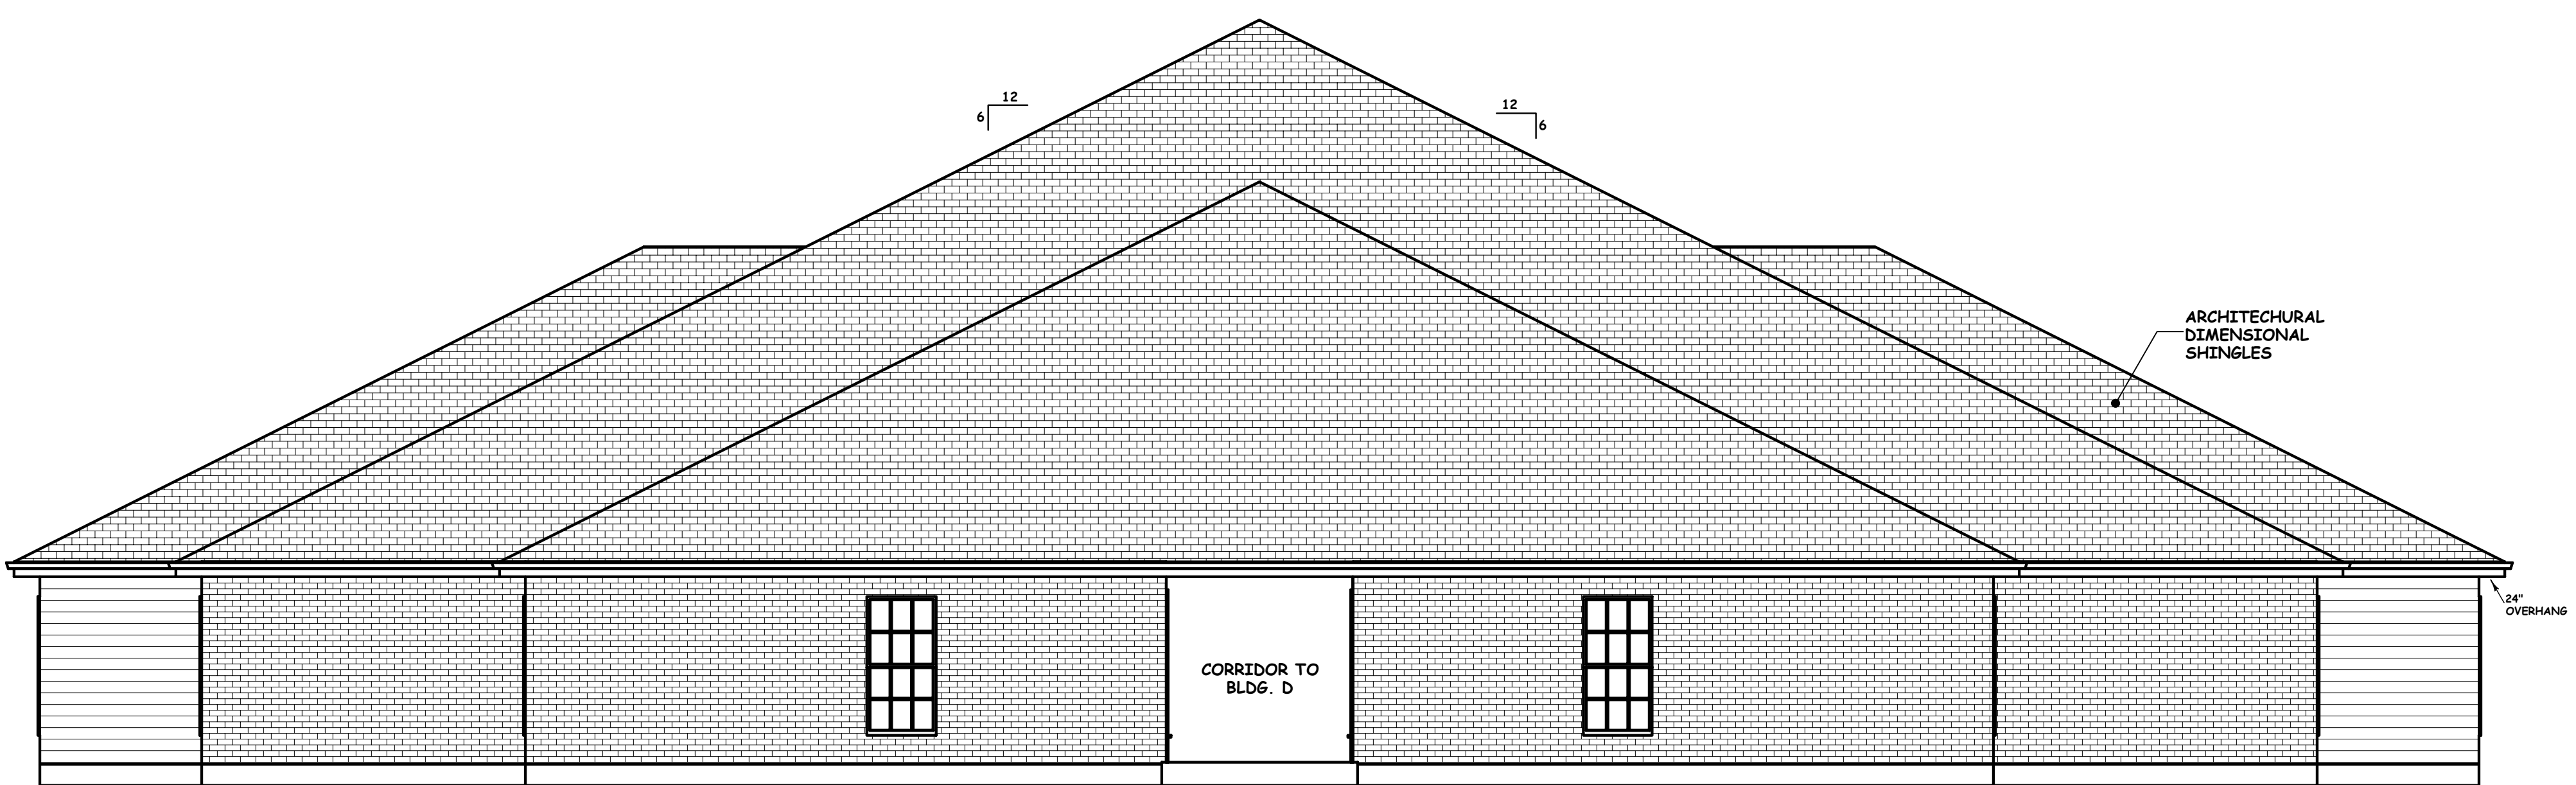

FRONT ELEVATION

Note: Although every effort has been made in preparing these plans and checking them for accuracy, the contractor must check all dimensions, details and code requirements applicable in the area of construction and be responsible for same.


PLANS FOR:
Summerfield Retirement Community, LLC
 Brownsitch Rd. & Dauphine Street
 St. Tammany Parish, LA

LIVING AREA 13360 SQ. FT.
 COVERED AREAS 172 SQ. FT.
 UNDER BEAM 13532 SQ. FT.


REVISIONS	BY
08/28/08	

Drawn by
 Checked by
 Date
03/26/08
 Scale
3/16" = 1' - 0"
 Job No.

Sheet No.
G2

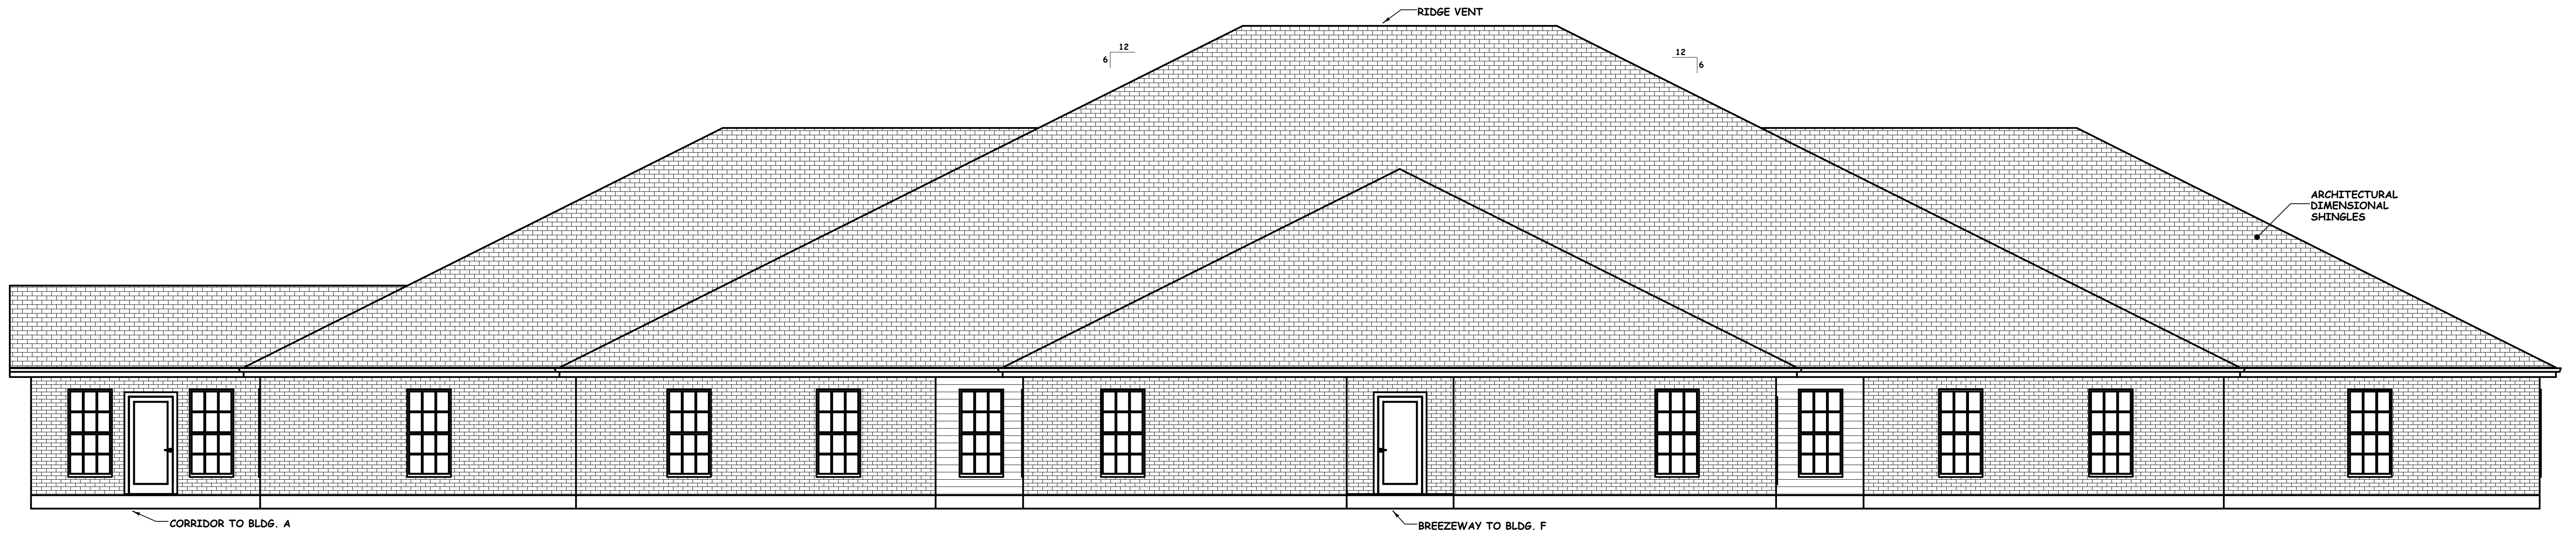

LEFT SIDE ELEVATION

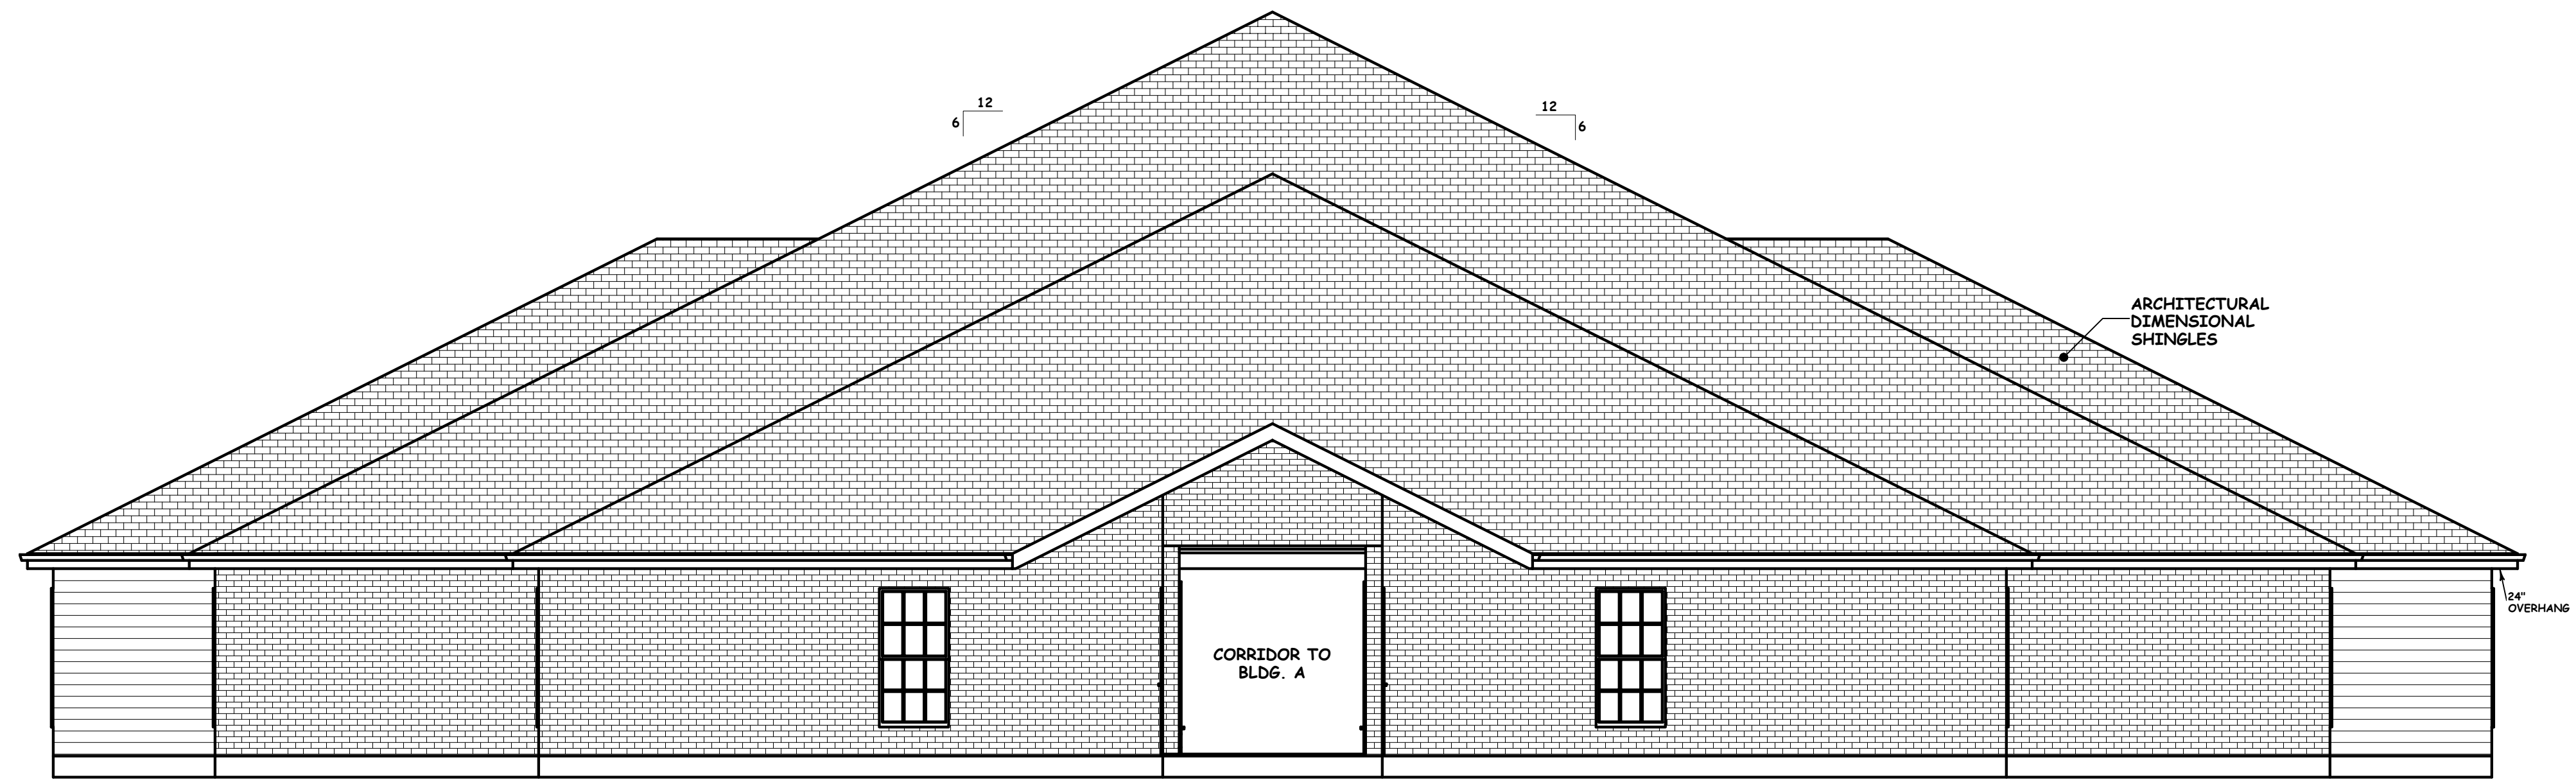

REAR ELEVATION

Note: Although every effort has been made in preparing these plans and checking them for accuracy, the contractor must check all dimensions, details and code requirements applicable in the area of construction and be responsible for same.


PLANS FOR:
Summerfield Retirement Community, LLC
 Brownsitch Rd. & Dauphine Street
 St. Tammany Parish, LA

LIVING AREA 13360 SQ. FT.
 COVERED AREAS 172 SQ. FT.
 UNDER BEAM 13532 SQ. FT.

REVISIONS	BY
08/28/08	

Drawn by
 Checked by
 Date: 03/26/08
 Scale: 3/16"=1'-0"
 Job No.

Sheet No.
G3

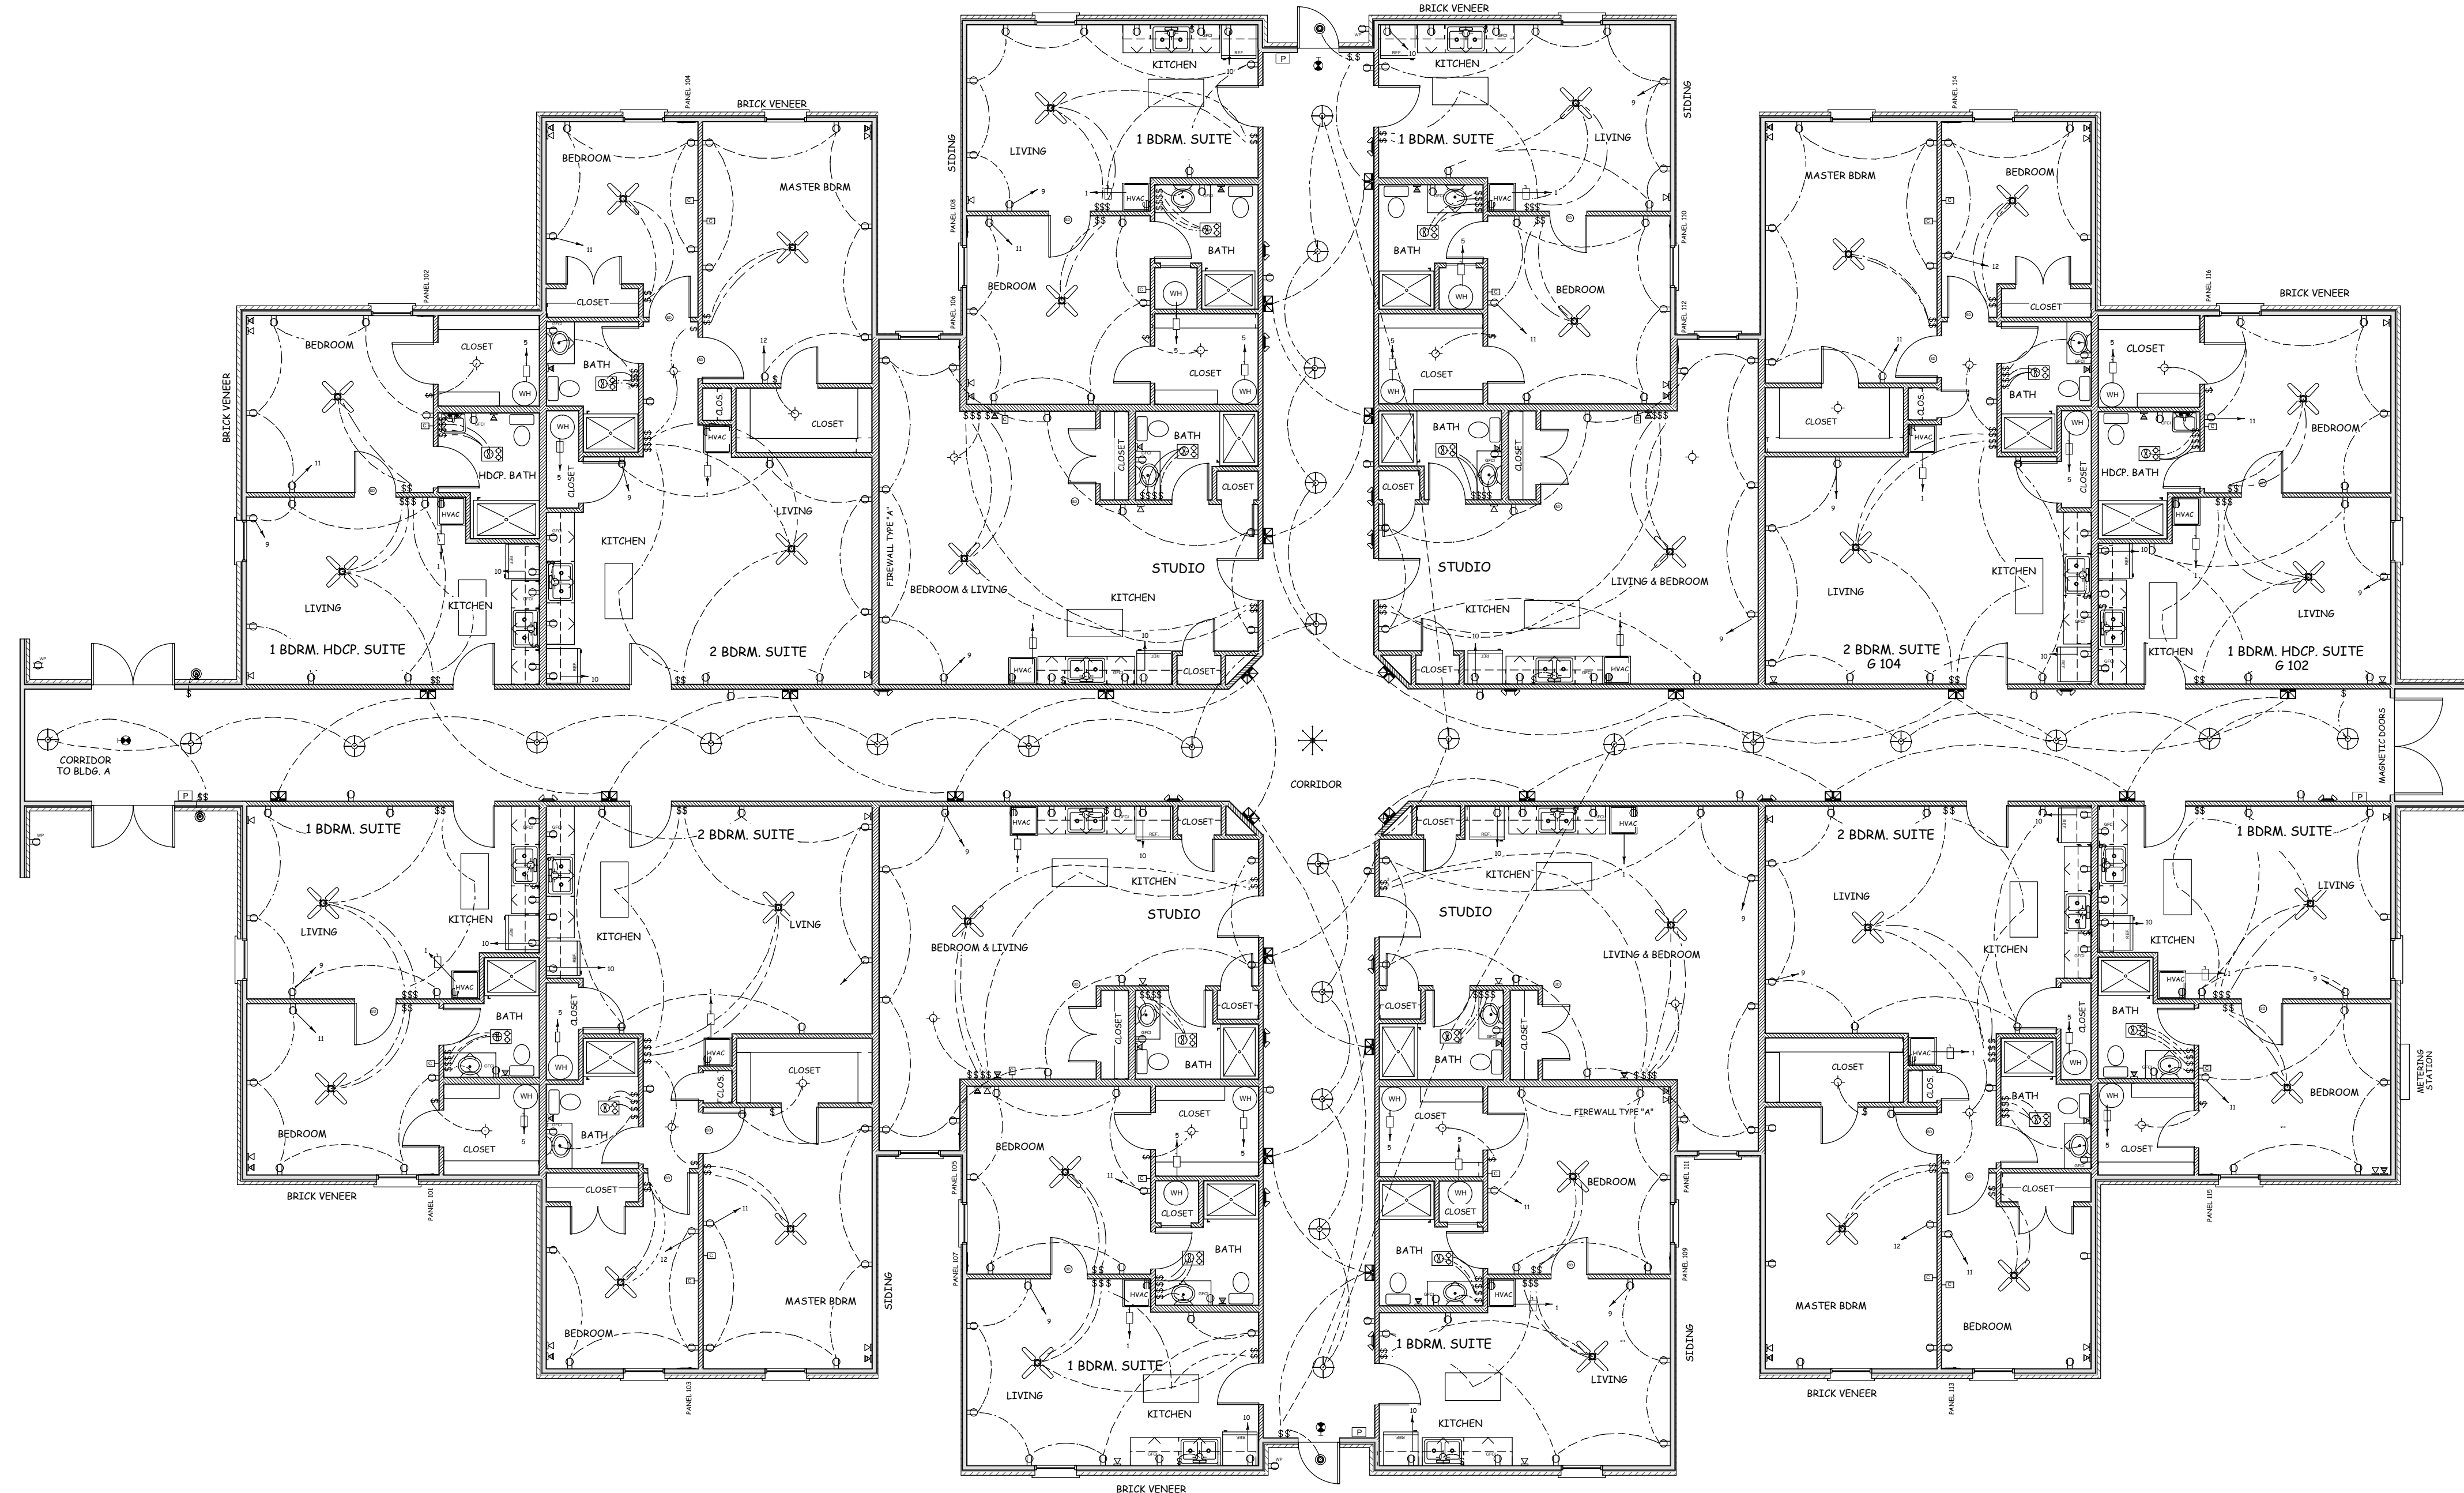

PANEL TYPICAL STUDIO APARTMENT				VOLTAGE: 120/208v, 1ø, 3w			
LOCATION: 80A MAIN BREAKER, 100A MAIN BUS				FLUSH MOUNTED W/EQUIPMENT GROUND BAR			
FEEDER SOURCE: NEAREST SERVICE ENTRANCE				SQUARE D TYPE QO OR EQUAL			
CKT. NO.	LOAD DESCRIPTION	BREAKER	LOAD (VA)	LOAD (VA)	BREAKER	LOAD DESCRIPTION	CKT. NO.
	LOCATION	AMP	POLE		POLE	LOCATION	
1	FURNACE BLOWER	30	2	--	--	2	A/C CONDENSER
3	WATER HEATER	20	1	--	1	BATHROOM	6
7	LIGHTING	20	1	--	1	KITCHEN COUNTER	8
9	RECEPTACLES LIVING ROOM	20	1	--	1	REFRIGERATOR	10
11	SPARE	20	1	--	1	SPARE	12
<input type="checkbox"/> SOLID NEUTRAL NEUTRAL WIRE (W)				<input type="checkbox"/> GROUND BUS GROUND WIRE (G)			
TOTAL CONNECTED LOAD (VA)				TOTAL CONNECTED LOAD (VA)			
A0=				B0=			

PANEL TYPICAL ONE BEDROOM APARTMENT				VOLTAGE: 120/208v, 1ø, 3w			
LOCATION: 80A MAIN BREAKER, 100A MAIN BUS				FLUSH MOUNTED W/EQUIPMENT GROUND BAR			
FEEDER SOURCE: NEAREST SERVICE ENTRANCE				SQUARE D TYPE QO OR EQUAL			
CKT. NO.	LOAD DESCRIPTION	BREAKER	LOAD (VA)	LOAD (VA)	BREAKER	LOAD DESCRIPTION	CKT. NO.
	LOCATION	AMP	POLE		POLE	LOCATION	
1	FURNACE BLOWER	30	2	--	--	2	A/C CONDENSER
3	WATER HEATER	20	1	--	1	BATHROOM	6
7	LIGHTING	20	1	--	1	KITCHEN COUNTER	8
9	RECEPTACLES LIVING ROOM	20	1	--	1	REFRIGERATOR	10
11	RECEPTACLES BEDROOM 1	20	1	--	1	SPARE	12
<input type="checkbox"/> SOLID NEUTRAL NEUTRAL WIRE (W)				<input type="checkbox"/> GROUND BUS GROUND WIRE (G)			
TOTAL CONNECTED LOAD (VA)				TOTAL CONNECTED LOAD (VA)			
A0=				B0=			

PANEL TYPICAL TWO BEDROOM APARTMENT				VOLTAGE: 120/208v, 1ø, 3w			
LOCATION: 80A MAIN BREAKER, 100A MAIN BUS				FLUSH MOUNTED W/EQUIPMENT GROUND BAR			
FEEDER SOURCE: NEAREST SERVICE ENTRANCE				SQUARE D TYPE QO OR EQUAL			
CKT. NO.	LOAD DESCRIPTION	BREAKER	LOAD (VA)	LOAD (VA)	BREAKER	LOAD DESCRIPTION	CKT. NO.
	LOCATION	AMP	POLE		POLE	LOCATION	
1	FURNACE BLOWER	30	2	--	--	2	A/C CONDENSER
3	WATER HEATER	20	1	--	1	BATHROOM	6
7	LIGHTING	20	1	--	1	KITCHEN COUNTER	8
9	RECEPTACLES LIVING ROOM	20	1	--	1	REFRIGERATOR	10
11	RECEPTACLES BEDROOM 1	20	1	--	1	BEDROOM 2	12
<input type="checkbox"/> SOLID NEUTRAL NEUTRAL WIRE (W)				<input type="checkbox"/> GROUND BUS GROUND WIRE (G)			
TOTAL CONNECTED LOAD (VA)				TOTAL CONNECTED LOAD (VA)			
A0=				B0=			

REVISIONS	BY
08/28/08	

Drawn by
 Checked by
 Date: 03/26/08
 Scale: 1/8"=1'-0"
 Job No.

Sheet No.
E4G

PLANS FOR:
Summerfield Retirement Community, LLC
 Brownsuitch Rd. & Dauphine Street
 St. Tammany Parish, LA

LIVING AREA 13360 SQ. FT.
 COVERED AREAS 172 SQ. FT.
 UNDER BEAM 13552 SQ. FT.

Note: Although every effort has been made in preparing these plans and checking them for accuracy, the contractor must check all dimensions, details and code requirements applicable in the area of construction and be responsible for same.