


FILE NAME: \\sawyer\proj\3102 - Main - 3102 - 3102.dwg DATE: 03/07/2024 11:53:38 AM

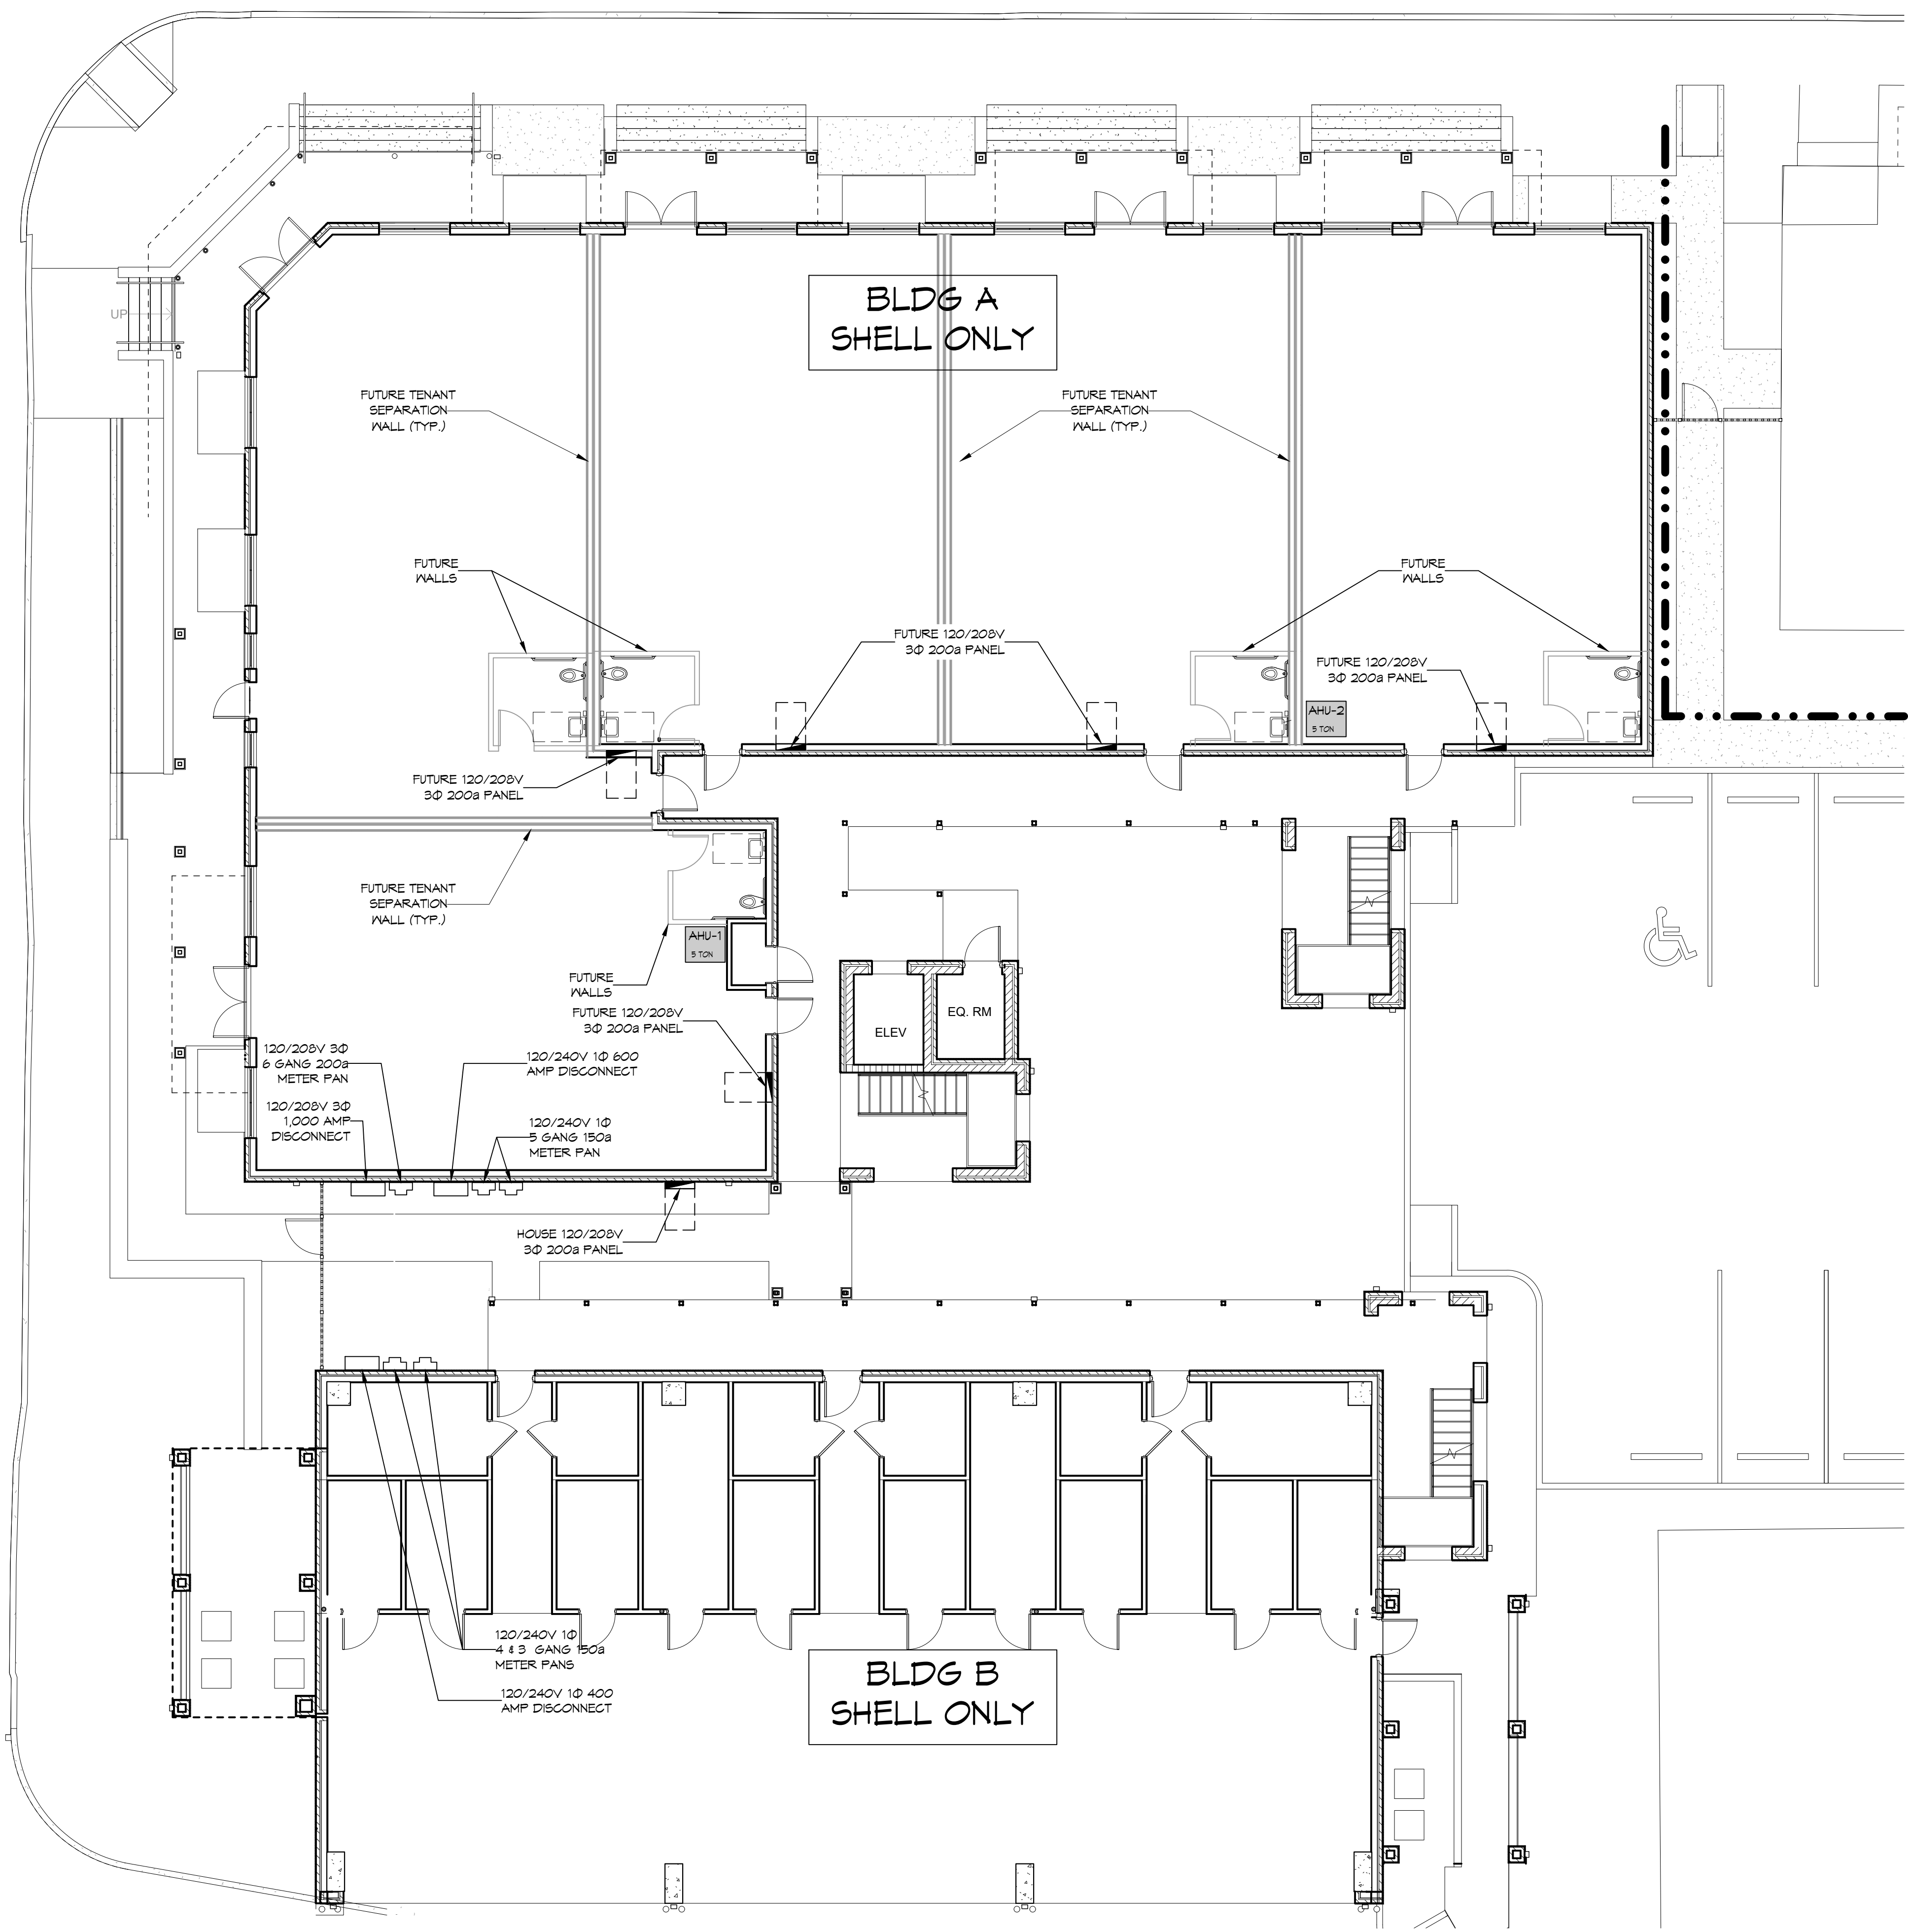

1 FIRST FLOOR MECHANICAL PLAN
SCALE: 1/8" = 1'-0"

TYPICAL DETAILS
SCALE: N.T.S.

DAMMON
ENGINEERING, INC.
LOUISIANA & MISSISSIPPI

Chief Engineer: Brian Wirtch, PE
554 Old Spanish Trail
Slidell, LA 70458
www.dammonengineering.com
info@dammonengineering.com
PH: 985.649.5832

#	DESCRIPTION	DATE

SEAL:

SHELL BUILDING
S Q U A R E 5
OFFICE AND RETAIL MIXED USE AND
RESIDENTIAL CONDOMINIUMS

BOSTON STREET AND VERMONT STREET,
COVINGTON, LA 70458

JOB No: 2442 DATE: 3/7/2024
DRAWN BY: CKD CHECKED BY: BAW

SHEET TITLE:
FIRST FLOOR ELECTRICAL PLAN

DRAWING NUMBER:

E101