


- LIGHT STANDARD
- DROP INLET
- TELE. RISER
- CABLE RISER
- SEWER CLEANOUT
- SEWER MANHOLE
- FIRE HYDRANT
- WATER VALVE
- WATER METER
- GUY WIRE
- UTILITY POLE
- GAS VALVE
- DRAIN MANHOLE
- UNDERGROUND WATER LINE MARKINGS
- UNDERGROUND FIBER/COMM LINE MARKINGS
- UNDERGROUND SEWER LINE MARKINGS
- 10"(BASE) CRAPLE MYRTLE

LEGEND - NEW IMPROVEMENTS


- WATERLINE
- DOMESTIC WATERLINE
- FIRE WATERLINE
- SANITARY SEWERLINE
- UNDERGROUND TELEPHONE
- UNDERGROUND ELECTRIC
- STORM DRAIN SYSTEM

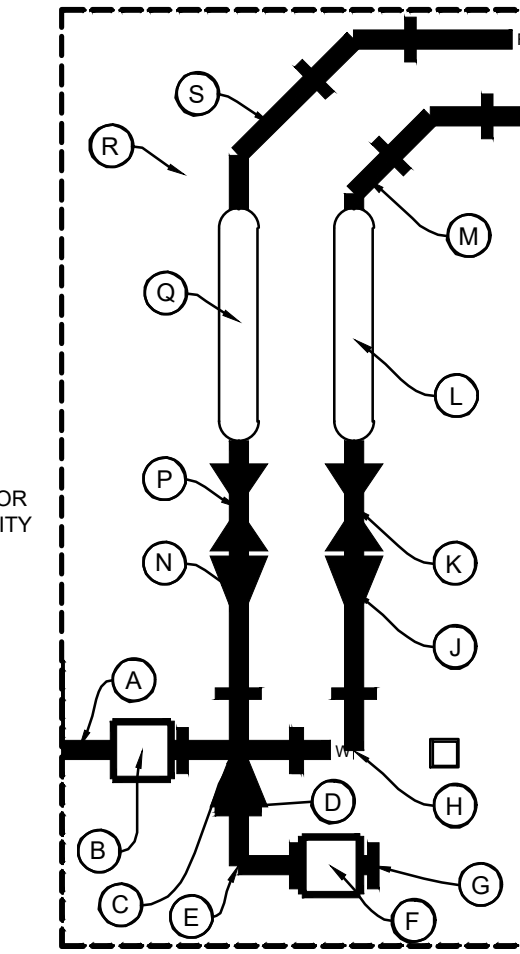

DETAIL 'A' KEYNOTE LEGEND

- A. 8" WATER LINE - REF. PLAN VIEW FOR CONTINUATION.
- B. 8" WATER METER TO BE INSTALLED WITHIN RIGHT-OF-WAY.
- C. 8" TEE
- D. 8"x1" REDUCER FITTING.
- E. 90° BEND
- F. 1" IRRIGATION WATER METER TO BE INSTALLED BY UTILITY PROVIDER.
- G. 1" PLUG
- H. 90° BEND
- J. 8"x4" REDUCER FITTING.
- K. 4" GATE VALVE.
- L. 4" ABOVEGROUND DOMESTIC WATER LINE BACKFLOW PREVENTER.
- M. 4" DOMESTIC WATER LINE TO BUILDINGS - REF. PLAN VIEW FOR CONTINUATION.
- N. 8"x8" REDUCER FITTING.
- P. 6" GATE VALVE.
- Q. 6" ABOVEGROUND FIRE WATER LINE BACKFLOW PREVENTER.
- R. 6"x13" CONCRETE PAD - REF. CIVIL PLANS FOR DETAILS.
- S. 6" FIRE WATER LINE TO BUILDINGS - REF. PLAN VIEW FOR CONTINUATION.

DETAIL 'A' N.T.S.

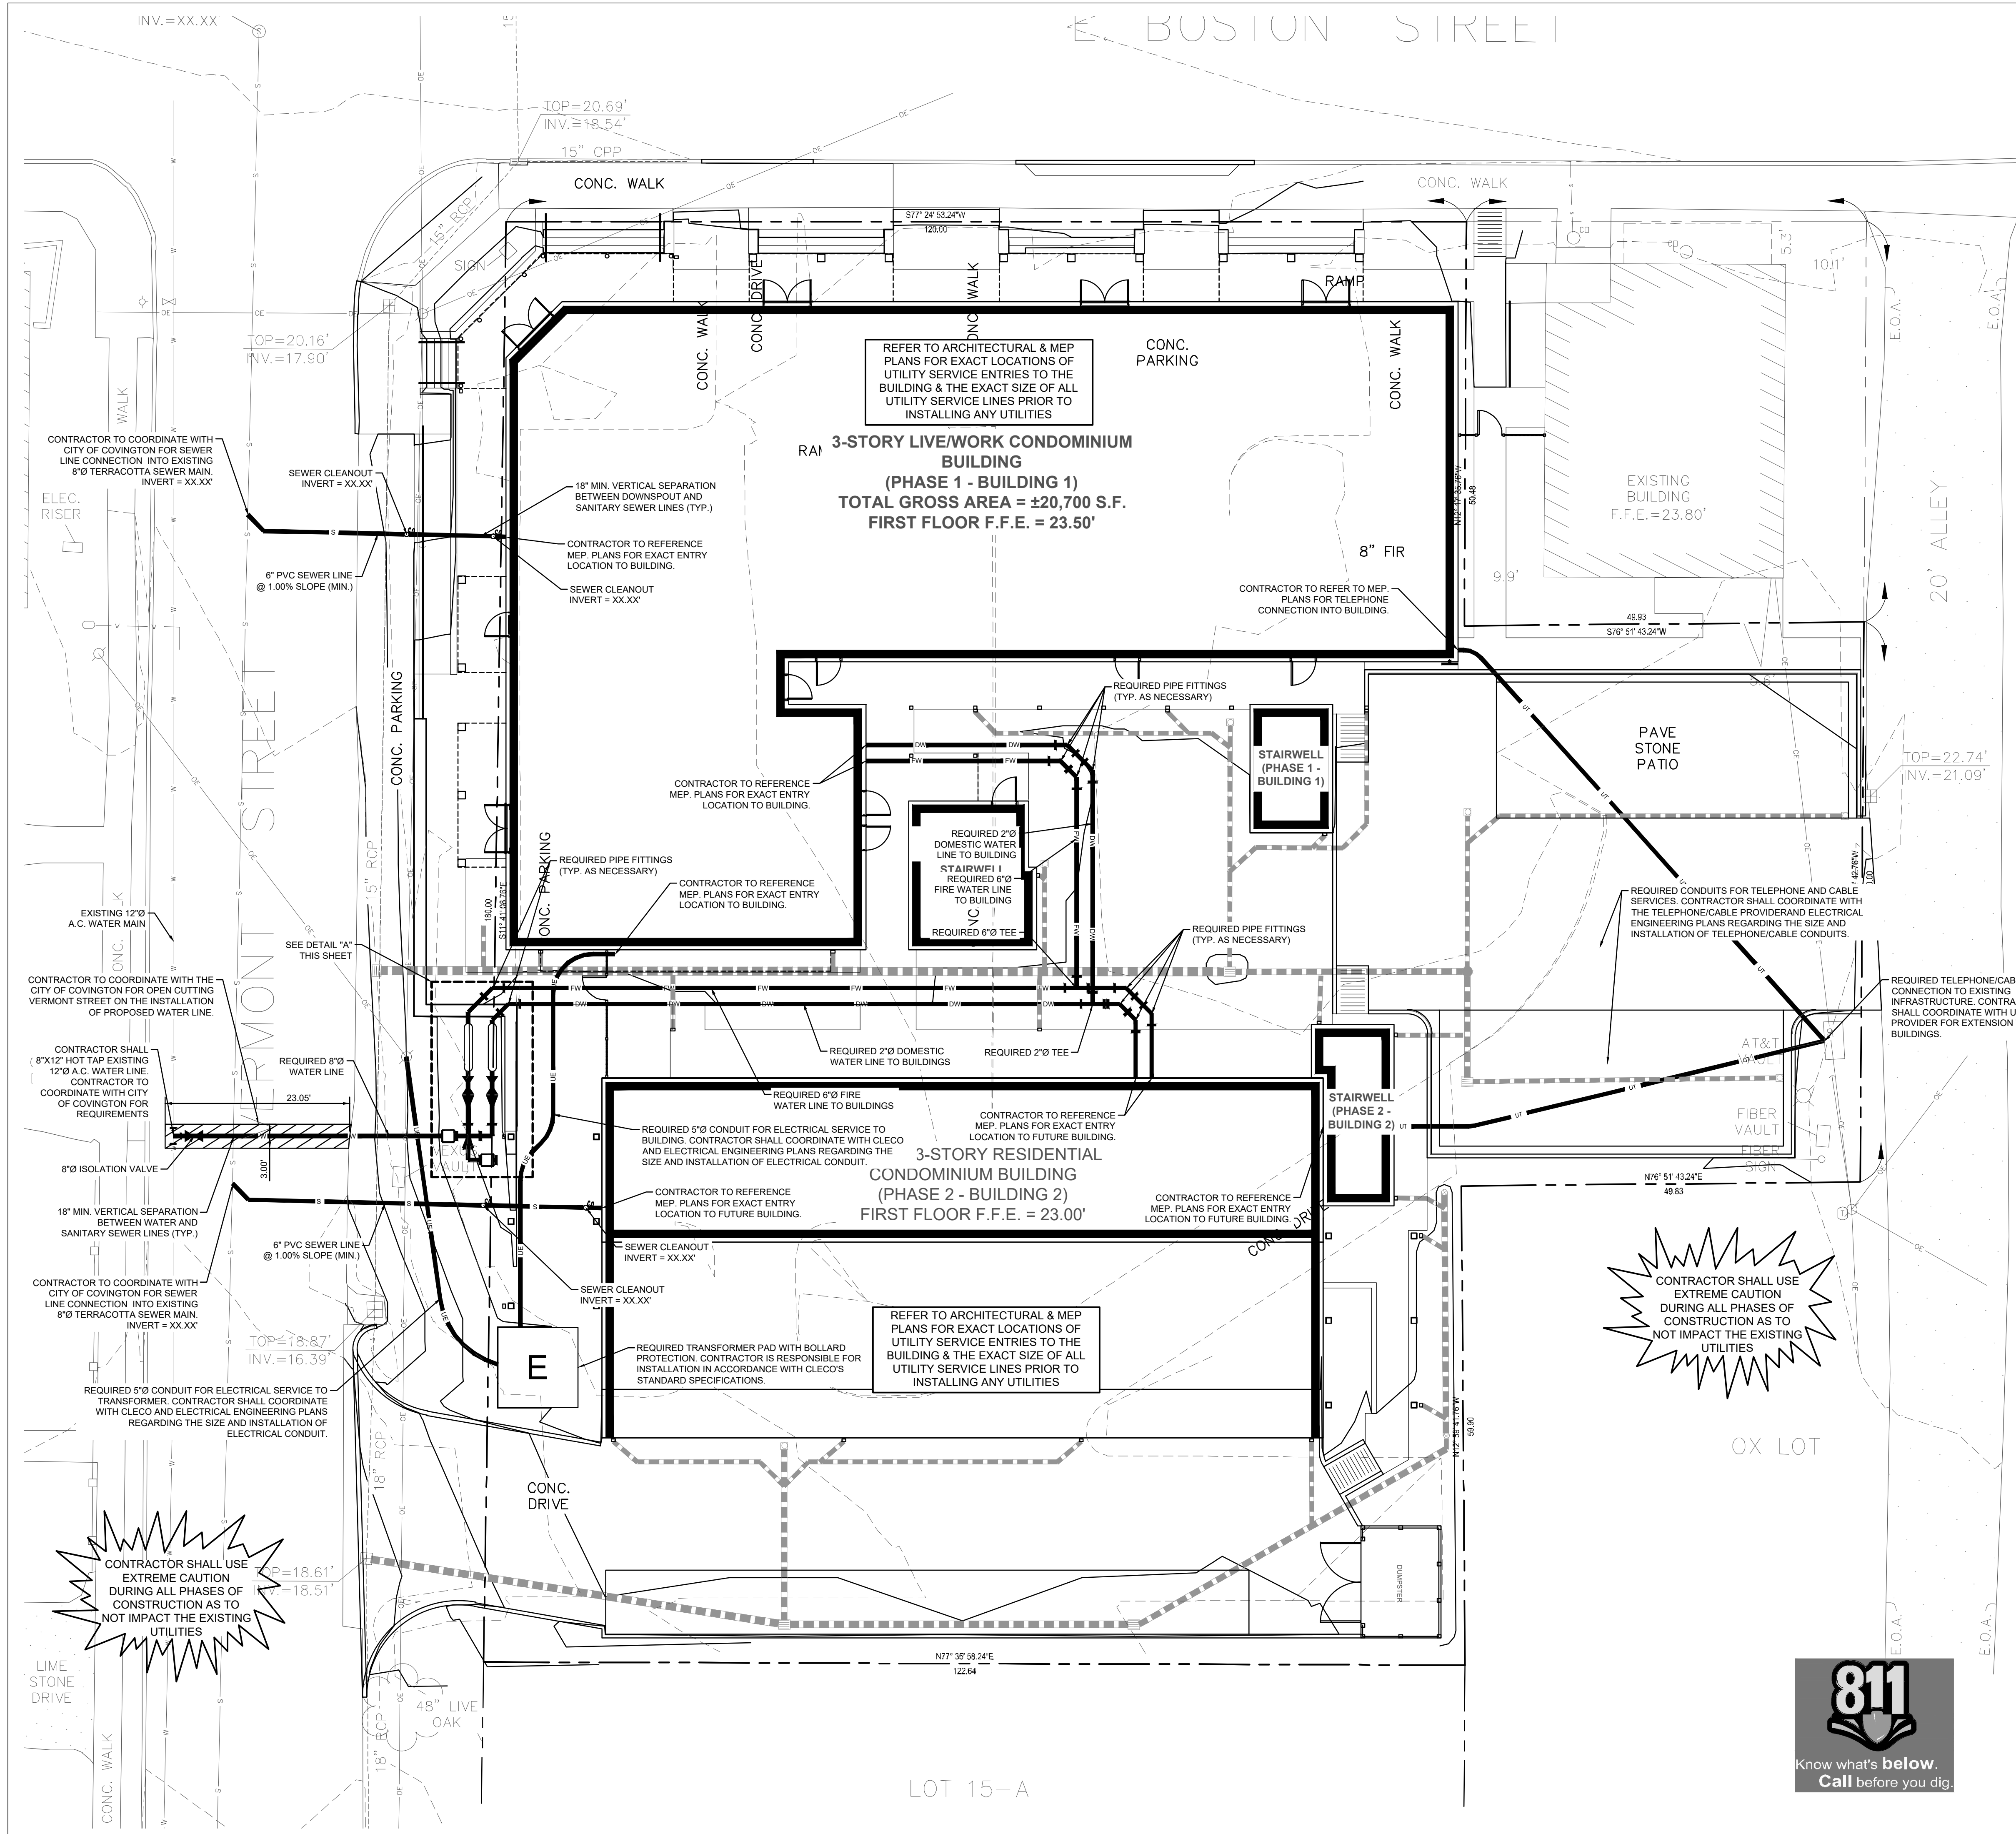

**SQUARE 5 MIXED USE DEVELOPMENT**  
 BOSTON STREET- LA HWY 21 AND VERMONT STREET  
 COVINGTON, LOUISIANA  
 MCMATH DEVELOPMENT



PROJECT NO.	23-1273
SUBMITTAL NAME	01/05/2024
CHECKED	XXX
DRAWN BY	AMR

SHEET

C-3

UTILITY PLAN

