

**DAMMON**  
ENGINEERING, INC.

CHIEF ENGINEER  
DAMIEN  
DAMMON, F.E.  
CHIEF ARCHITECT  
ROBERT  
WILTSE

1095 FLORIDA AVENUE  
SUITE 111, LA. 70438  
OFFICE 504.649.5892  
FAX: 504.641.5930

WWW.DAMMONENGINEERING.COM  
EMAIL: DAMON@DAMMONENGINEERING.COM  
DAMMONENR@BLSBOUTHERN.NET

ARCHITECTURE  
ENGINEERING  
STUDIES  
PLANNING  
INVESTIGATION  
EXPERT WITNESS

NEW  
APARTMENT  
COMPLEX

CROSSWINDS  
APARTMENTS  
HAMMOND, LA

BIDG. 3  
OVERALL  
ELECTRICAL  
PLAN

REV: 1/1-15-10


SCALE: AS NOTED

JOB#: 08112.13

DATE: 12-16-09


SHEET

E-4

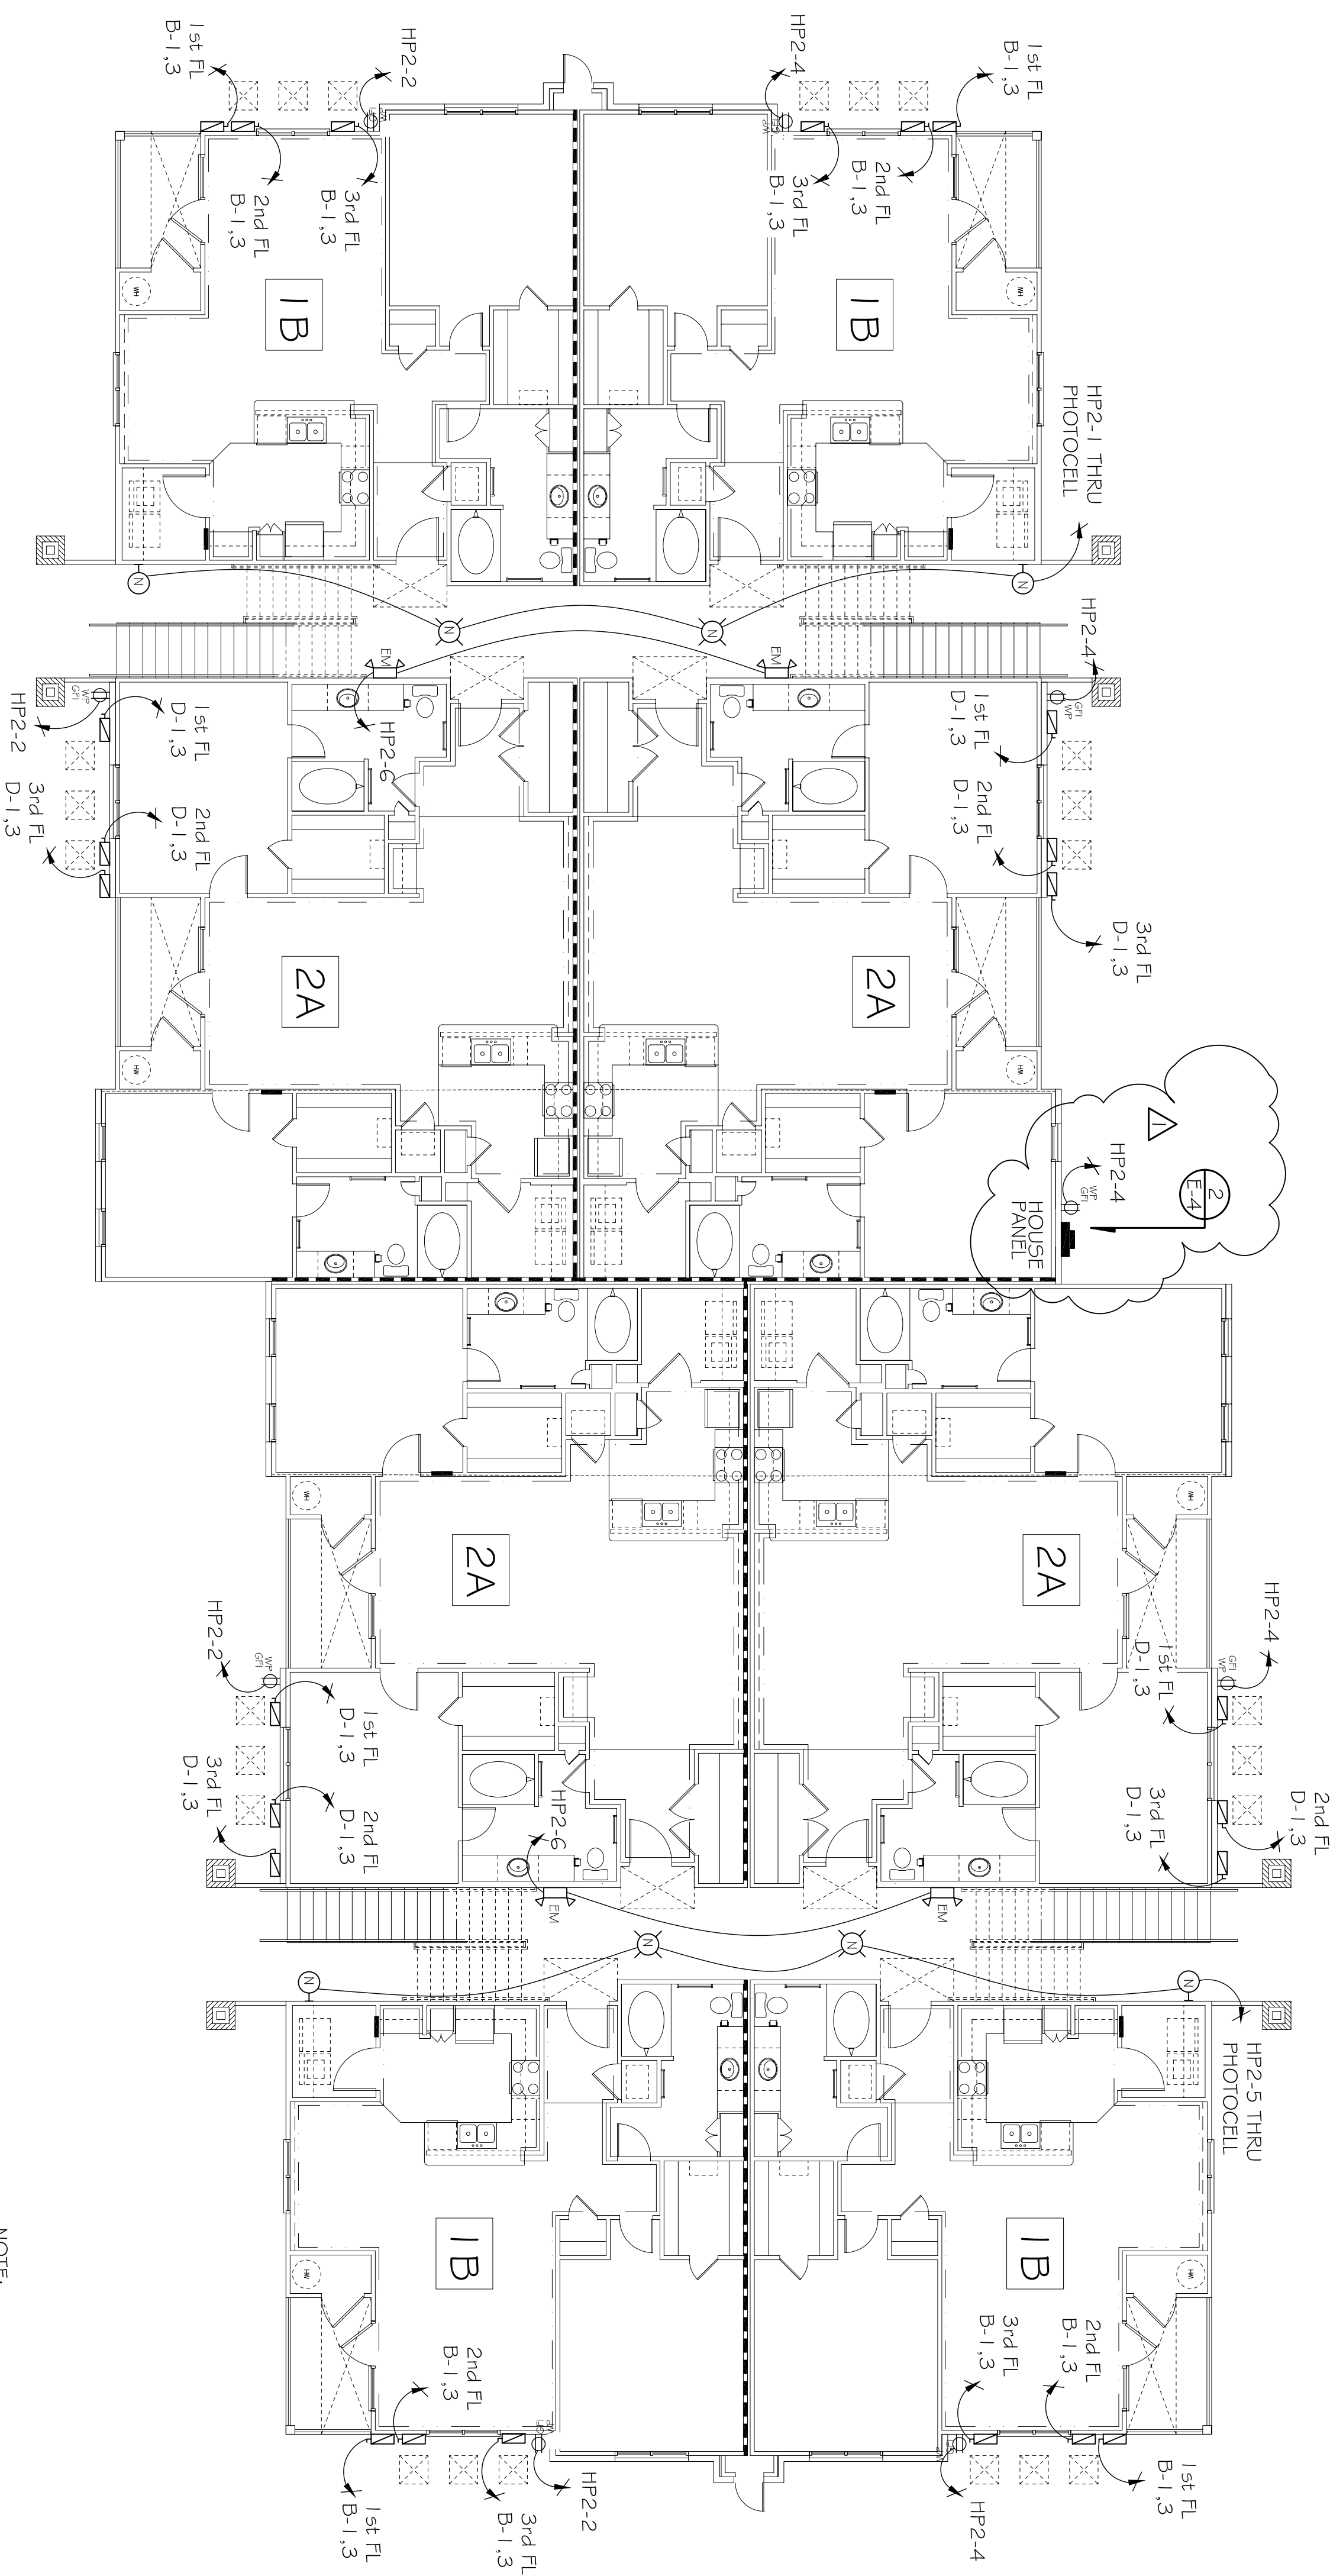


BIDG. 3 1ST FLOOR OVERALL  
ELECTRICAL PLAN  
SCALE: 1/8"=1'-0"

NOTE:  
SEE DRAWINGS E-5 & E-6 ELECTRICAL  
PLANS FOR UNIT POWER AND  
LIGHTING.

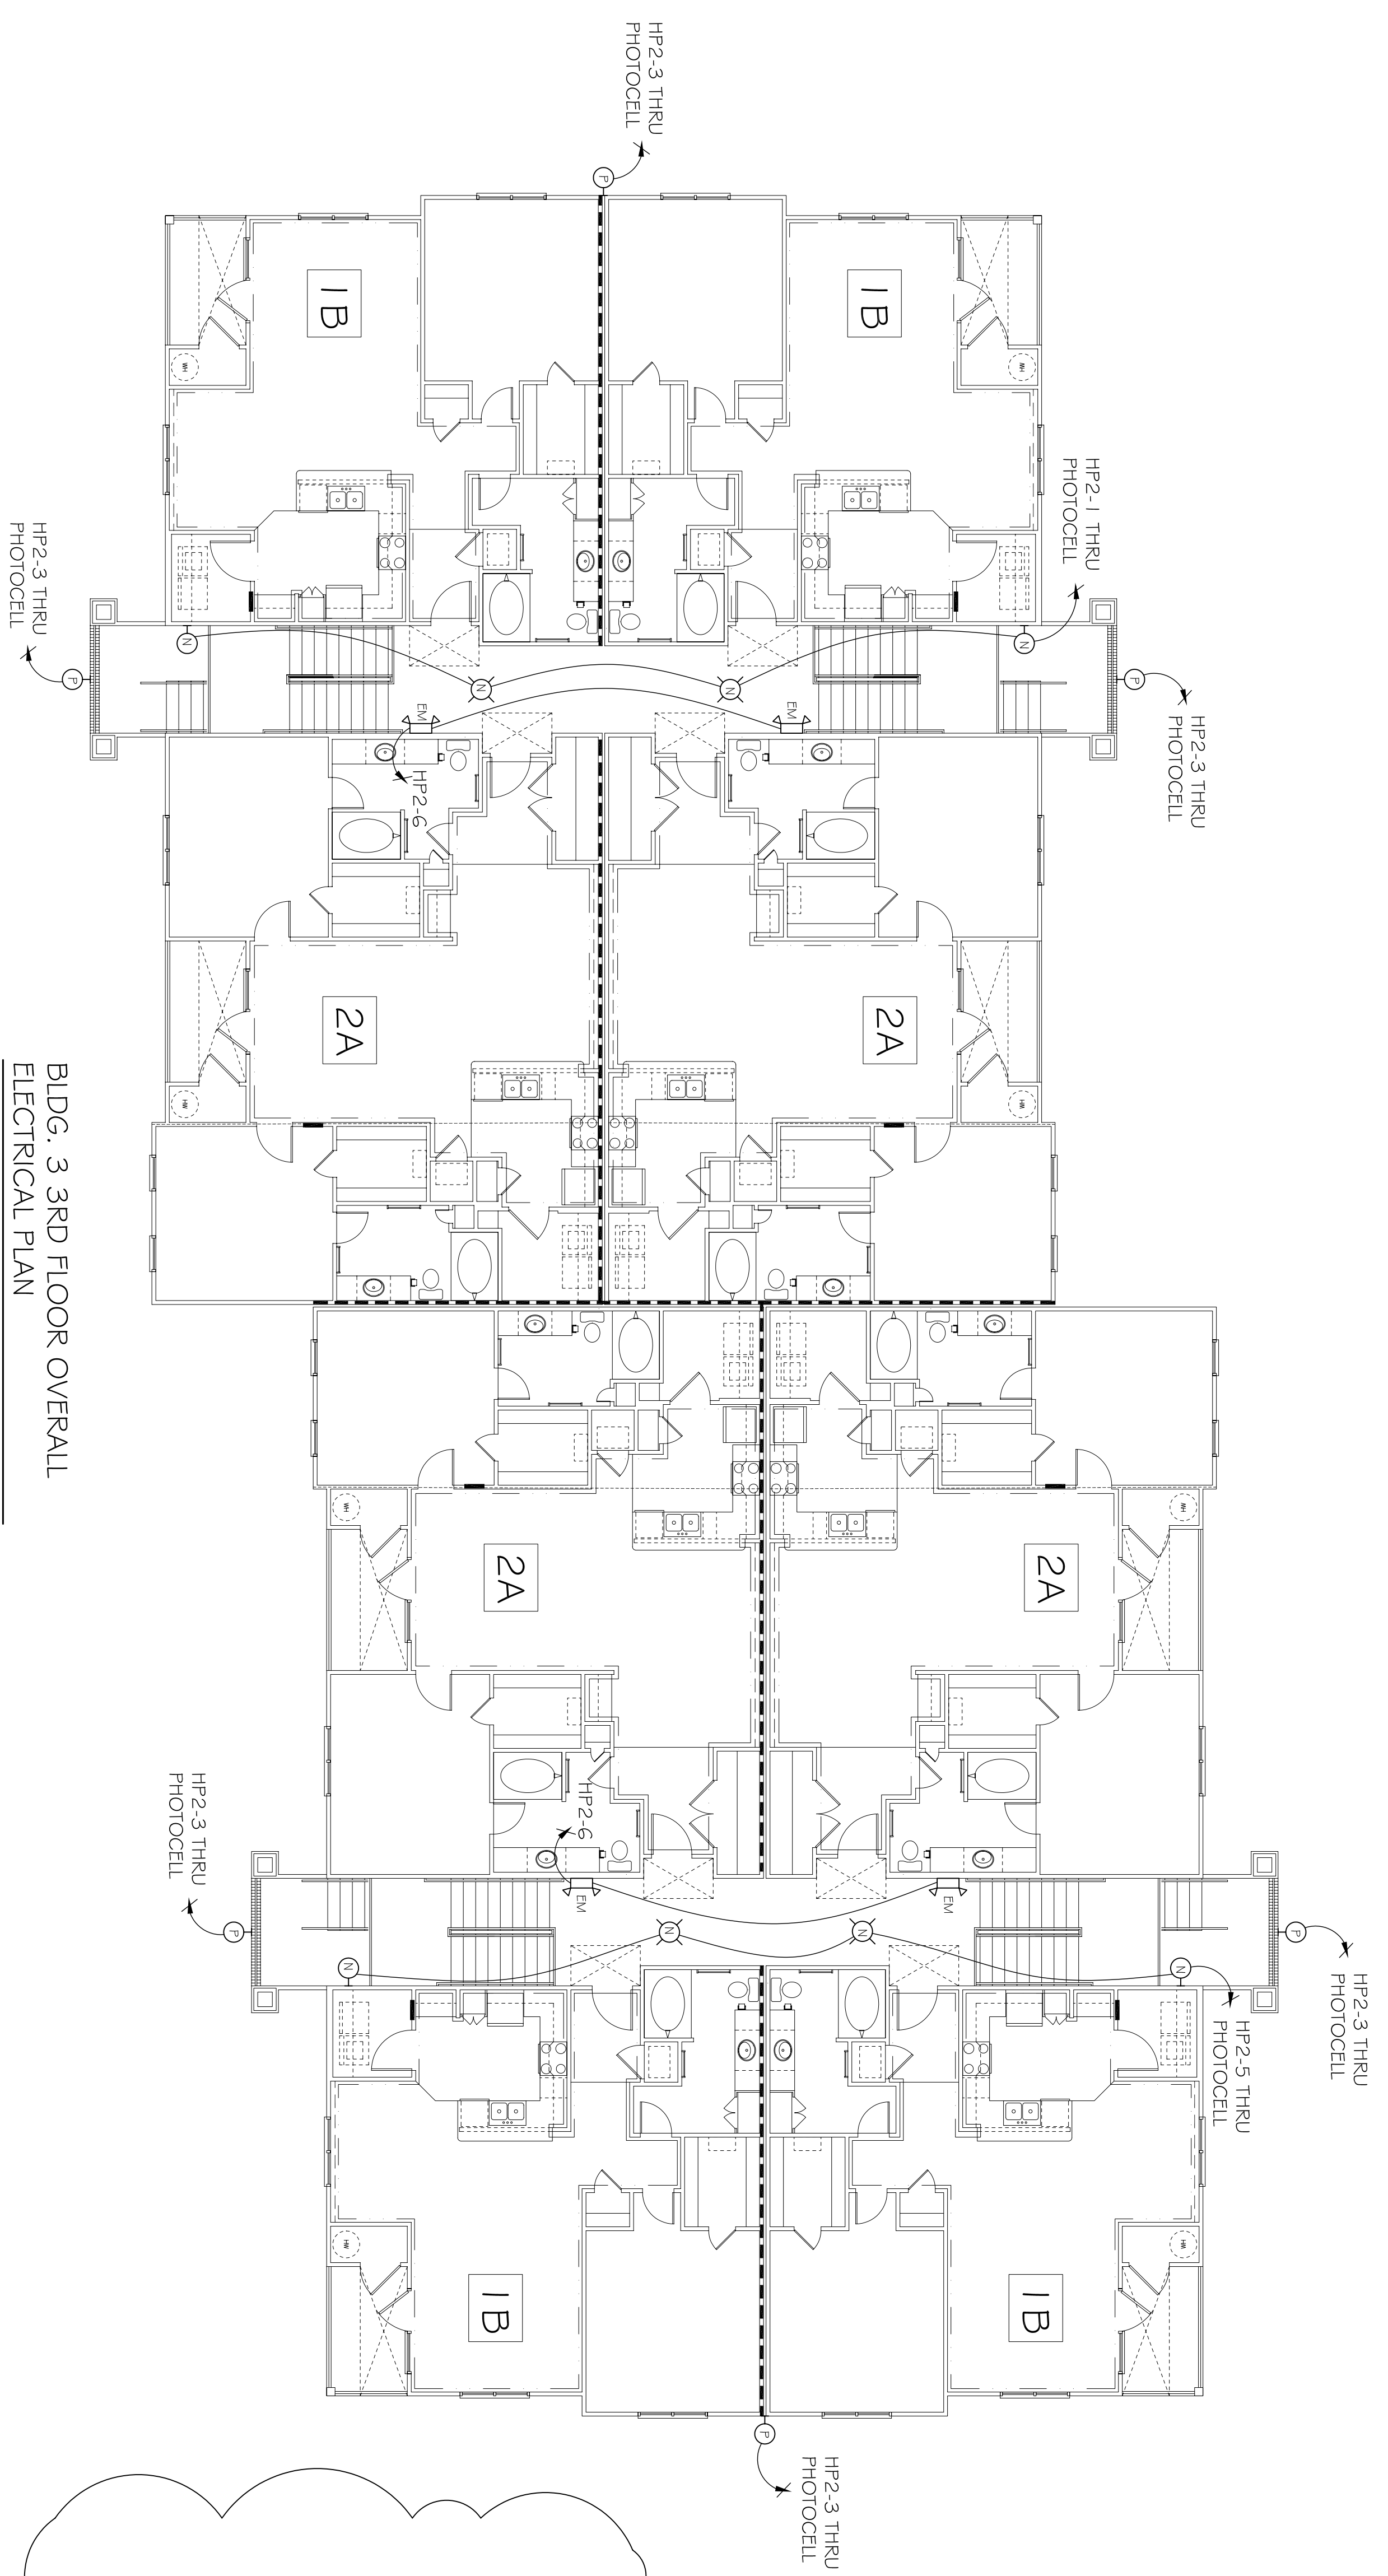

BIDG. 3 3RD FLOOR OVERALL  
ELECTRICAL PLAN  
SCALE: 1/8"=1'-0"

NOTE: 2ND FLOOR IS SIMILAR TO 3RD FLOOR.

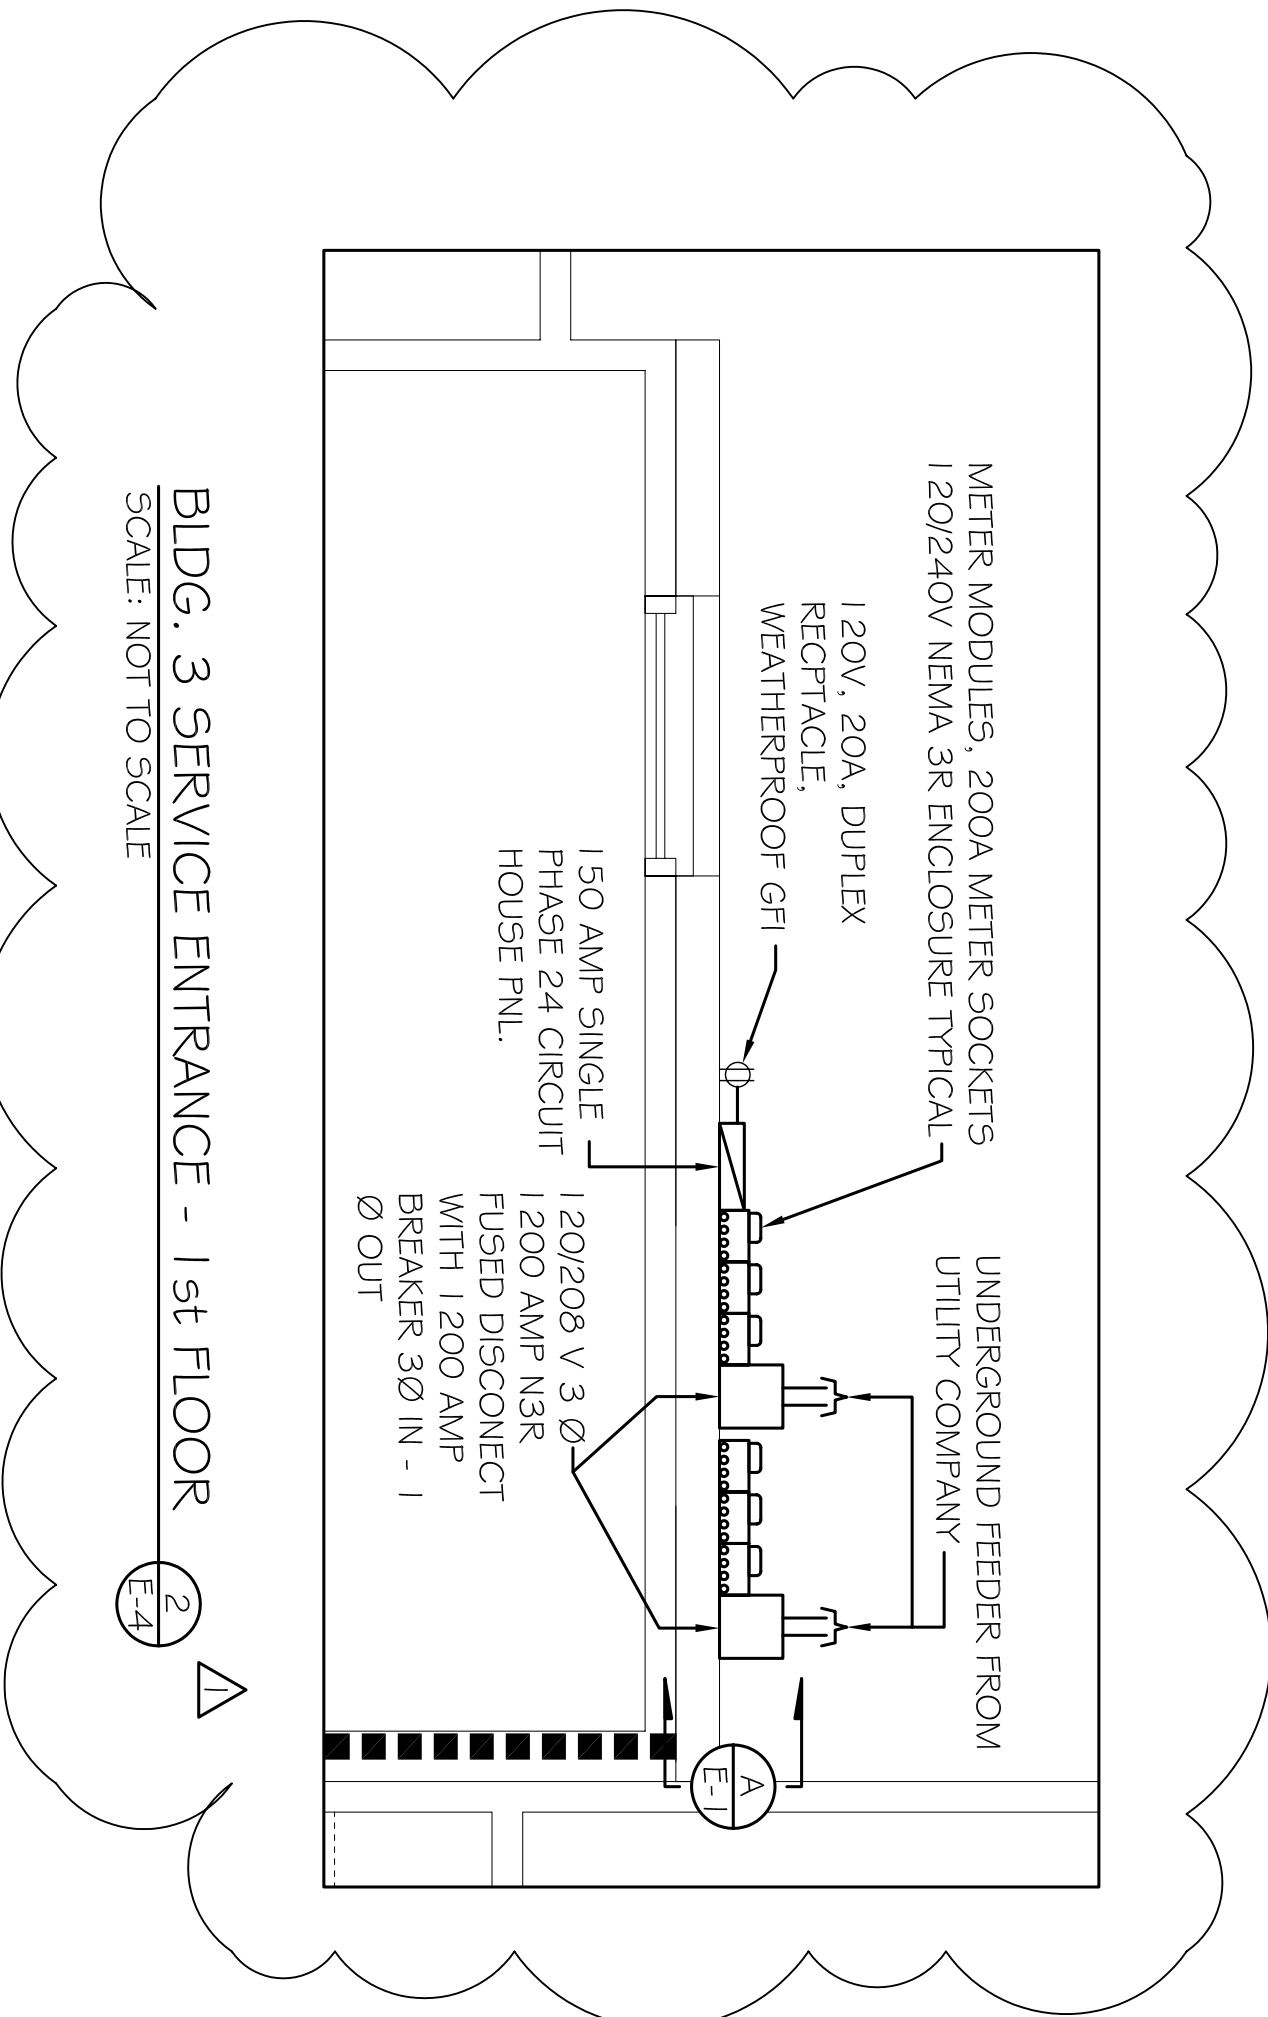

BIDG. 3 SERVICE ENTRANCE - 1ST FLOOR  
SCALE: NOT TO SCALE