




UNIT 1A ELECTRICAL PLAN
SCALE: 3/8"=1'-0"

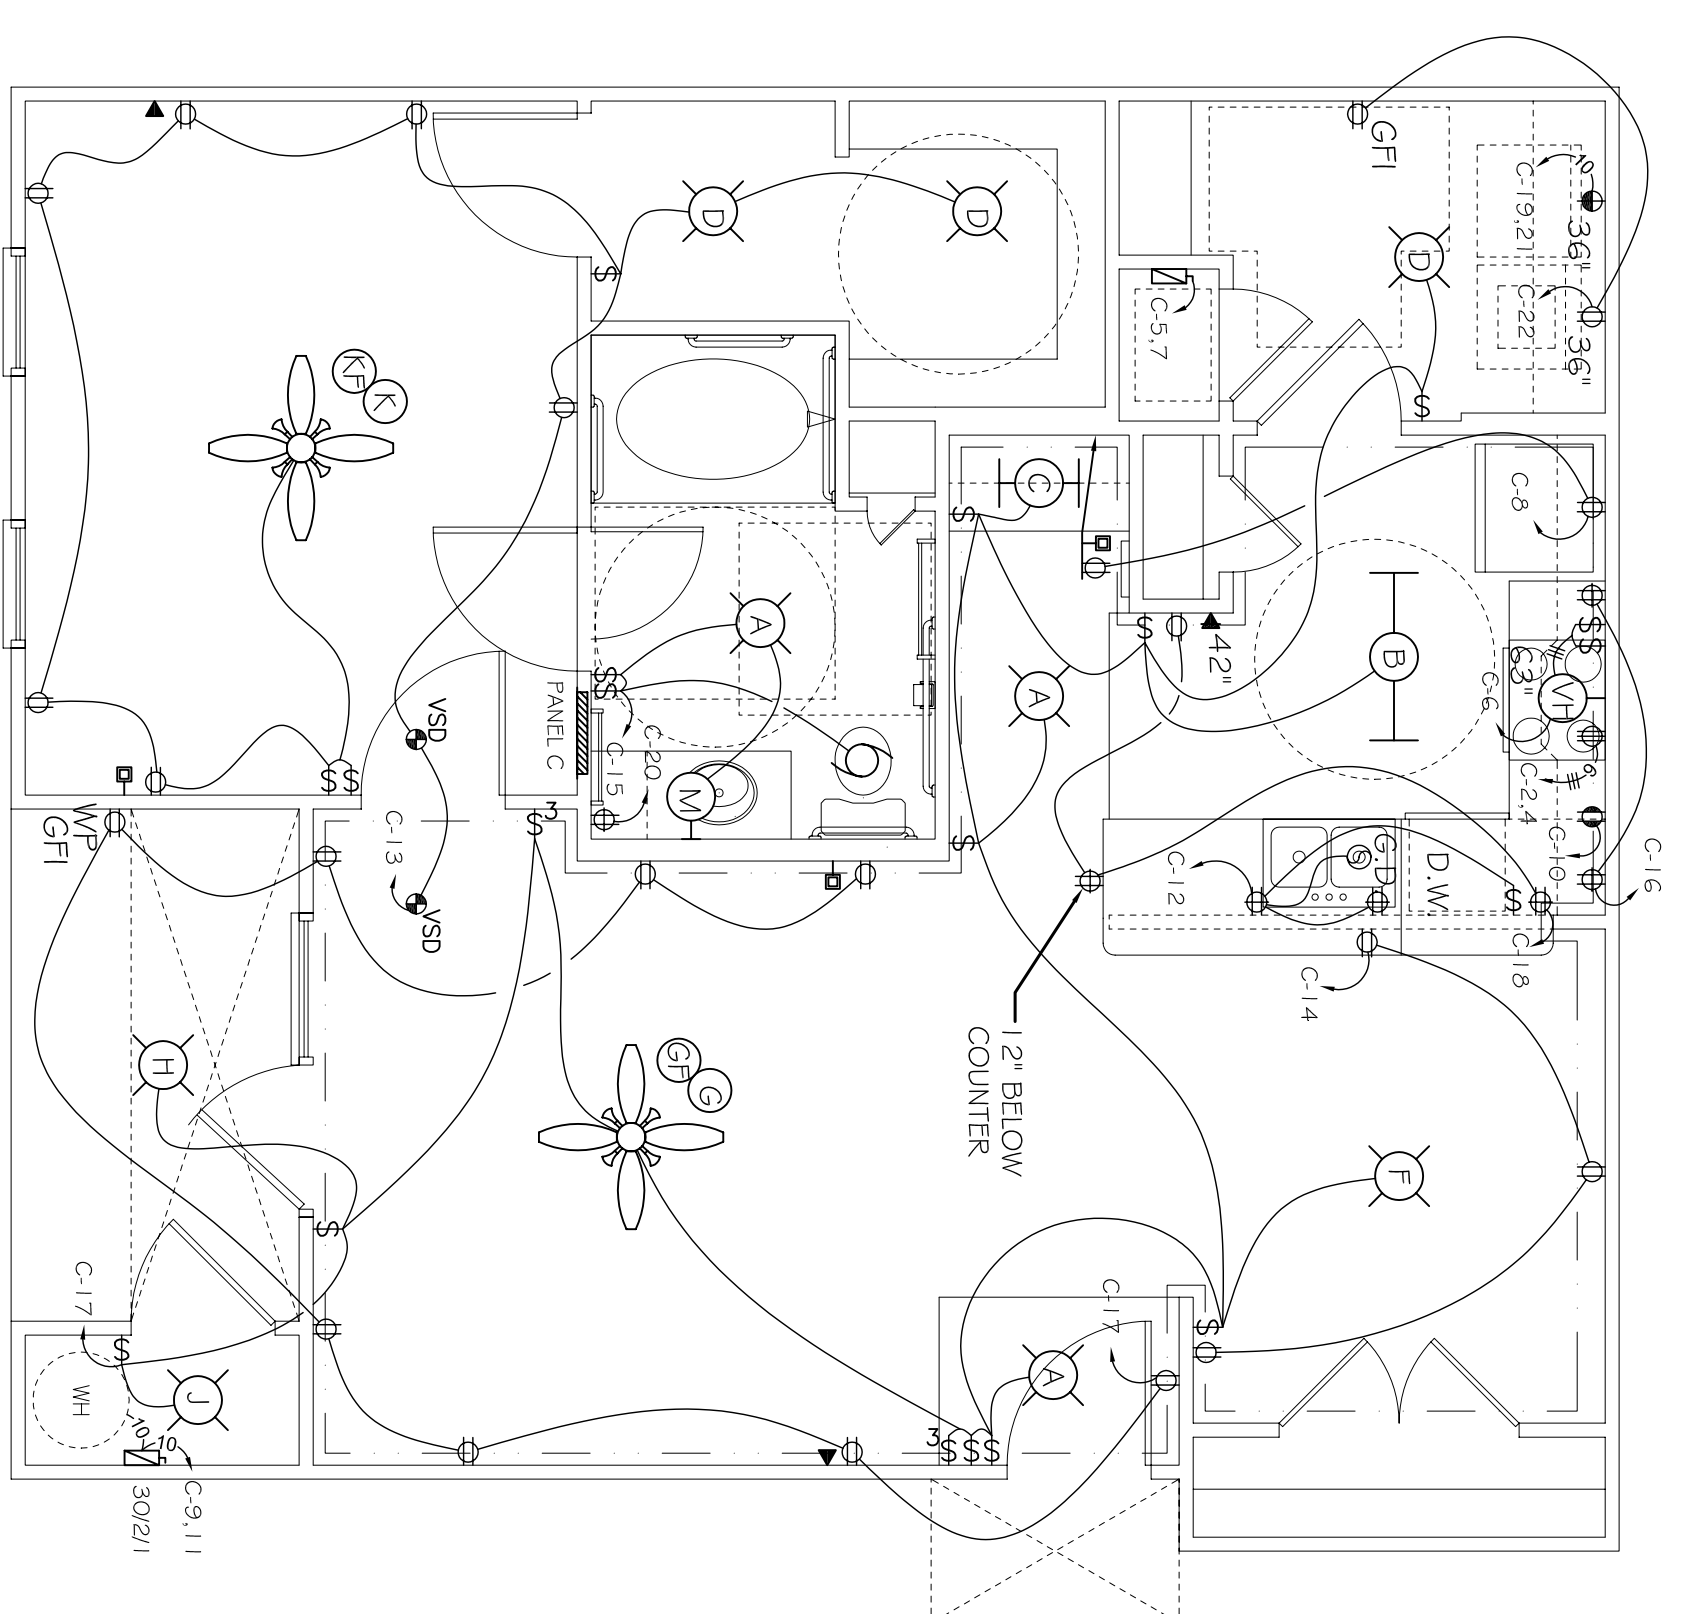


UNIT 1A-HC ELECTRICAL PLAN
SCALE: 3/8"=1'-0"

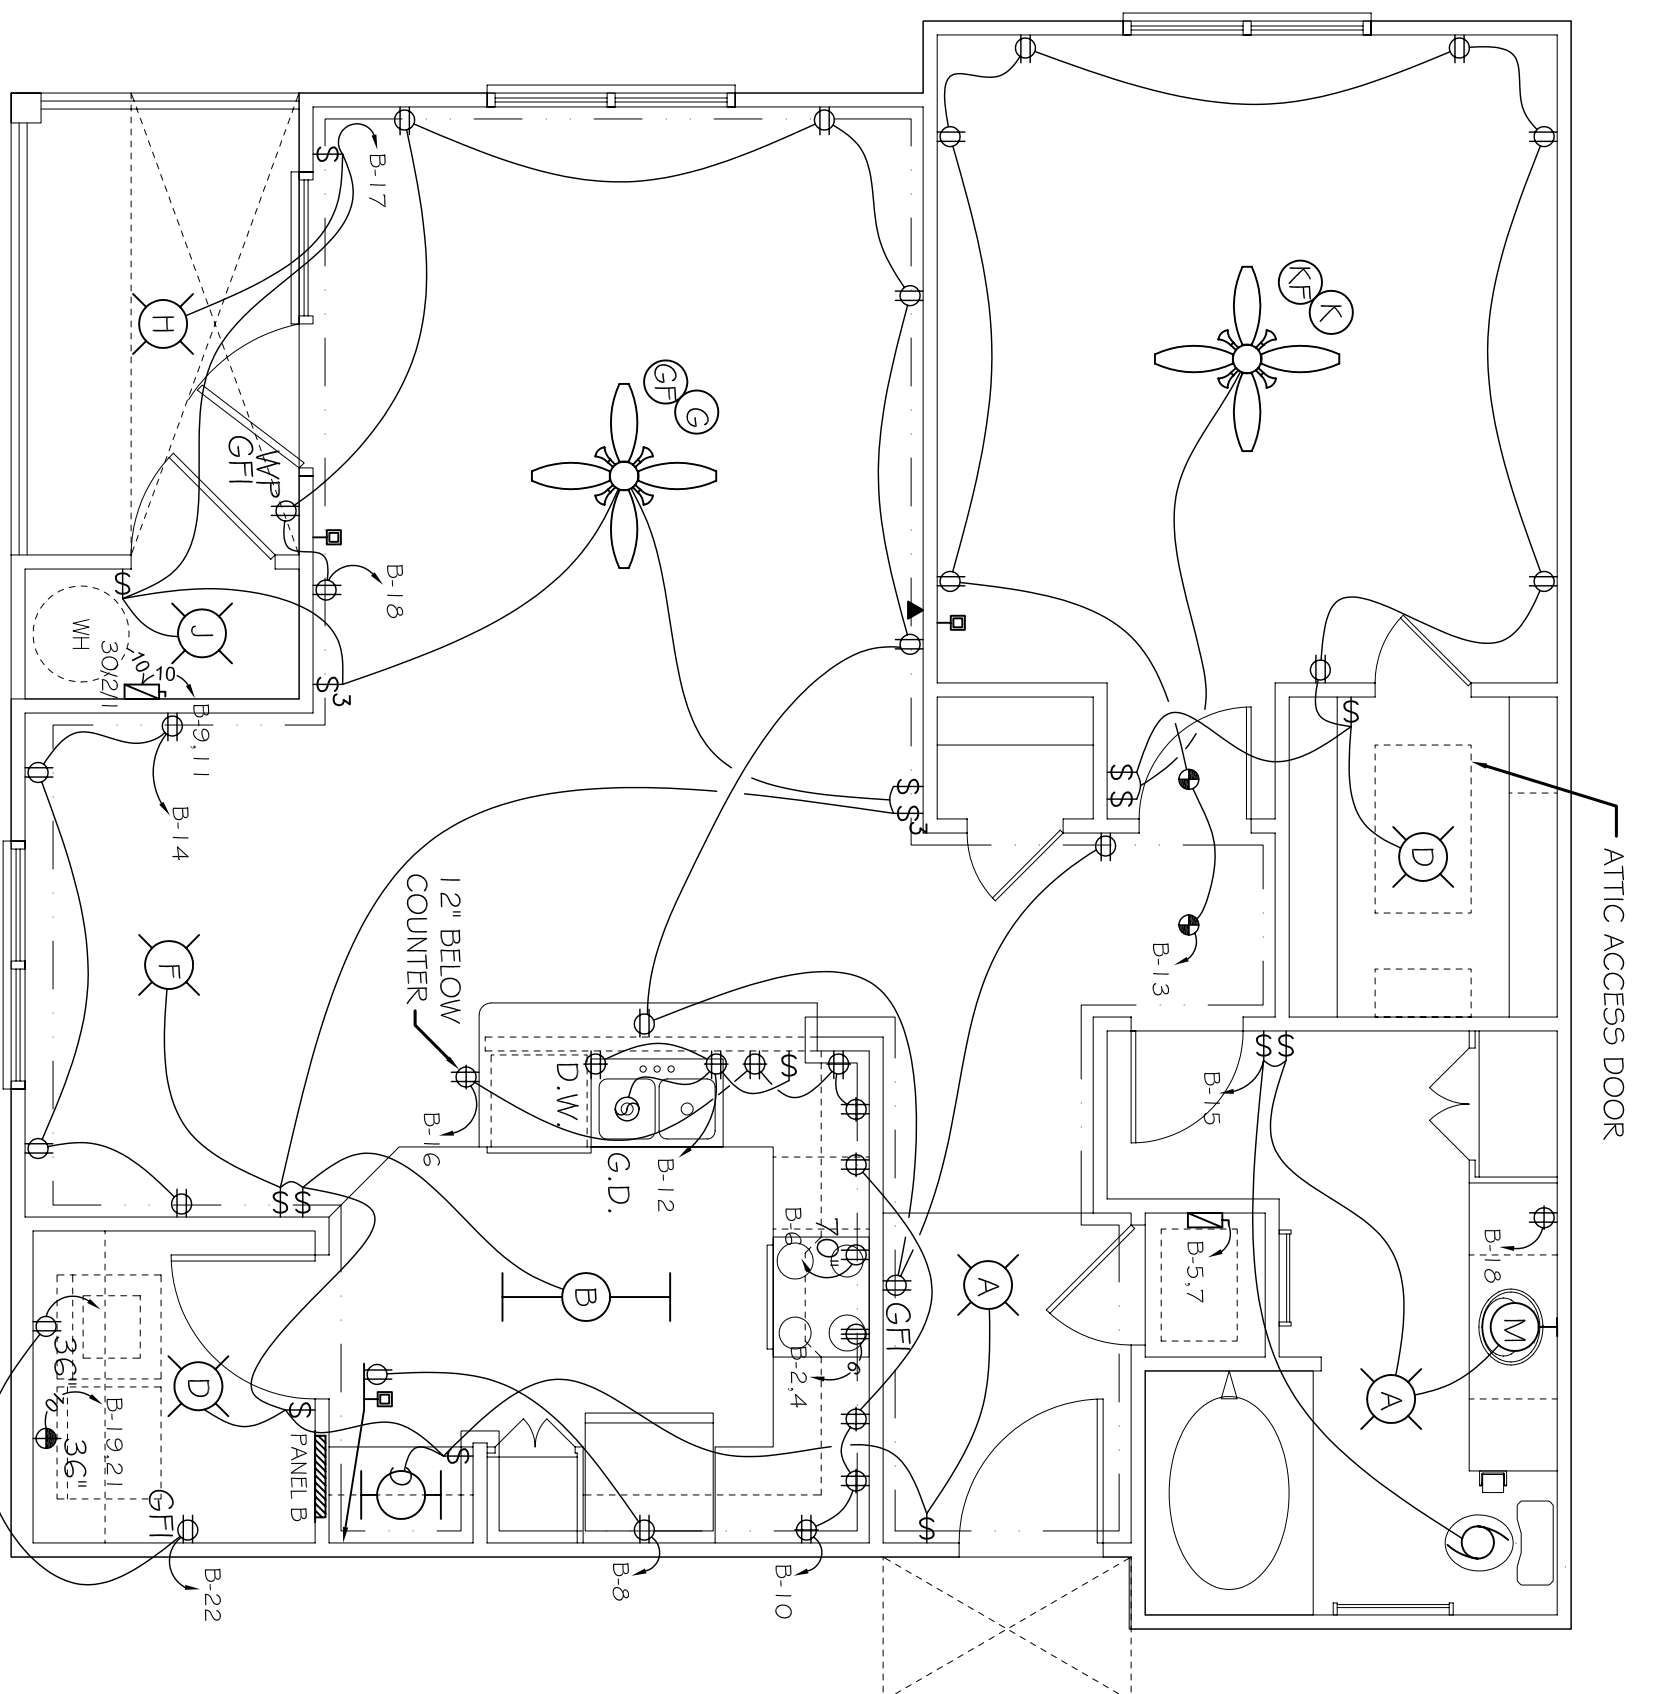

UNIT 1B ELECTRICAL PLAN
SCALE: 3/8"=1'-0"

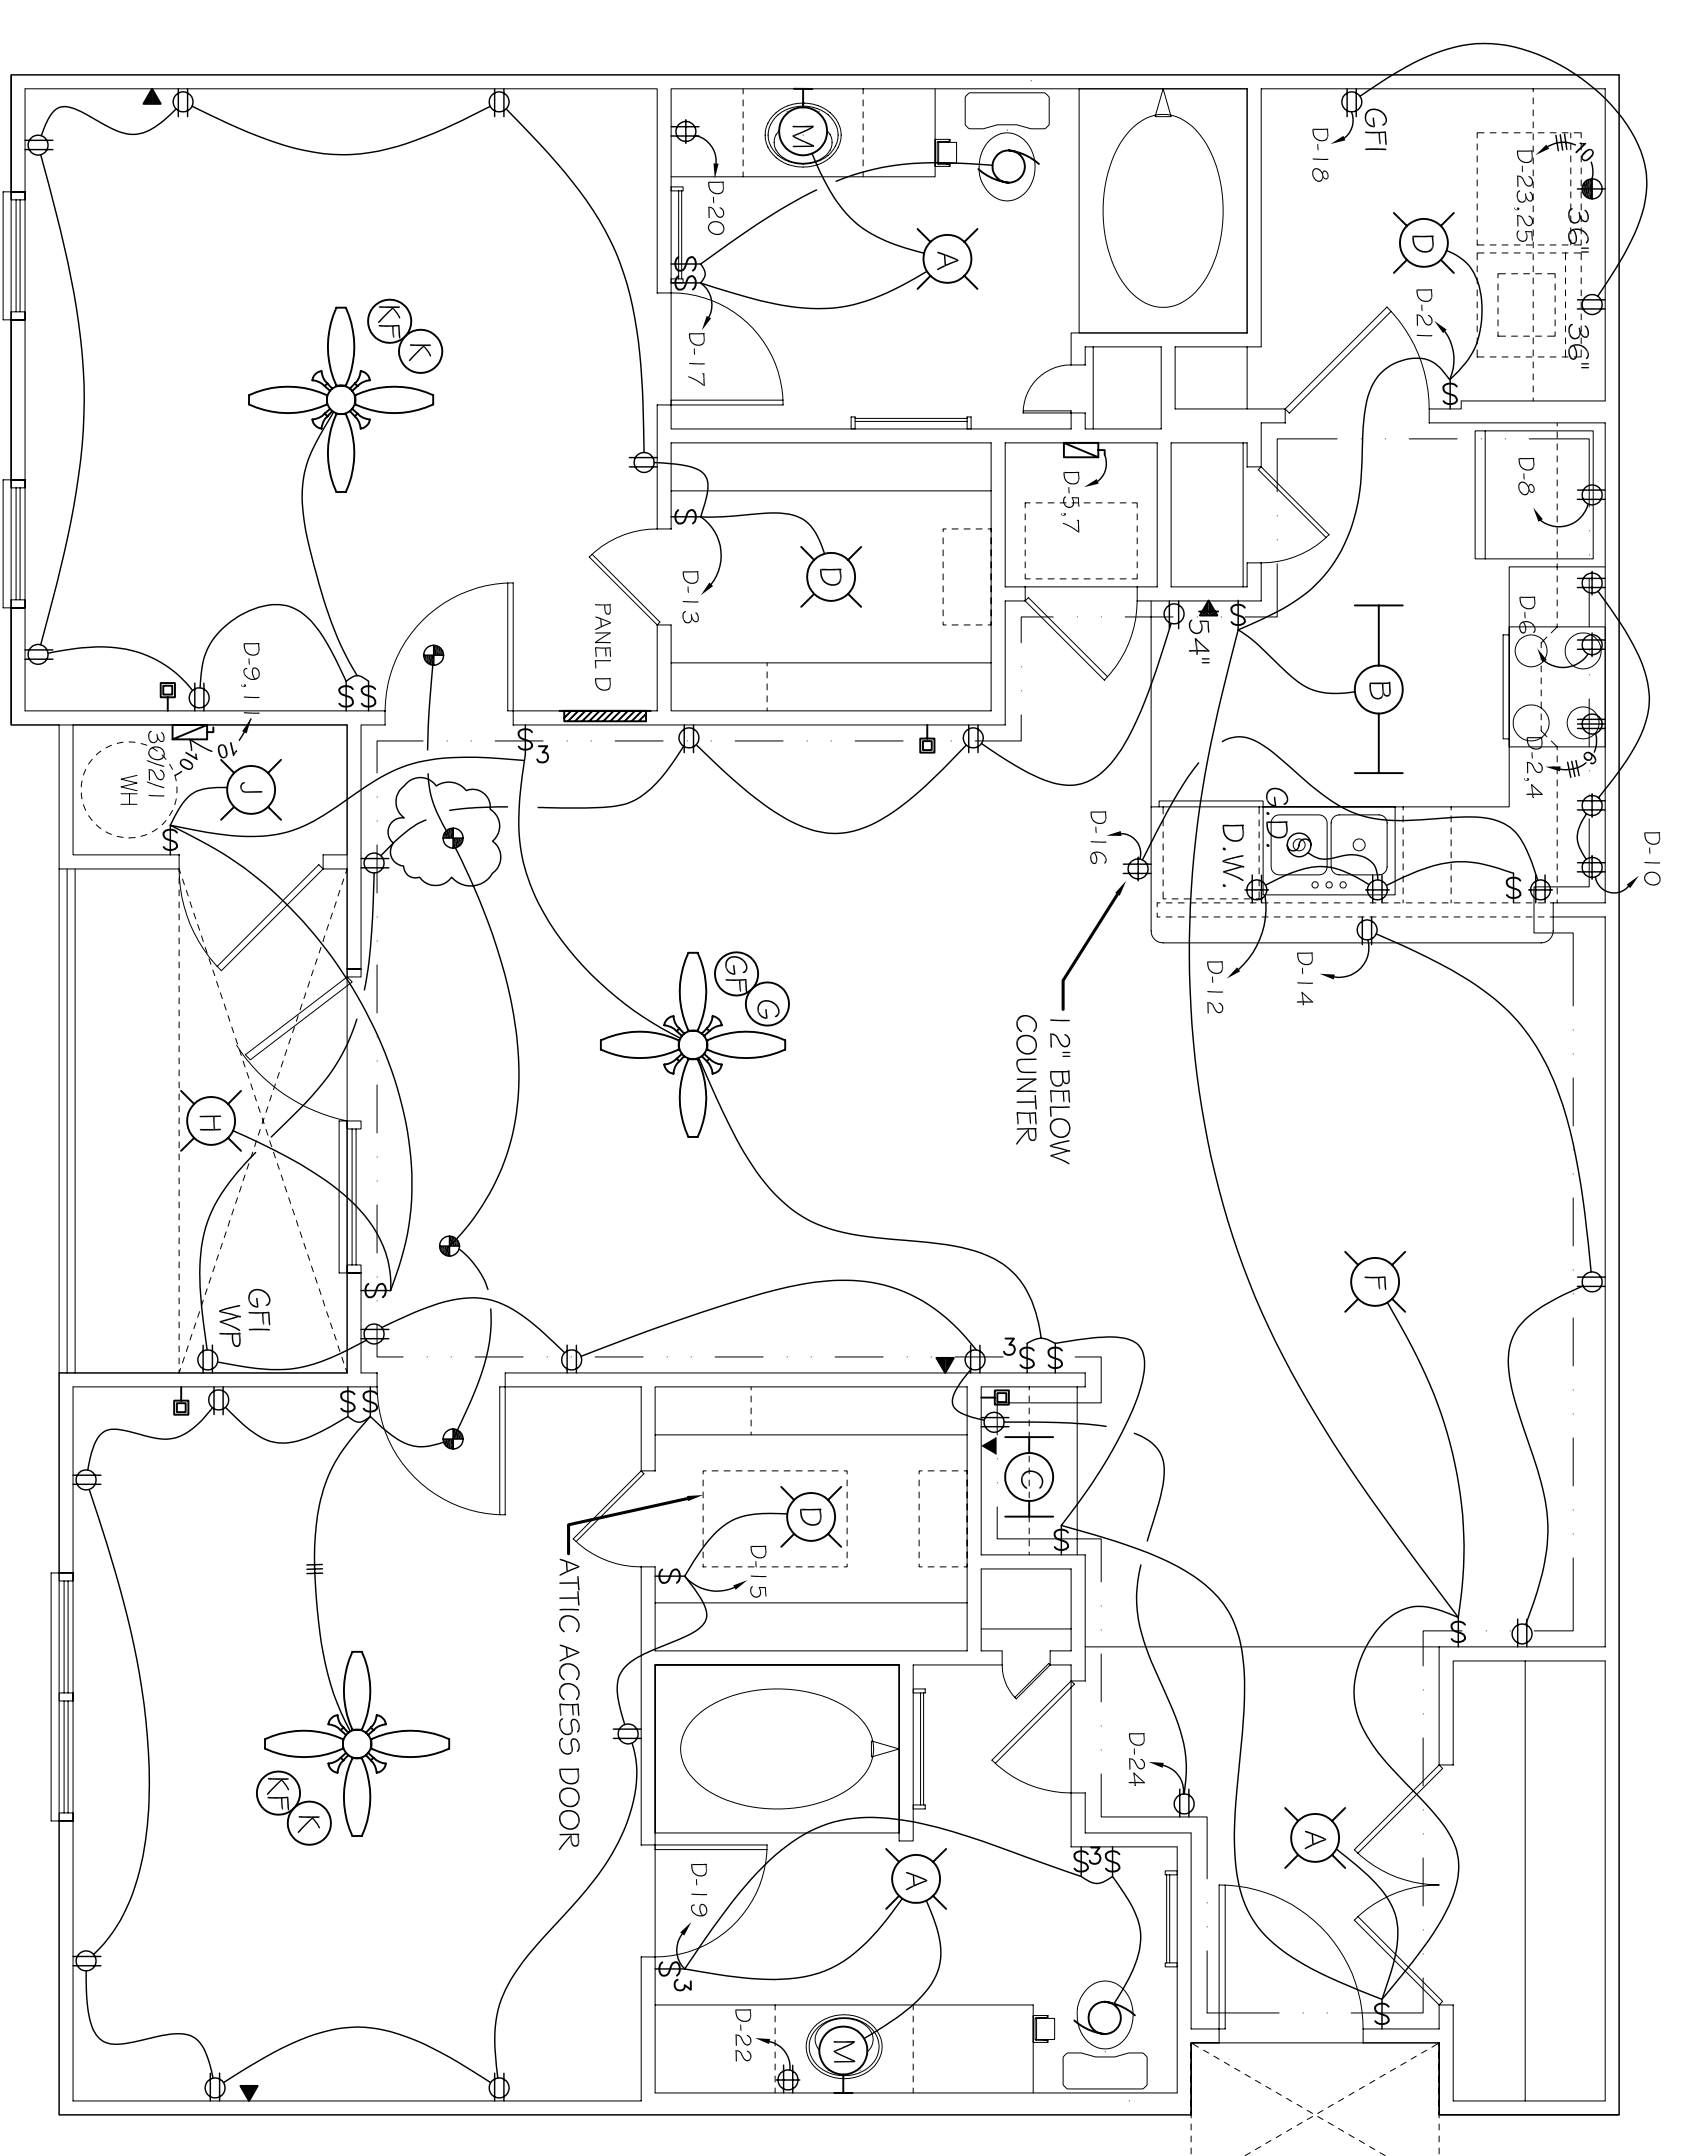

UNIT 2A ELECTRICAL PLAN
SCALE: 3/8"=1'-0"

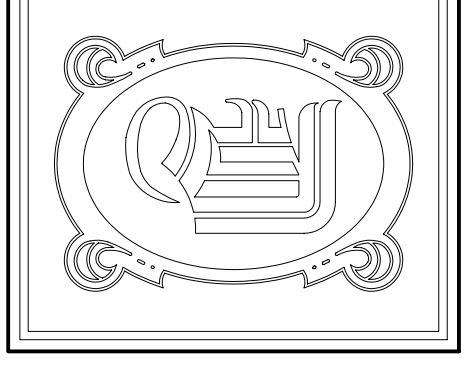

DAMMON
ENGINEERING, INC.

CHIEF ENGINEER
EMMETT
DAMMON, F.I.E.
CHIEF ARCHITECT
ROBERT
WILTSE

1095 FLORIDA AVENUE
SUITE 111, LA. 70455
OFFICE: 504-885-5892
FAX: 504-885-5930

WWW.DAMMONENGINEERING.COM
EMAIL: DAMMON@RELSOLUTION.NET

ARCHITECTURE
ENGINEERING
STUDIES
PLANNING
INVESTIGATION
EXPERT WITNESS

NEW
APARTMENT
COMPLEX

CROSSWINDS
APARTMENTS
HAMMOND, LA

UNITS 1A,
1A-HC, 1B & 2A
ELECTRICAL
PLAN

REV: 2-18-10

SCALE: AS NOTED

JOB#: 08112.13

DATE: 12-11-09

SHEET

E-5

OF