




LEASING BLDG. 1ST FLOOR  
LIGHTING PLAN  
SCALE: 1/8"=1'-0"

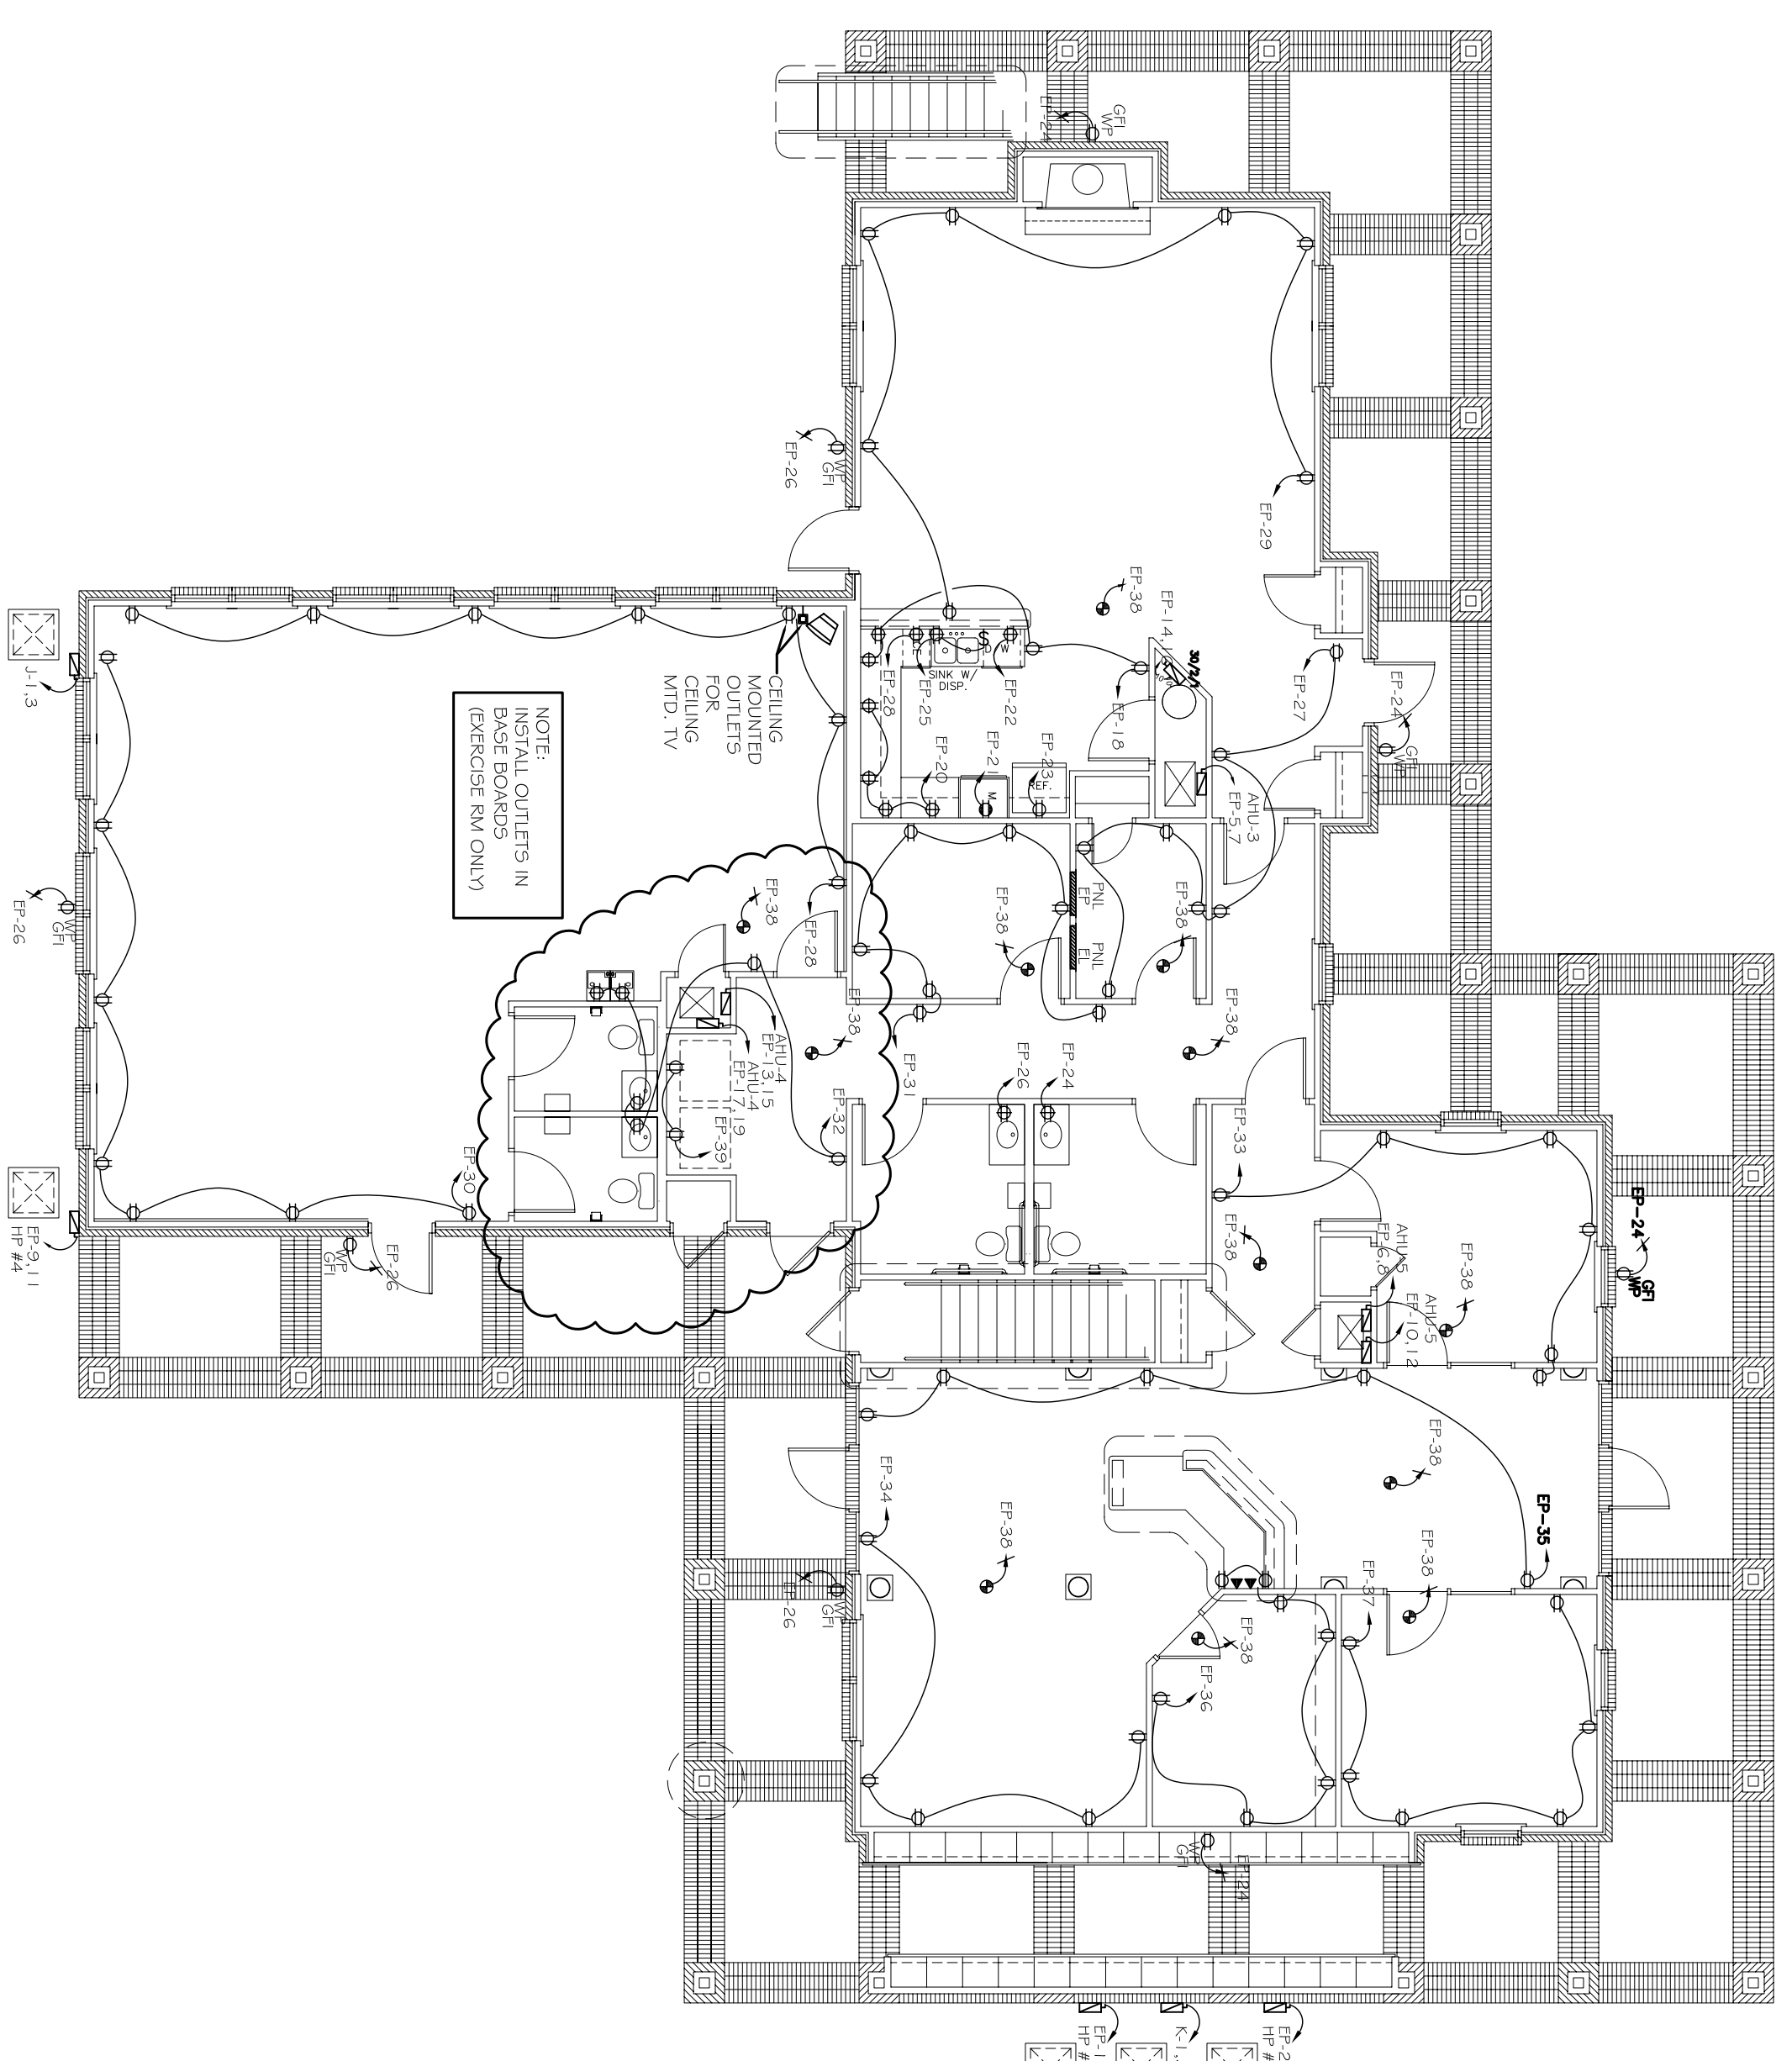

LEASING BLDG. 1ST FLOOR  
ELECTRICAL PLAN  
SCALE: 1/8"=1'-0"

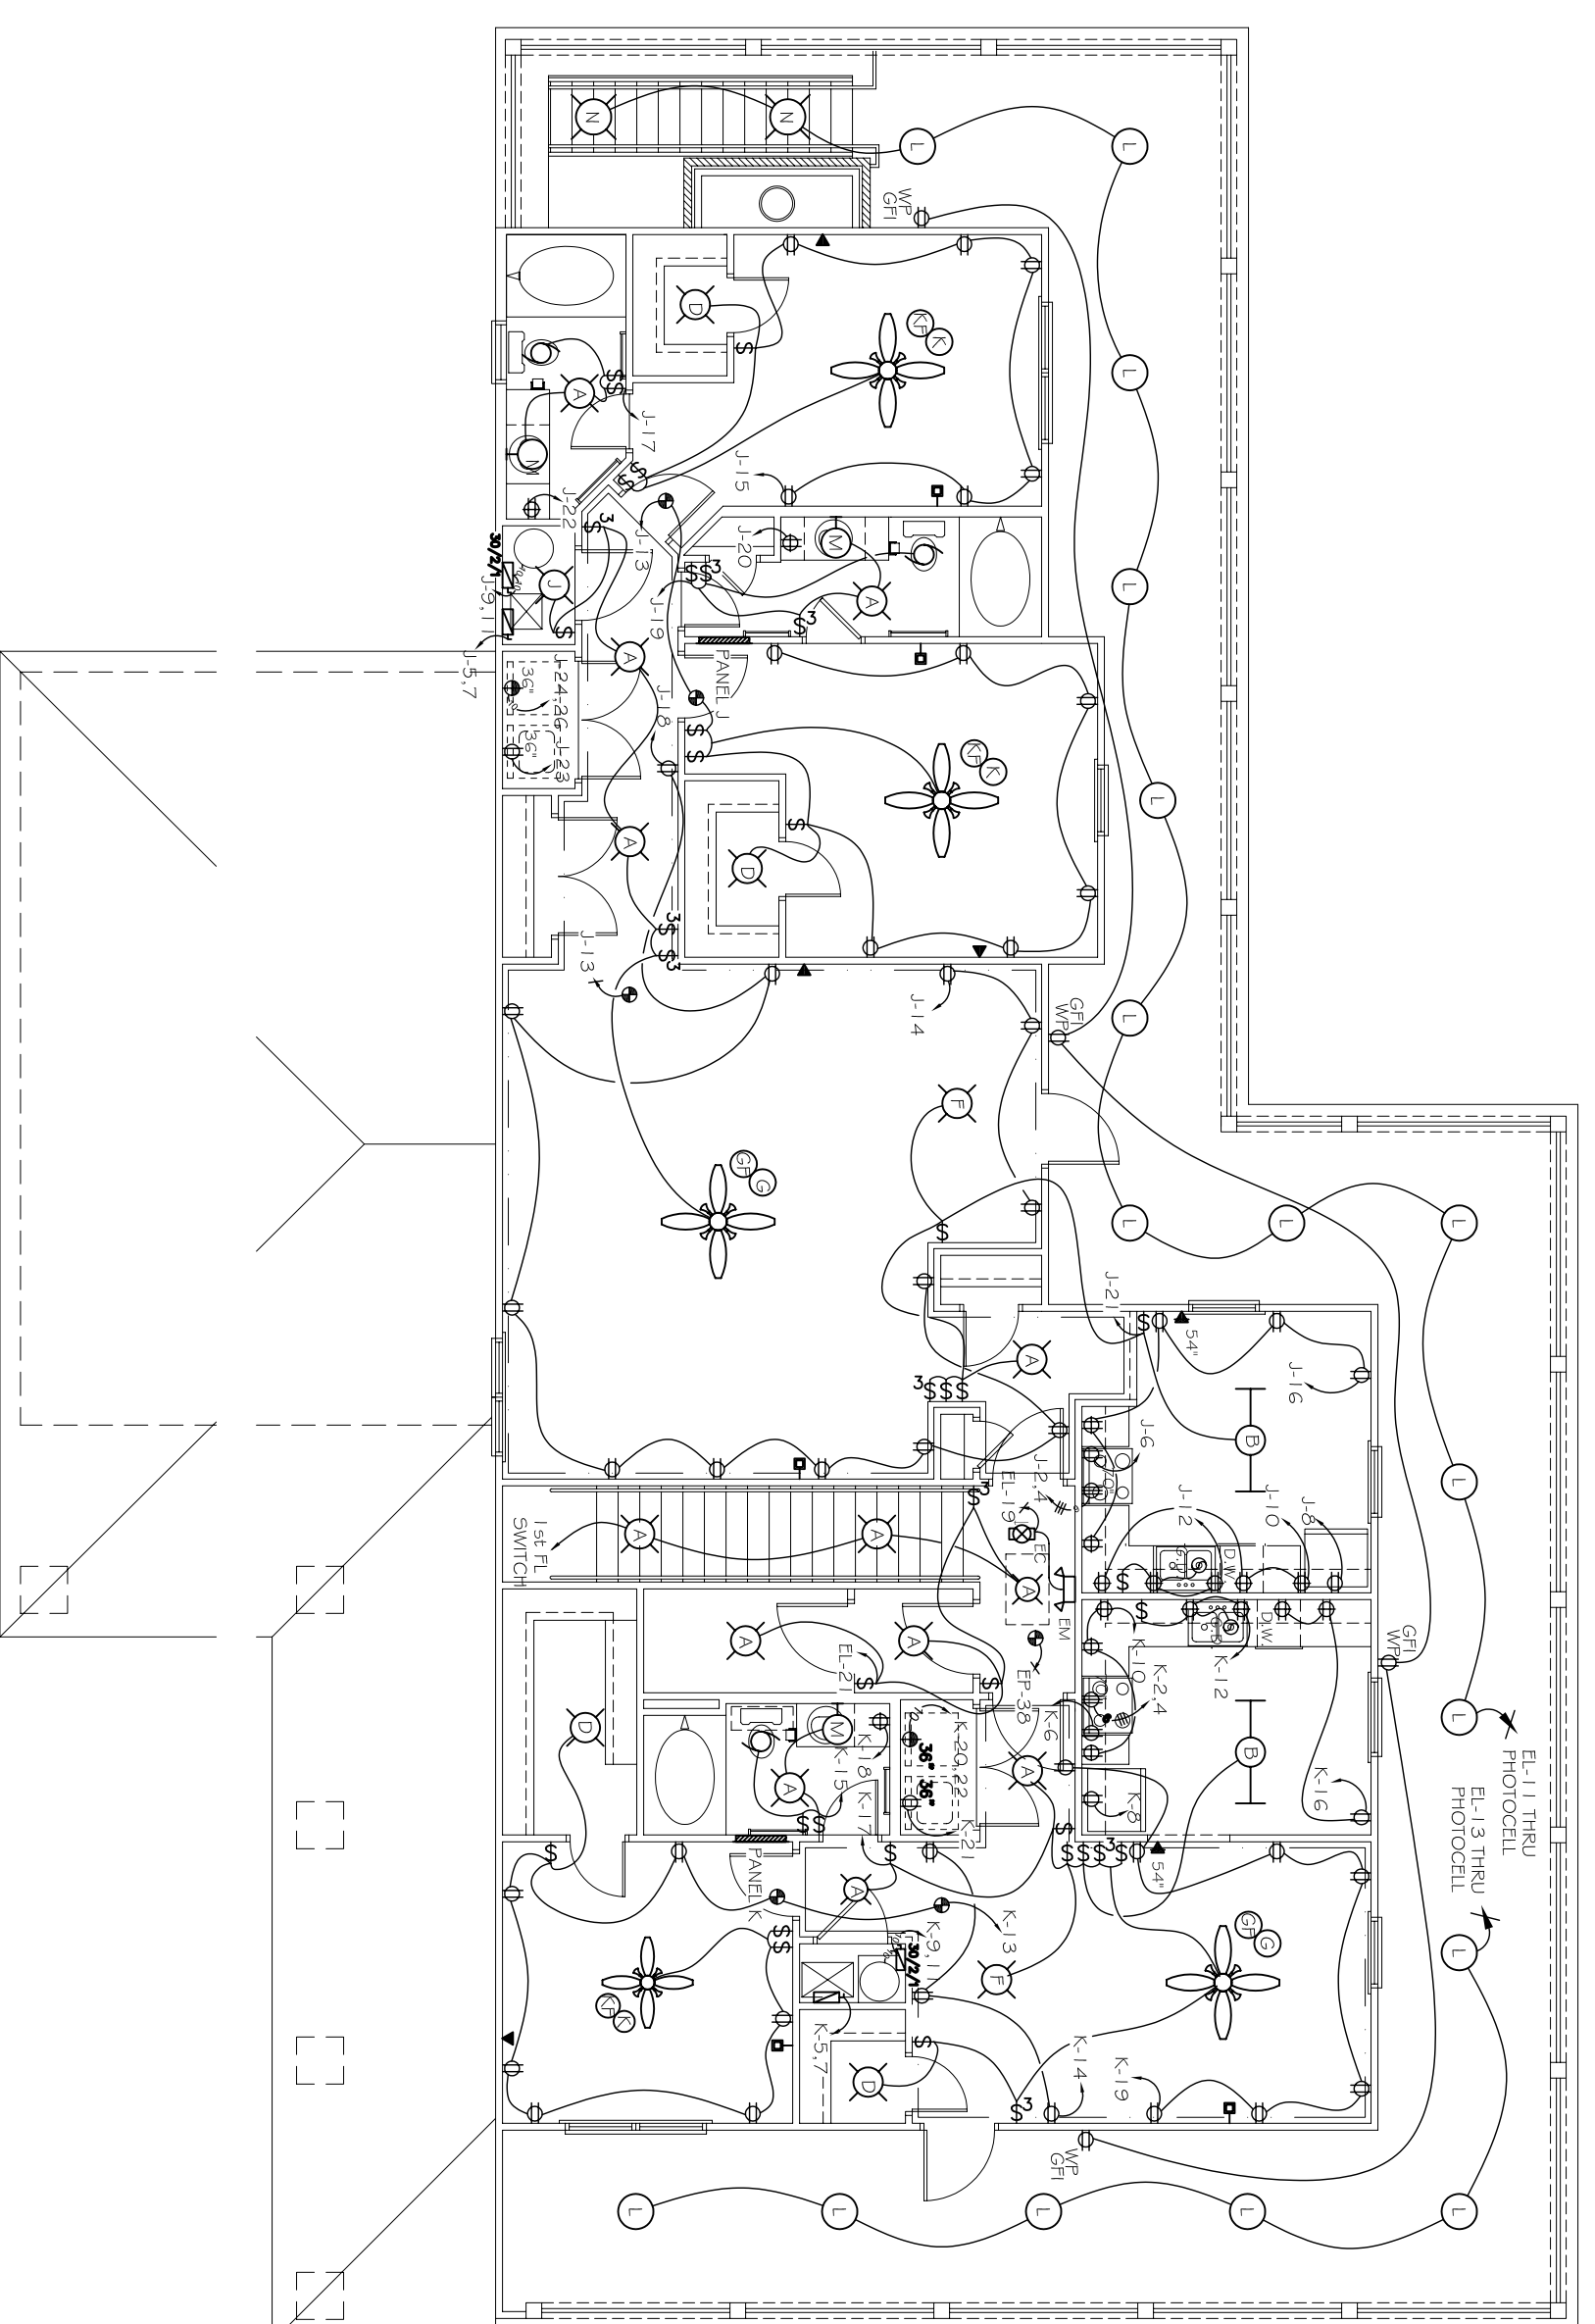

LEASING BLDG. 2ND FLOOR  
ELECTRICAL PLAN  
SCALE: 1/8"=1'-0"

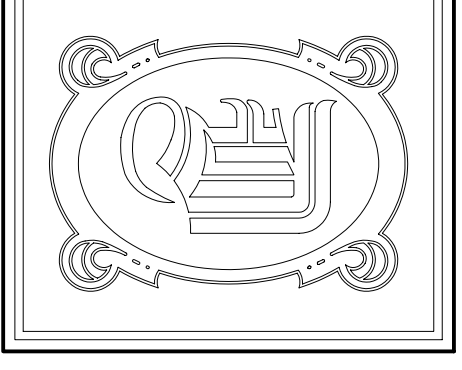

**DAMMON**  
ENGINEERING, INC.

CHIEF ENGINEER  
EMMETT  
DAMMON, F.T.E.  
CHIEF ARCHITECT  
ROBERT  
WILTSE

1095 FLORIDA AVENUE  
SUITE 111, LA. 70438  
OFFICE: 504-641-5892  
FAX: 504-641-5930

WEBSITE:  
WWW.DAMMONENGINEERING.COM  
EMAIL:  
DAMMONENR@BLSBOUTI.NET

ARCHITECTURE  
ENGINEERING  
STUDIES  
PLANNING  
INVESTIGATION  
EXPERT WITNESSES

NEW  
APARTMENT  
COMPLEX

CROSSWINDS  
APARTMENTS  
HAMMOND, LA

LEASING  
BLDG.  
ELECTRICAL  
PLAN

REV: 2-19-10  
2-24-10  
SCALE: AS NOTED  
JOB# 08112113  
DATE: 12-16-09  
SHEET

E-7

OF