




BLDGS. 1, 2, 5 & 6  
OVERALL MECHANICAL PLAN  
SCALE: 1/8" = 1'-0"

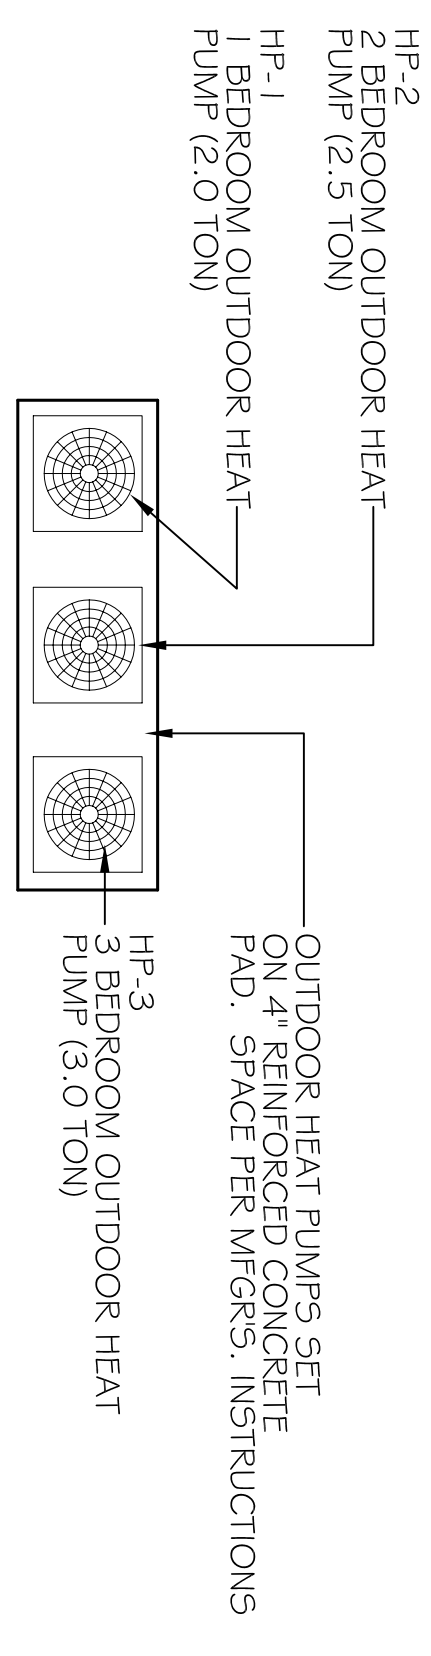

APARTMENTS HEAT PUMPS LAYOUT  
SCALE: NTS

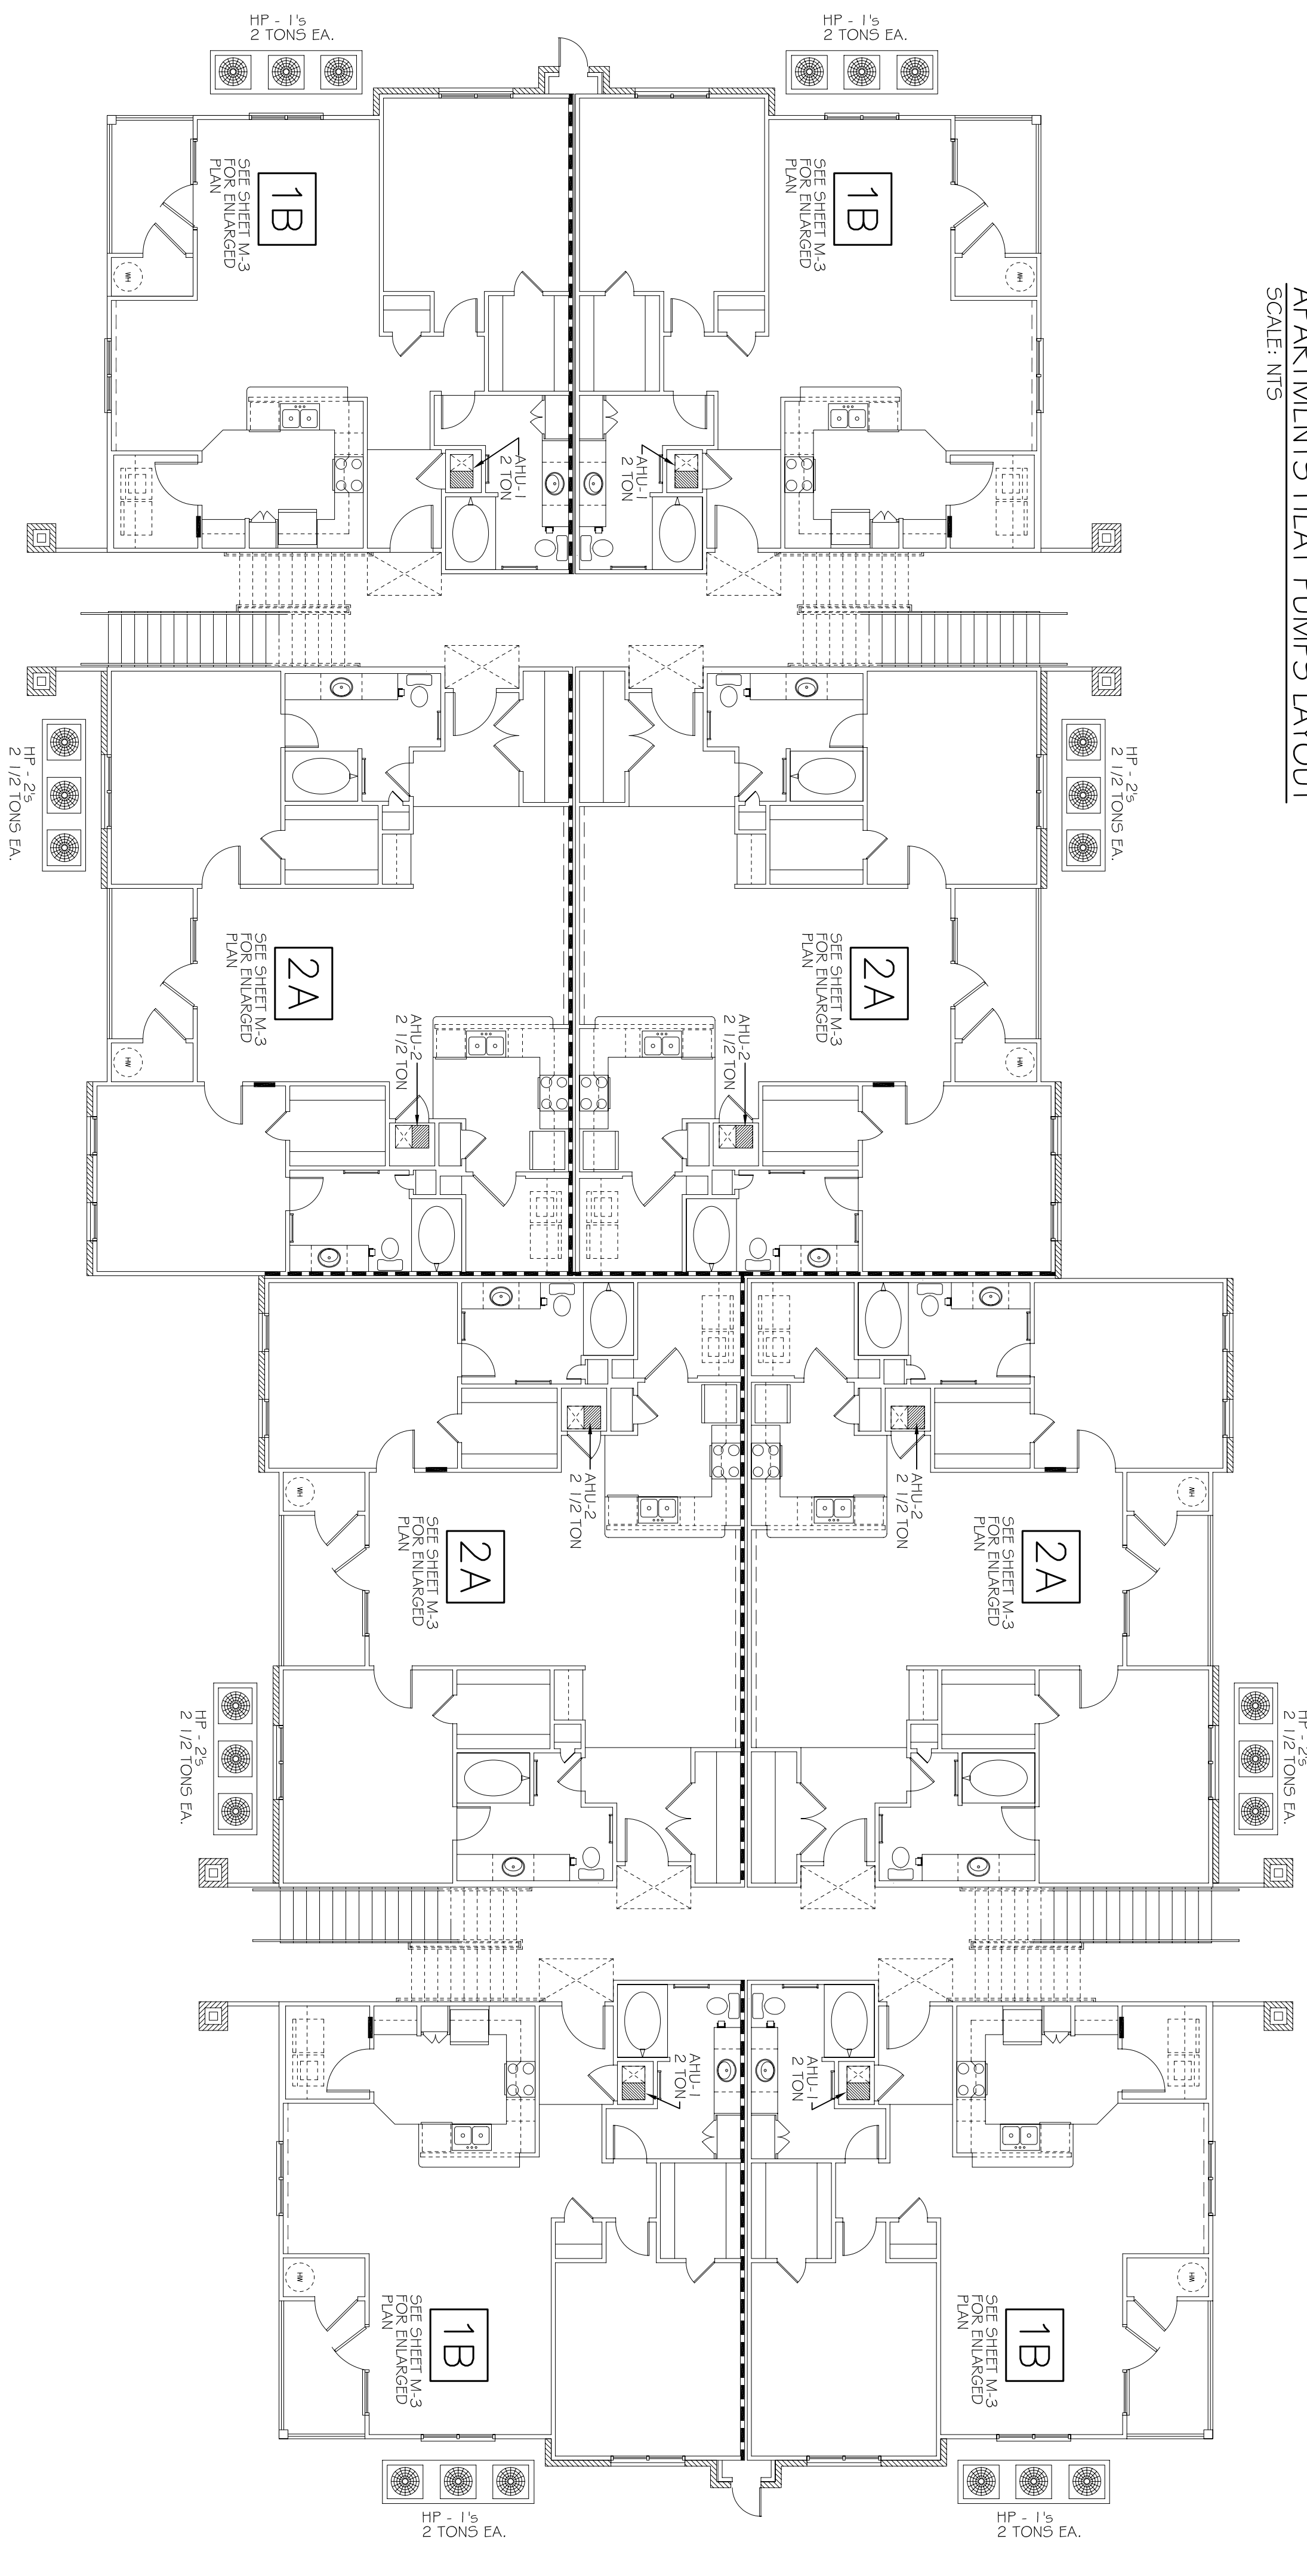


BLDG. 3  
OVERALL MECHANICAL PLAN  
SCALE: 1/8" = 1'-0"

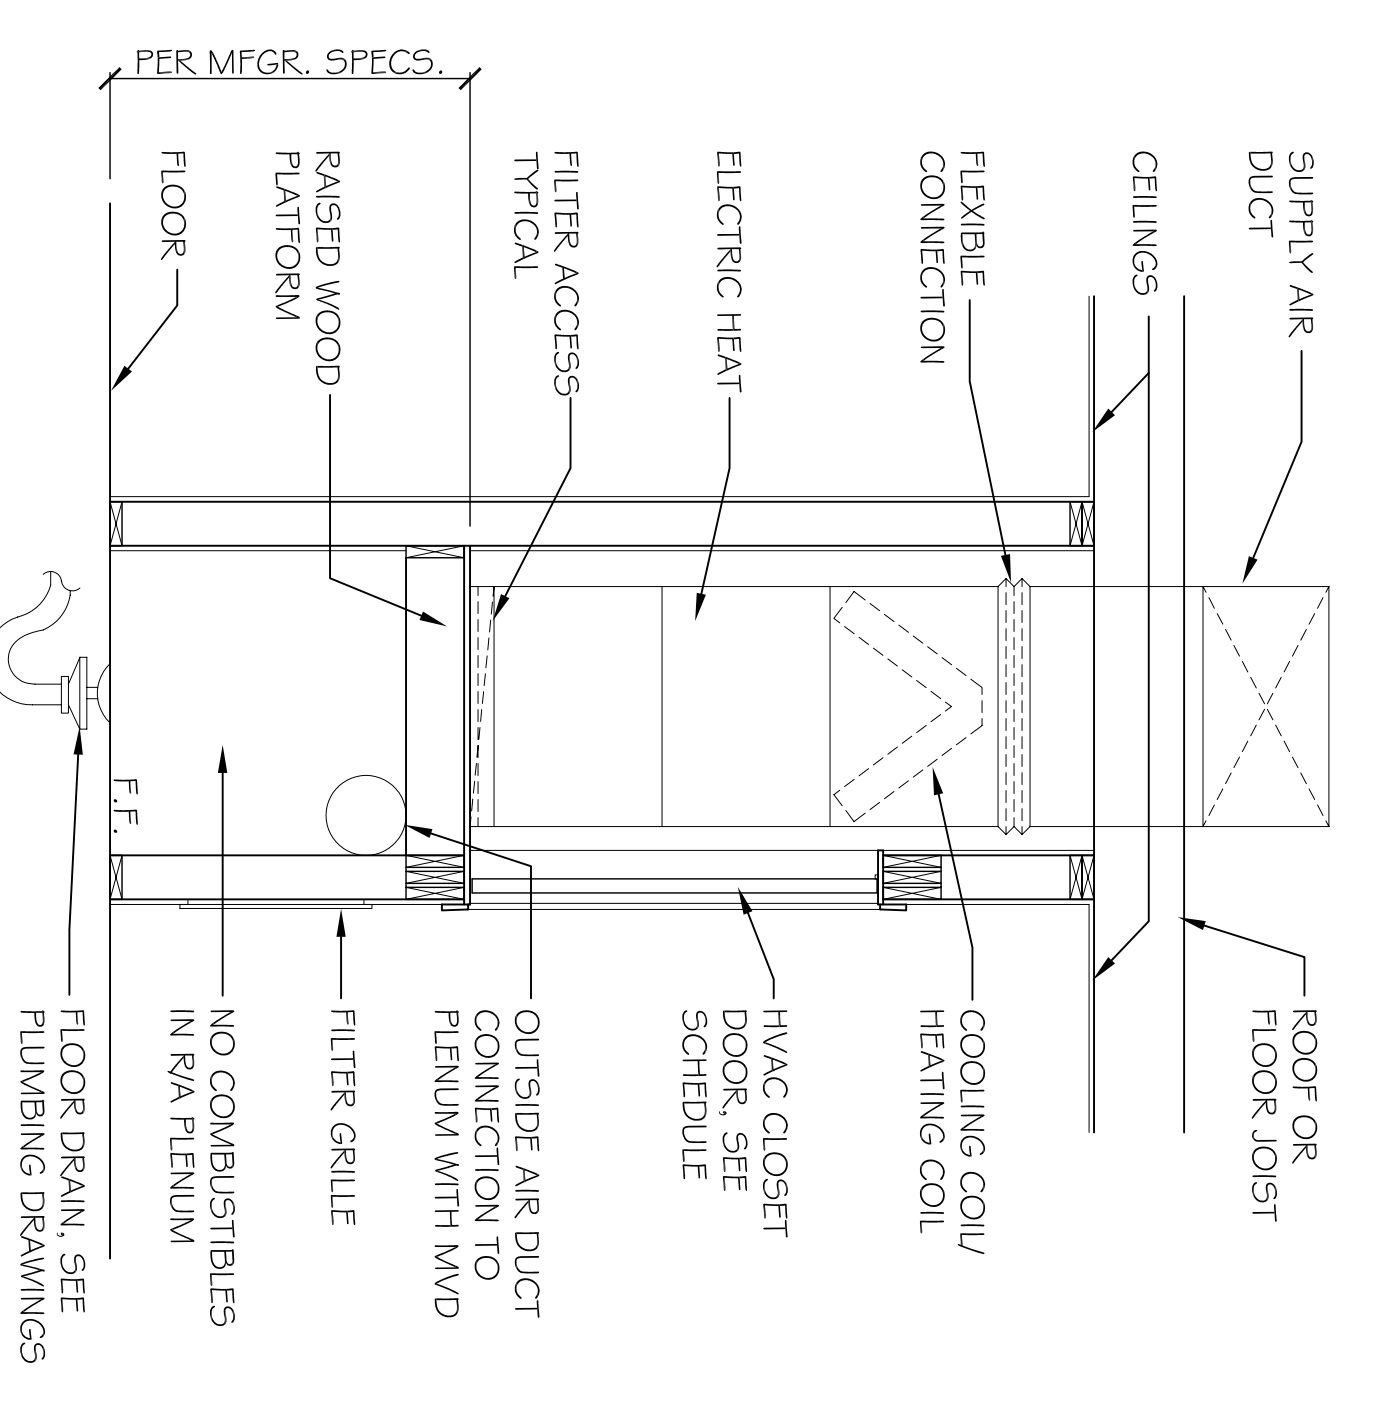


HVAC AHU/CLOSET SECTION  
SCALE: NTS

- NOTES:
1. ON UNITS UNDER 5 TONS, PROVIDE FIRESTAY IN THE RETURN AIR WIRE TO SHUT DOWN THE UNIT WHEN TEMPERATURE IS EXCEEDED.
  2. ON UNITS 5 TONS OR LARGER, PROVIDE A SMOKE DETECTOR IN THE SUPPLY AND THE RETURN AIR DUCTS WIRE TO SHUT DOWN THE UNIT WHEN SMOKE IS DETECTED. THE SMOKE DETECTOR IN THE RETURN AIR MAY BE ELIMINATED IF CONTRACTOR RECEIVES APPROVAL FROM THE LOCAL AUTHORITY HAVING JURISDICTION.

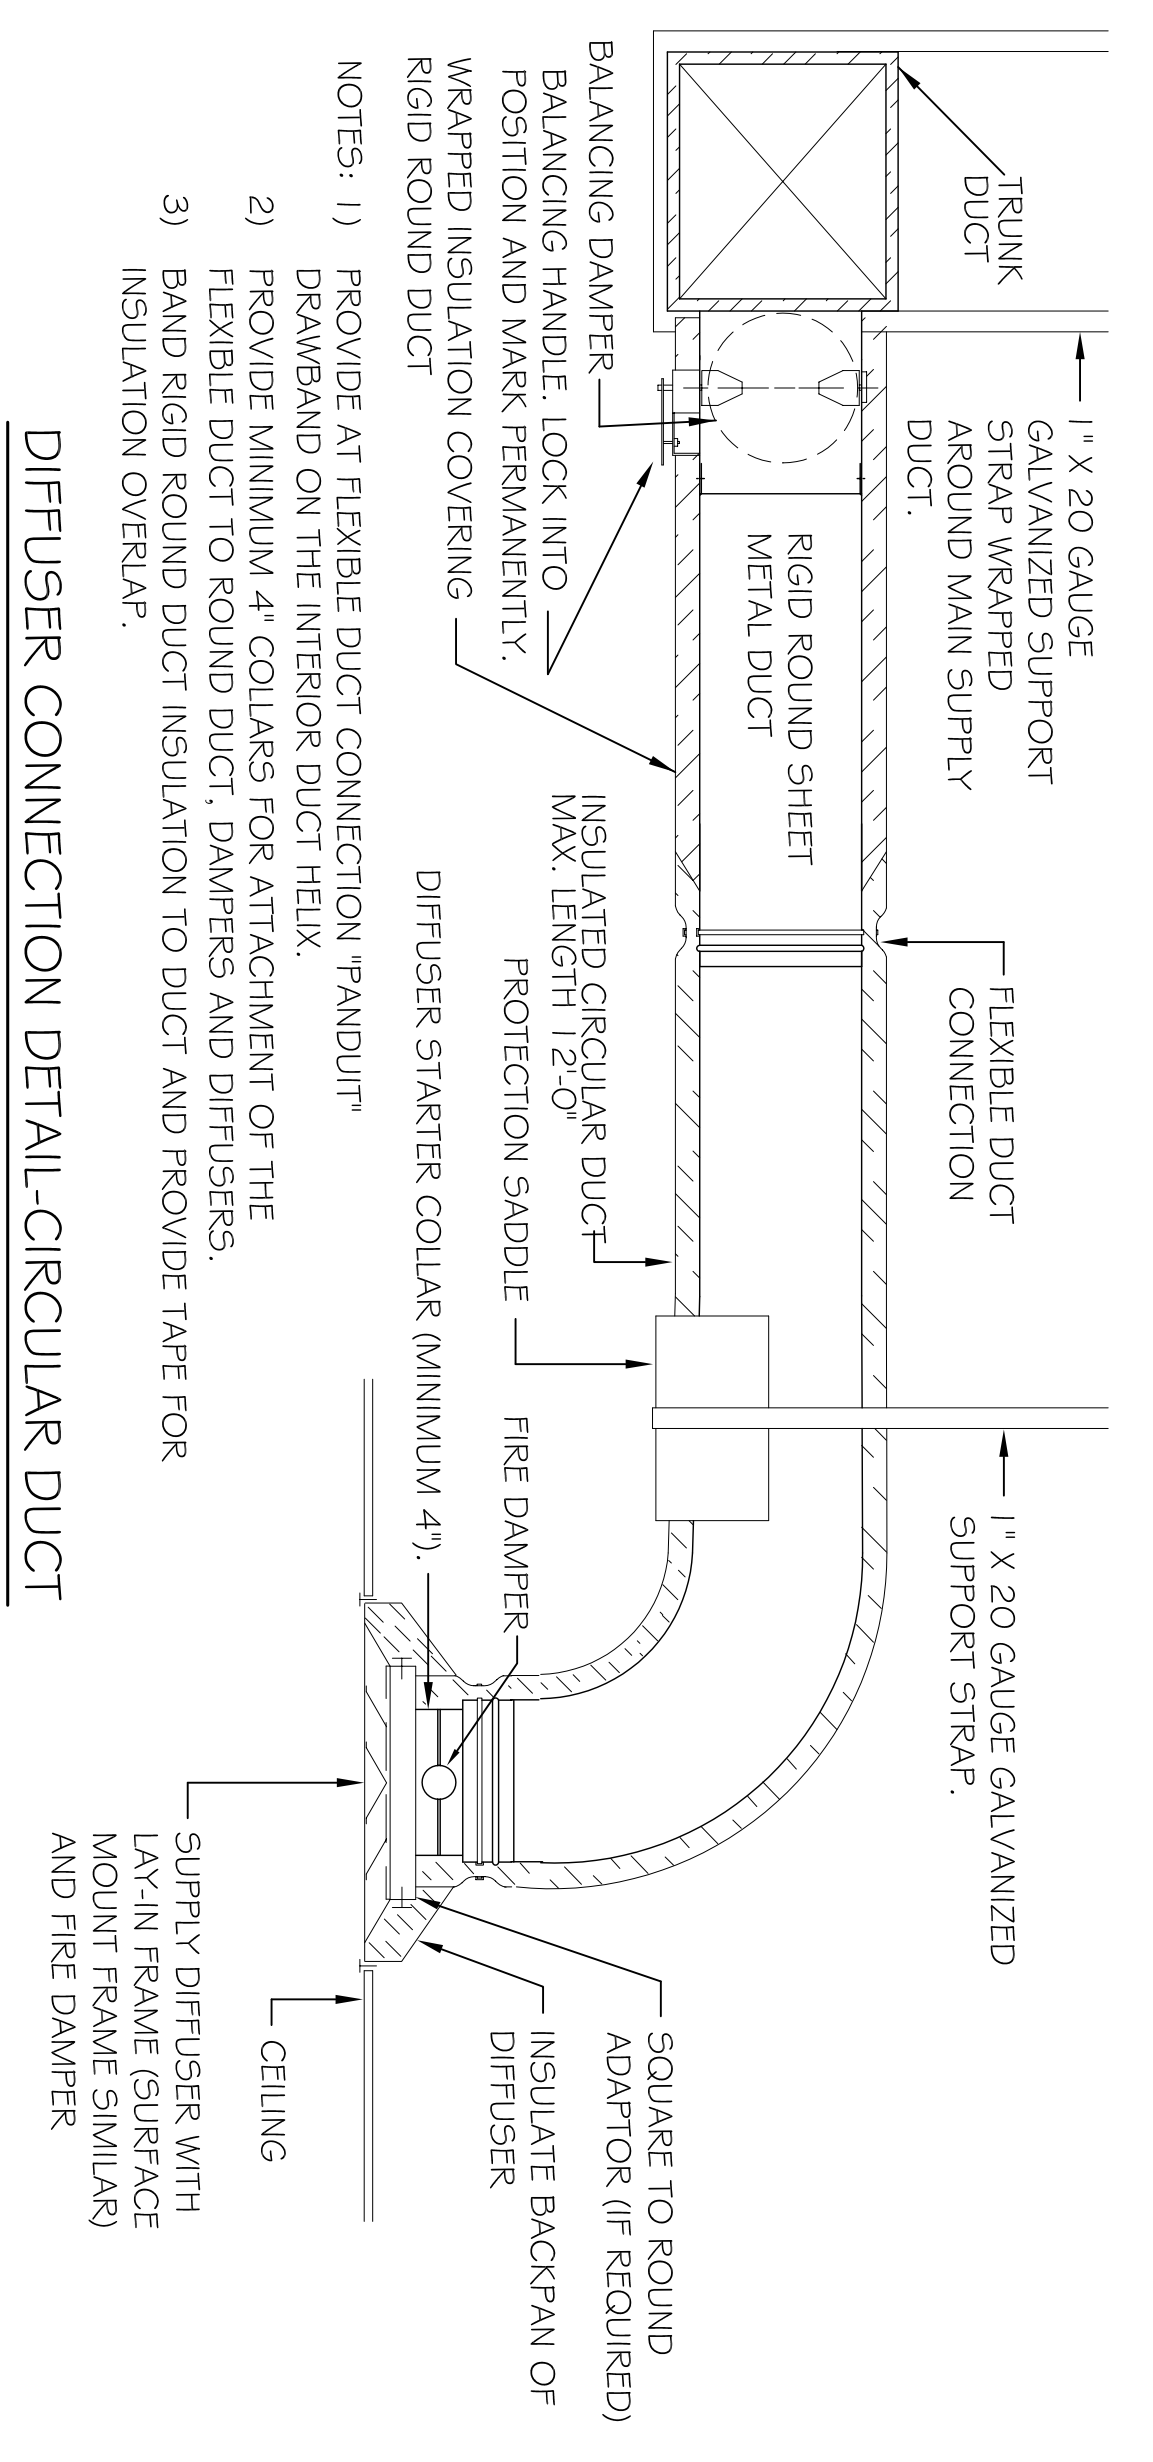

DIFFUSER CONNECTION DETAIL-CIRCULAR DUCT  
SCALE: NTS (AT RATED CEILING)

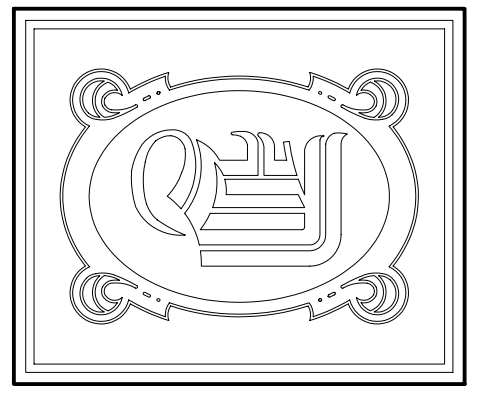

**DAMMON**  
ENGINEERING, INC.

CHIEF ENGINEER  
DAMON, F.E.  
CHIEF ARCHITECT  
ROBERT WILTSE

1095 FLORIDA AVENUE  
SUITE 111, LA. 70455  
OFFICE: 504-649-5682  
FAX: 504-641-5930

WWW.DAMMONENGINEERING.COM  
EMAIL: DAMON@BELLFLOWER.NET  
DAMON@BELLFLOWER.NET

ARCHITECTURE  
ENGINEERING  
STUDIES  
PLANNING  
INVESTIGATION  
EXPERT WITNESS

NEW  
APARTMENT  
COMPLEX

CROSSWINDS  
APARTMENTS  
HAMMOND, LA

BLDGS. 1, 2, 3, 5,  
& 6 OVERALL  
MECHANICAL  
PLANS & DETAILS

REV:	
SCALE:	AS NOTED
JOB#:	08112.13
DATE:	12-16-09
SHEET	

M-2