



ONE BEDROOM
UNIT 1A MECHANICAL PLAN
SCALE: 3/4"=1'-0"
921 SQ. FT.

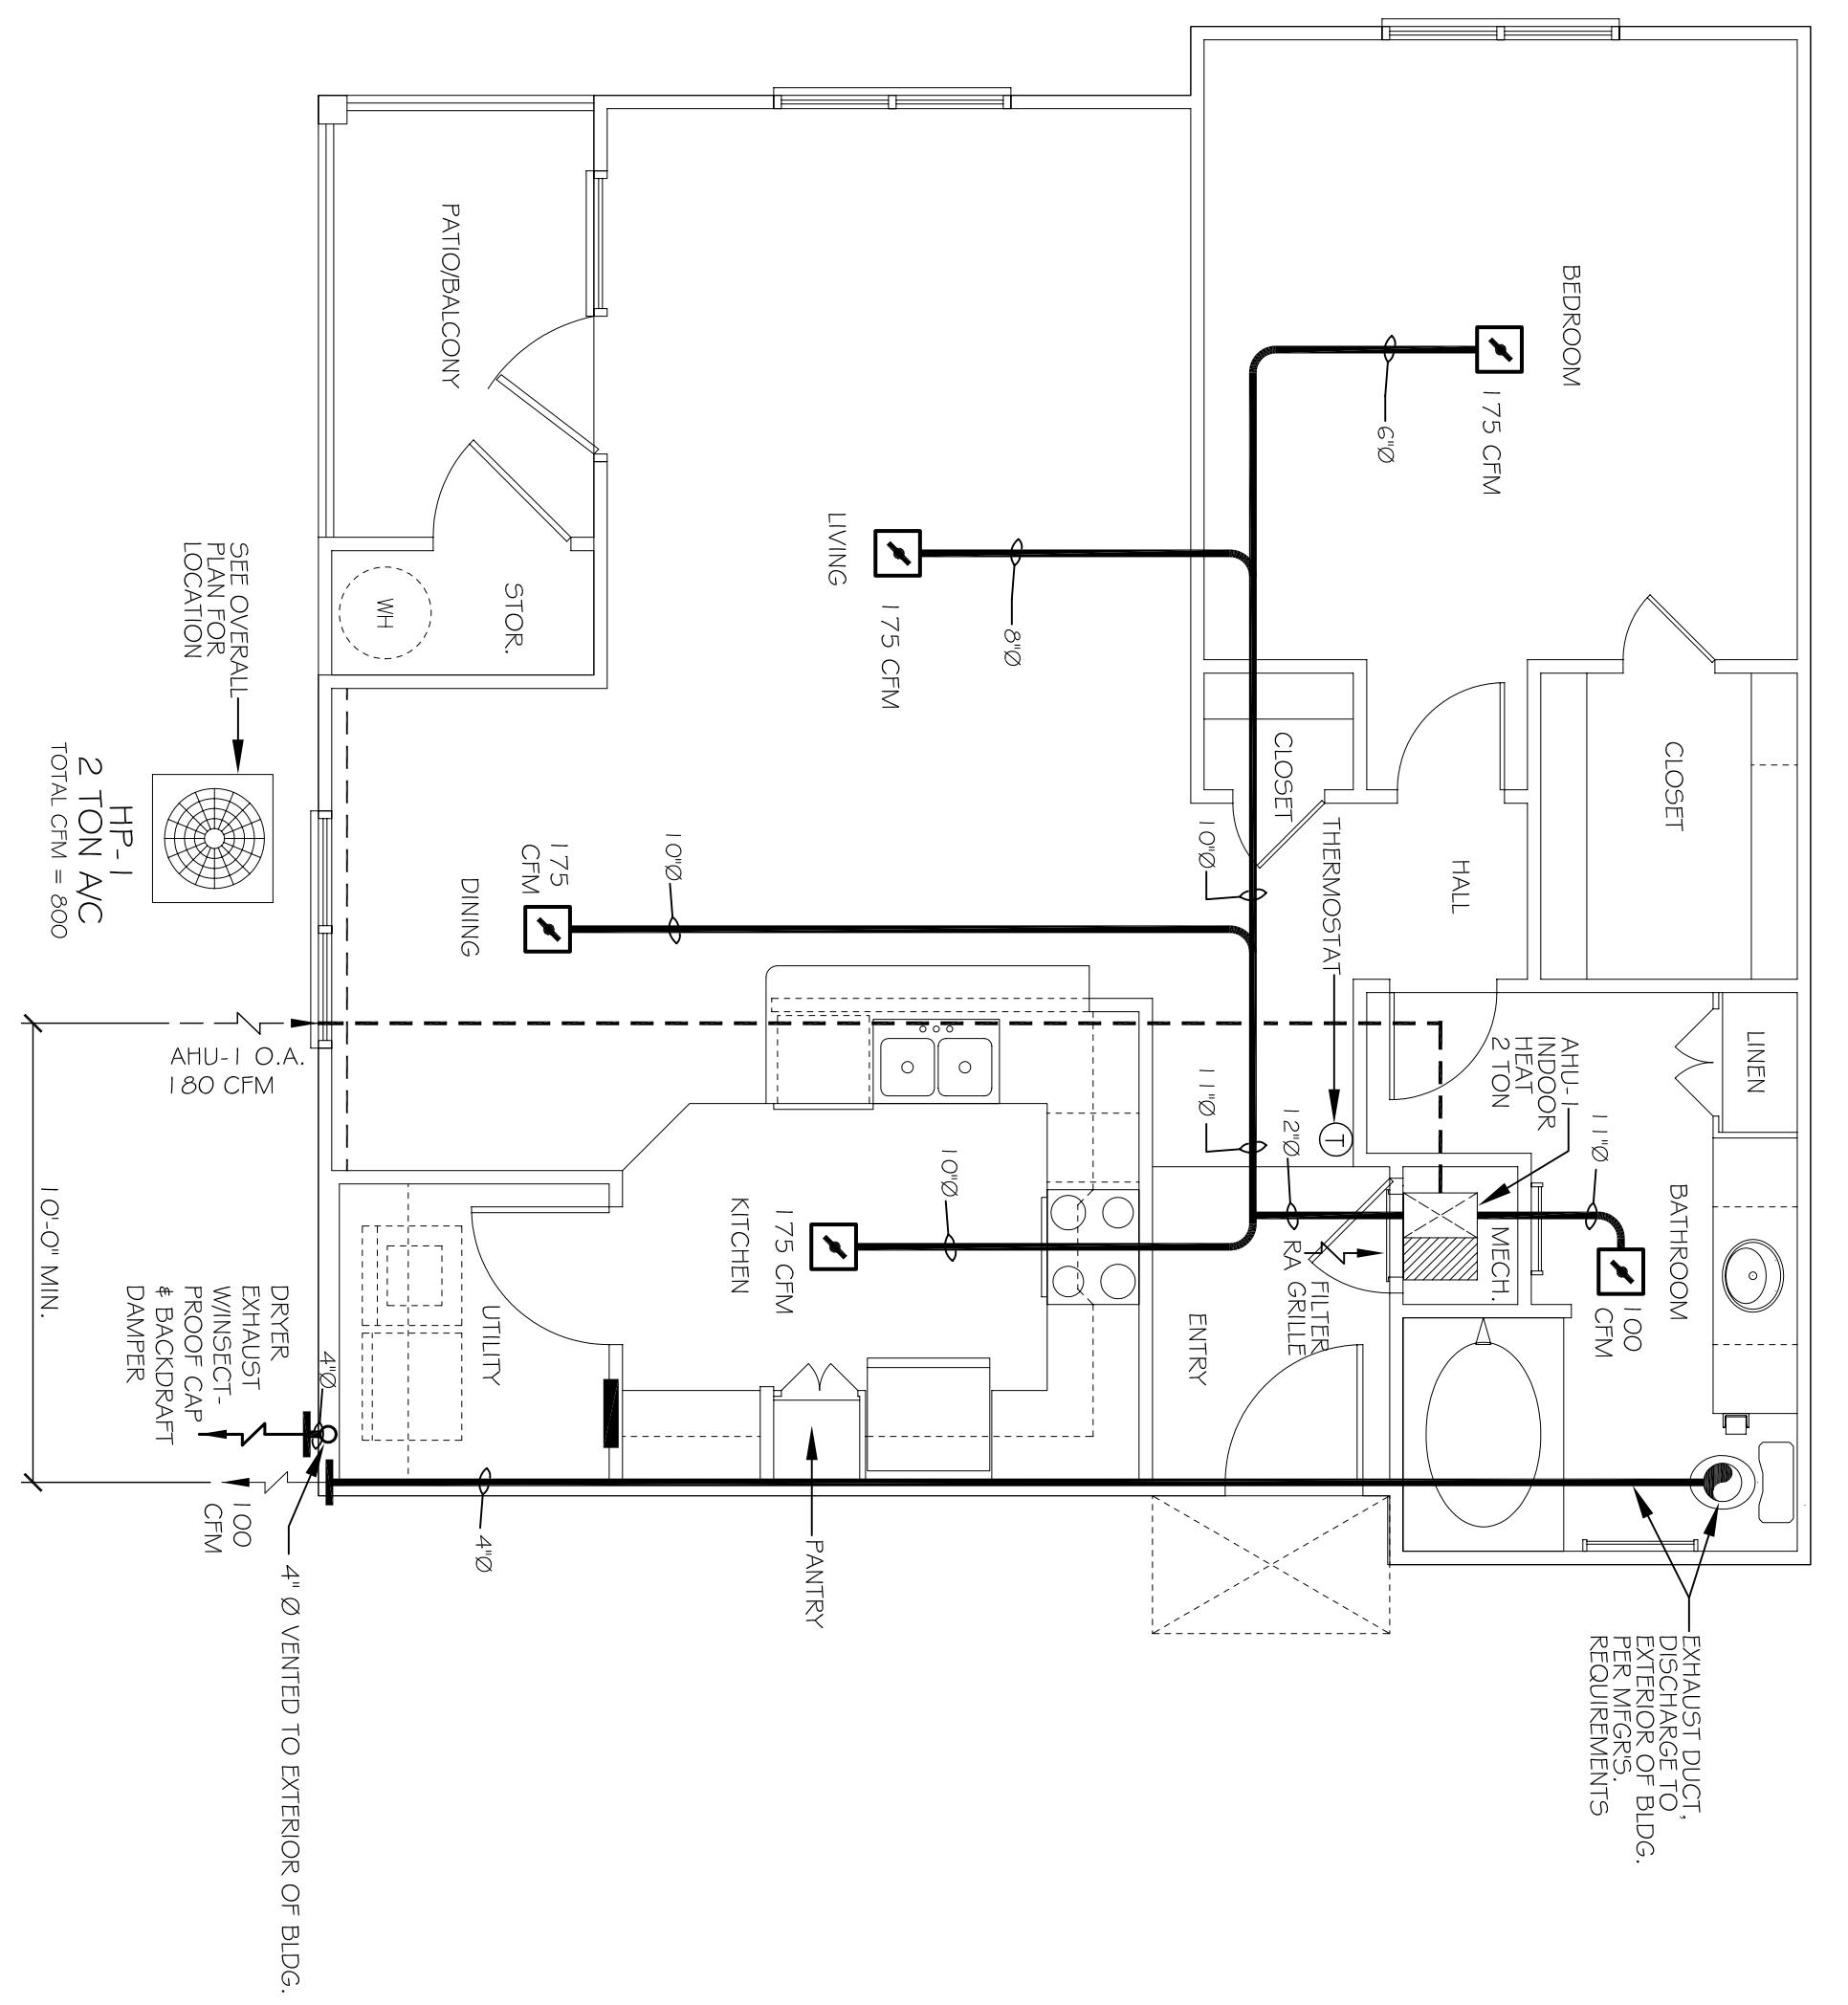


ONE BEDROOM
UNIT 1B MECHANICAL PLAN
SCALE: 3/4"=1'-0"
968 SQ. FT.


- LEGEND**
- ☐ SUPPLY AIR VENT WITH FIRE DAMPER.
 - RETURN AIR GRILLE WALL MOUNTED SEE PLAN FOR EXACT LOCATION
 - BATHROOM EXHAUST
 - ⊖ THERMOSTAT
 - ⌈ FILTER GRILLE SA

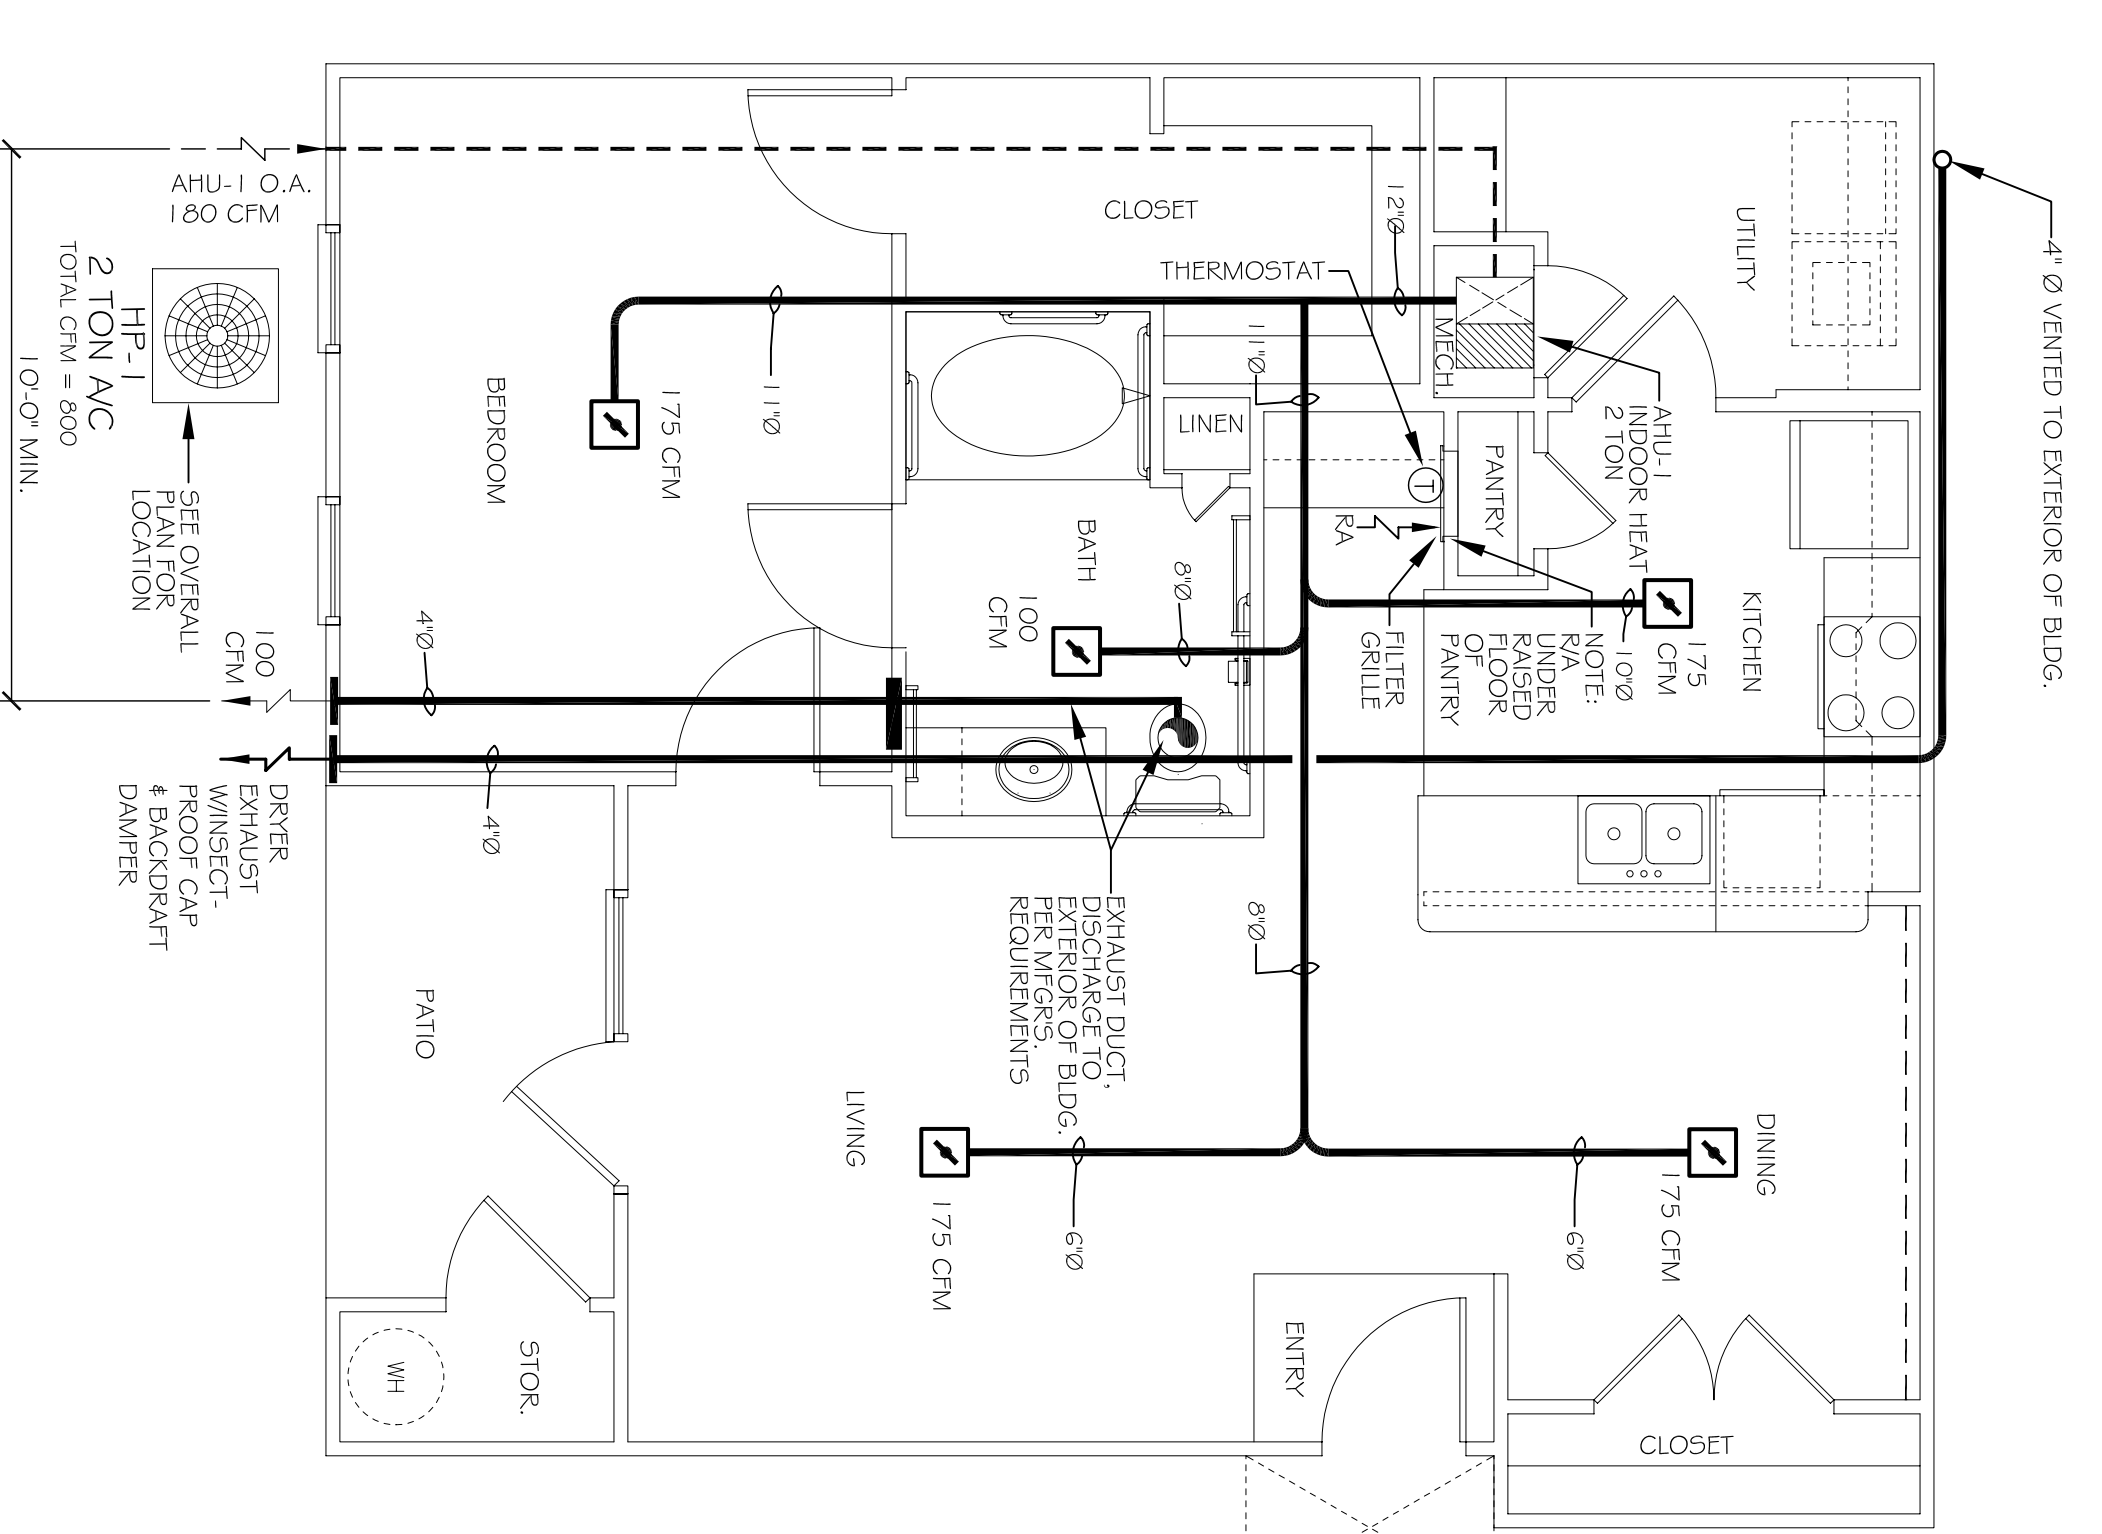

ONE BEDROOM (HANDICAP)
UNIT 1A-HC MECHANICAL PLAN
SCALE: 3/4"=1'-0"
921 SQ. FT.

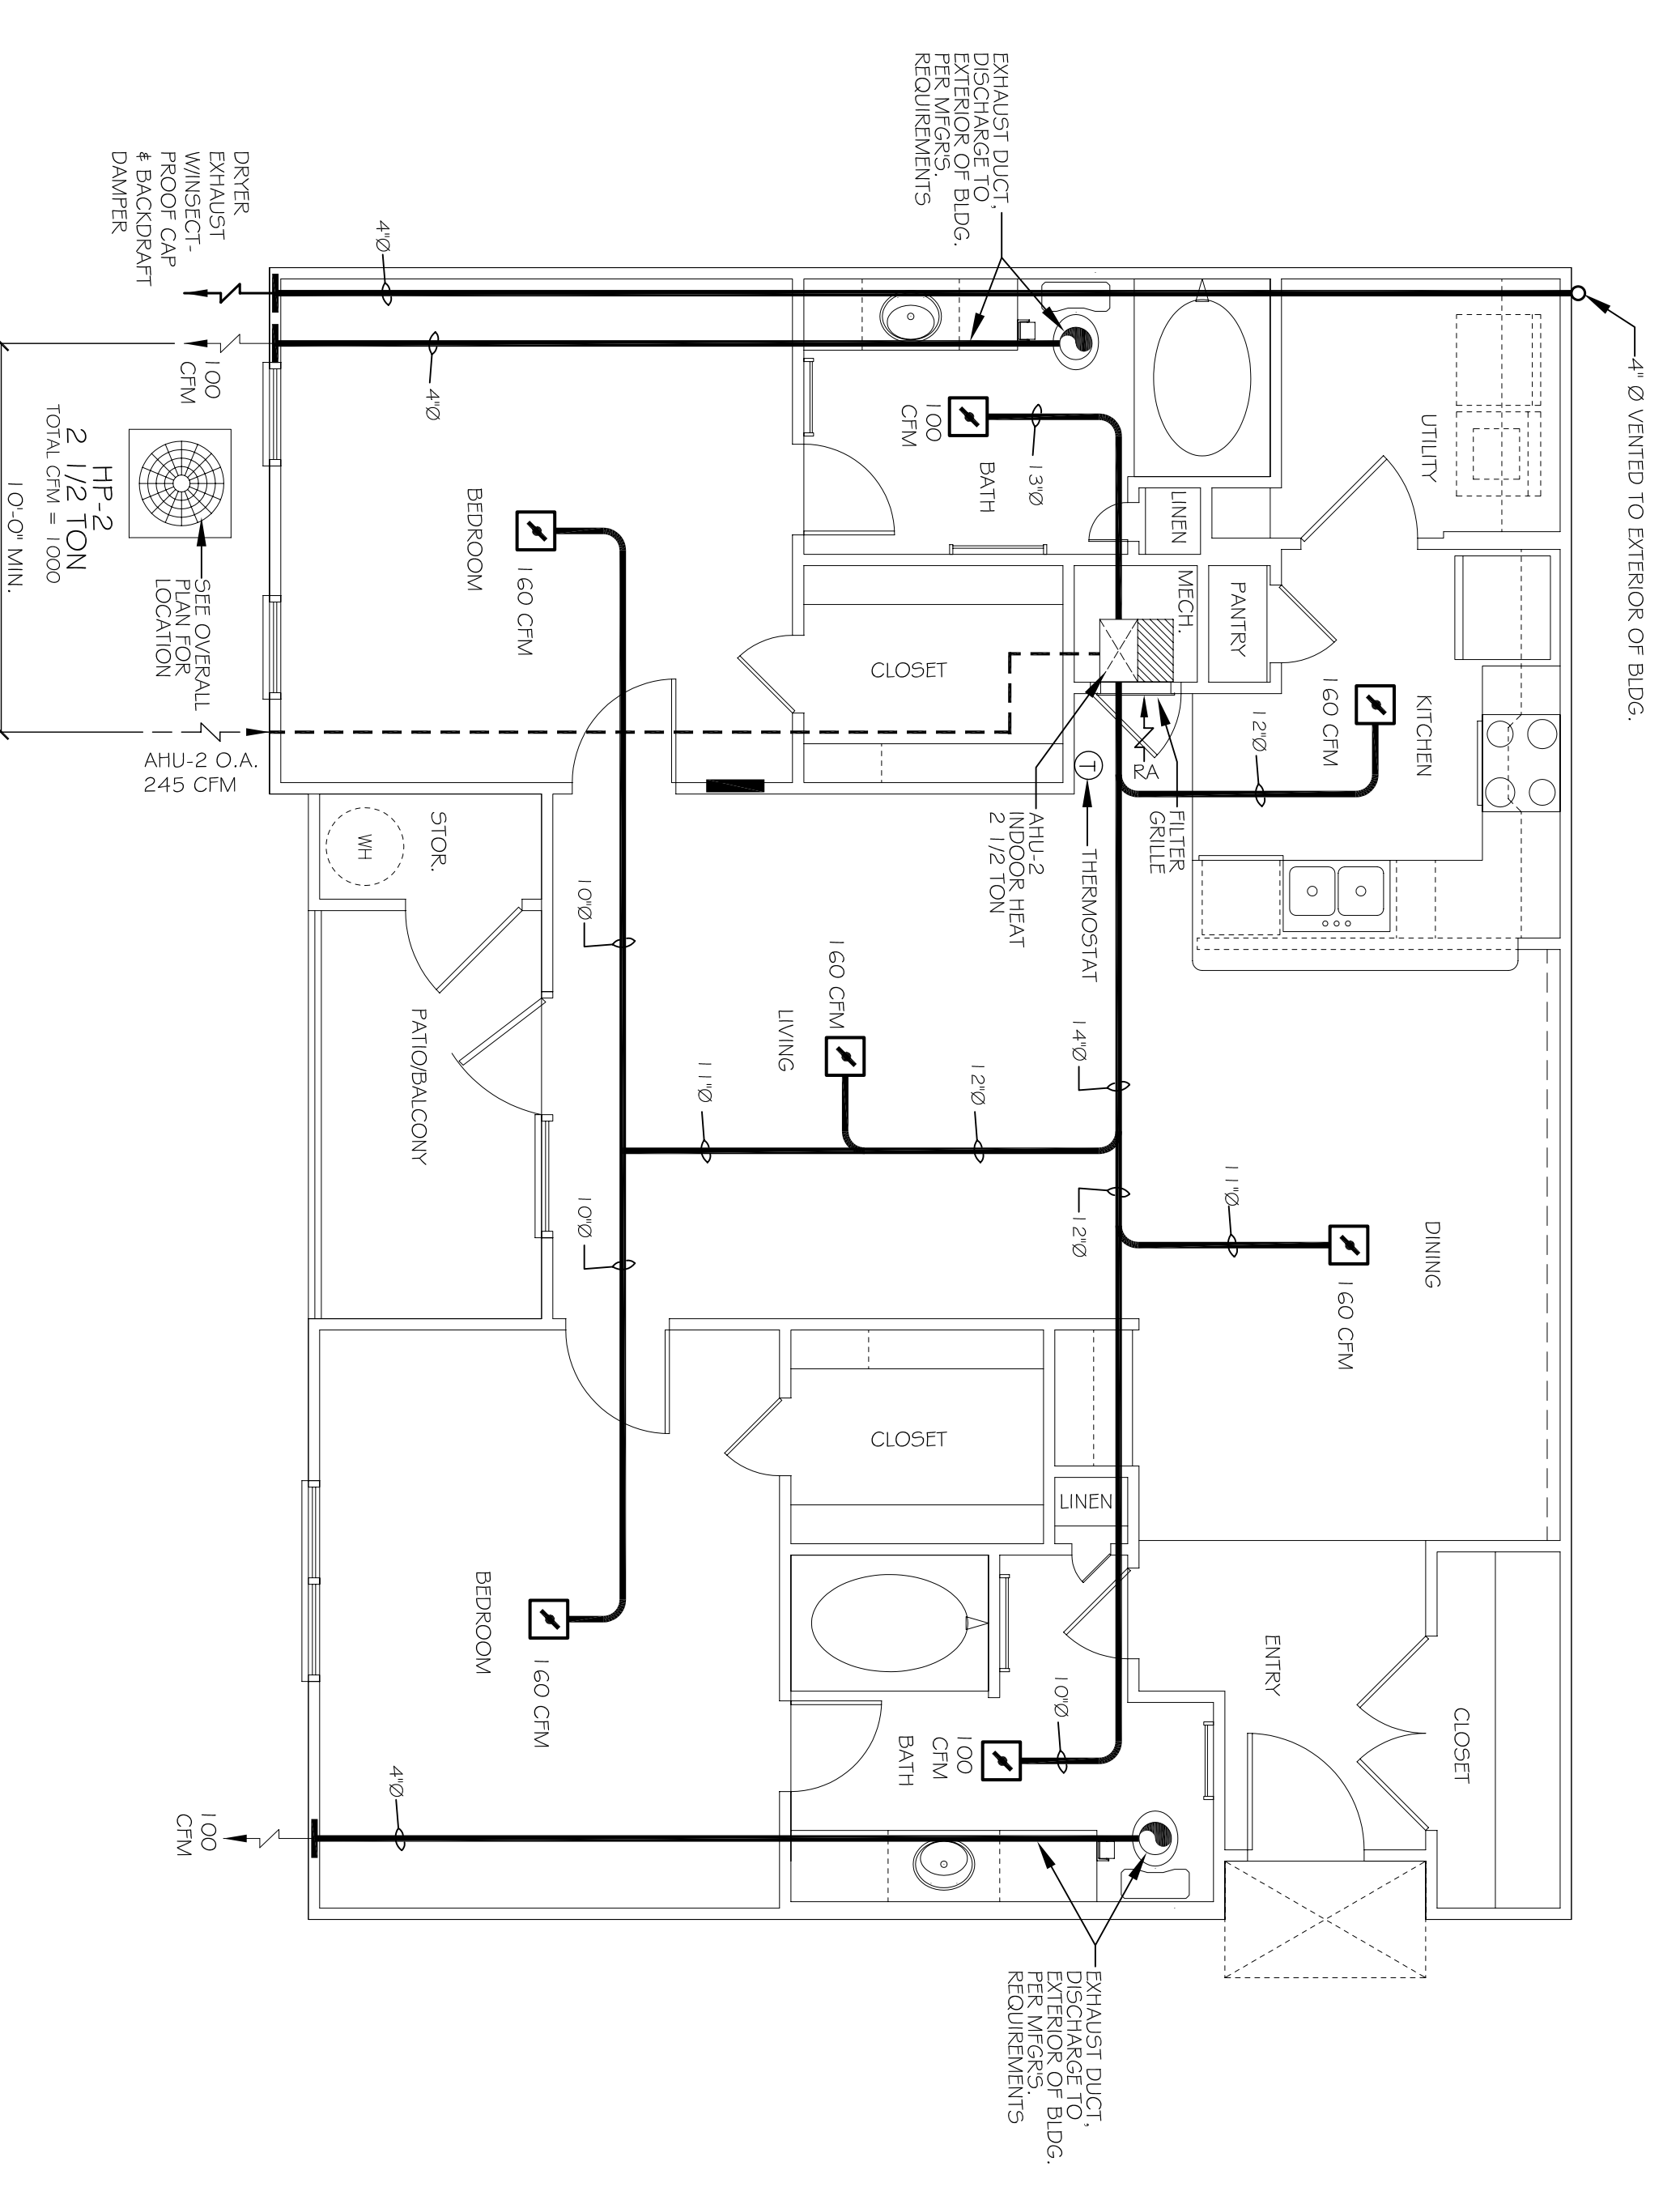

TWO BEDROOM
UNIT 2A MECHANICAL PLAN
SCALE: 3/4"=1'-0"
1,324 SQ. FT.

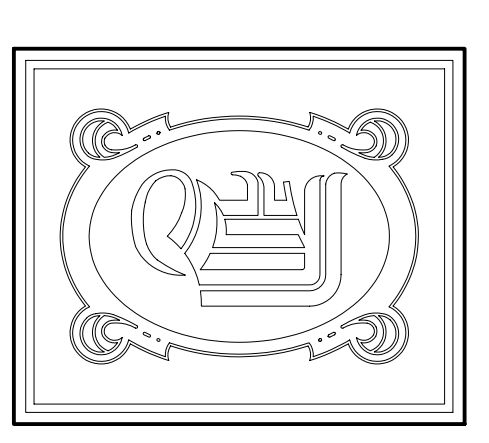

DAMMON
ENGINEERING, INC.

CHIEF ENGINEER
DAMON, F. E.
CHIEF ARCHITECT
ROBERT WILTSE

1095 FLORIDA AVENUE
SUITE 11, 70435
OFFICE 925-649-5892
FAX: 925-641-5930

WWW.DAMMONENGINEERING.COM
EMAIL: DAMON@DELLSOFT.NET
DAMMON@DELLSOFT.NET

ARCHITECTURE
ENGINEERING
STUDIES
PLANNING
INVESTIGATION
EXPERT WITNESS

NEW
APARTMENT
COMPLEX

CROSSWINDS
APARTMENTS
HAMMOND, LA

UNITS 1A,
1A-HC, 1B & 2A
MECHANICAL PLAN

REV:
SCALE: AS NOTED
JOB#: 08112.13
DATE: 12-16-09
SHEET