

DAMMON
ENGINEERING, INC.

CHIEF ENGINEER
EMMETT
DAMMON, F.T.E.
CHIEF ARCHITECT
ROBERT
WILTSE

1095 FLORIDA AVENUE
SLIDELL, LA. 70458
OFFICE: 984-9582
FAX: 984-1-5930

WWW.DAMMONENGINEERING.COM
DMAIL: DAMMONENR@BELLFLOWER.NET

ARCHITECTURE
ENGINEERING
STUDIES
PLANNING
INVESTIGATION
EXPERT WITNESS

NEW
APARTMENT
COMPLEX

CROSSWINDS
APARTMENTS
HAMMOND, LA

UNITS 2A-HC,
3A & 3A-HC
MECHANICAL PLAN

REV:


SCALE: AS NOTED

JOB#: 08112.13

DATE: 12-16-09


SHEET

M-4

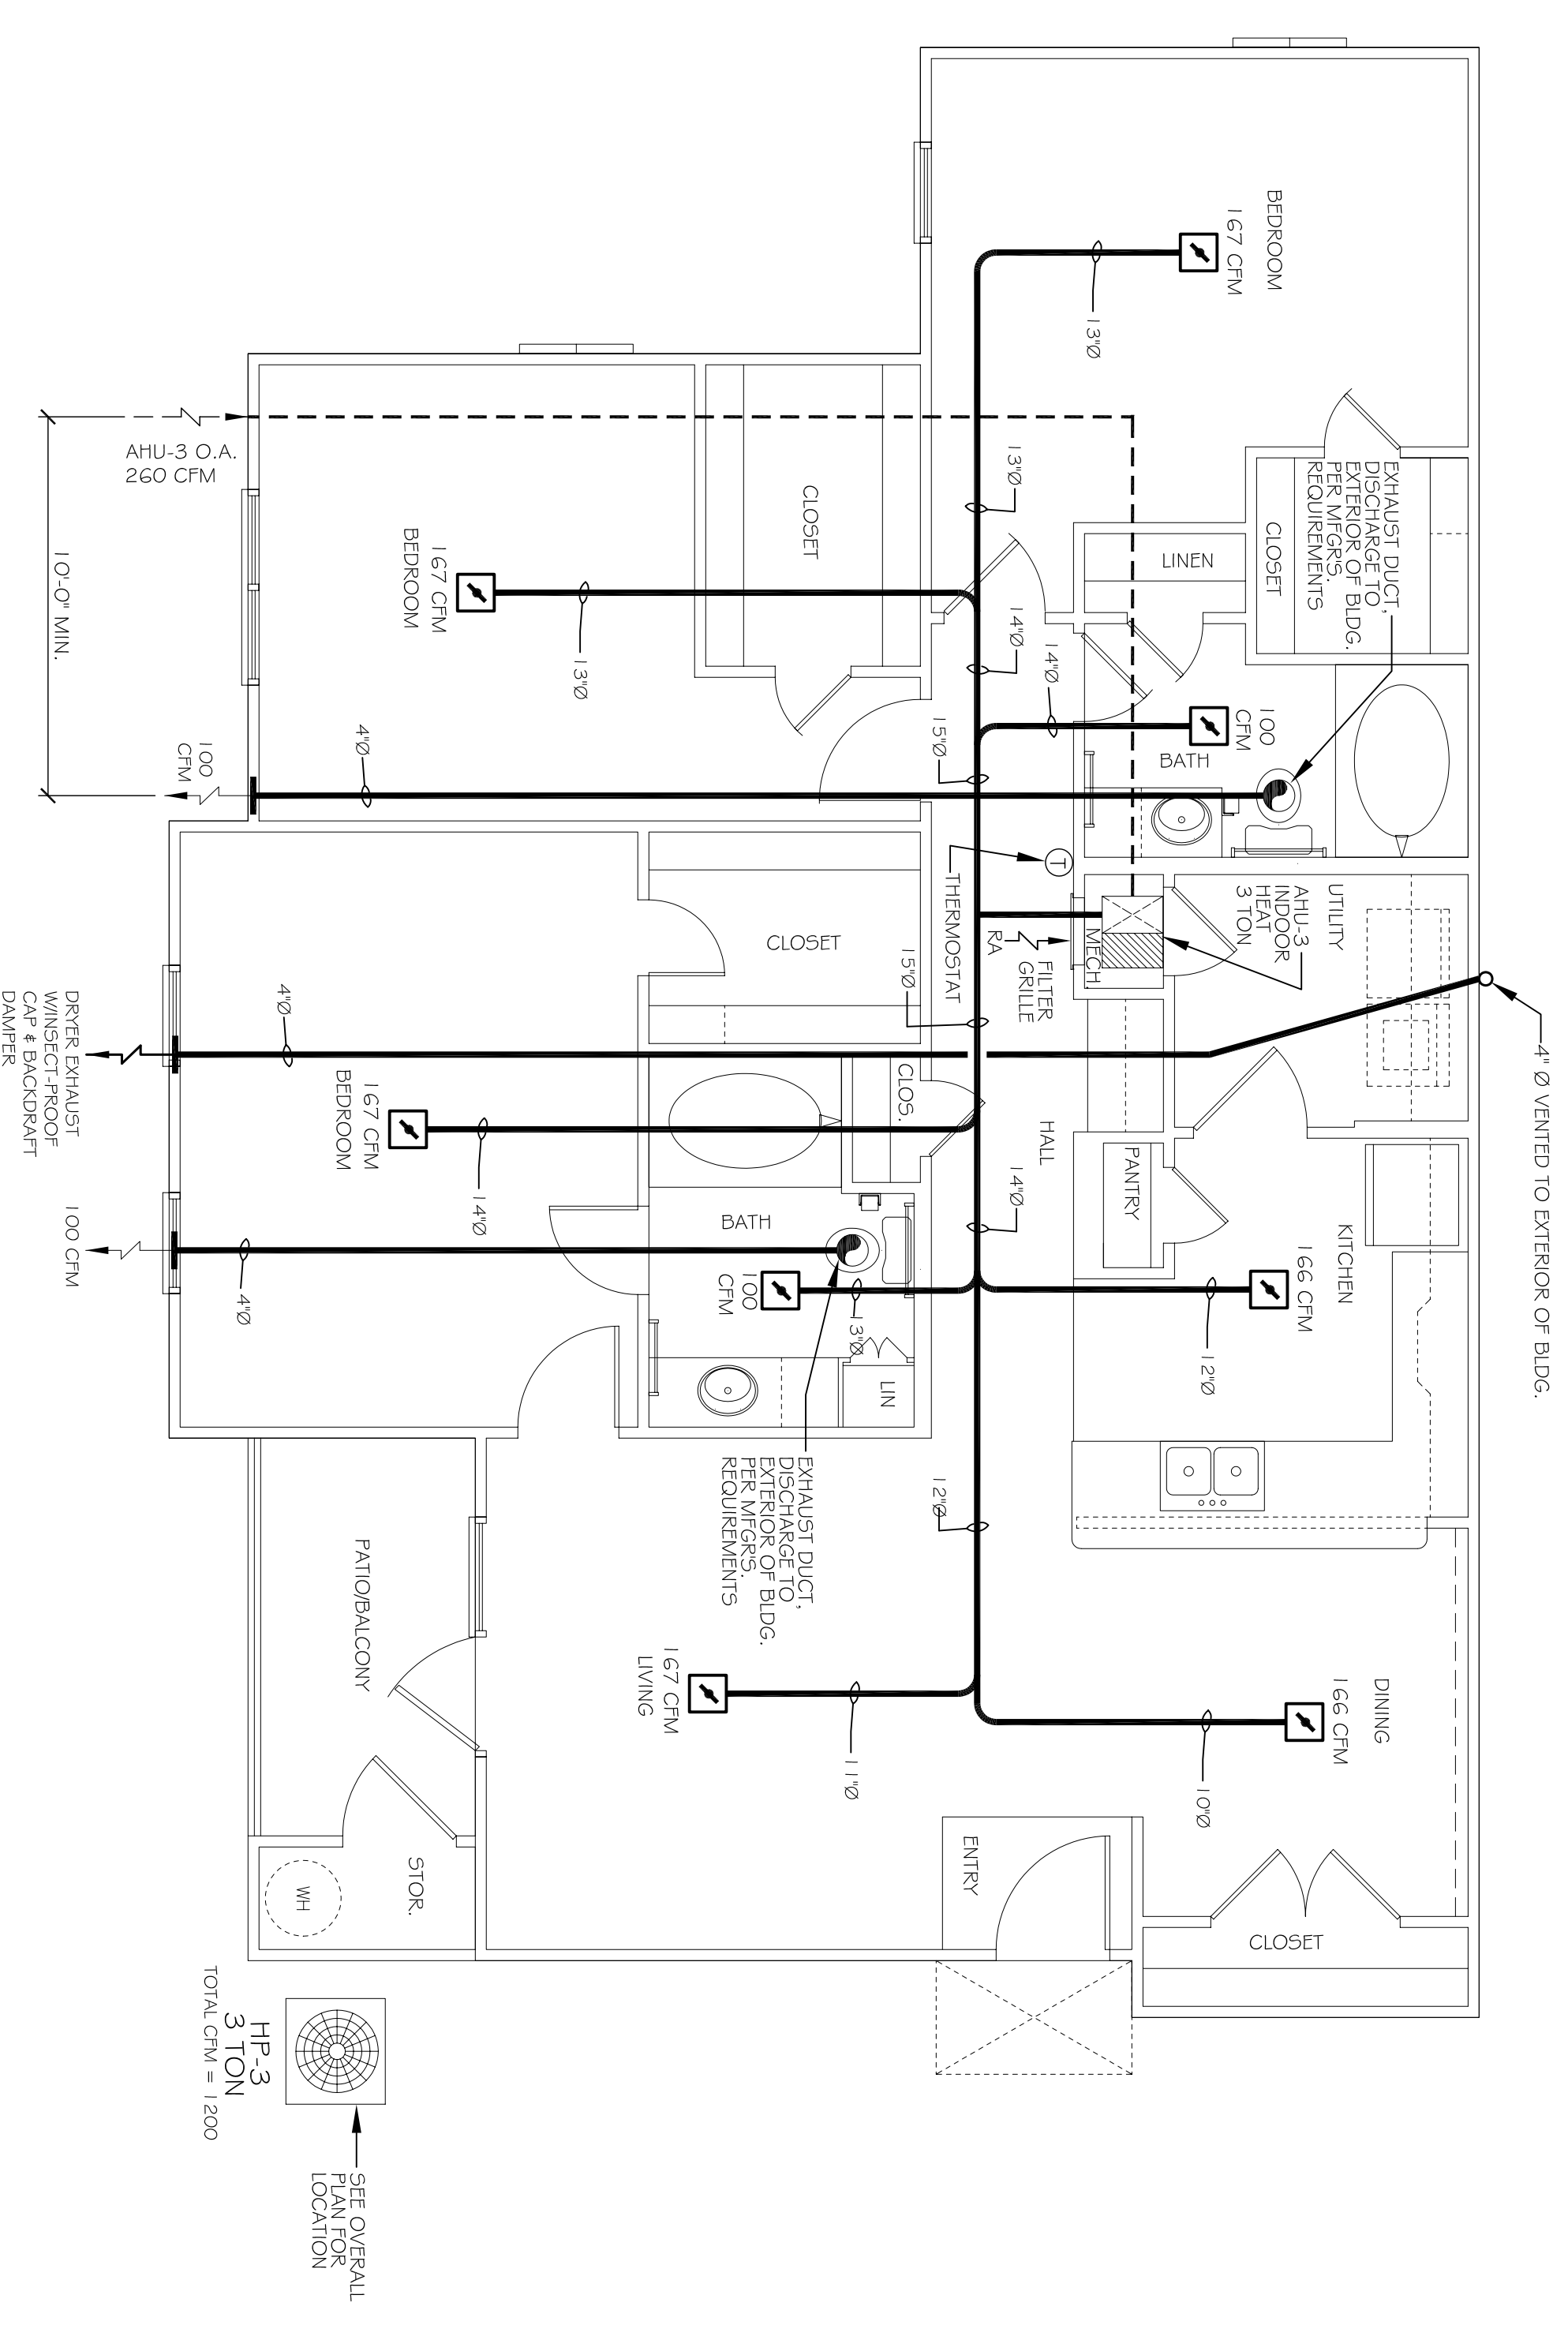


**THREE BEDROOM
UNIT 3A MECHANICAL PLAN**
SCALE: 1/4" = 1'-0" 1,482 SQ. FT.

- LEGEND**
- ☑ SUPPLY AIR VENT WITH FIRE DAMPER, CEILING MOUNTED
 - ☑ RETURN AIR GRILLE, WALL MOUNTED BELOW HVAC CLOSET DOOR, TYP. SEE PLAN FOR EXACT LOCATION
 - ⊙ BATHROOM EXHAUST
 - ⊙ THERMOSTAT

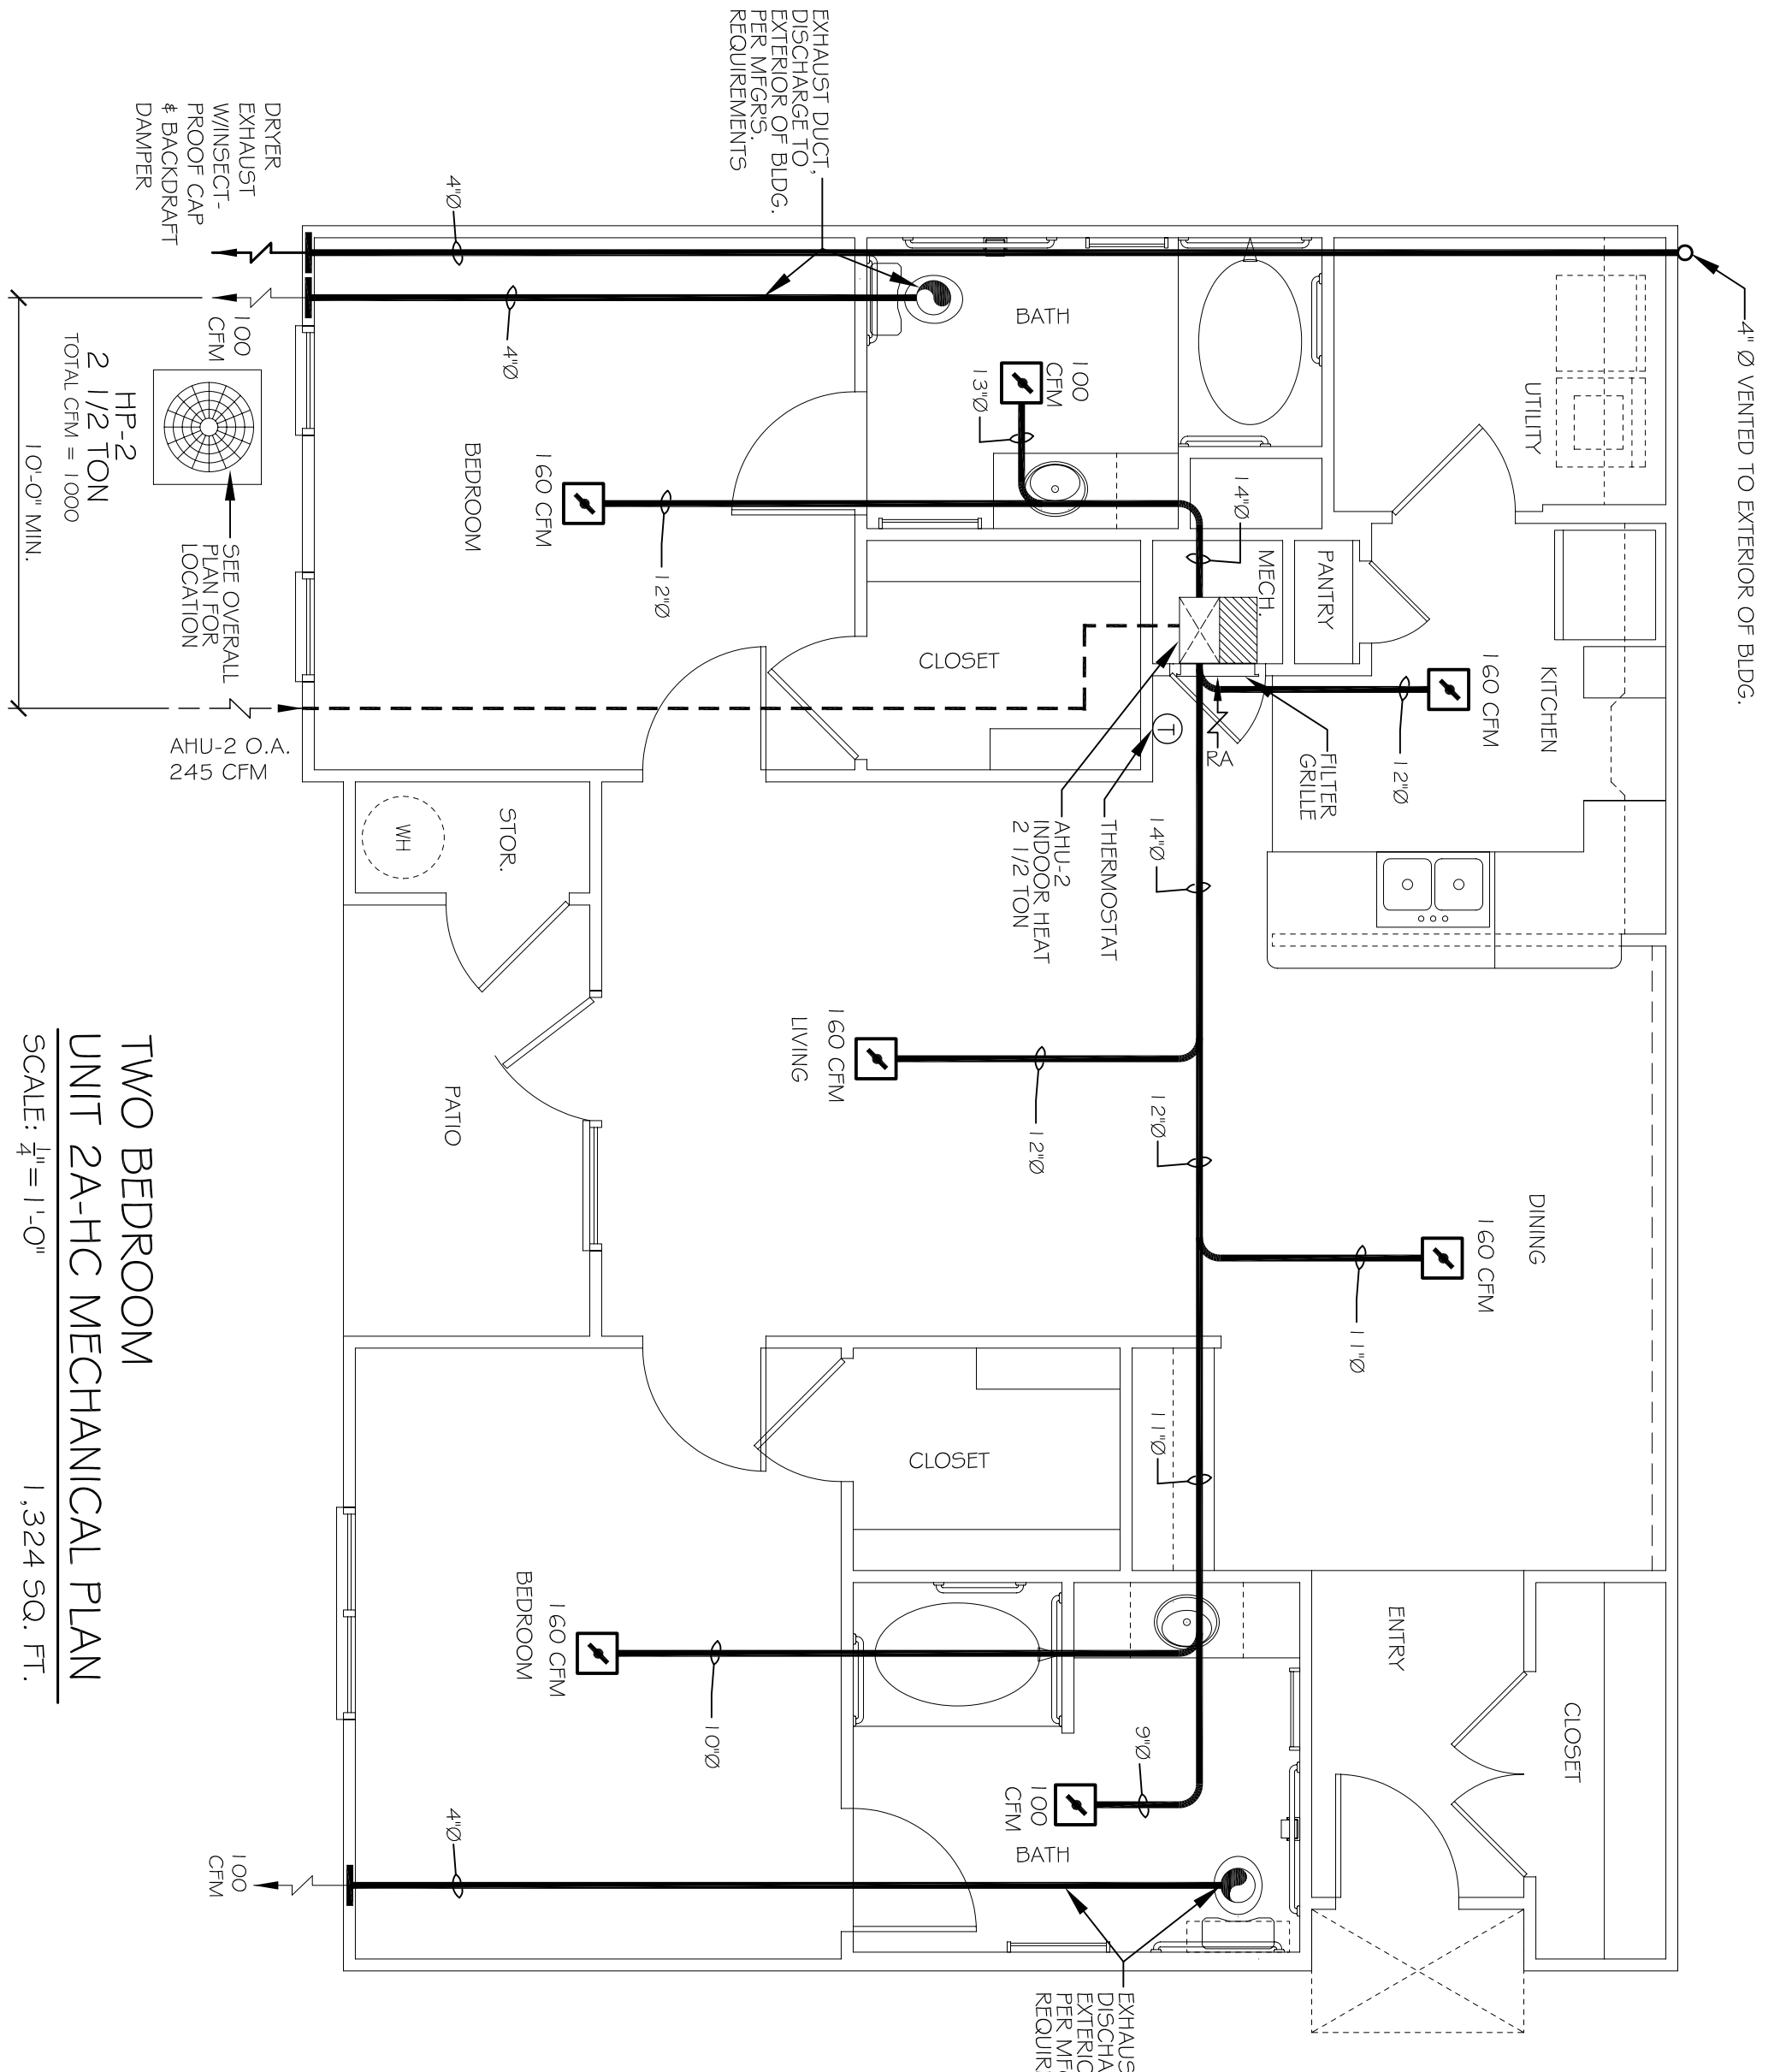

**TWO BEDROOM
UNIT 2A-HC MECHANICAL PLAN**
SCALE: 1/4" = 1'-0" 1,324 SQ. FT.

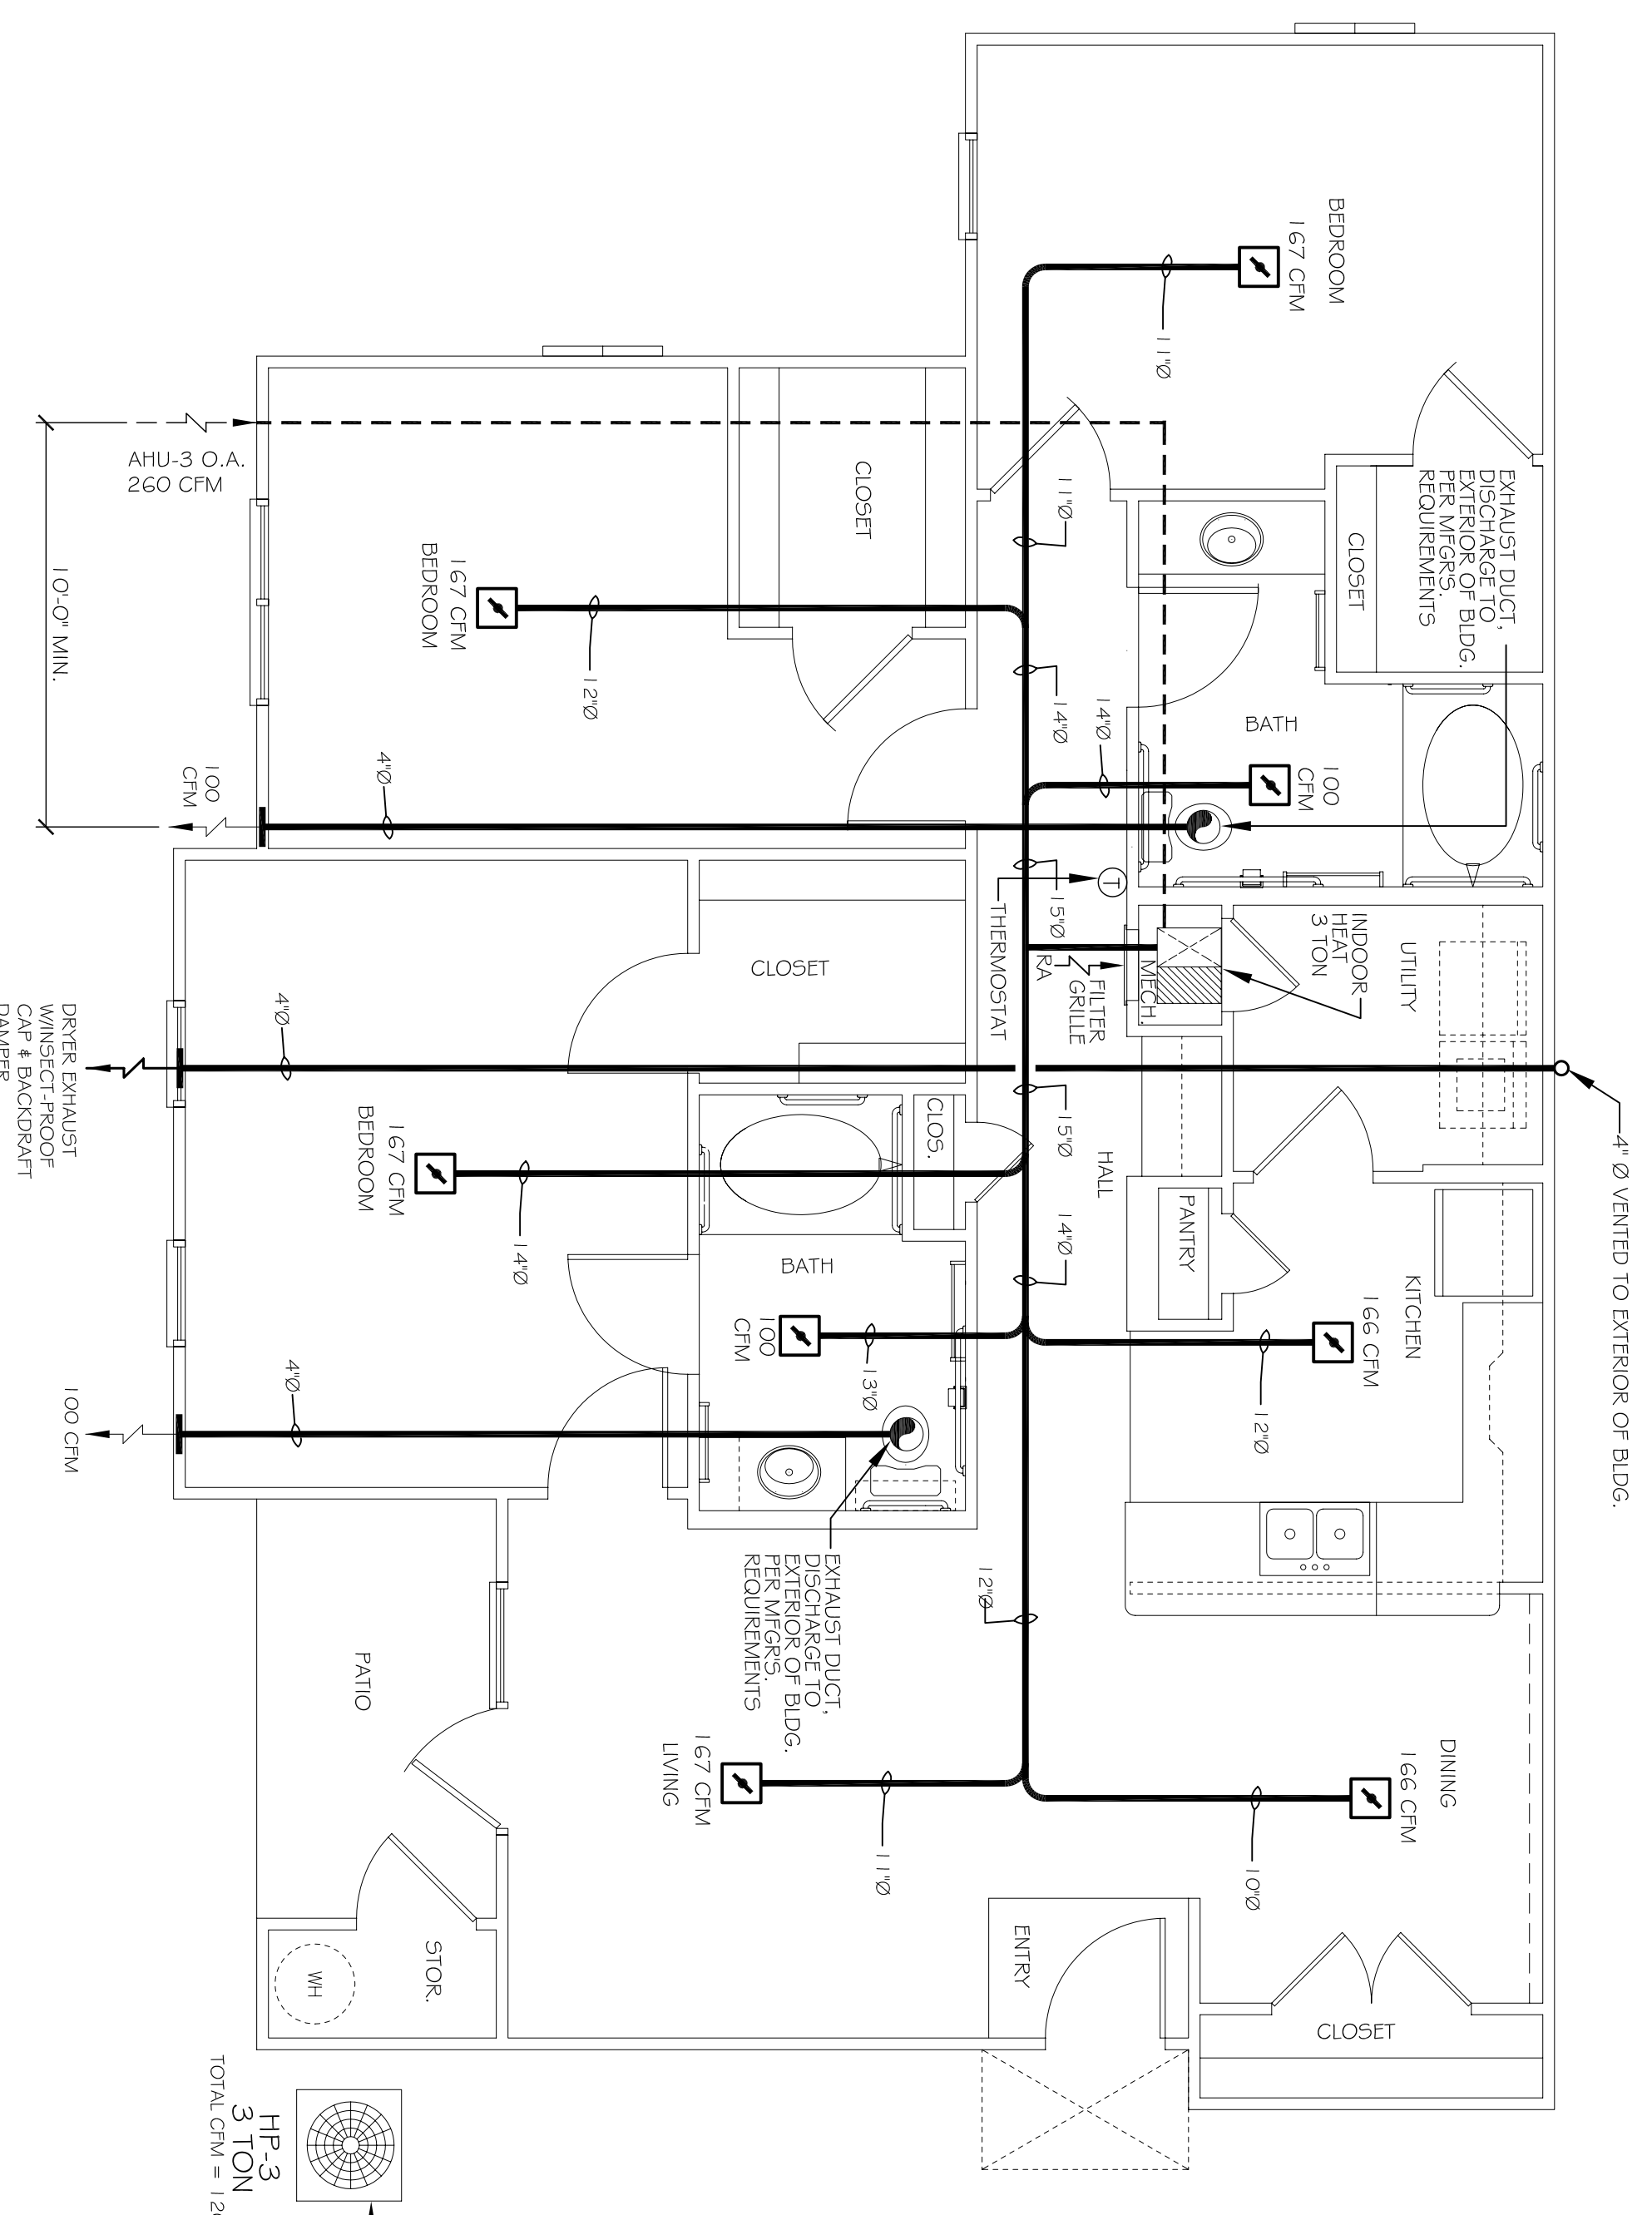

**THREE BEDROOM
UNIT 3A-HC MECHANICAL PLAN**
SCALE: 1/4" = 1'-0" 1,482 SQ. FT.