



UNIT 1A WATER PLUMBING PLAN
SCALE: 1/4"=1'-0"

MARK	DESCRIPTION	TYPE	ROUGH-IN SIZES			NOTES
			WASTE	VENT	CW HW	
WC	WATER CLOSET	VALVE	4"	4"	1/2"	3
LAV	LAVATORY	WALL HUNG	2"	2"	1/2"	1, 2, 3
F.D.	FLOOR DRAIN	-	2"	2"	1/2"	-
KS	KITCHEN	-	2"	2"	1/2"	4
BT	BATH TUB	-	2"	2"	1/2"	-
ICE MAKER	ICE MAKER	-	2"	2"	1/2"	-
WASH	WASHING MACHINE	-	2"	2"	1/2"	-
AHU COND	AIR HANDLING UNIT	-	2"	2"	1/2"	-

- NOTES:
1. INSTALL PIPING FOR HANDICAP FIXTURE.
 2. PROVIDE CHAIR CARRIER FOR WALL HUNG FIXTURE.
 3. H.C. - HANDICAP FIXTURE WHERE APPLICABLE.
 4. INSTALL CONTINUOUS DRIP VALVE ON ALL FLOOR DRAINS.

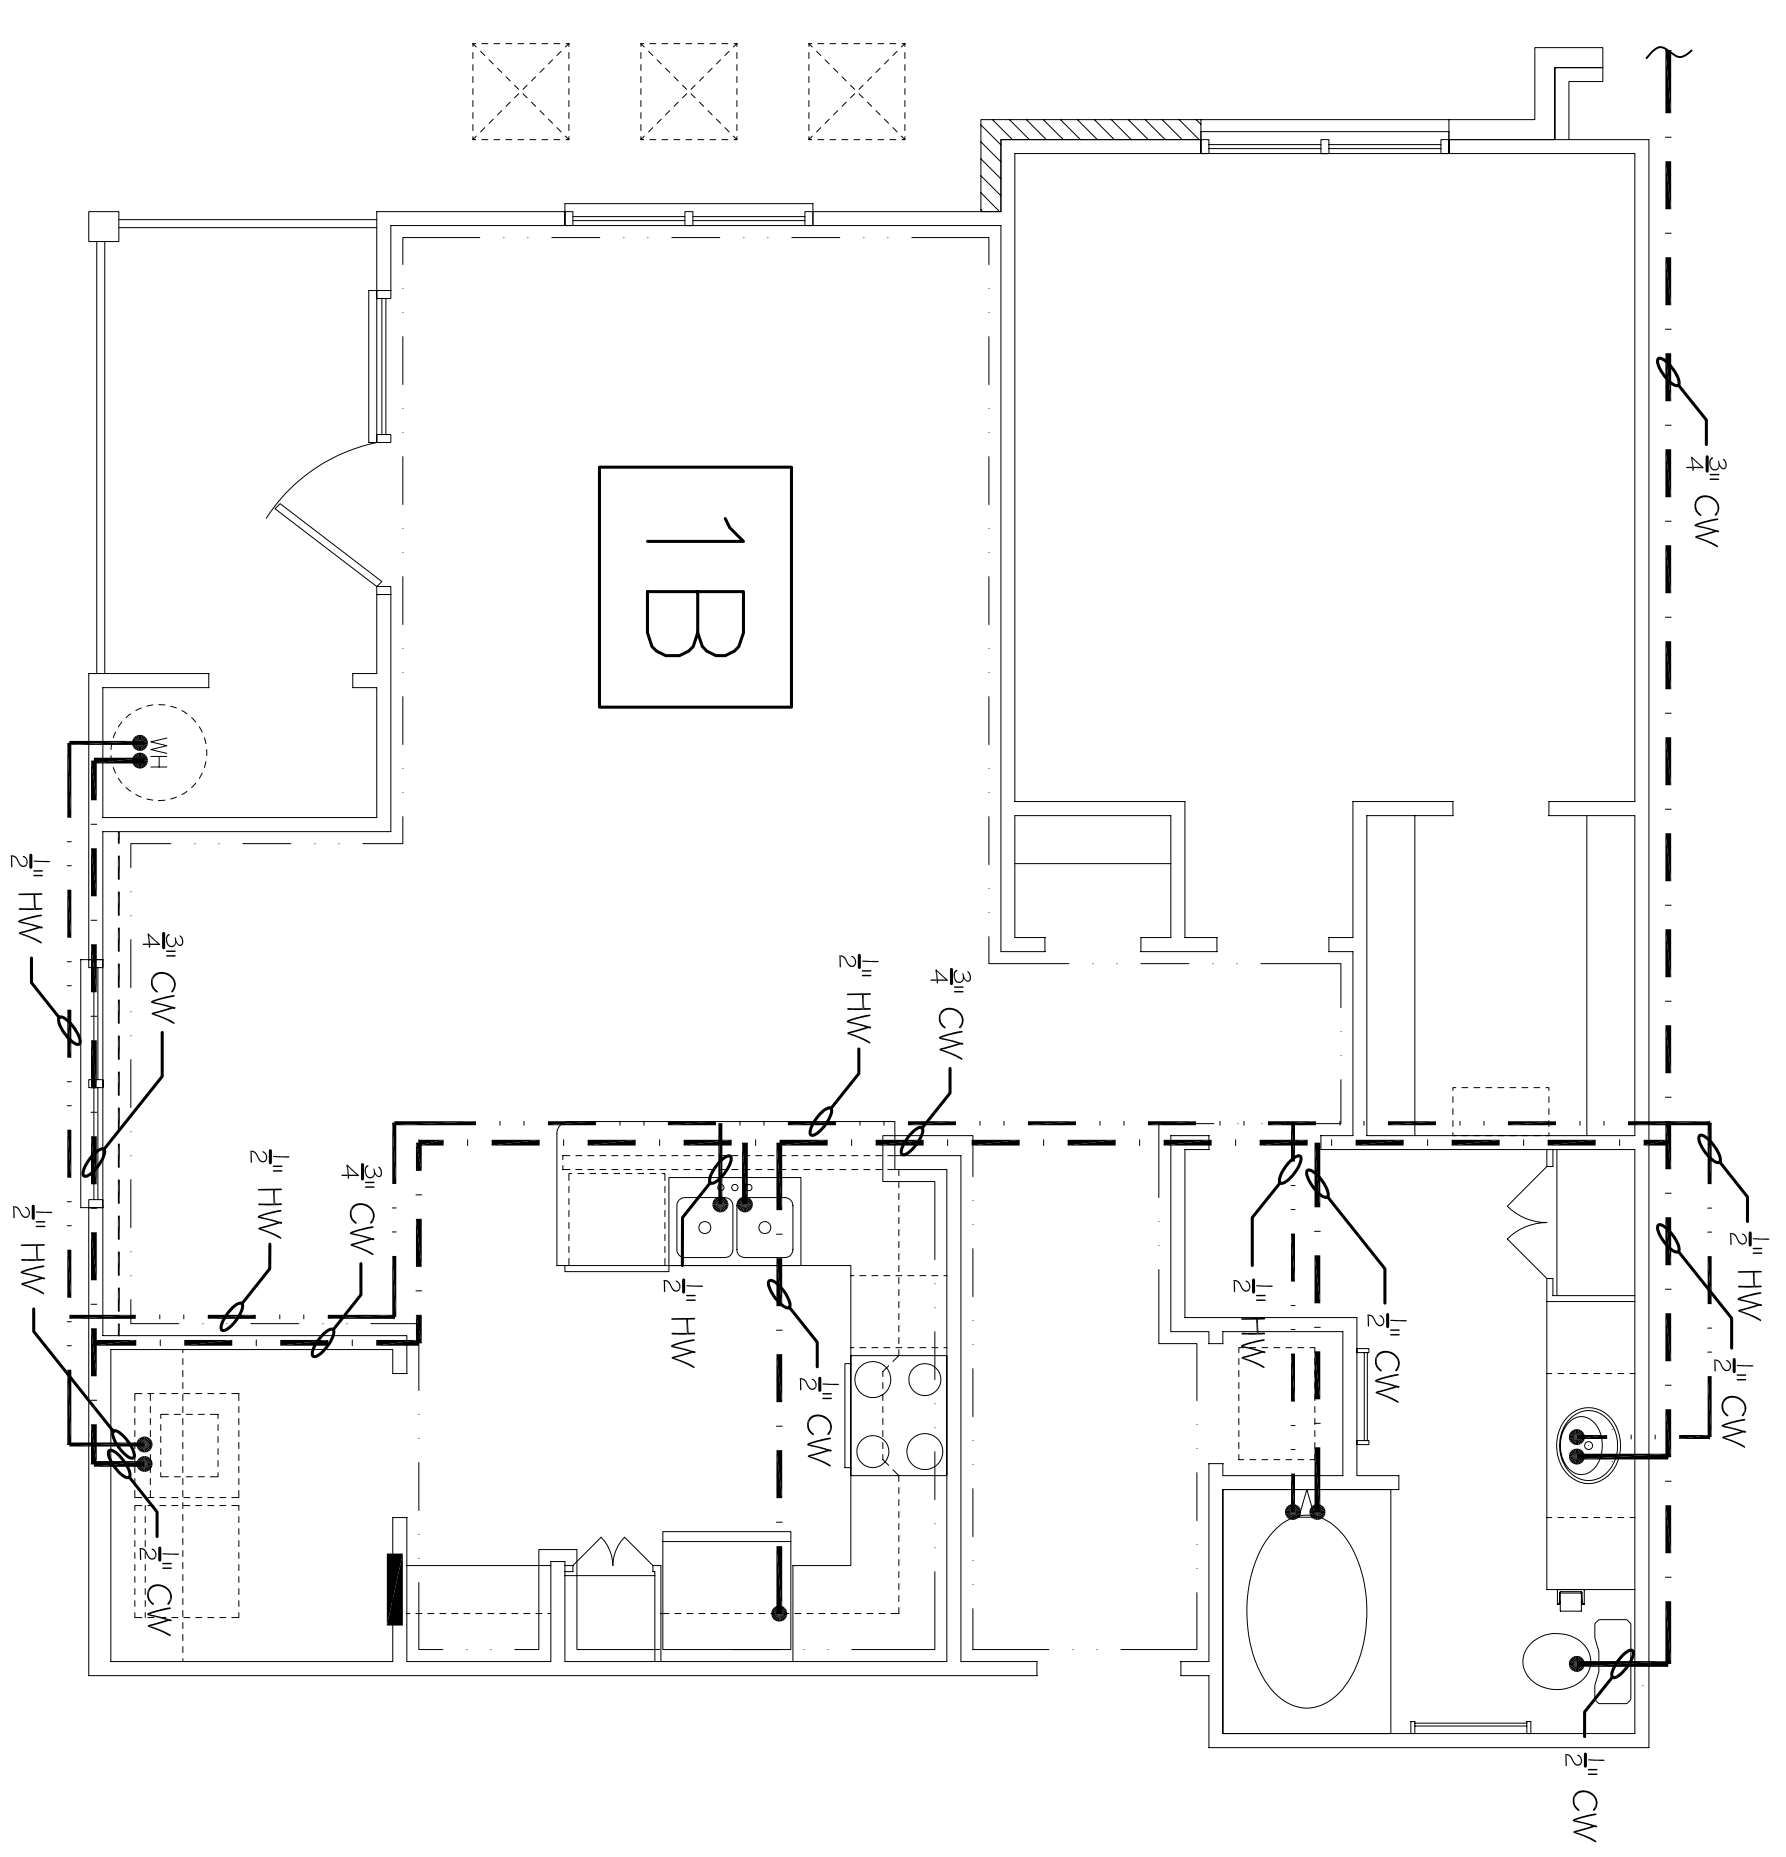


UNIT 1B WATER PLUMBING PLAN
SCALE: 1/4"=1'-0"

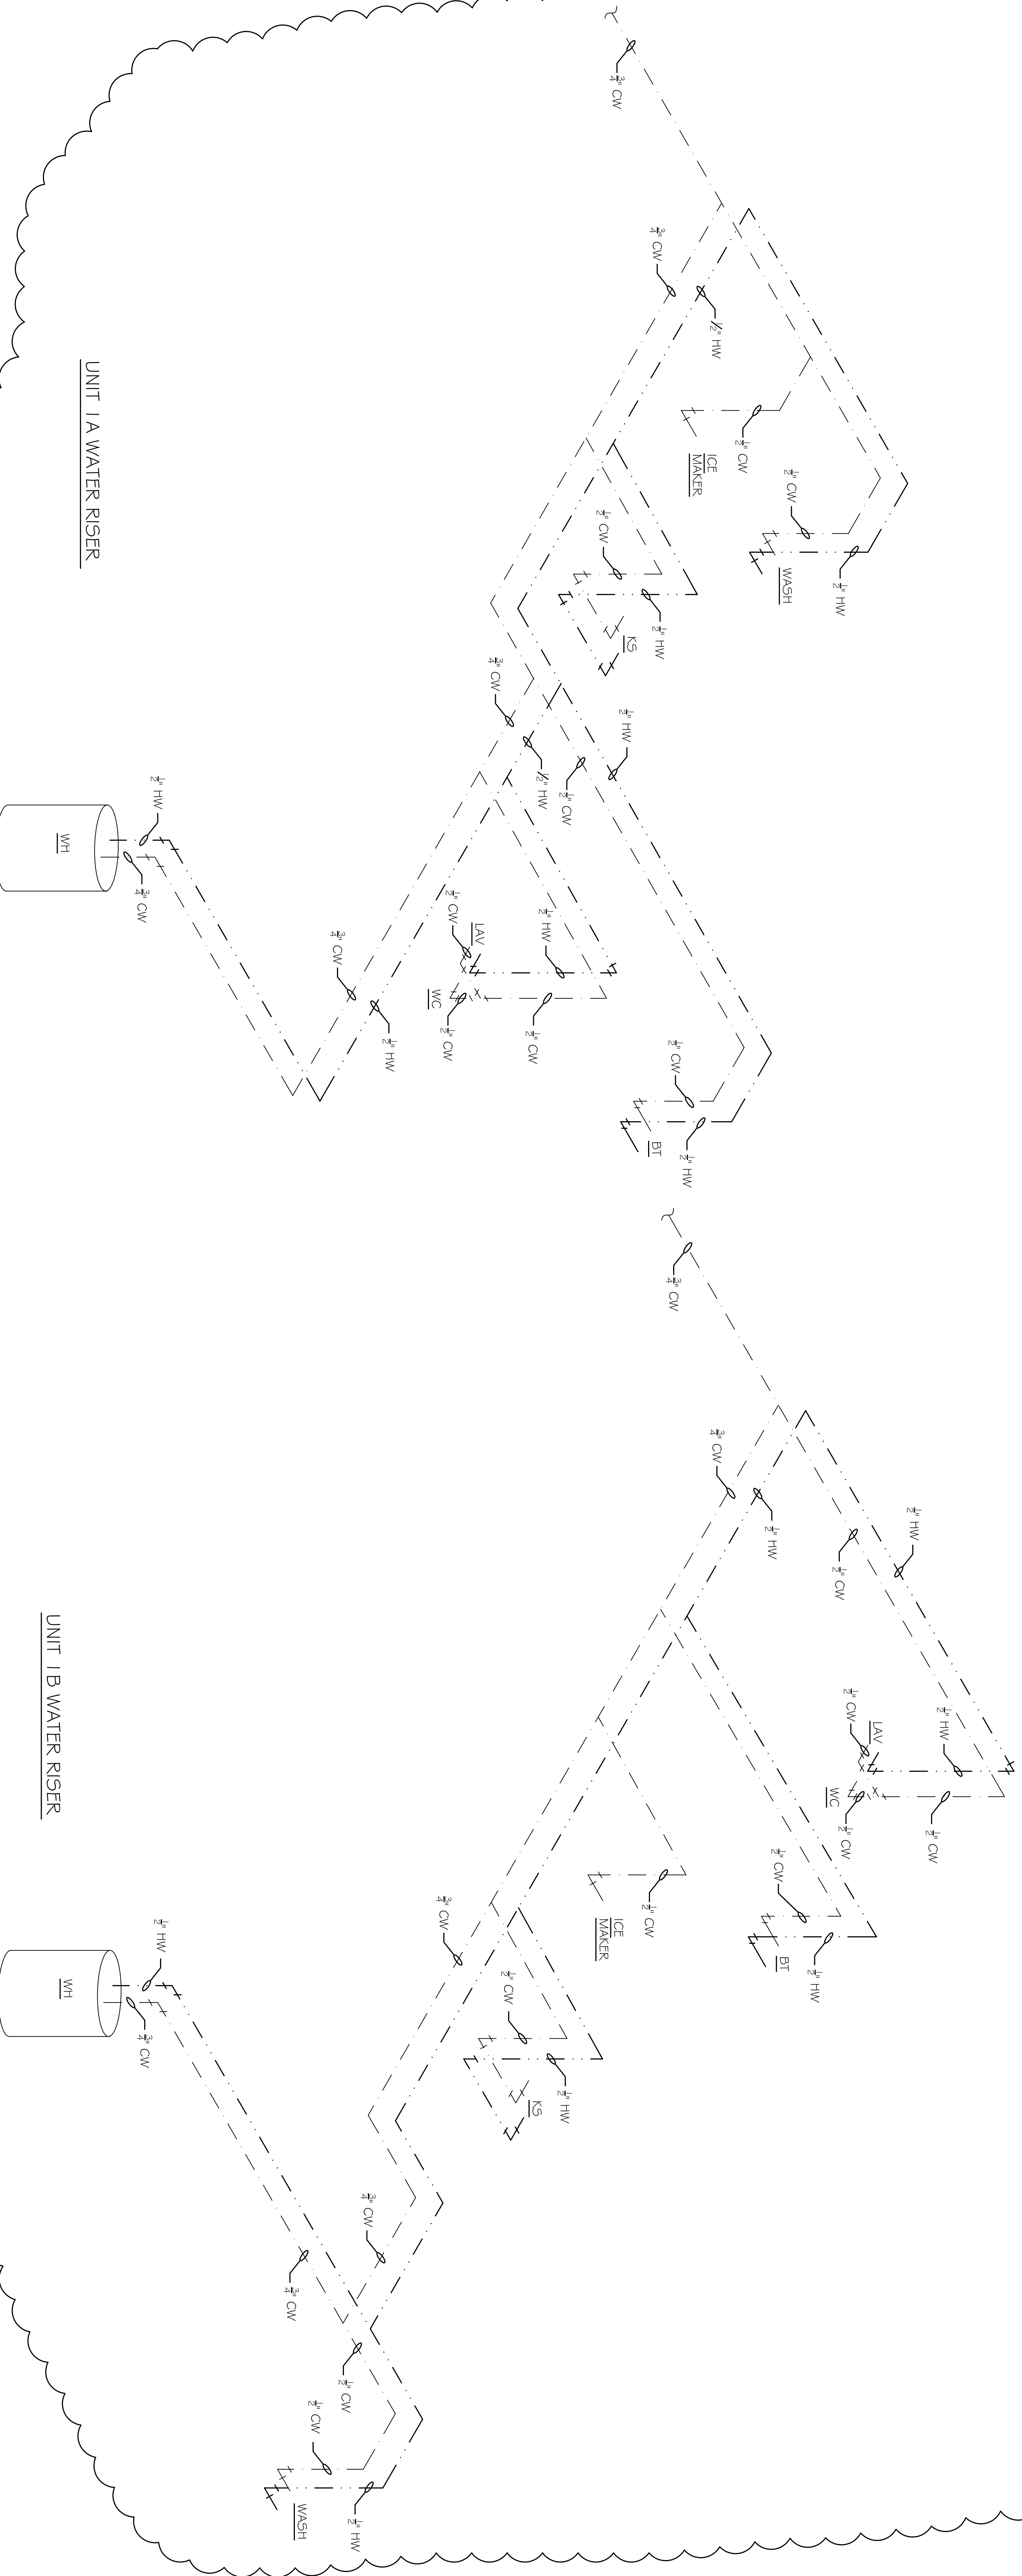

UNIT 1A WATER RISER

UNIT 1B WATER RISER

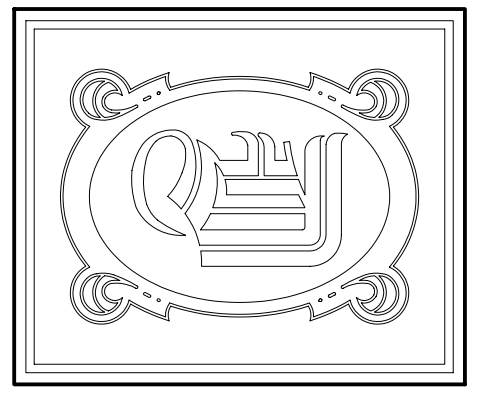

CHIEF ENGINEER
DAMMON, F.T.E.
CHIEF ARCHITECT
ROBERT
WILTSE

1095 FLORIDA AVENUE
SUITE 111, 70455
OFFICE 909-641-5892
FAX: 909-641-5930

WWW.DAMMONENGINEERING.COM
EMAIL: DAMMON@DAMMONENR.COM
DAMMONENR@GMAIL.COM

ARCHITECTURE
ENGINEERING
STUDIES
PLANNING
INVESTIGATION
EXPERT WITNESSES

NEW
APARTMENT
COMPLEX

CROSSWINDS
APARTMENTS
HAMMOND, LA

UNITS 1A & 1B
WATER PLUMBING
PLAN & RISERS

REV: 1-15-10

SCALE: AS NOTED

JOB#: 08112.13

DATE: 12-16-09

SHEET

P-3

OF