
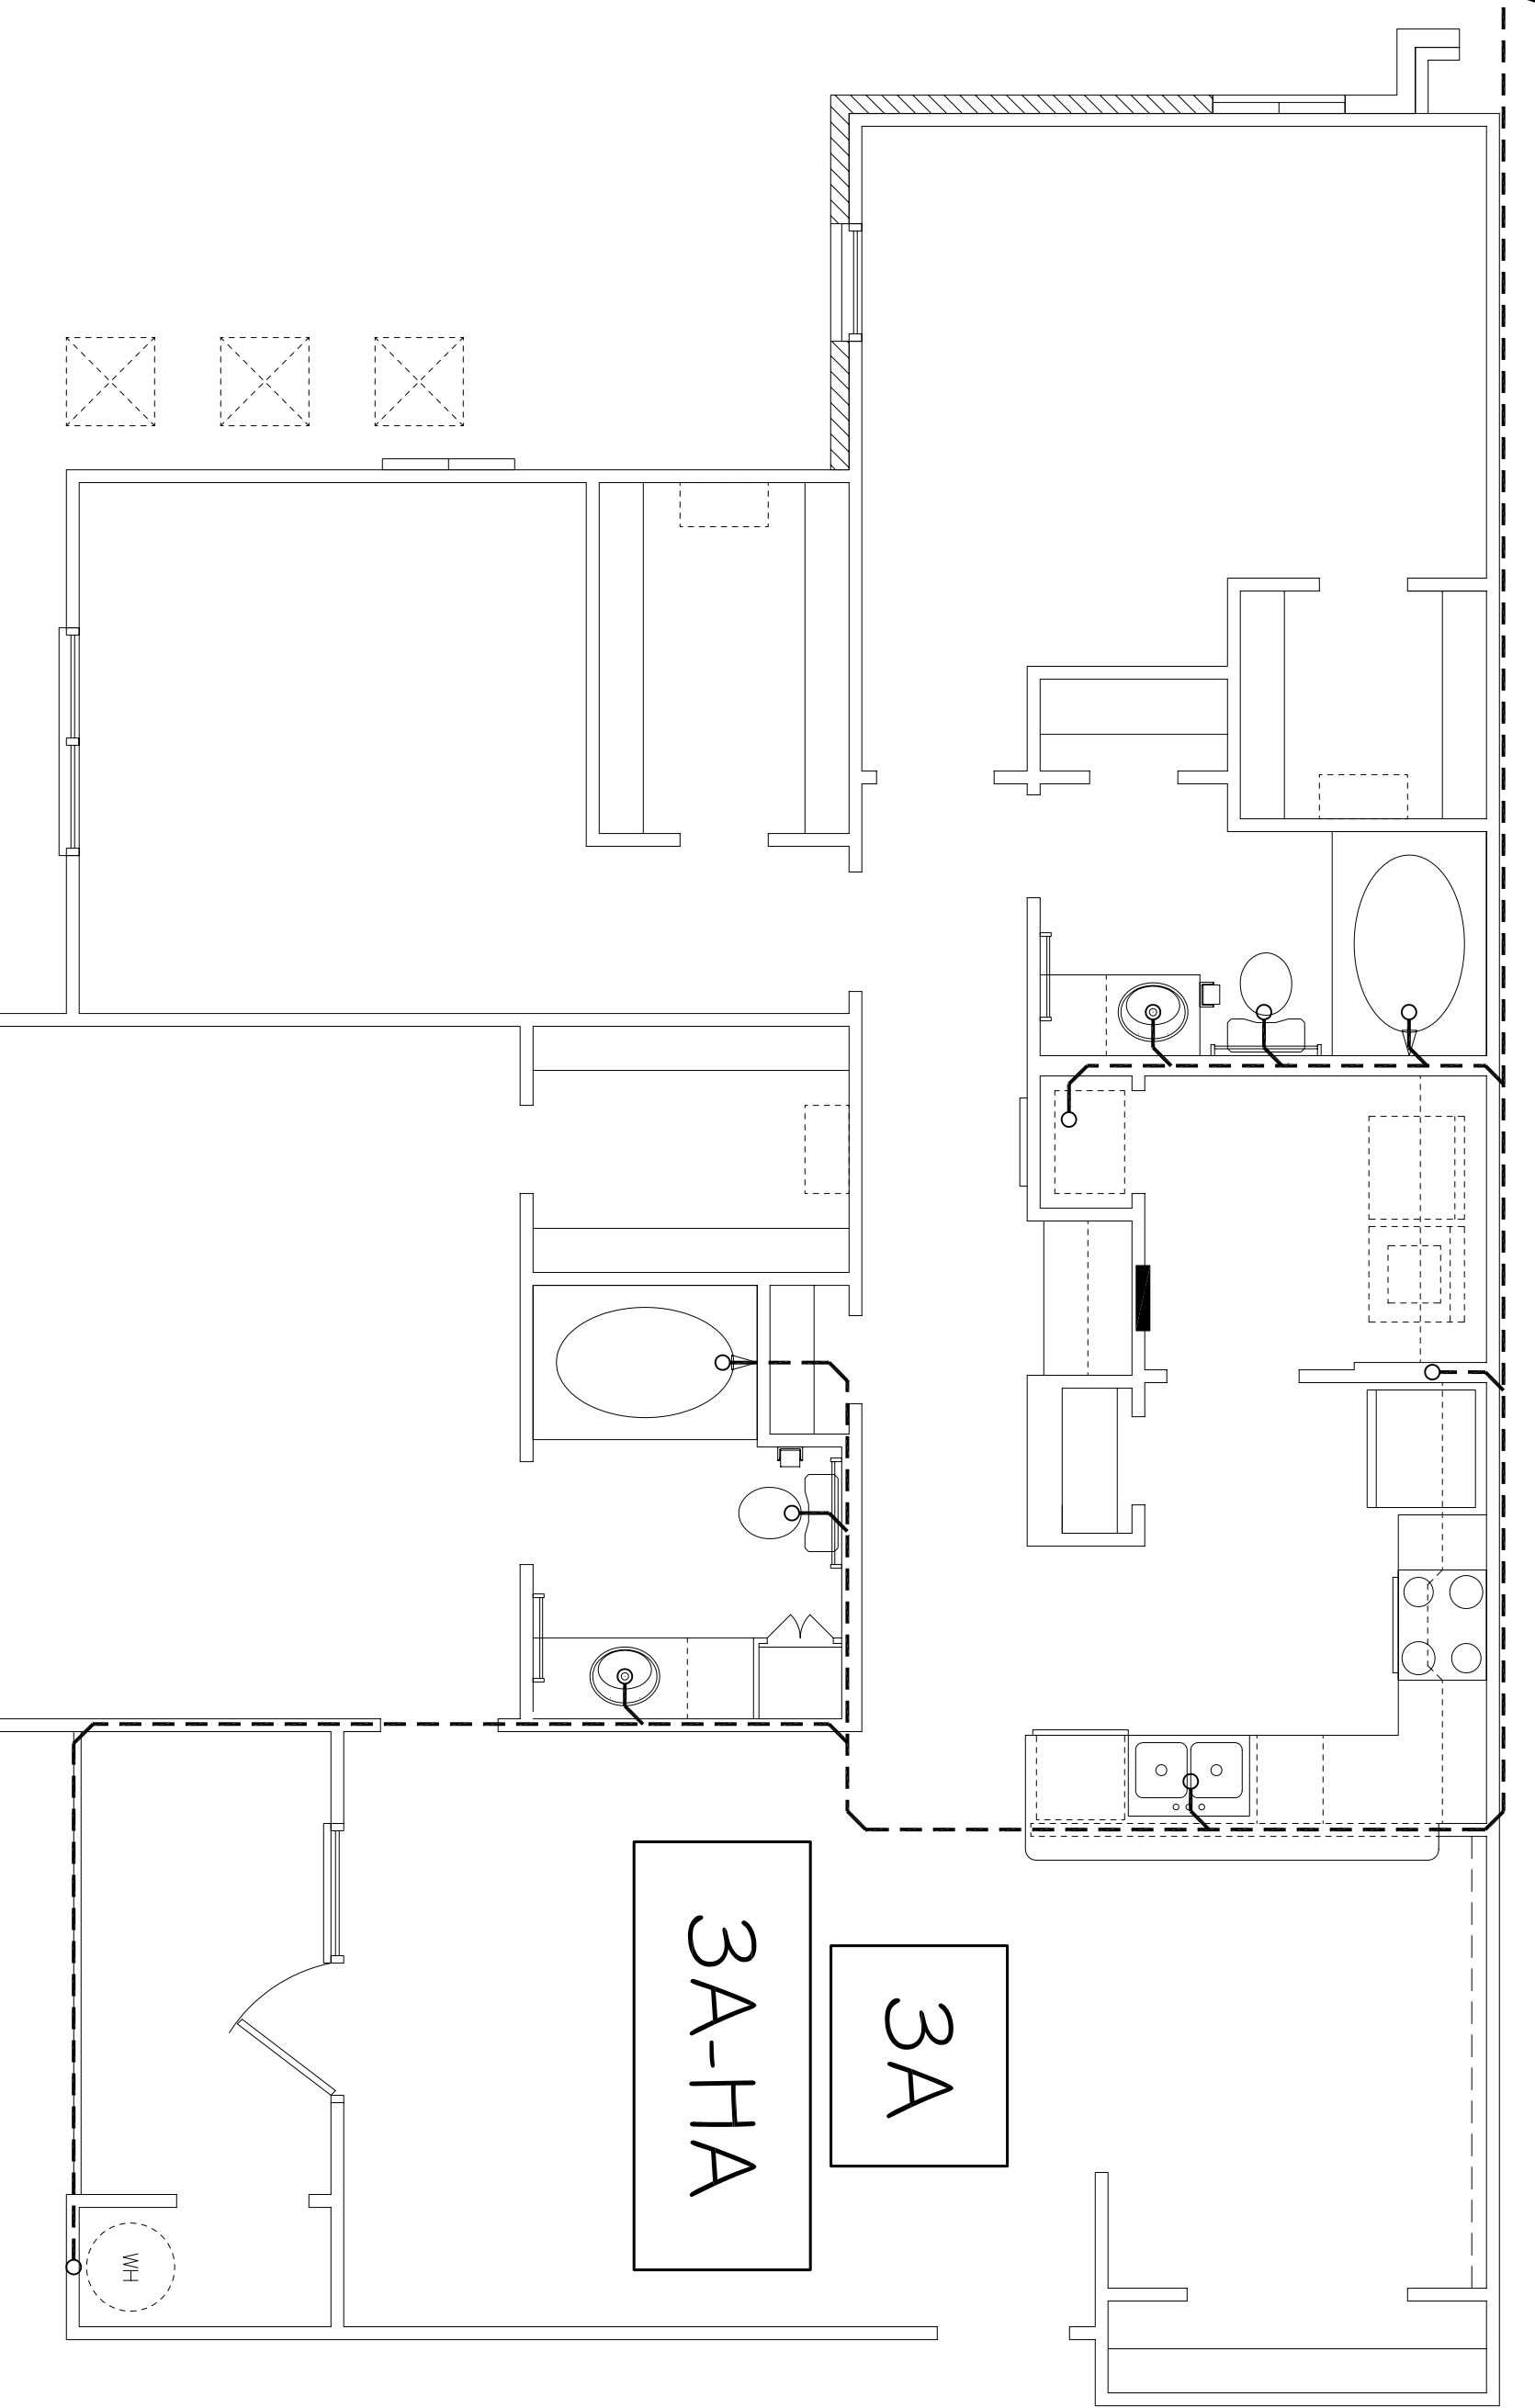





UNIT 2A SEWER PLUMBING RISER
SCALE: 1/4" = 1'-0"

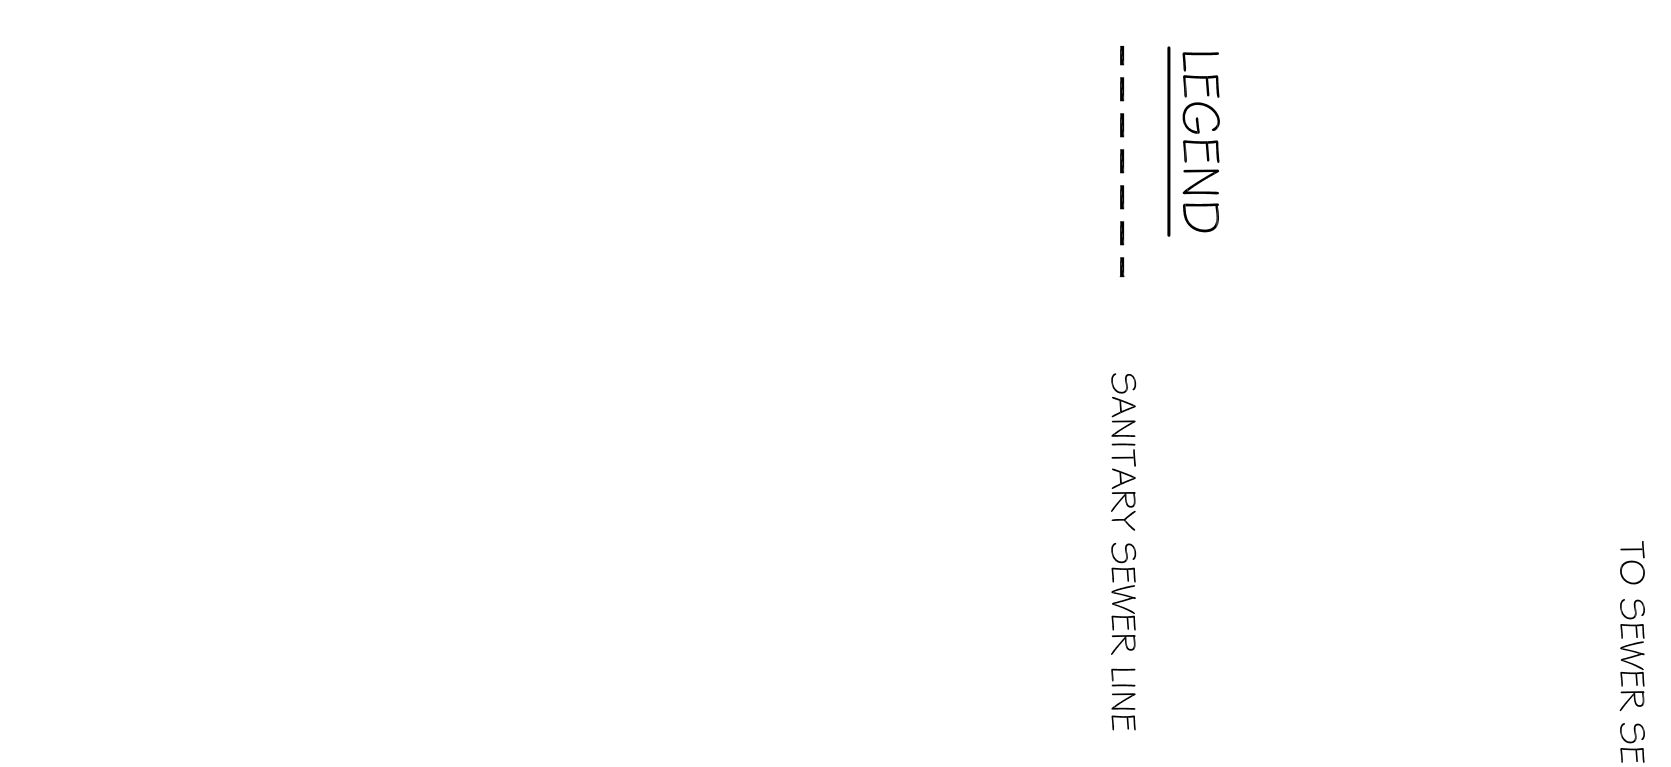

UNIT 3A SEWER PLUMBING RISER
SCALE: 1/4" = 1'-0"

MARK	DESCRIPTION	TYPE	ROUGH-IN SIZES	NOTES
WC	WATER CLOSET	VALVE	4" 4" 1/2"	3
LAV	LAVATORY	WALL HUNG	2" 1/2" 1/2"	1, 2, 3
F.D.	FLOOR DRAIN	-	2" 1/2" -	4
KS	KITCHEN	-	2" 1/2" 1/2"	-
BT	BATH TUB	-	2" 1/2" 1/2"	-
ICE MAKER	ICE MAKER	-	2" 1/2" -	-
WASH	WASHING MACHINE	-	2" 1/2" 1/2"	-
ATU COND.	ATU HANDLING UNIT	-	2" -	-

- NOTES:
1. INSULATE PIPING FOR HANDICAP FIXTURE.
 2. PROVIDE CHAIR CARRIER FOR WALL HUNG FIXTURE.
 3. H. C. - HANDICAP FIXTURE WHERE APPLICABLE
 4. INSTALL CONTINUOUS DRIP VALVE ON ALL FLOOR DRAINS.

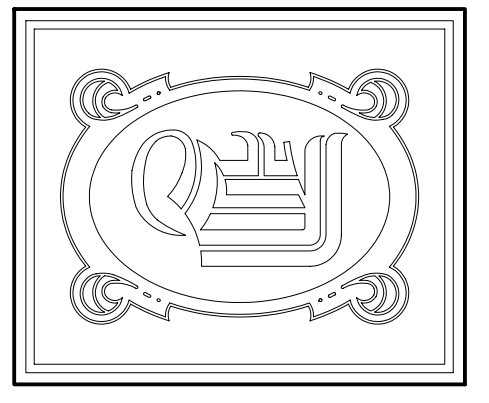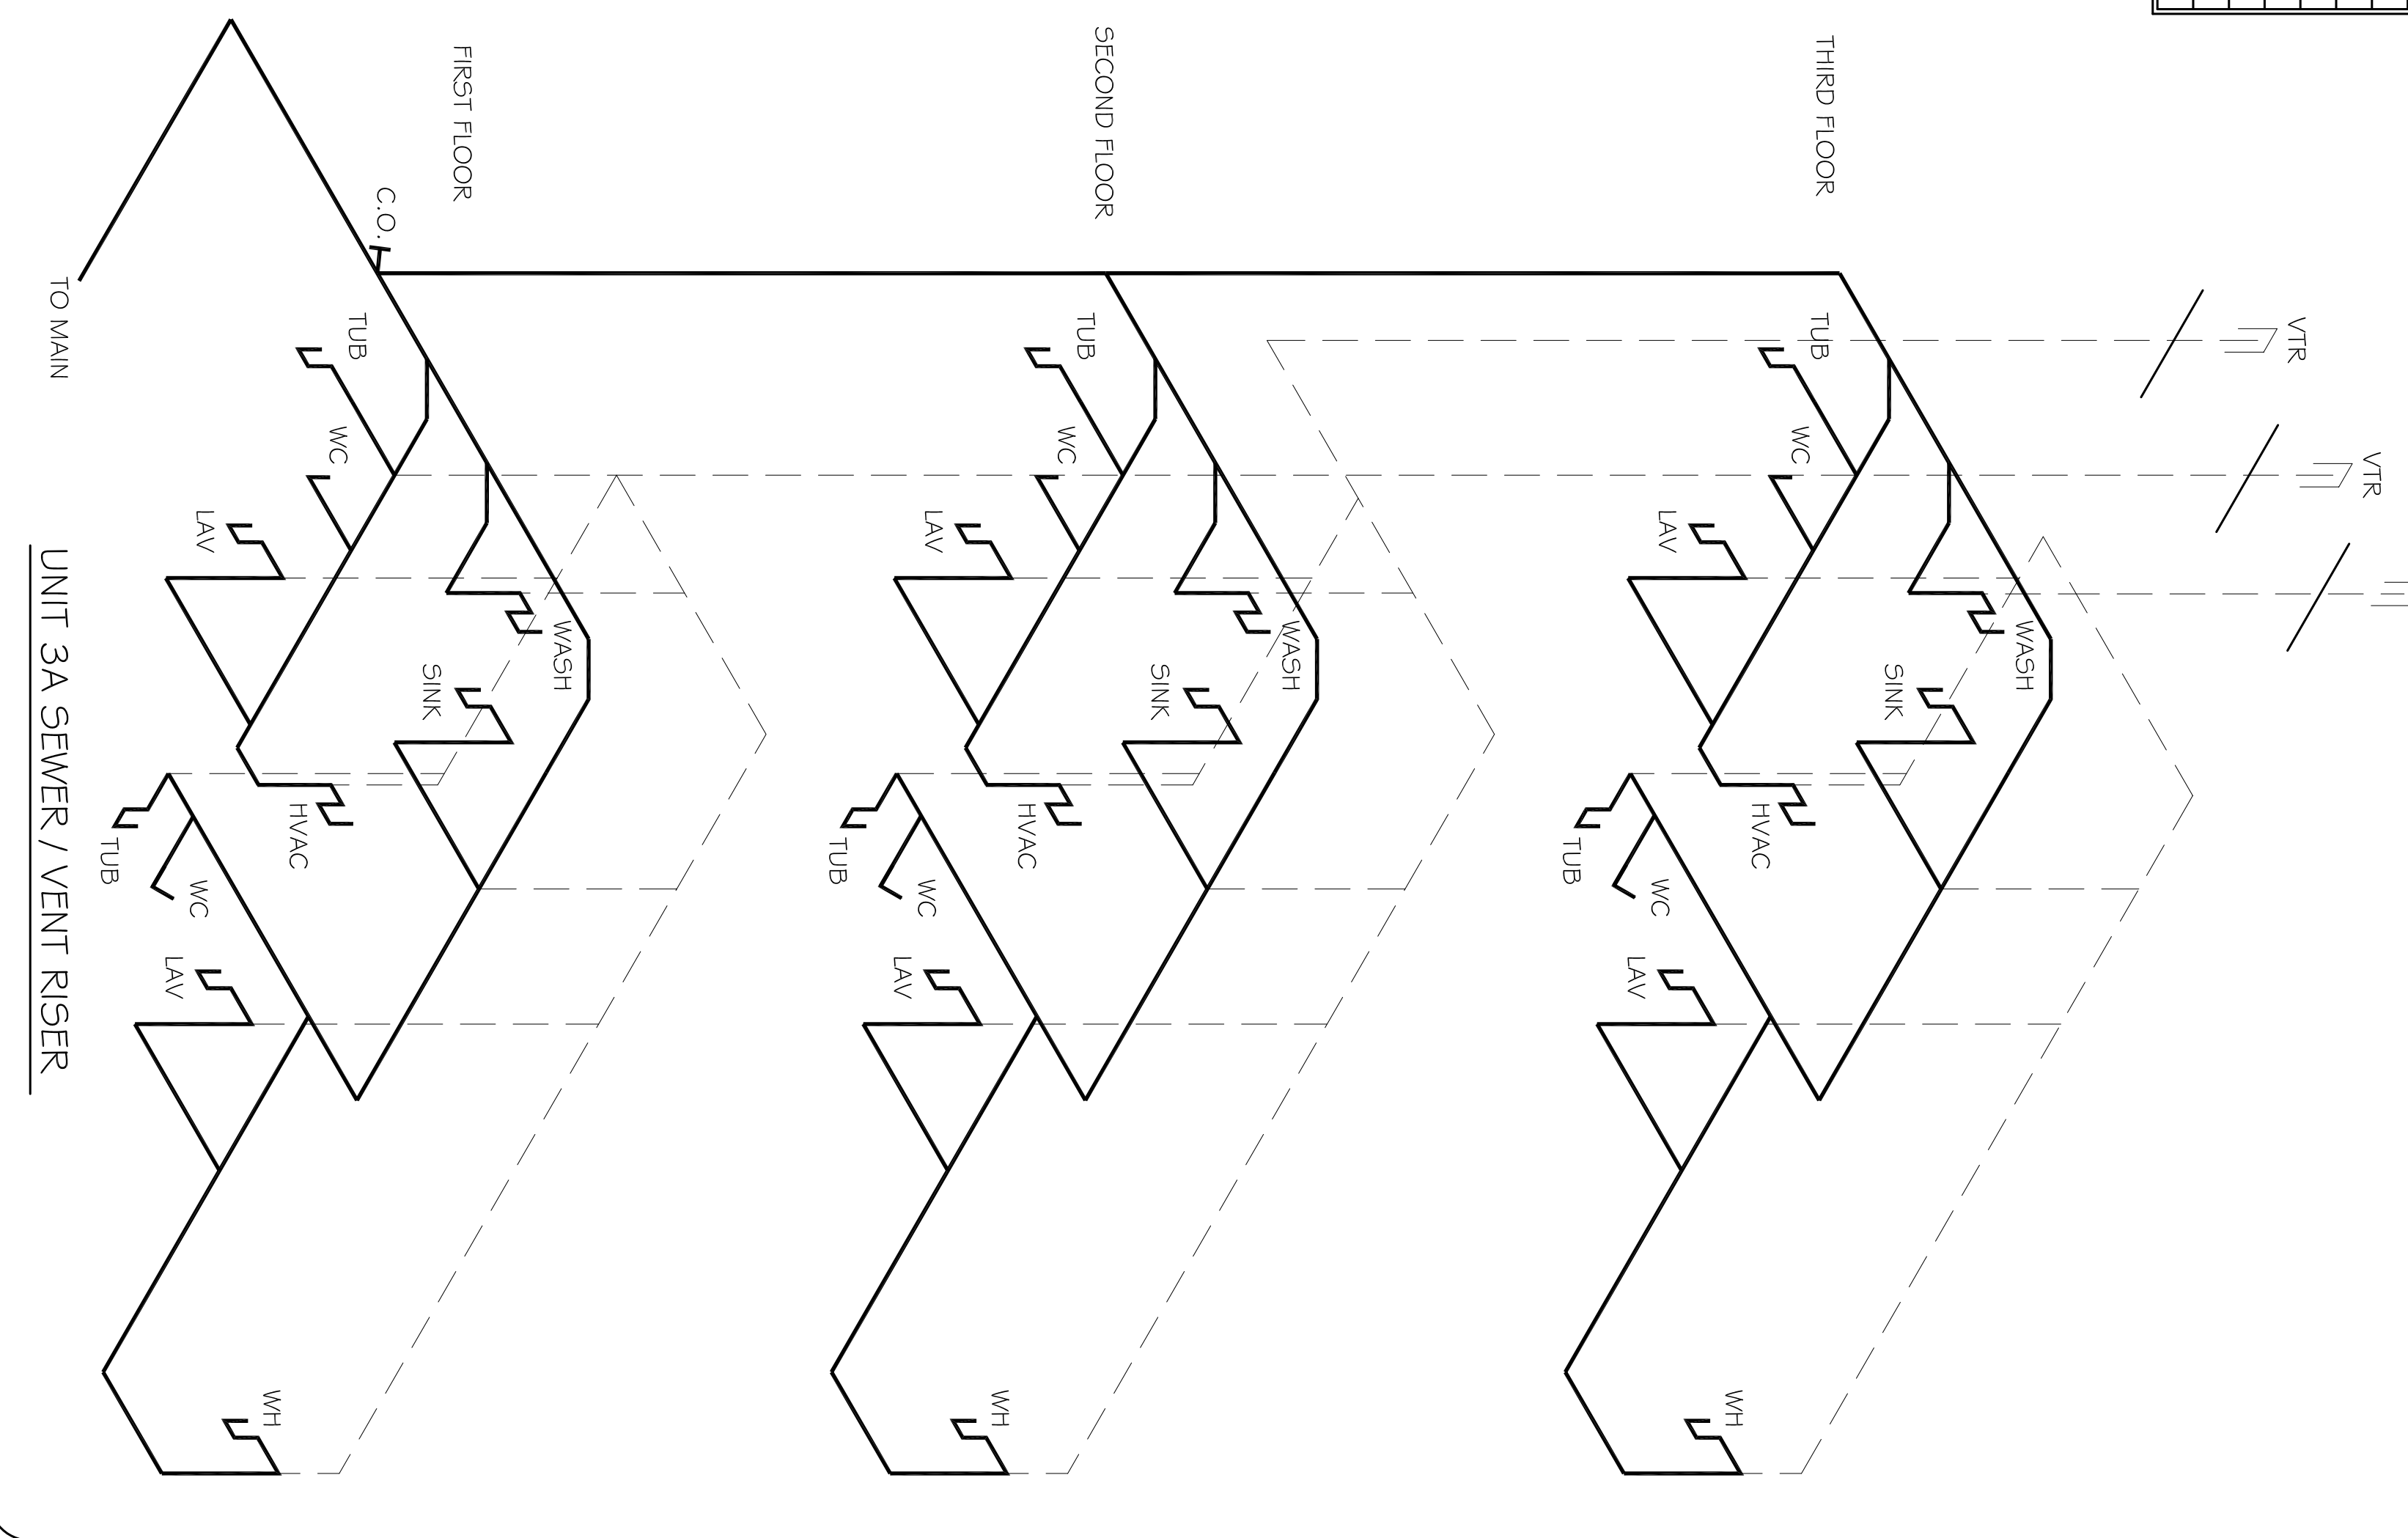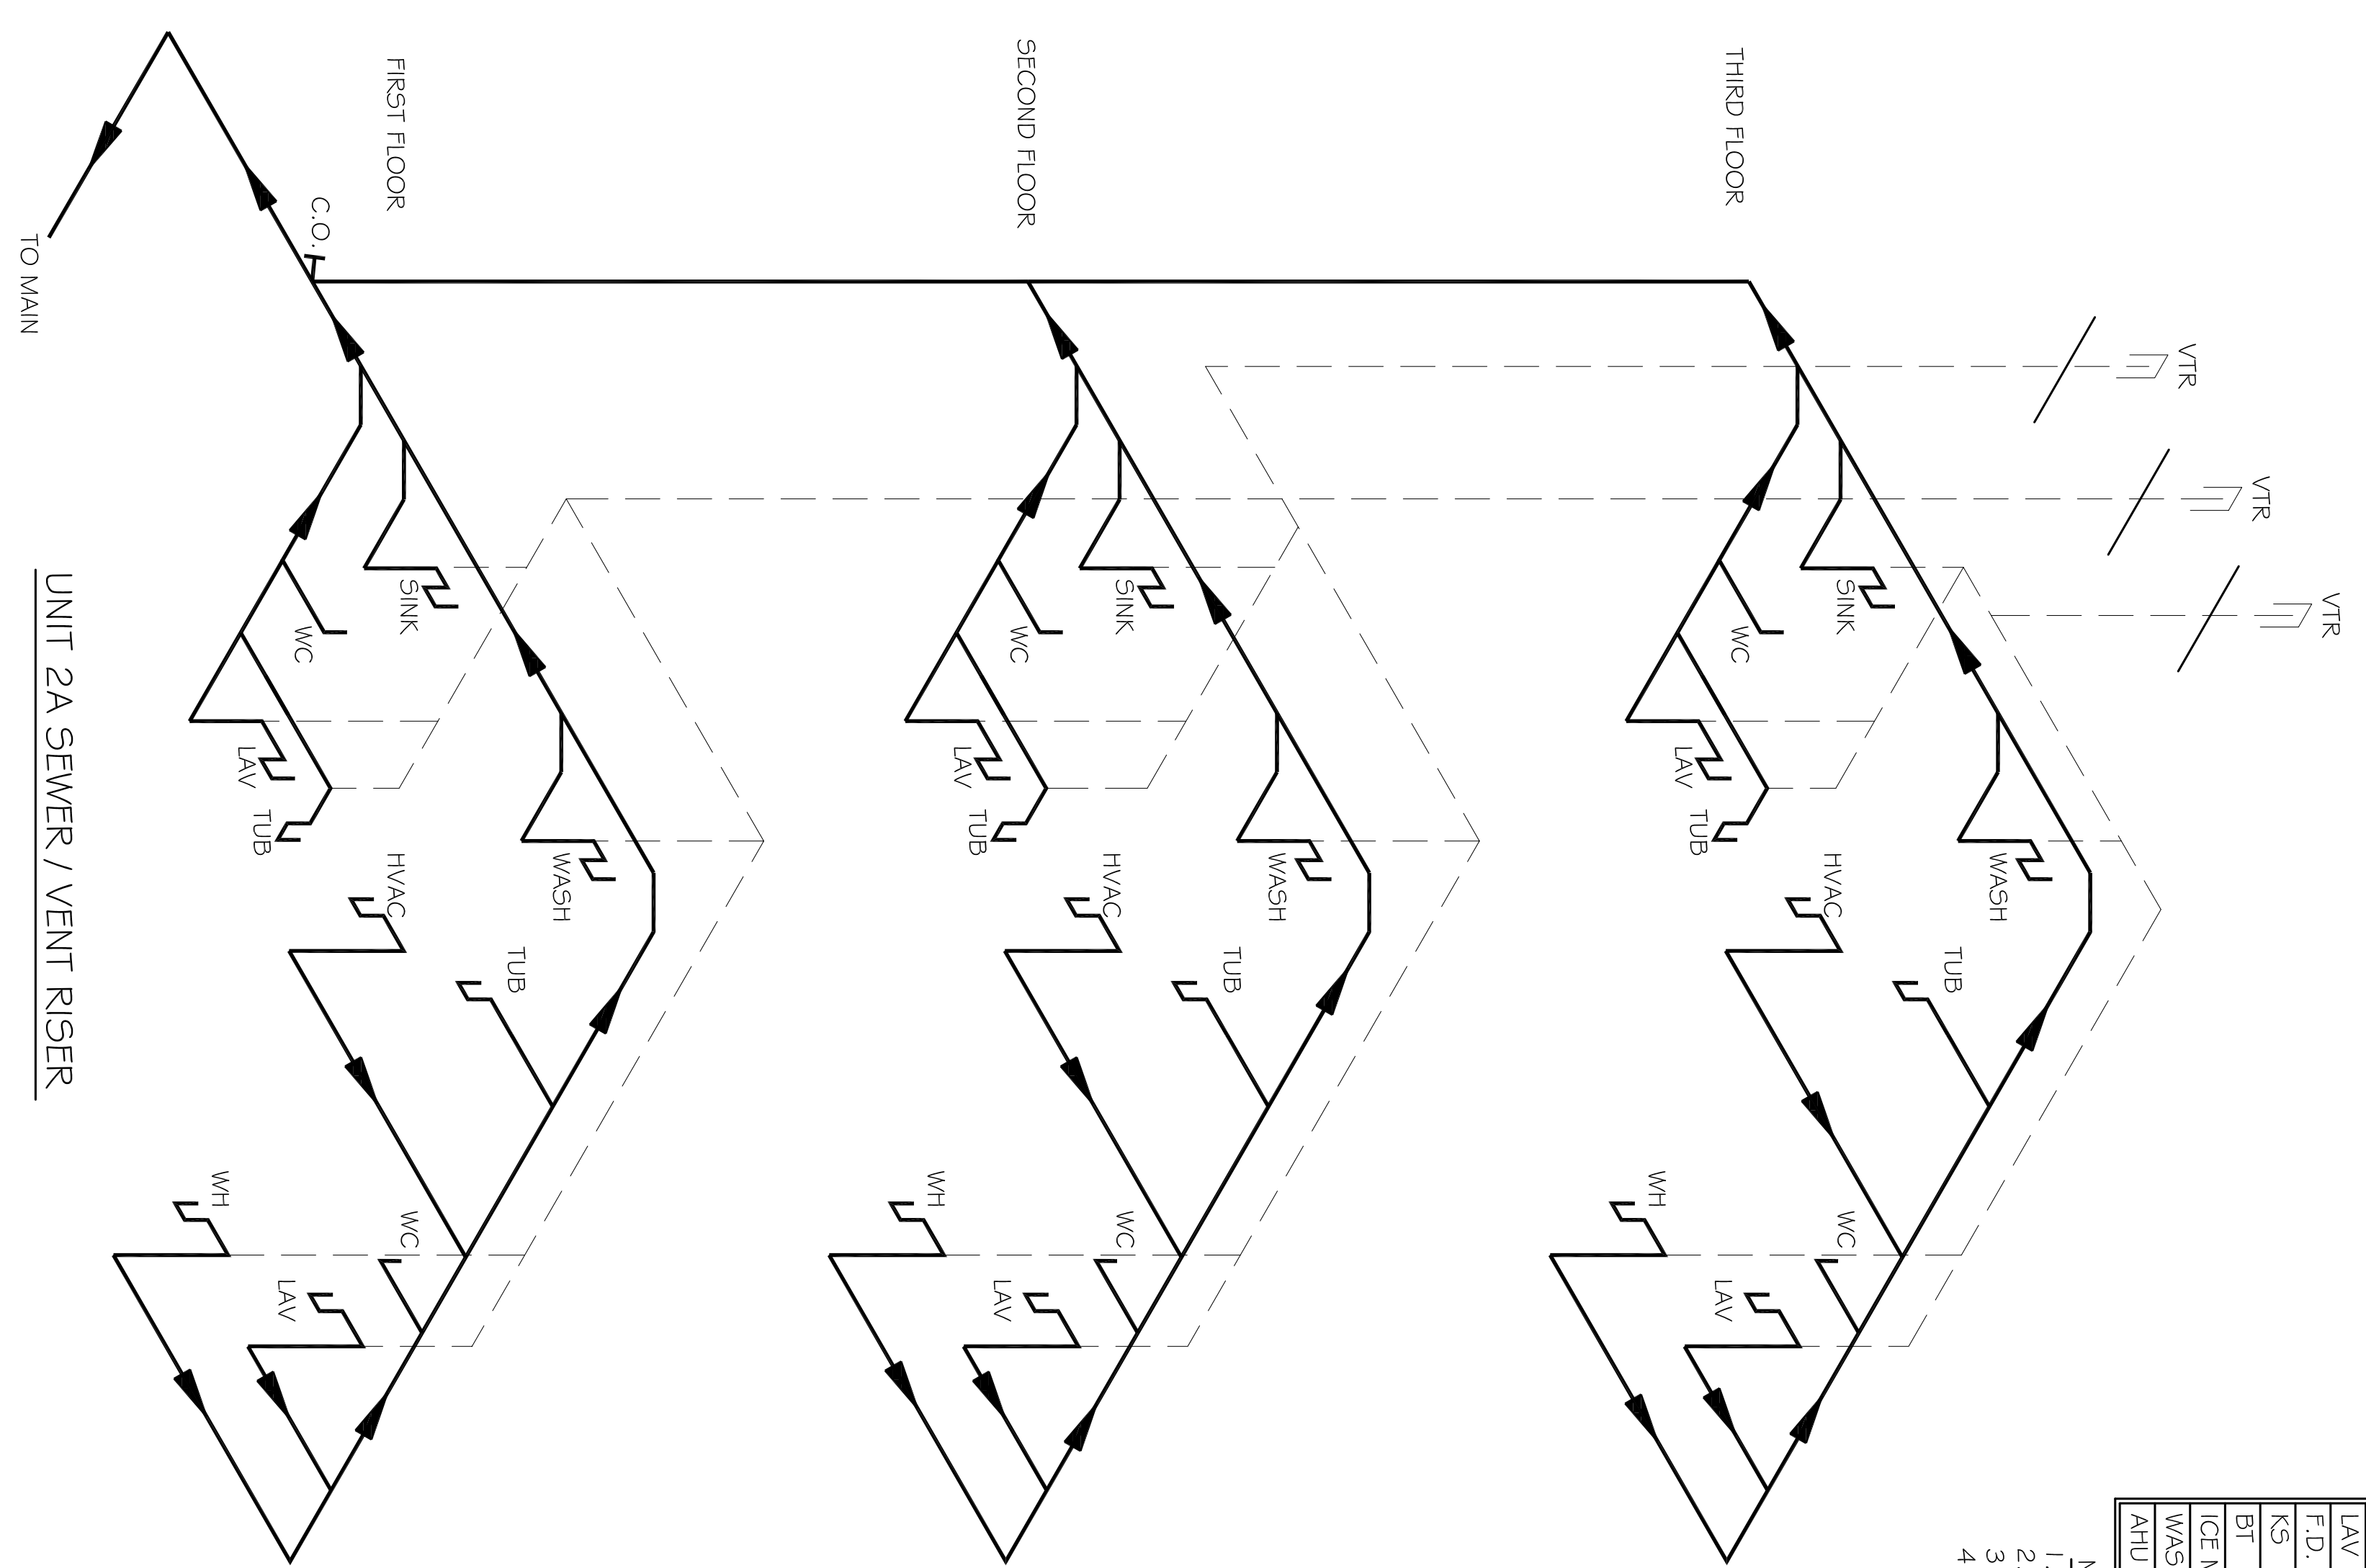

DAMMON ENGINEERING, INC.
 CHIEF ENGINEER
 EMMETT DAMMON, F.T.E.
 CHIEF ARCHITECT
 ROBERT WILTSE

1095 FLORIDA AVENUE
 SUITE 111, LA. 70455
 OFFICE: 504-955-5892
 FAX: 504-955-5930

WWW.DAMMONENGINEERING.COM
 EMAIL: DAMMONEN@BELLFLOWER.NET

ARCHITECTURE
 ENGINEERING
 STUDIES
 PLANNING
 INVESTIGATION
 EXPERT WITNESS

NEW APARTMENT COMPLEX

CROSSWINDS APARTMENTS
 HAMMOND, LA

UNITS 2A & 3A
 SEWER PLUMBING
 PLAN & RISERS

REV: 1-15-10

SCALE: AS NOTED
 JOB#: 08112.13
 DATE: 12-16-09
 SHEET