



TWO BEDROOM
UNIT 2A-HC MECHANICAL PLAN
SCALE: 3/4" = 1'-0"
1,324 SQ. FT.


- LEGEND**
- ☑ SUPPLY AIR VENT WITH FIRE DAMPER, CEILING MOUNTED
 - ☑ RETURN AIR GRILLE, WALL MOUNTED BELOW HVAC CLOSET DOOR, TYP. SEE PLAN FOR EXACT LOCATION
 - ☑ BATHROOM EXHAUST
 - ⊙ THERMOSTAT

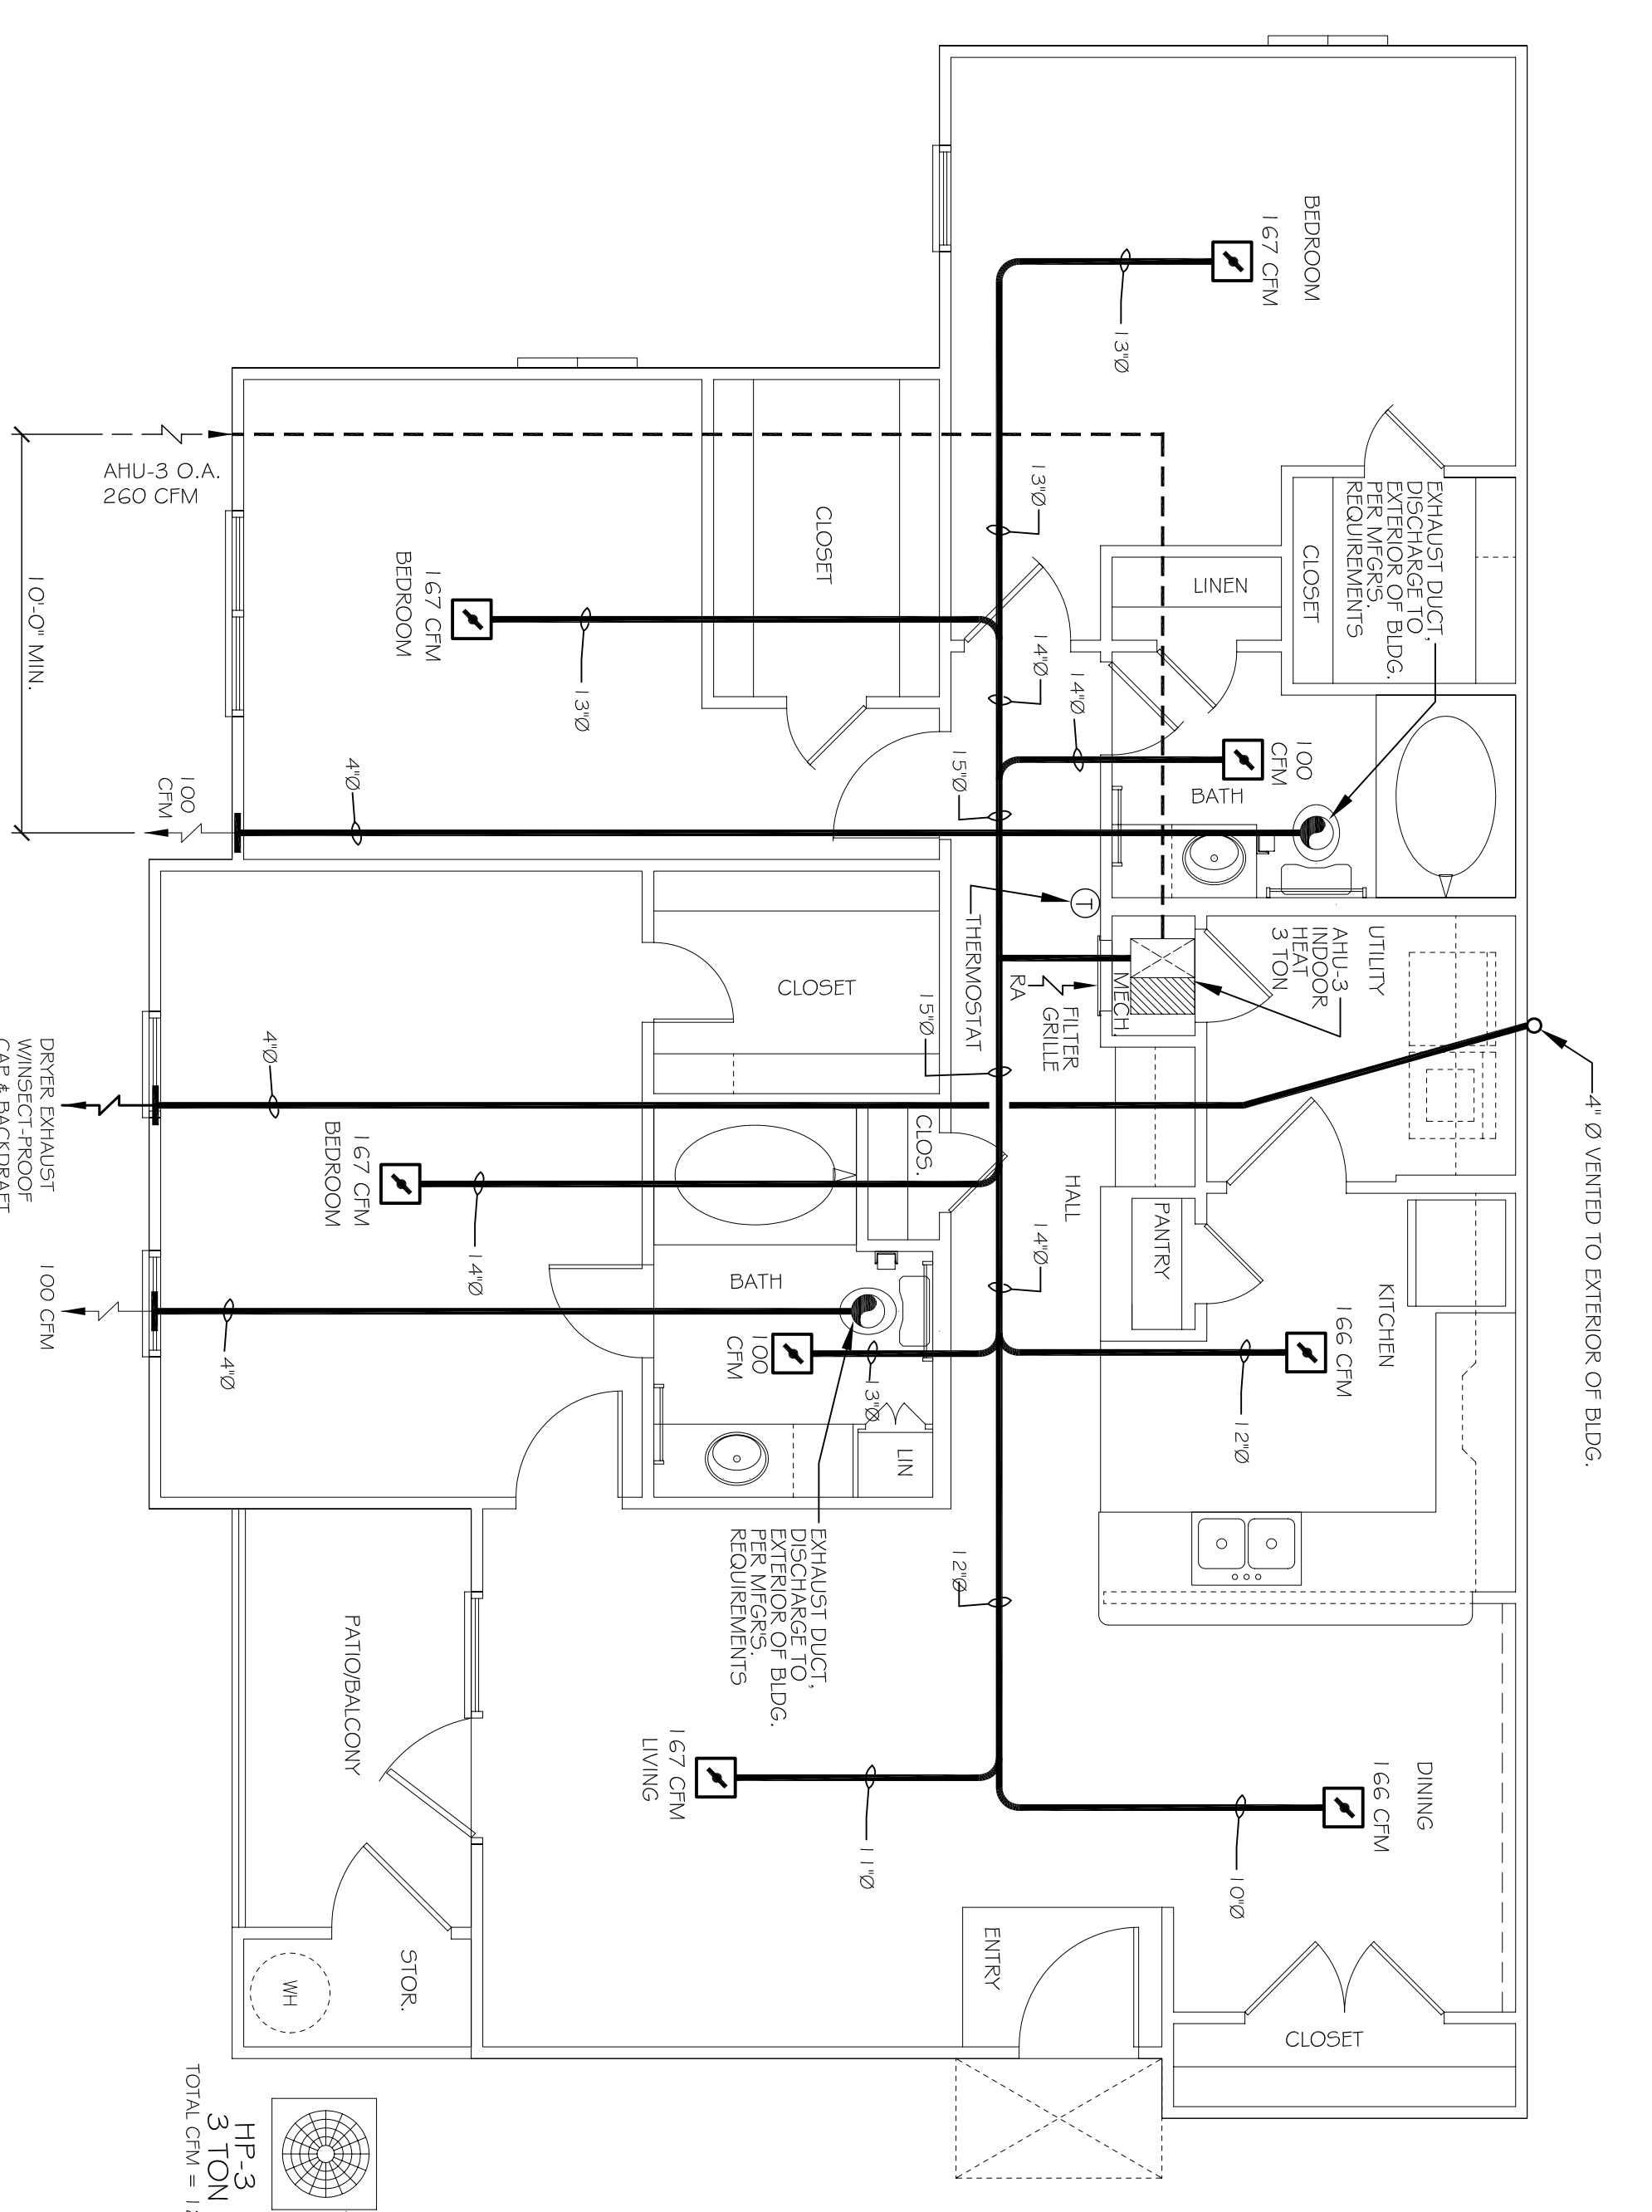

THREE BEDROOM
UNIT 3A MECHANICAL PLAN
SCALE: 3/4" = 1'-0"
1,482 SQ. FT.

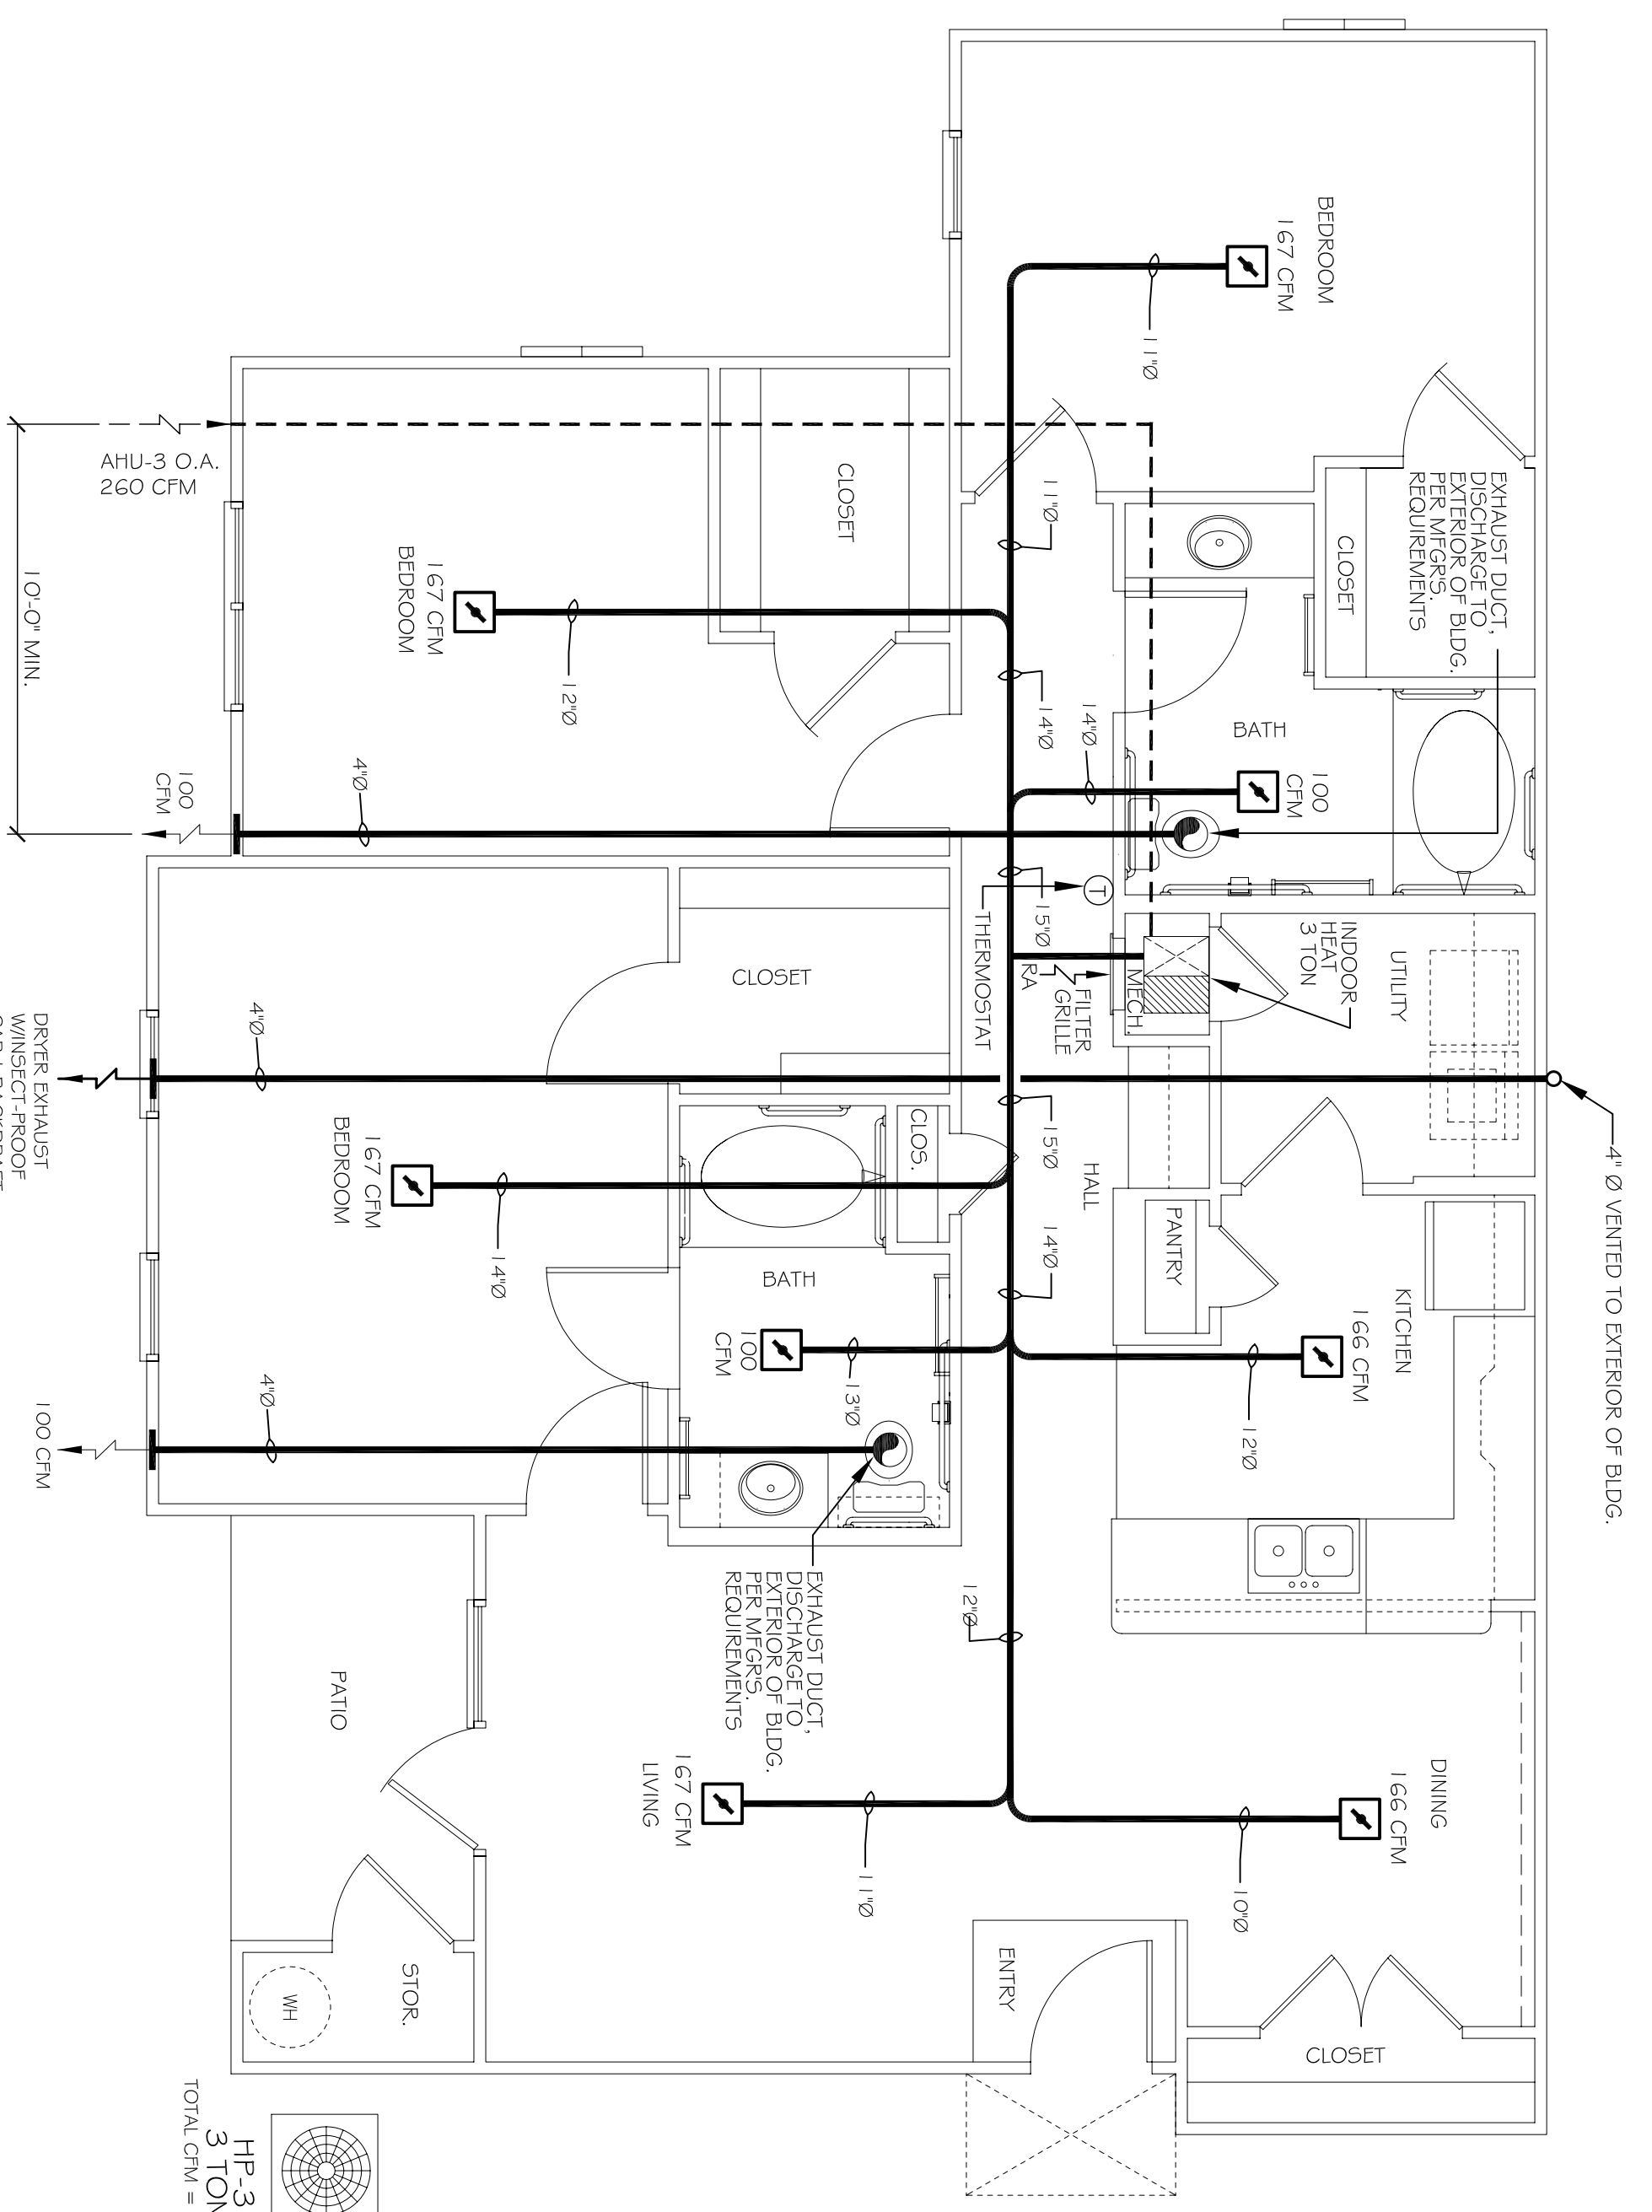

THREE BEDROOM
UNIT 3A-HC MECHANICAL PLAN
SCALE: 3/4" = 1'-0"
1,482 SQ. FT.

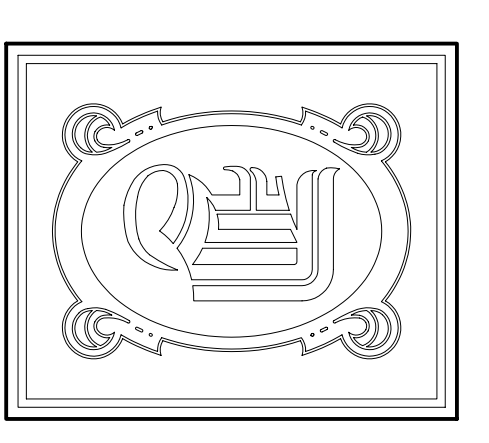

DAMMON ENGINEERING, INC.
 CHIEF ENGINEER
 EMAMETI DAMMON, P.E.
 CHIEF ARCHITECT
 ROBERT WILTSE

1095 FLORIDA AVENUE
 SUITE 11, LA. 70458
 OFFICE: 985-649-5832
 FAX: 985-641-5950

WEBSITE: WWW.DAMMONENGINEERING.COM
 EMAIL: DAMMONENR@BRLDOUTH.NET

ARCHITECTURE
 ENGINEERING
 STUDIES
 PLANNING
 INVESTIGATION
 EXPERT WITNESS

NEW APARTMENT COMPLEX

CROSSWINDS APARTMENTS HAMMOND, LA

UNITS 2A-HC, 3A & 3A-HC MECHANICAL PLAN

REV:	SCALE: AS NOTED
JOB#: 08112.13	DATE: 12-16-09
SHEET	
M-4	
OF	