

DAMMON
ENGINEERING, INC.

CHIEF ENGINEER
EMMETT
DAMMON, P.E.
CHIEF ARCHITECT
ROBERT
WILTSE

1095 FLORIDA AVENUE
SLIDELL, LA. 70458
OFFICE: 985-649-5632
FAX: 985-641-5950

WEBSITE:
WWW.DAMMONENGINEERING.COM
EMAIL:
DAMMONENG@BLSOUTH.NET

ARCHITECTURE
ENGINEERING
STUDIES
PLANNING
INVESTIGATION
EXPERT WITNESS

NEW
APARTMENT
COMPLEX

CROSSWINDS
APARTMENTS
HAMMOND, LA

LEASING BLDG./
CLUBHOUSE
FIRST FLOOR
MECHANICAL PLAN

REV:
SCALE: AS NOTED


JOB#: 08112.13

DATE: 12-16-09


SHEET

M-5

OF

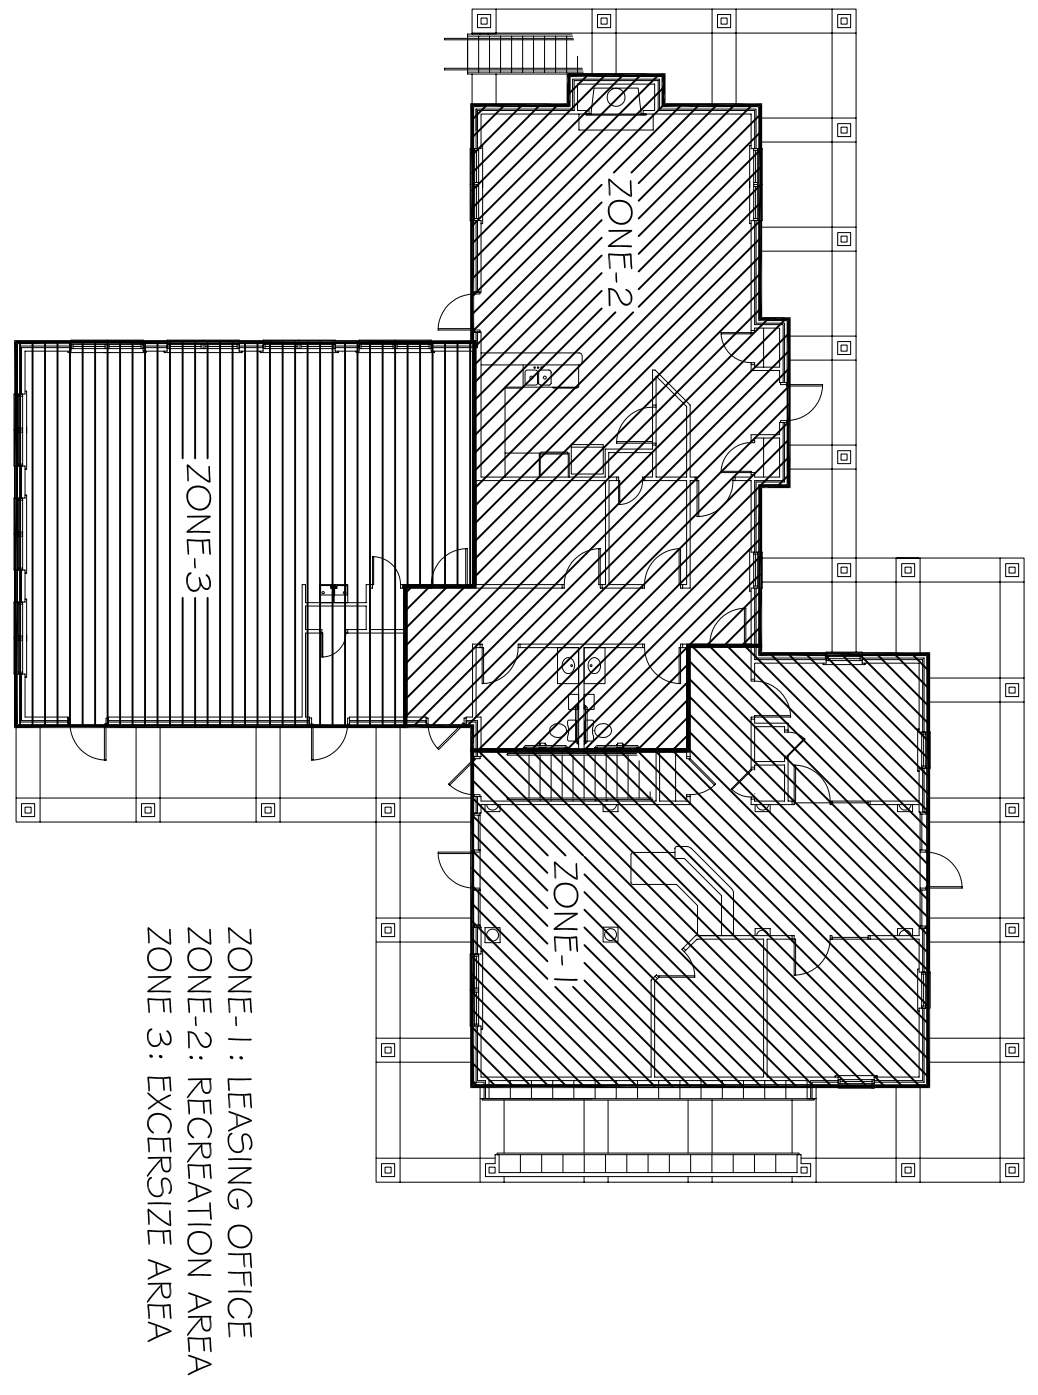

LEASING BLDG./CLUBHOUSE
1ST FLOOR MECHANICAL KEY PLAN
SCALE: NTS

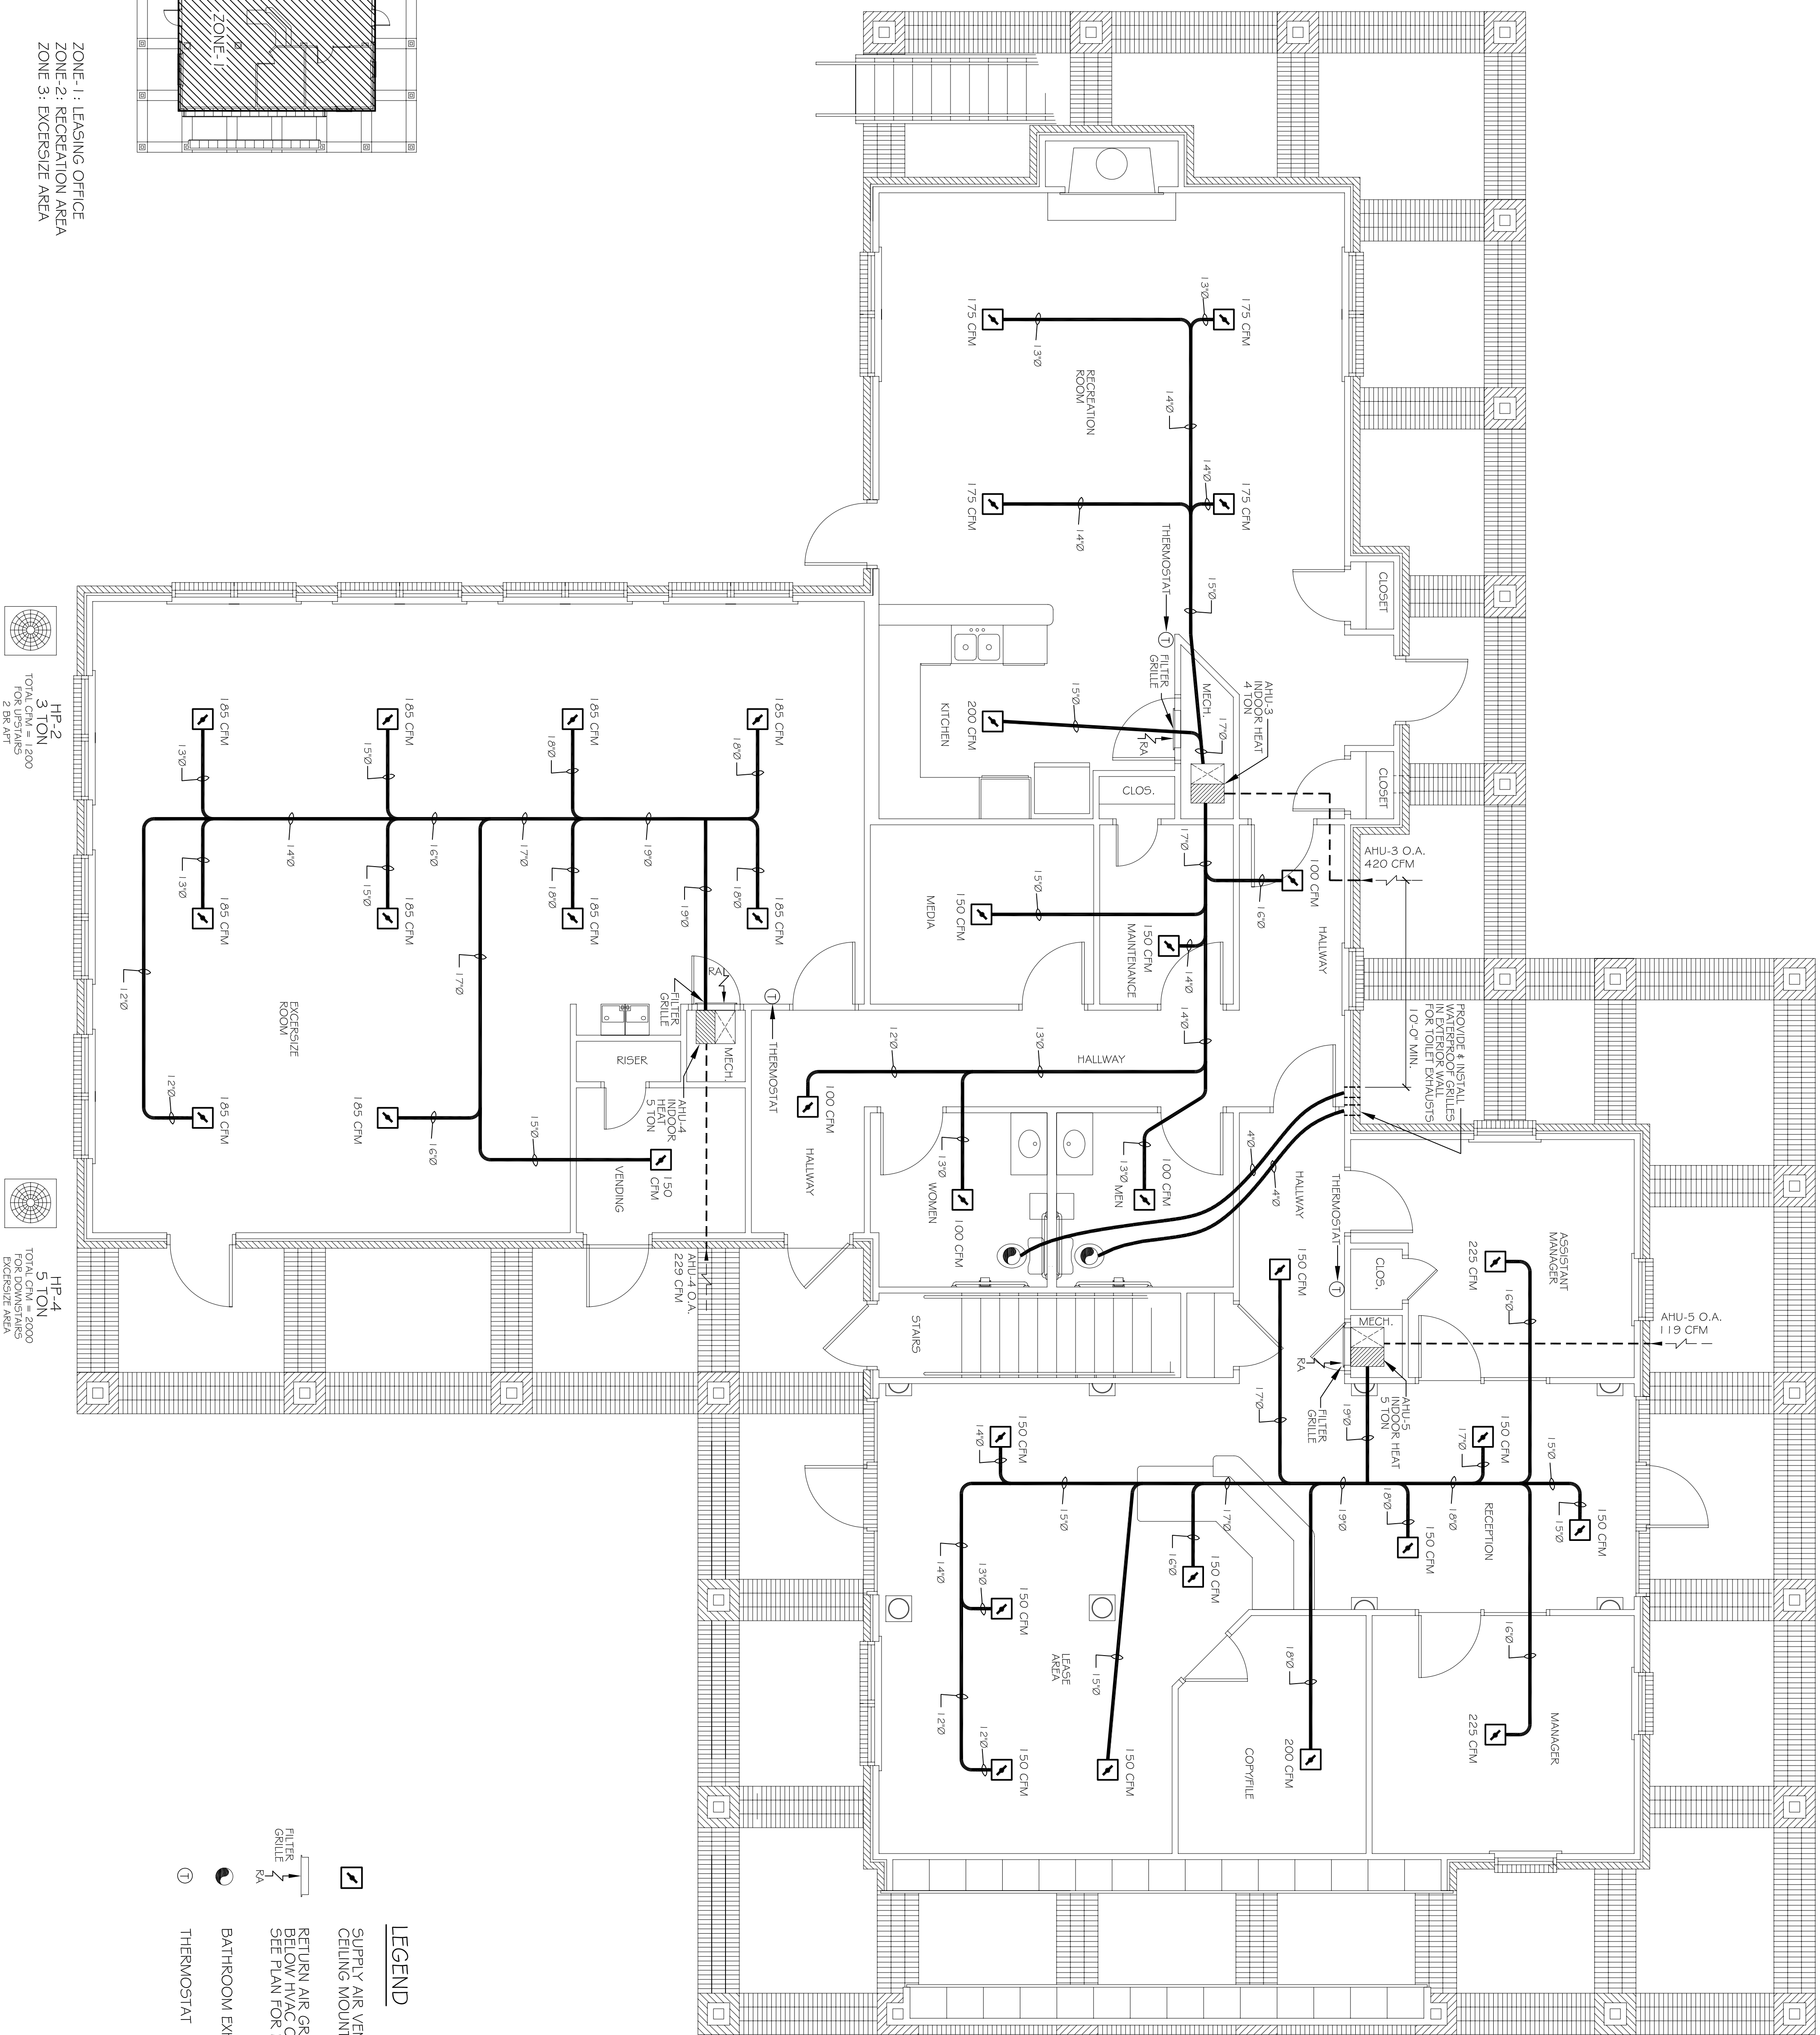

- LEGEND**
- ☑ SUPPLY AIR VENT WITH FIRE DAMPER, CEILING MOUNTED
 - ☐ RETURN AIR GRILLE WALL MOUNTED BELOW HANG CLOSEST TO ROOM. SEE PLAN FOR EXACT LOCATION.
 - ☉ BATHROOM EXHAUST
 - ⊙ THERMOSTAT

LEASING BLDG./CLUBHOUSE
1ST FLOOR MECHANICAL PLAN
SCALE: 1/4"=1'-0"
3,767 SQ. FT.

