

**DAMMON**  
ENGINEERING, INC.

CHIEF ENGINEER  
EMMETT  
DAMMON, P.E.  
CHIEF ARCHITECT  
ROBERT  
WILTSE

1095 FLORIDA AVENUE  
SLIDELL, LA, 70458  
OFFICE: 985-649-5632  
FAX: 985-641-5950

WEBSITE:  
WWW.DAMMONENGINEERING.COM  
EMAIL:  
DAMMONENG@BRLDOUTH.NET


ARCHITECTURE  
ENGINEERING  
STUDIES  
PLANNING  
INVESTIGATION  
EXPERT WITNESS

NEW  
APARTMENT  
COMPLEX



CROSSWINDS  
APARTMENTS  
HAMMOND, LA

LEASING BLDG. /  
CLUBHOUSE  
SECOND FLOOR  
MECHANICAL PLAN

REV:	
SCALE:	AS NOTED
JOB#:	08112.13
DATE:	12-16-09
SHEET	M-6
OF	

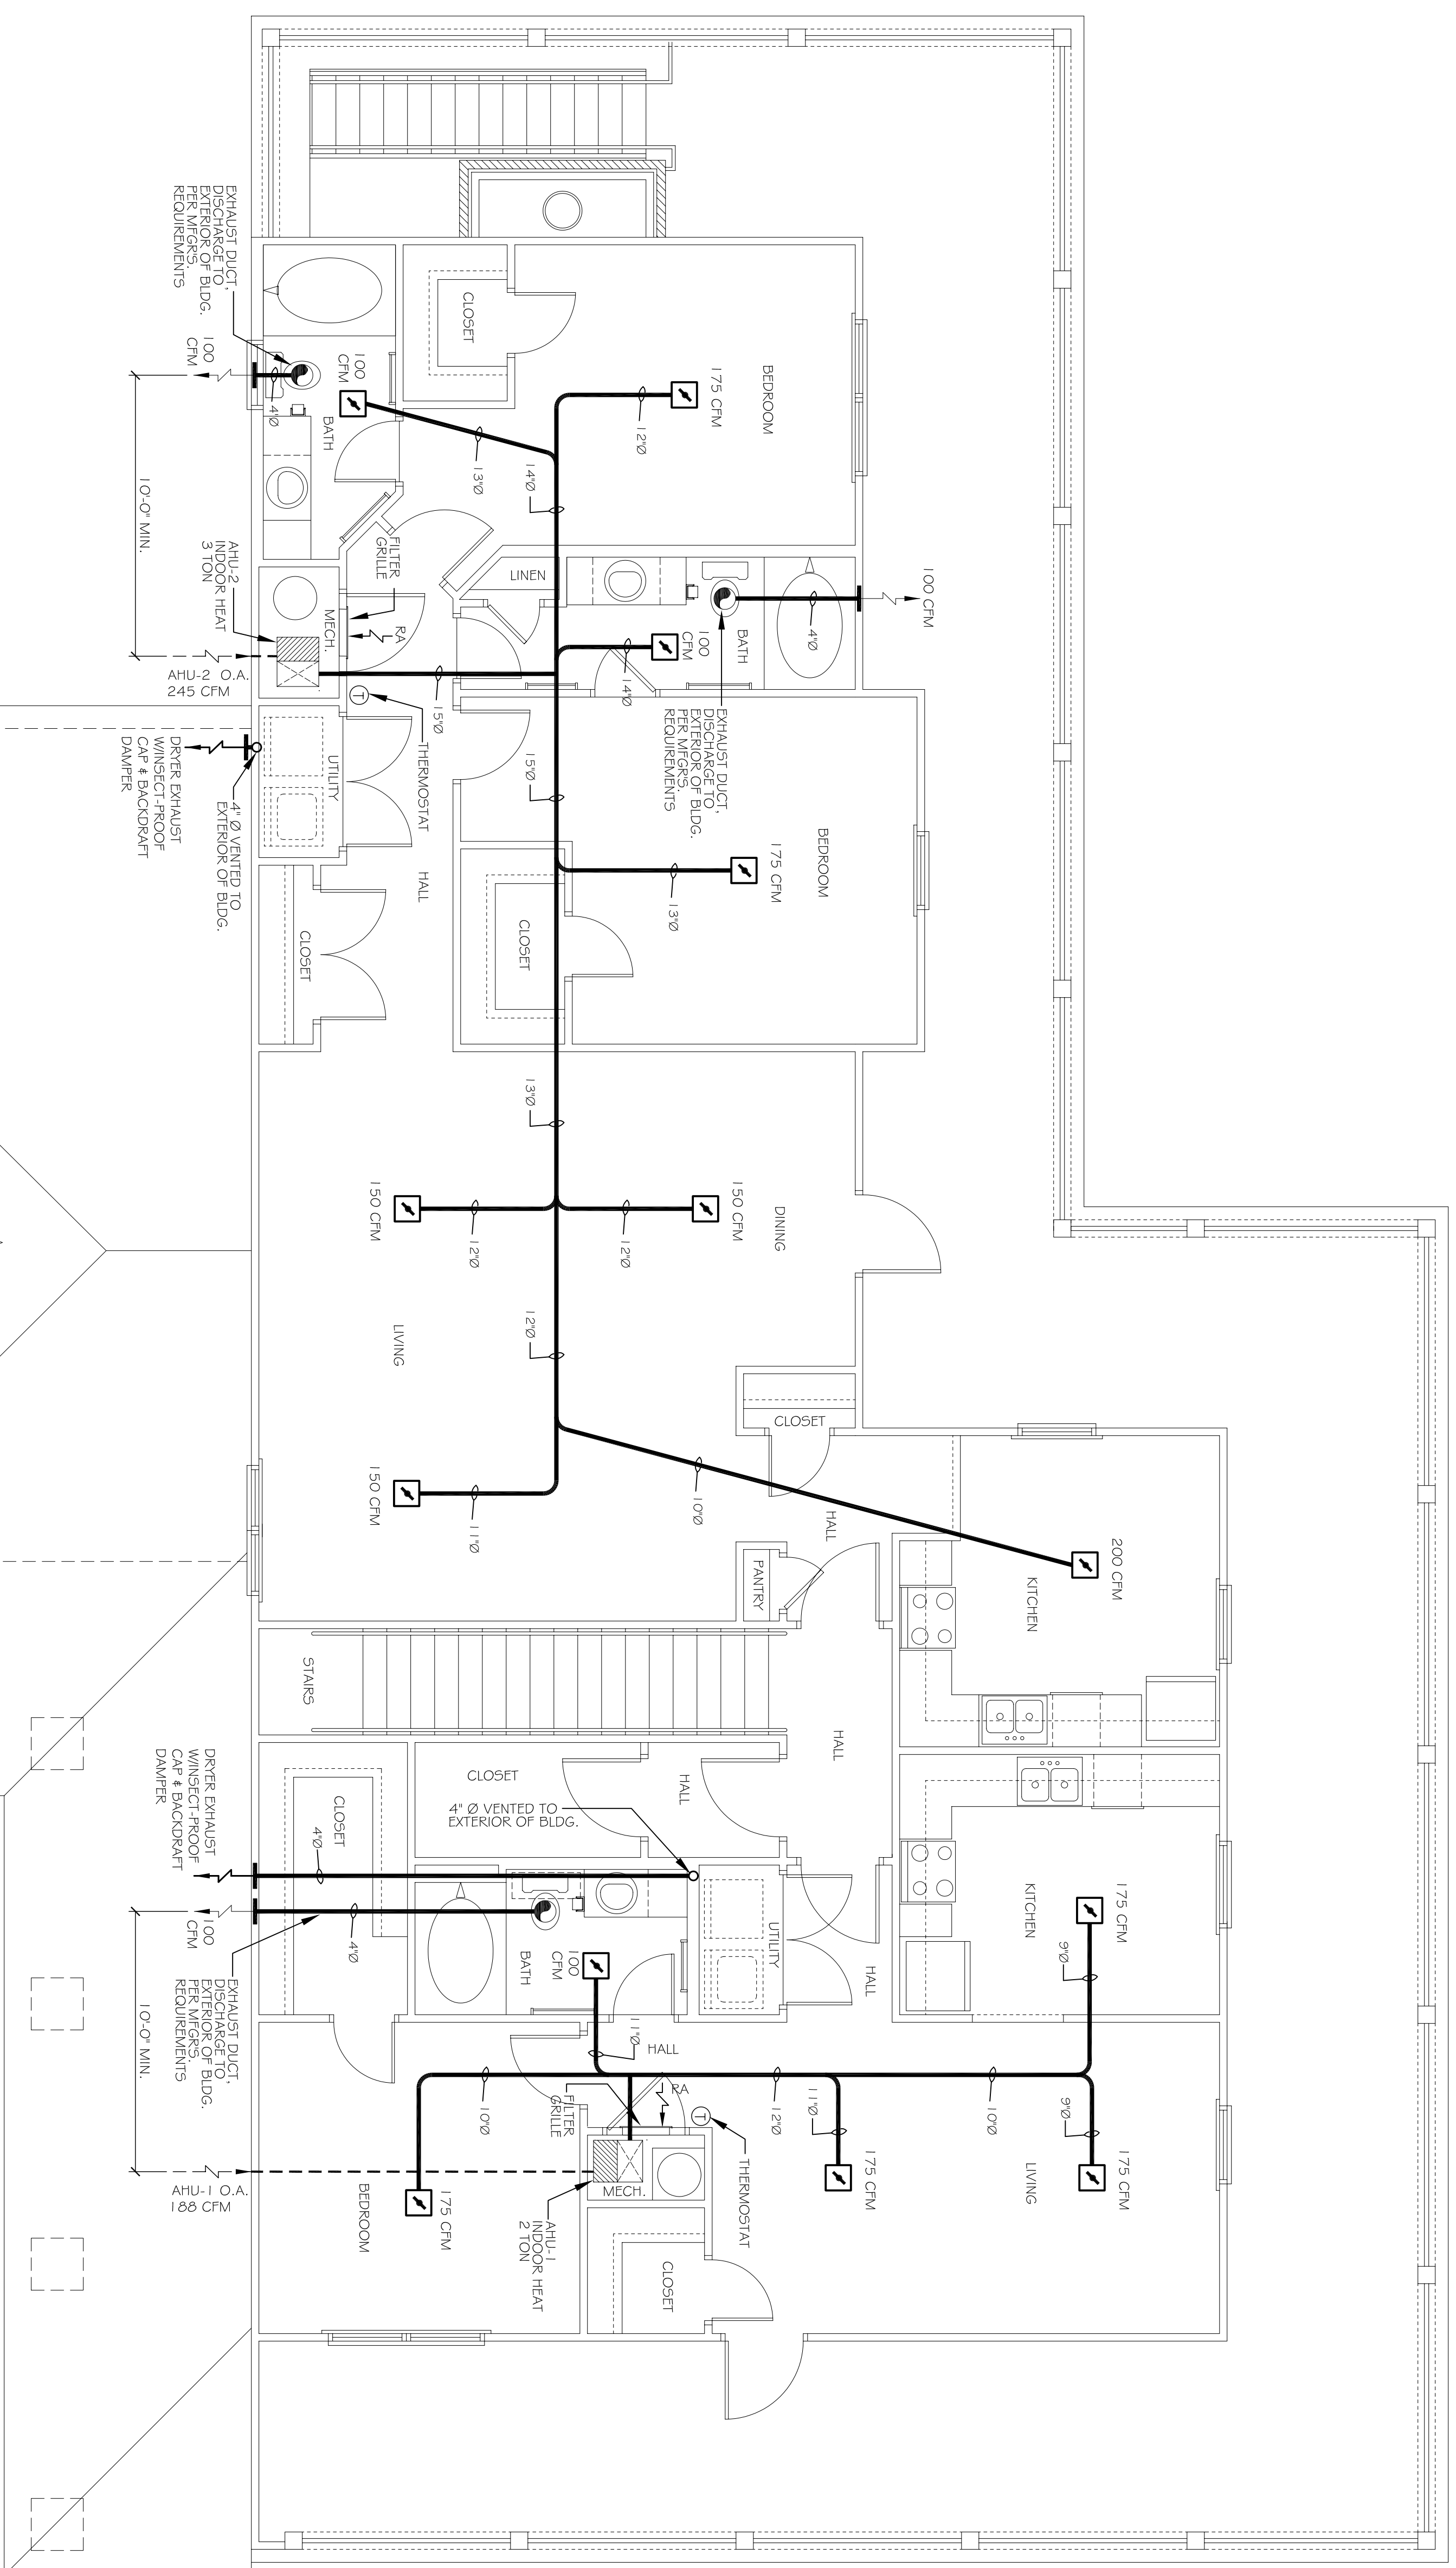

LEASING BLDG./CLUBHOUSE  
2ND FLOOR MECHANICAL PLAN  
SCALE: 1/4" = 1'-0"  
2,447 SQ. FT.

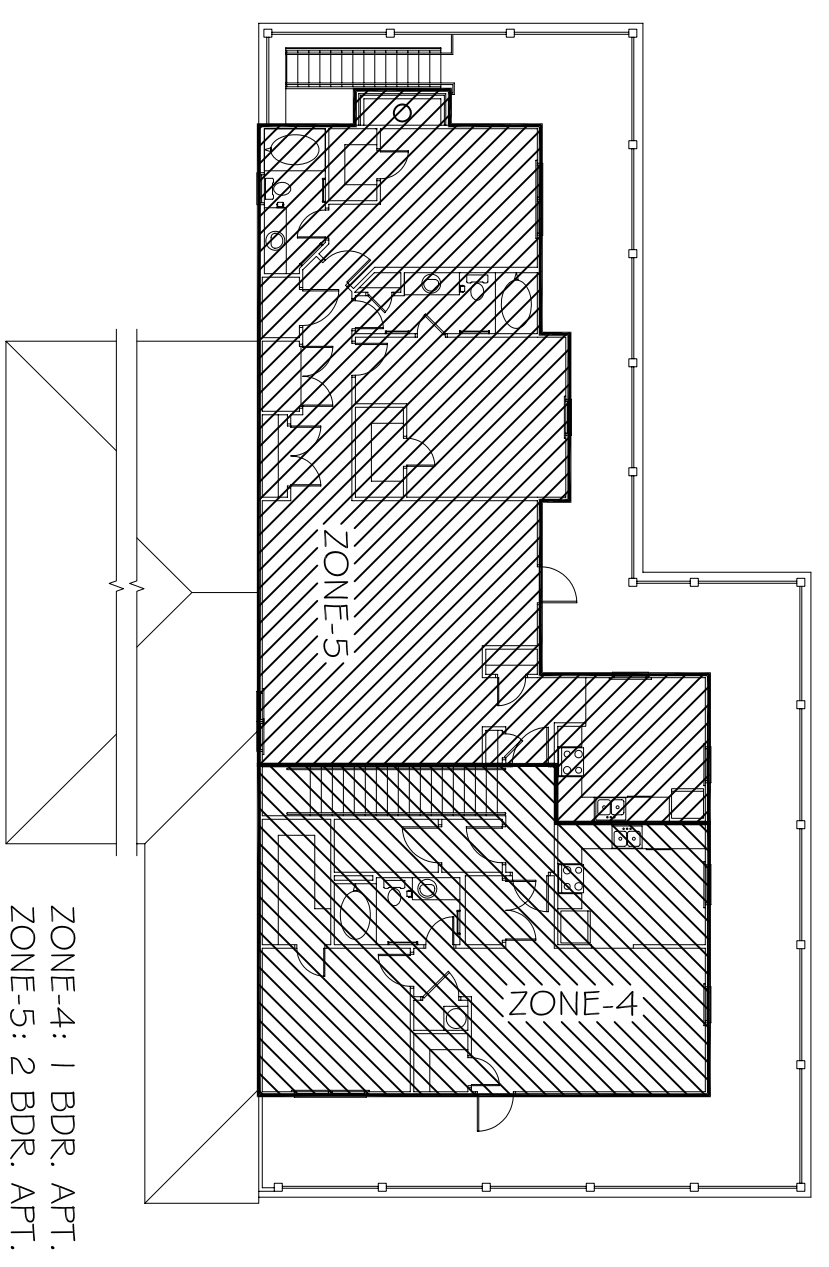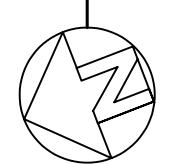

LEASING BLDG./CLUBHOUSE  
2ND FLOOR MECHANICAL KEY PLAN  
SCALE: NTS

- LEGEND**
- ☑ SUPPLY AIR VENT WITH FIRE DAMPER, CEILING MOUNTED
  - ▭ RETURN AIR GRILLE, WALL MOUNTED BELOW HVAC CLOSEST DOOR, TYP. SEE PLAN FOR EXACT LOCATION
  - ⊙ BATHROOM EXHAUST
  - ⊙ THERMOSTAT
  - ⊙ FILTER GRILLE
  - ⊙ FA