

DAMMON
ENGINEERING, INC.

CHIEF ENGINEER
DAMON, P.E.
CHIEF ARCHITECT
ROBERT
WILTSE

1095 FLORIDA AVENUE
SUITE 114, L.A. 70453
OFFICE: 504-264-5932
FAX: 504-641-5930


WEBSITE:
WWW.DAMMONENGINEERING.COM
EMAIL: DAMMON@BLSOUTH.NET

ARCHITECTURE
ENGINEERING
STUDIES
PLANNING
INVESTIGATION
EXPERT WITNESS


NEW
APARTMENT
COMPLEX

CROSSWINDS
APARTMENTS
HAMMOND, LA

BLDG. 1, 2, 3,
5 & 6
PLUMBING PLAN

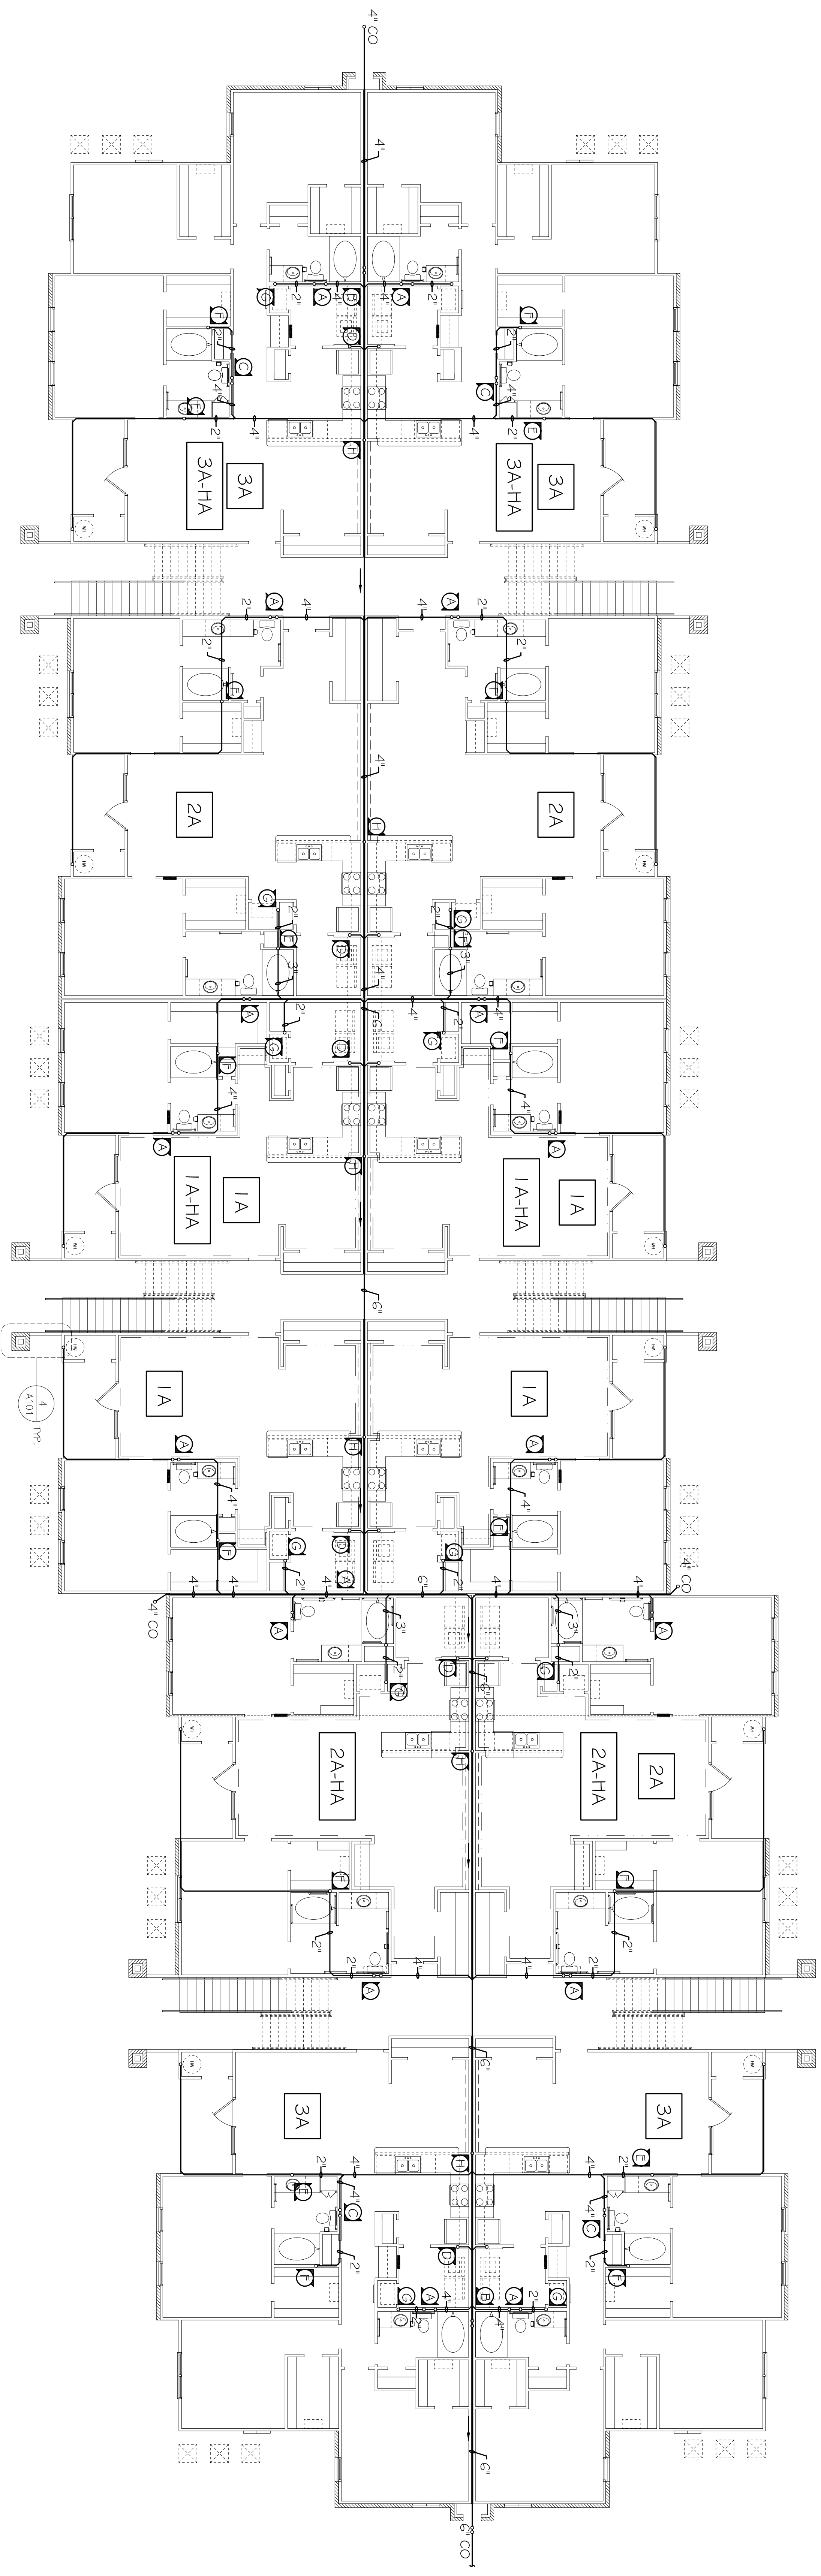

BLDG. 1, 2, 5 & 6 1ST
FLOOR PLUMBING PLAN
SCALE: 1/8"=1'-0"

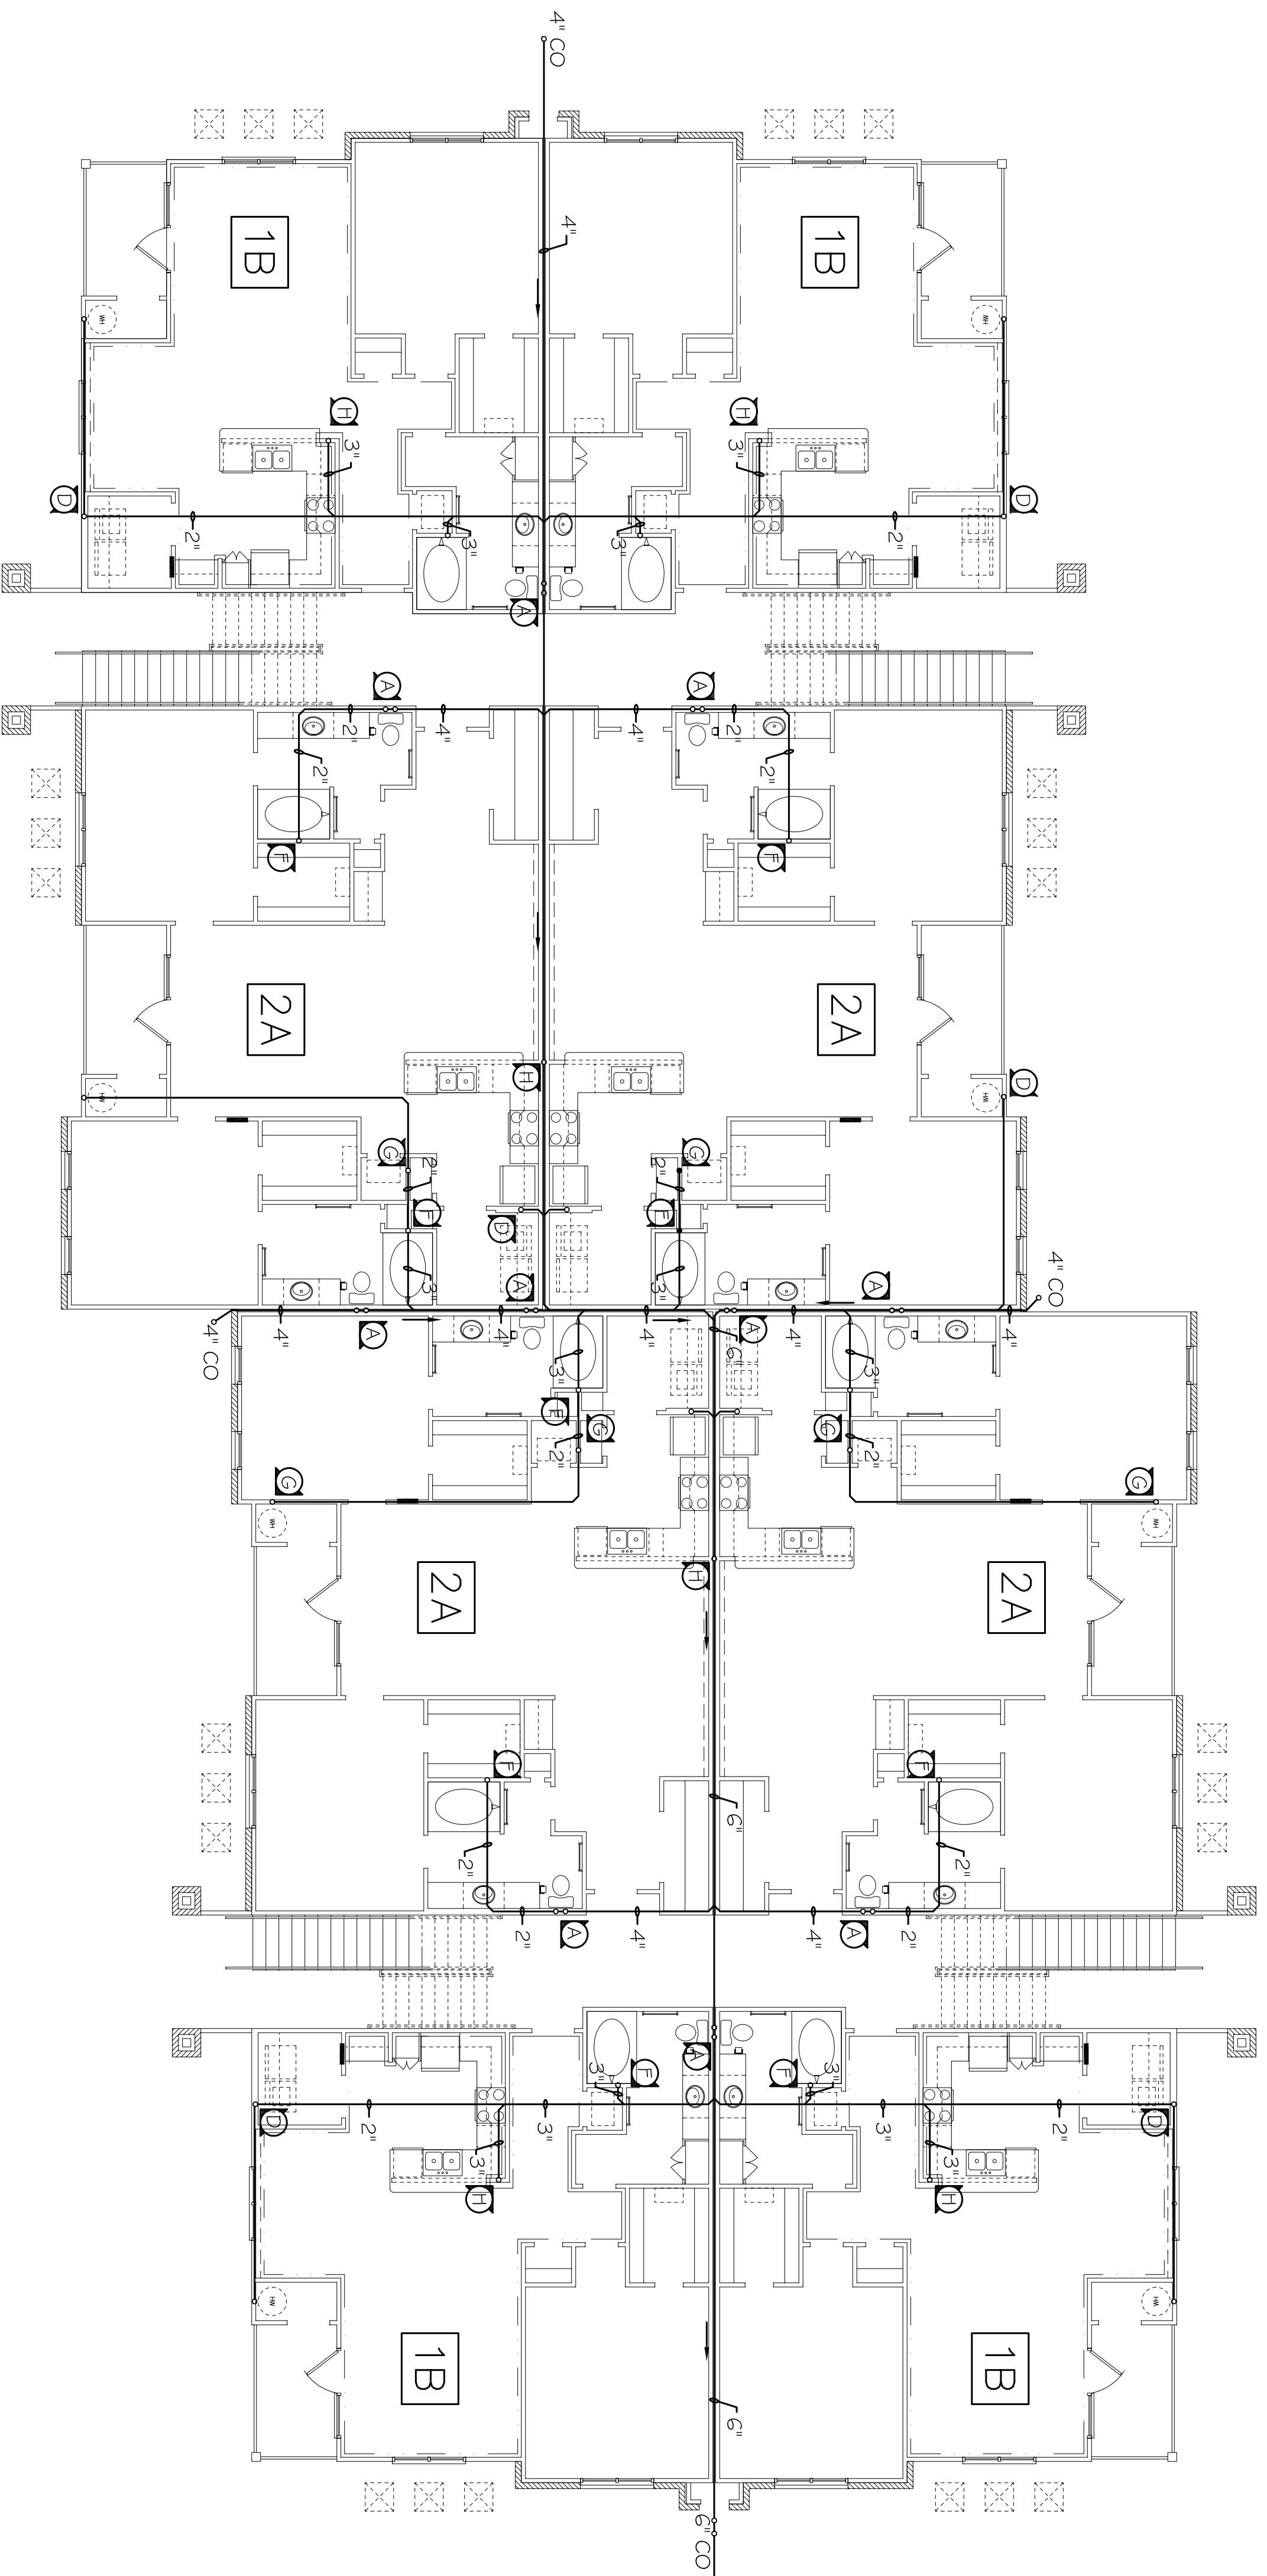

BLDG. 3 1ST FLOOR
PLUMBING PLAN
SCALE: 1/8"=1'-0"

LEGEND
TYPICAL VENT RISER DESIGNATION,
SEE DWG. P-5

REV:

SCALE: AS NOTED

JOB#: 08112.13

DATE: 12-16-09

SHEET

P-2

OF