

**DAMMON**  
ENGINEERING, INC.

CHIEF ENGINEER  
EMMETT  
DAMMON, P.E.  
CHIEF ARCHITECT  
ROBERT  
WILTSE

1095 FLORIDA AVENUE  
SUITE L, LA. 70458  
OFFICE: 985-649-5832  
FAX: 985-641-5950

WEBSITE:  
WWW.DAMMONENGINEERING.COM  
EMAIL:  
DAMMONENG@BELLSOUTH.NET

ARCHITECTURE  
ENGINEERING  
STUDIES  
PLANNING  
INVESTIGATION  
EXPERT WITNESS

NEW/  
APARTMENT  
COMPLEX

CROSSWINDS  
APARTMENTS  
HAMMOND, LA

LEASING  
BLDG.  
PLUMBING PLAN  
AND RISERS

REV:

SCALE: AS NOTED


JOB#: 08112.13

DATE: 12-16-09


SHEET

P-4


OF

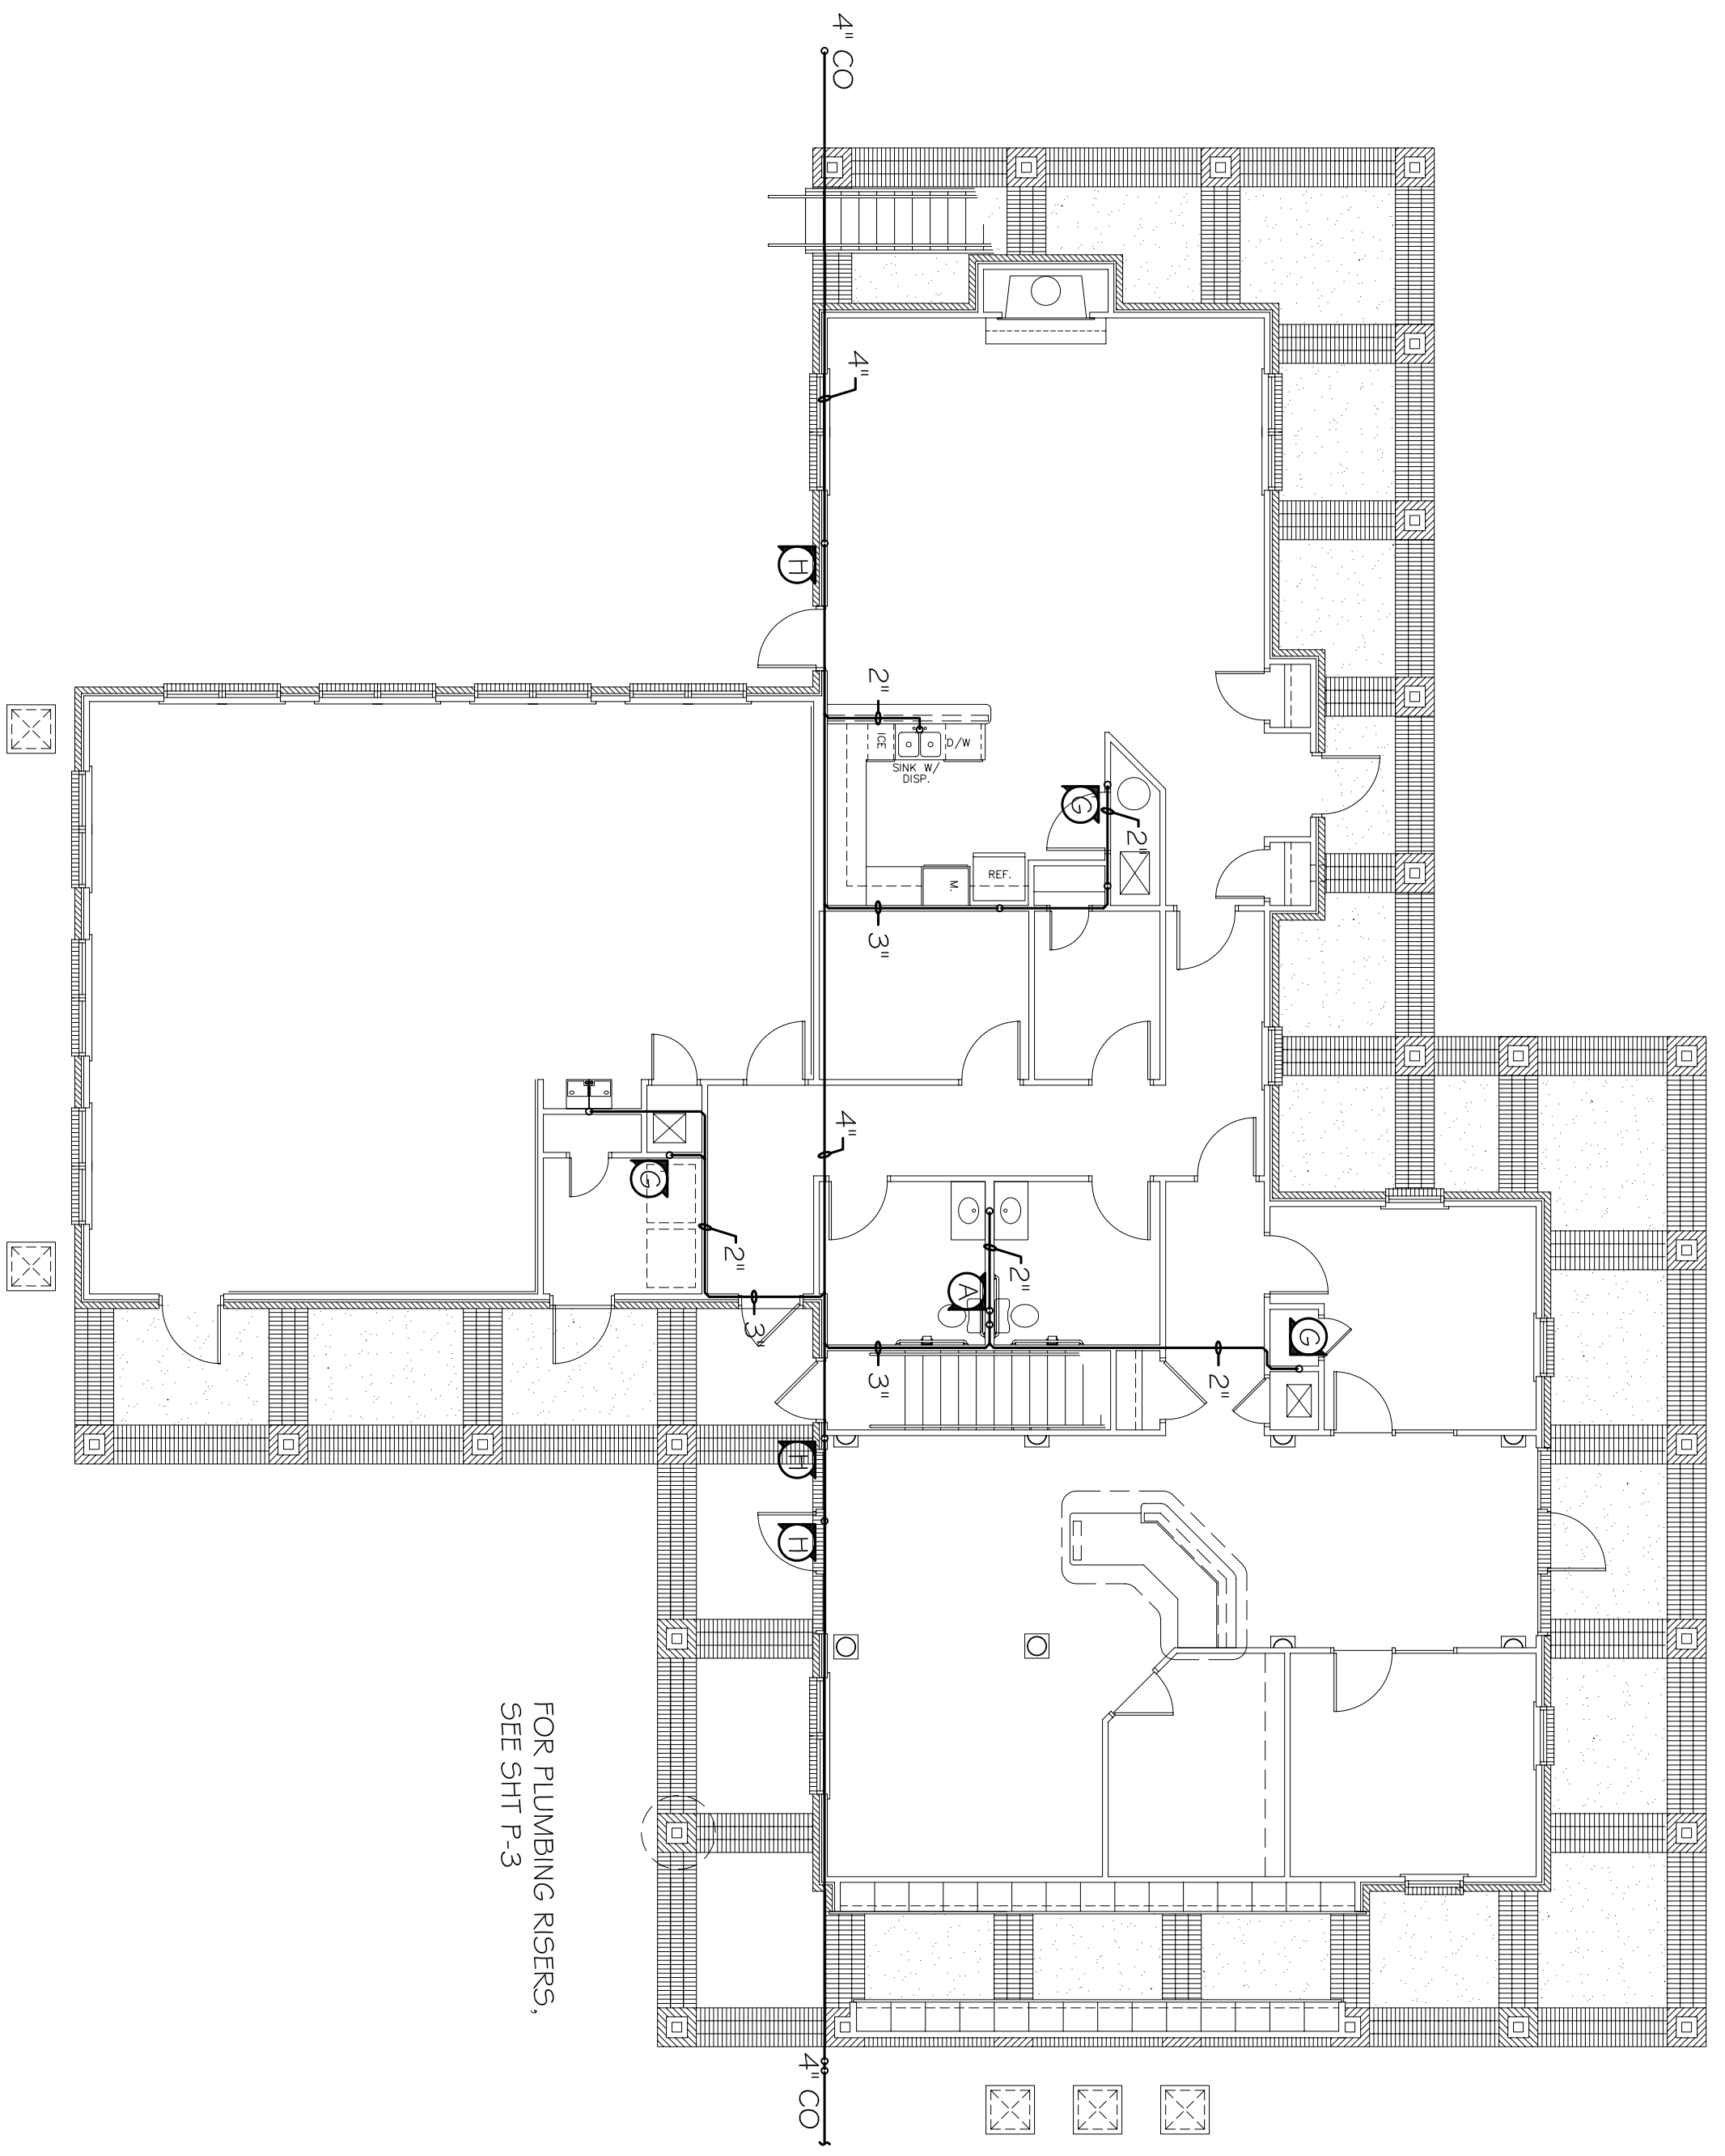


LEASING BLDG. 1ST FLOOR  
PLUMBING PLAN  
SCALE: 1/8"=1'-0"

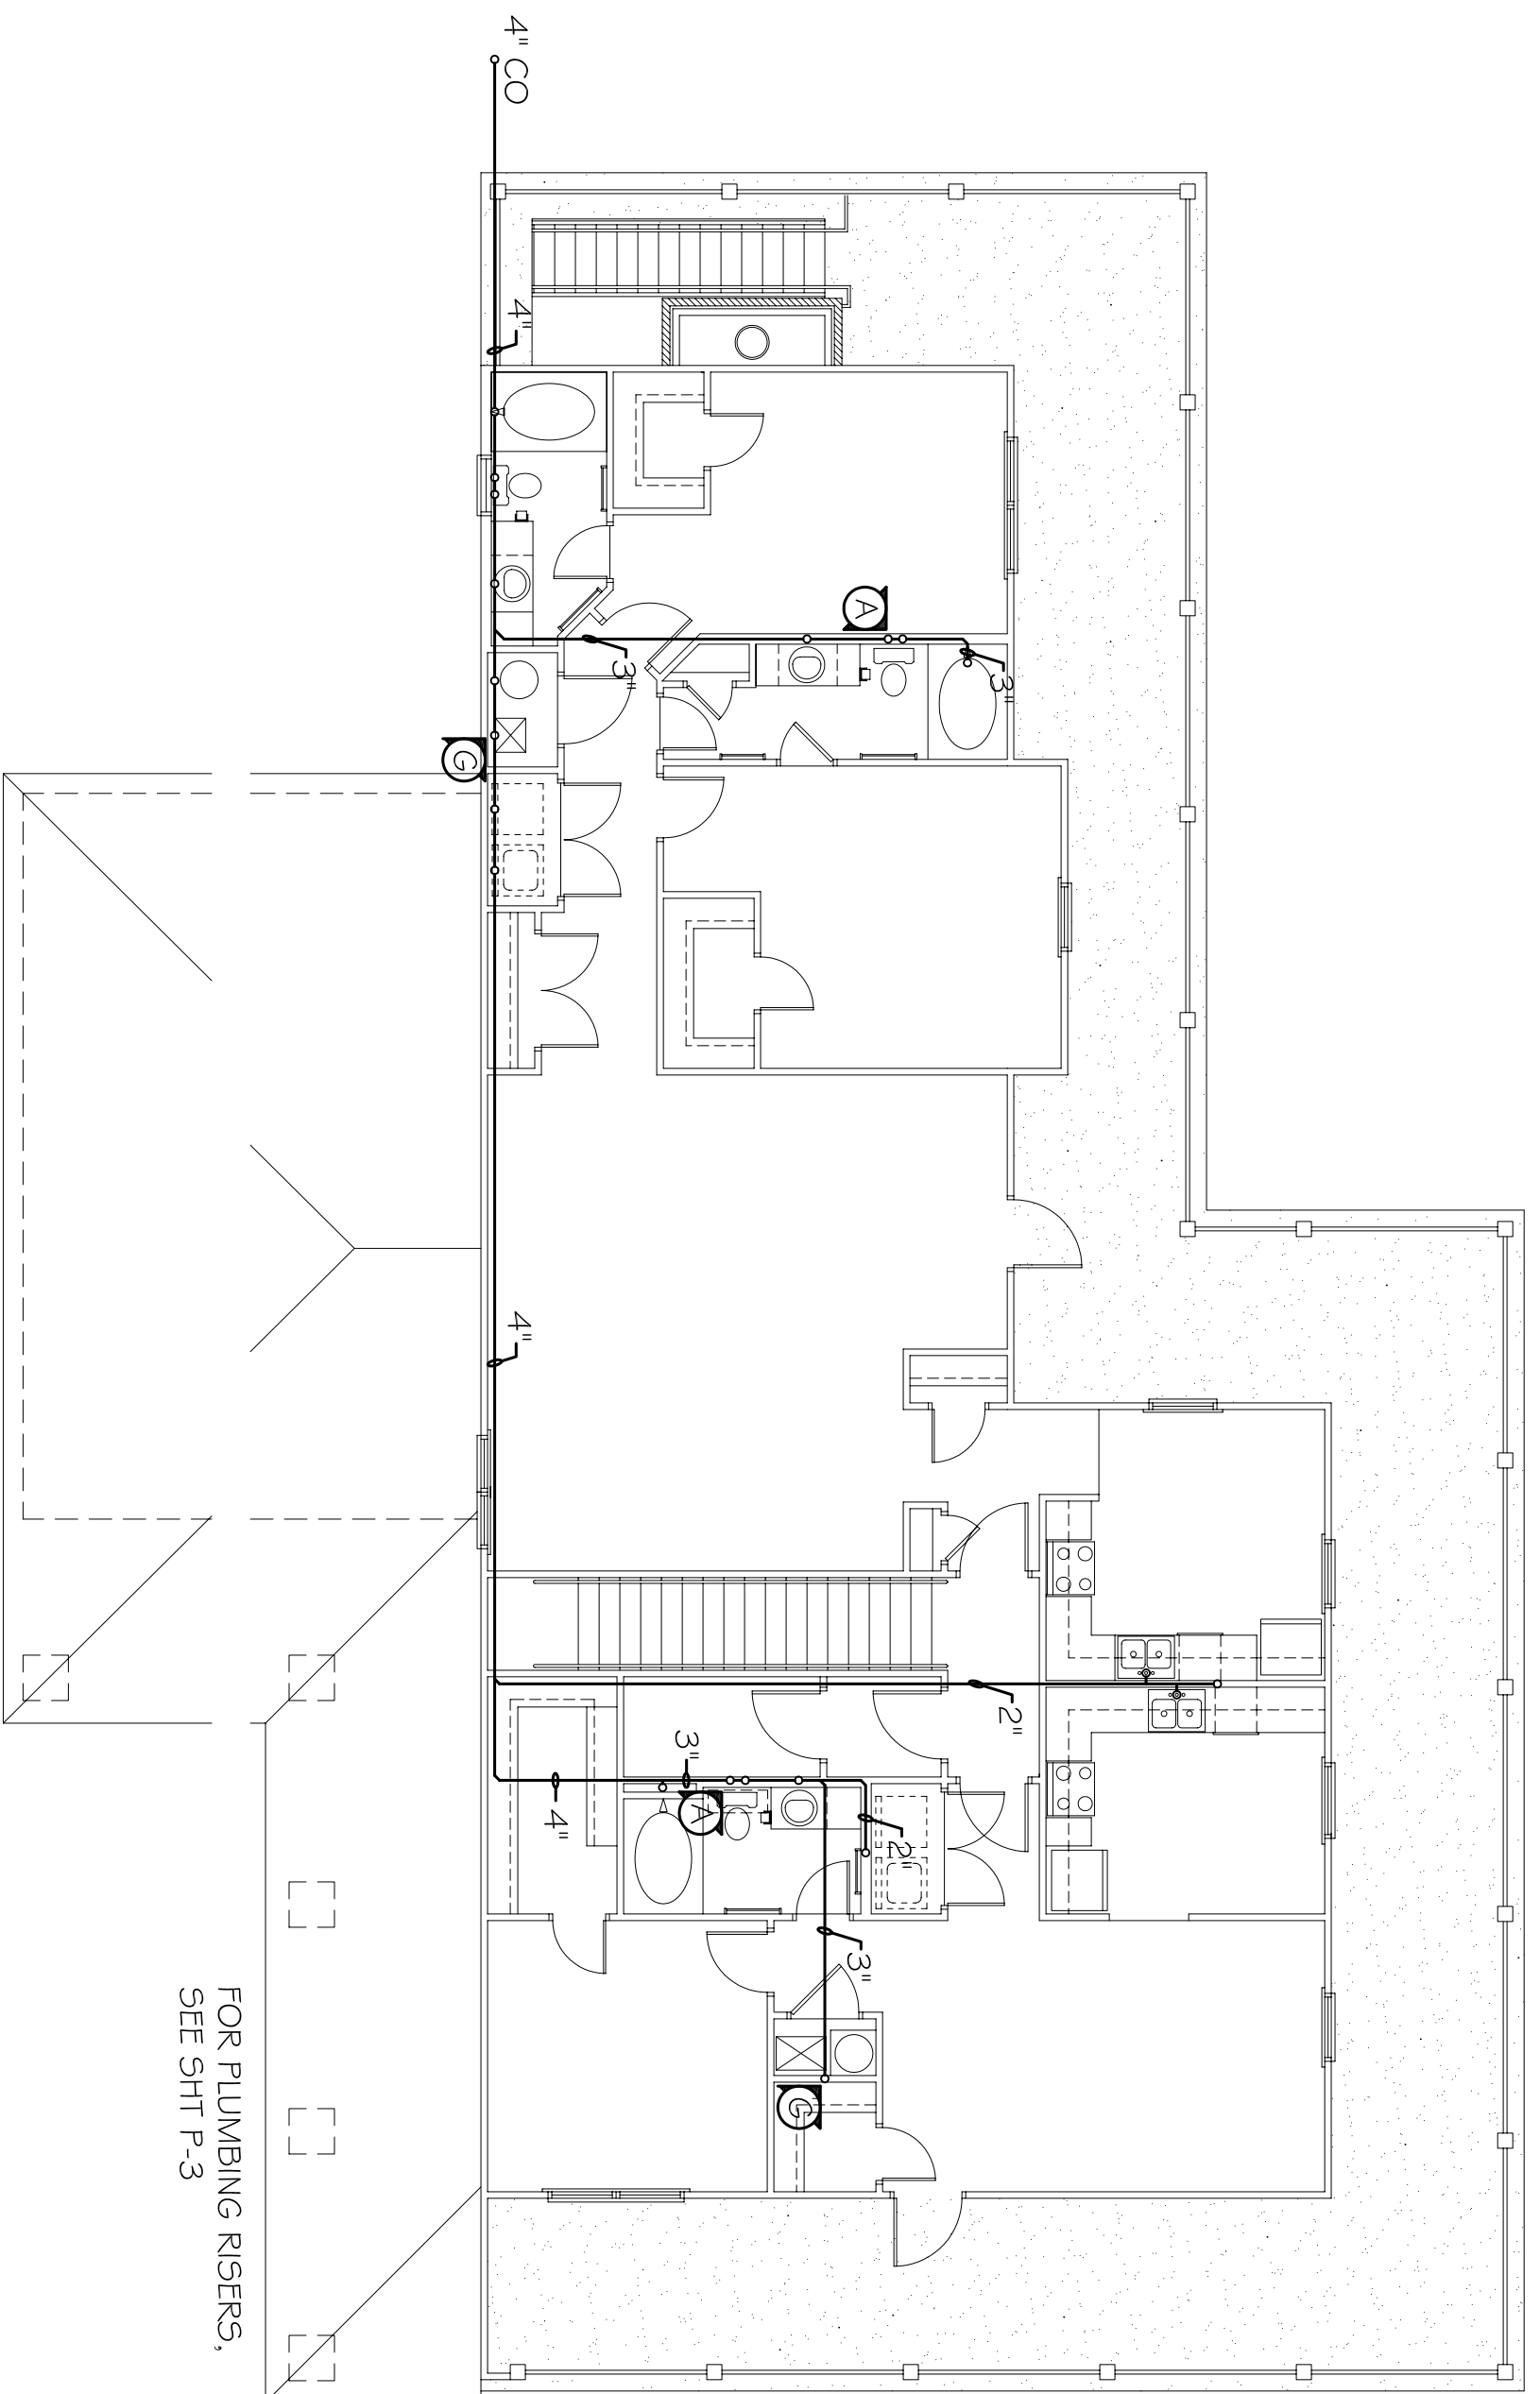

LEASING BLDG. 2ND FLOOR  
PLUMBING PLAN  
SCALE: 1/8"=1'-0"

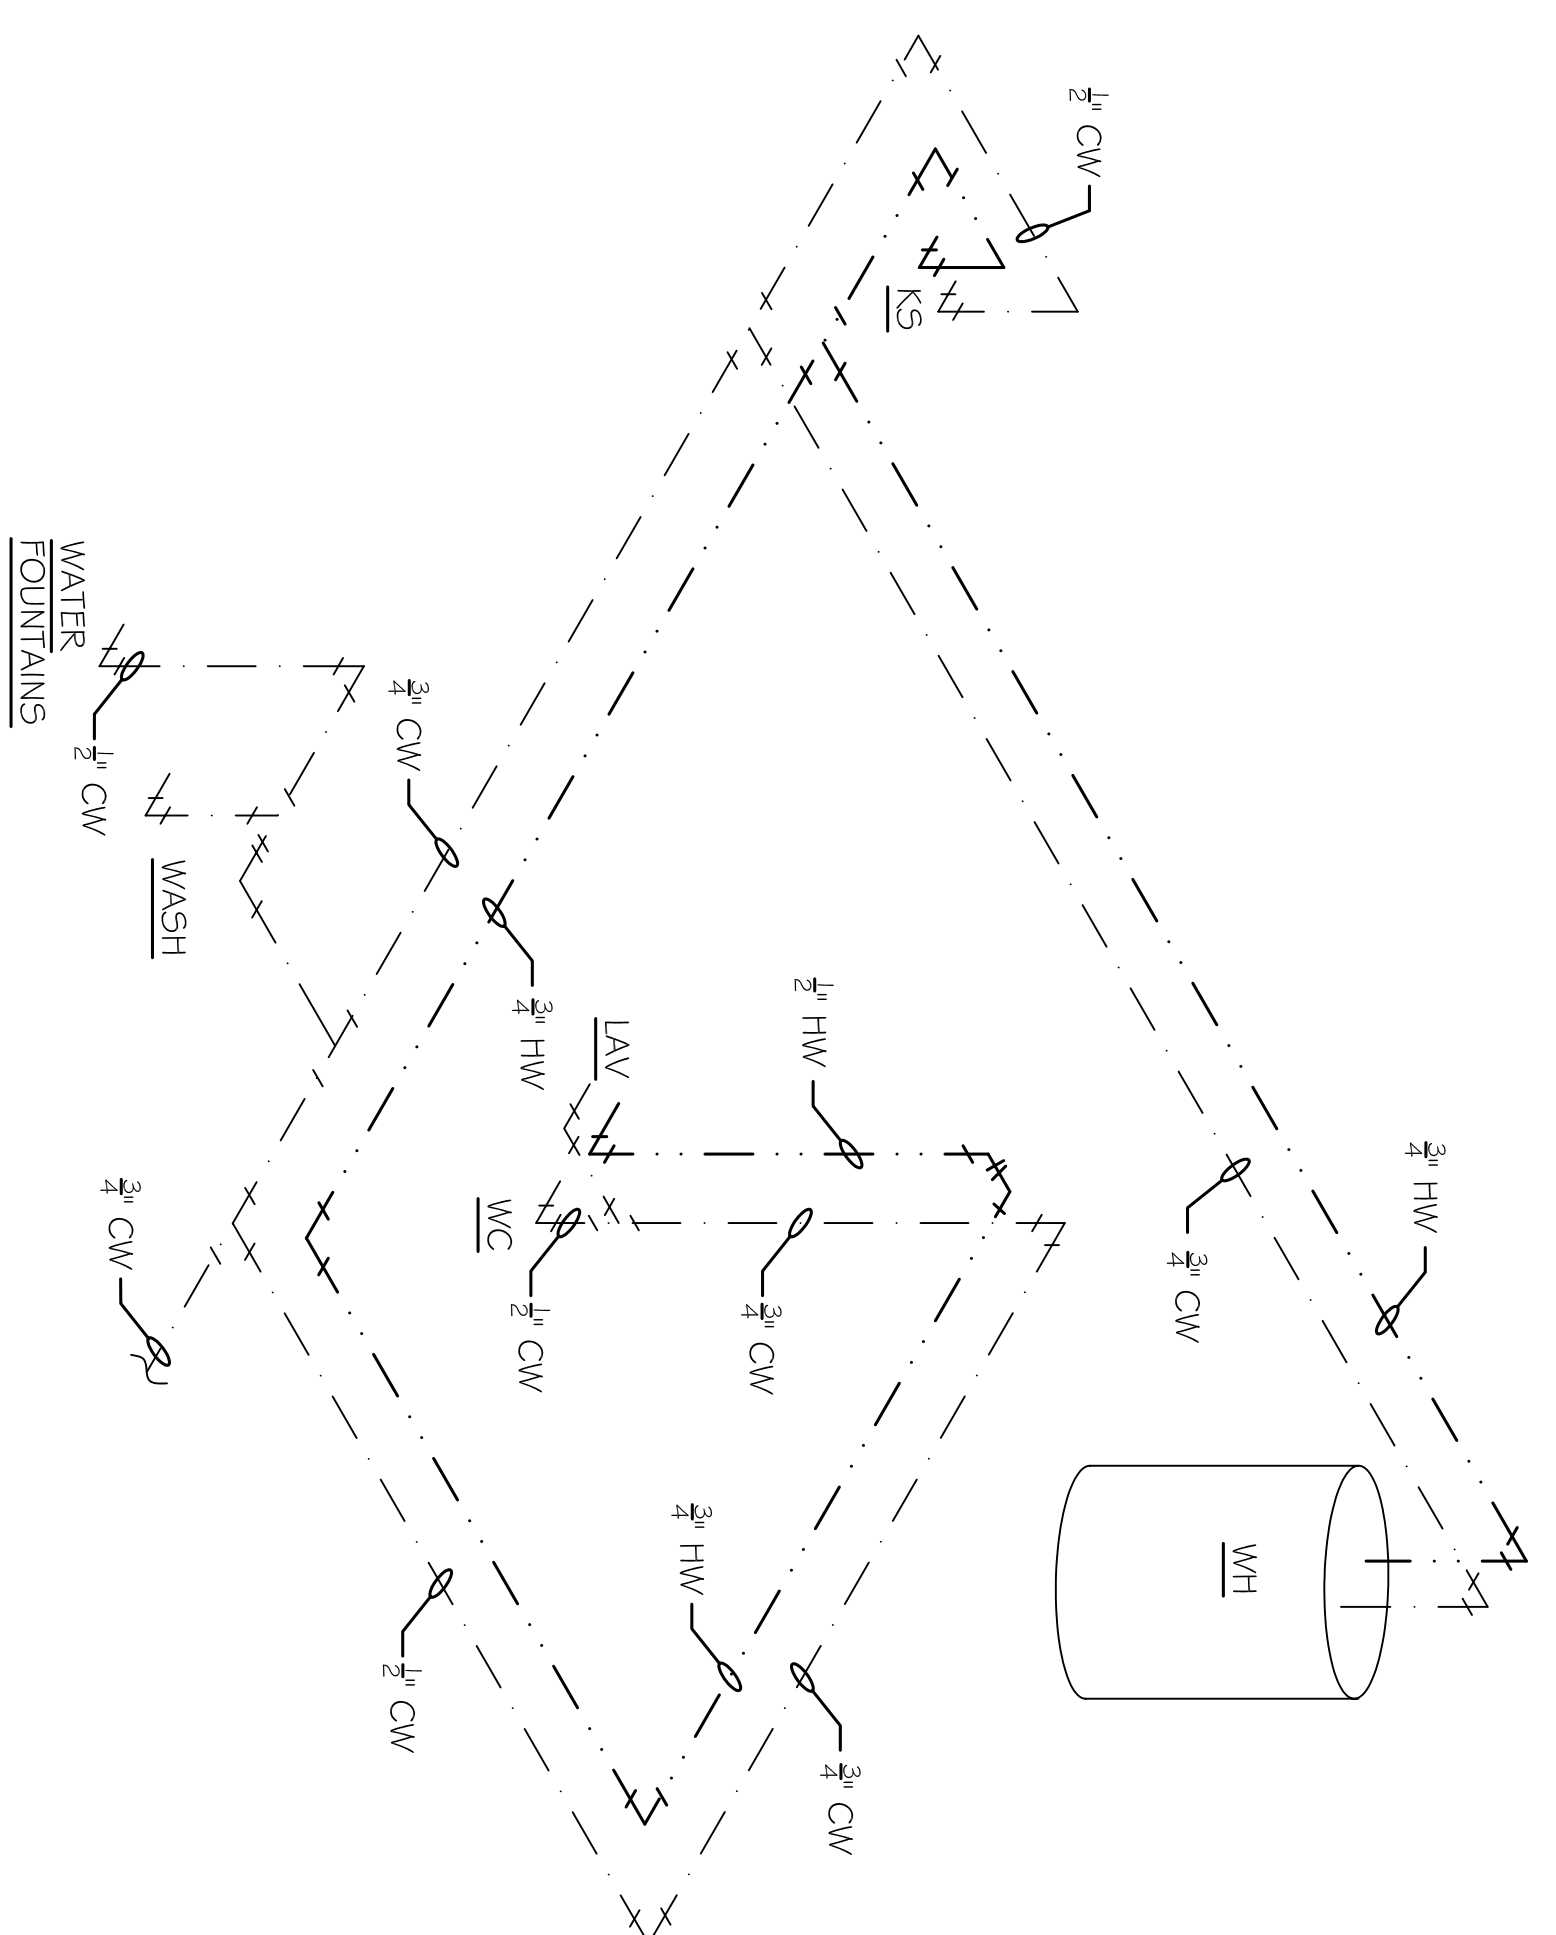

1ST FLOOR WATER RISER

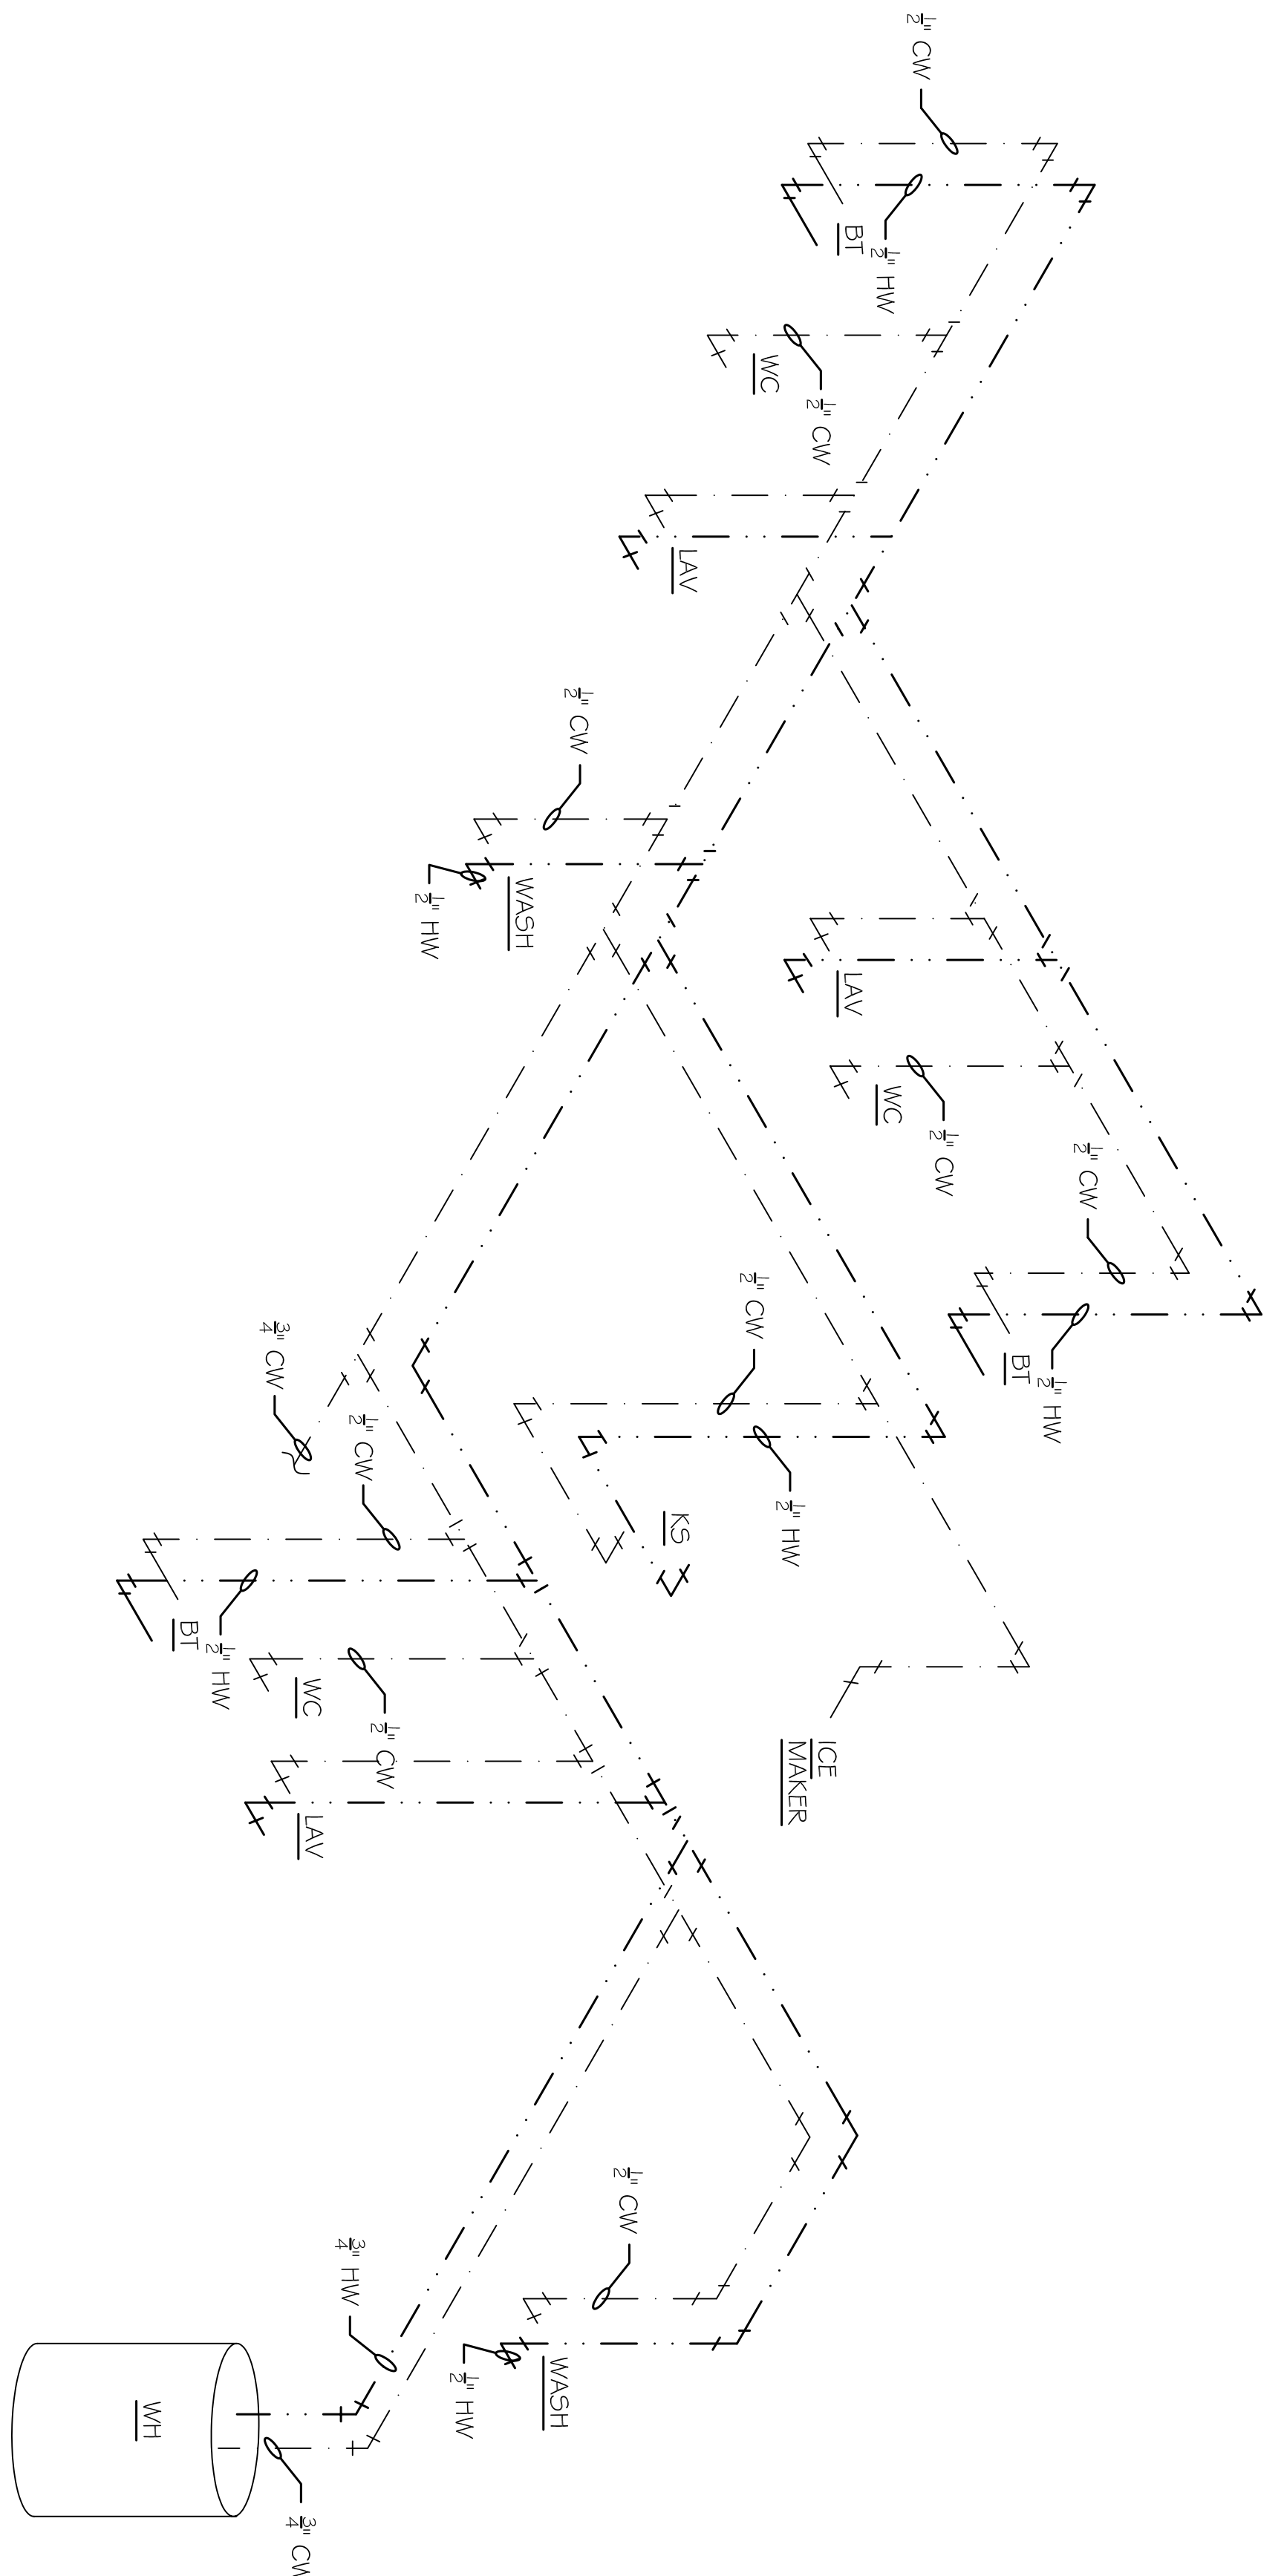

2ND FLOOR WATER RISER