


NOTE:
THIS DRAWING FOR ILLUSTRATION PURPOSES ONLY
AND EQUIPMENT SHALL BE INSTALLED TO MEET FIELD REQUIREMENTS.

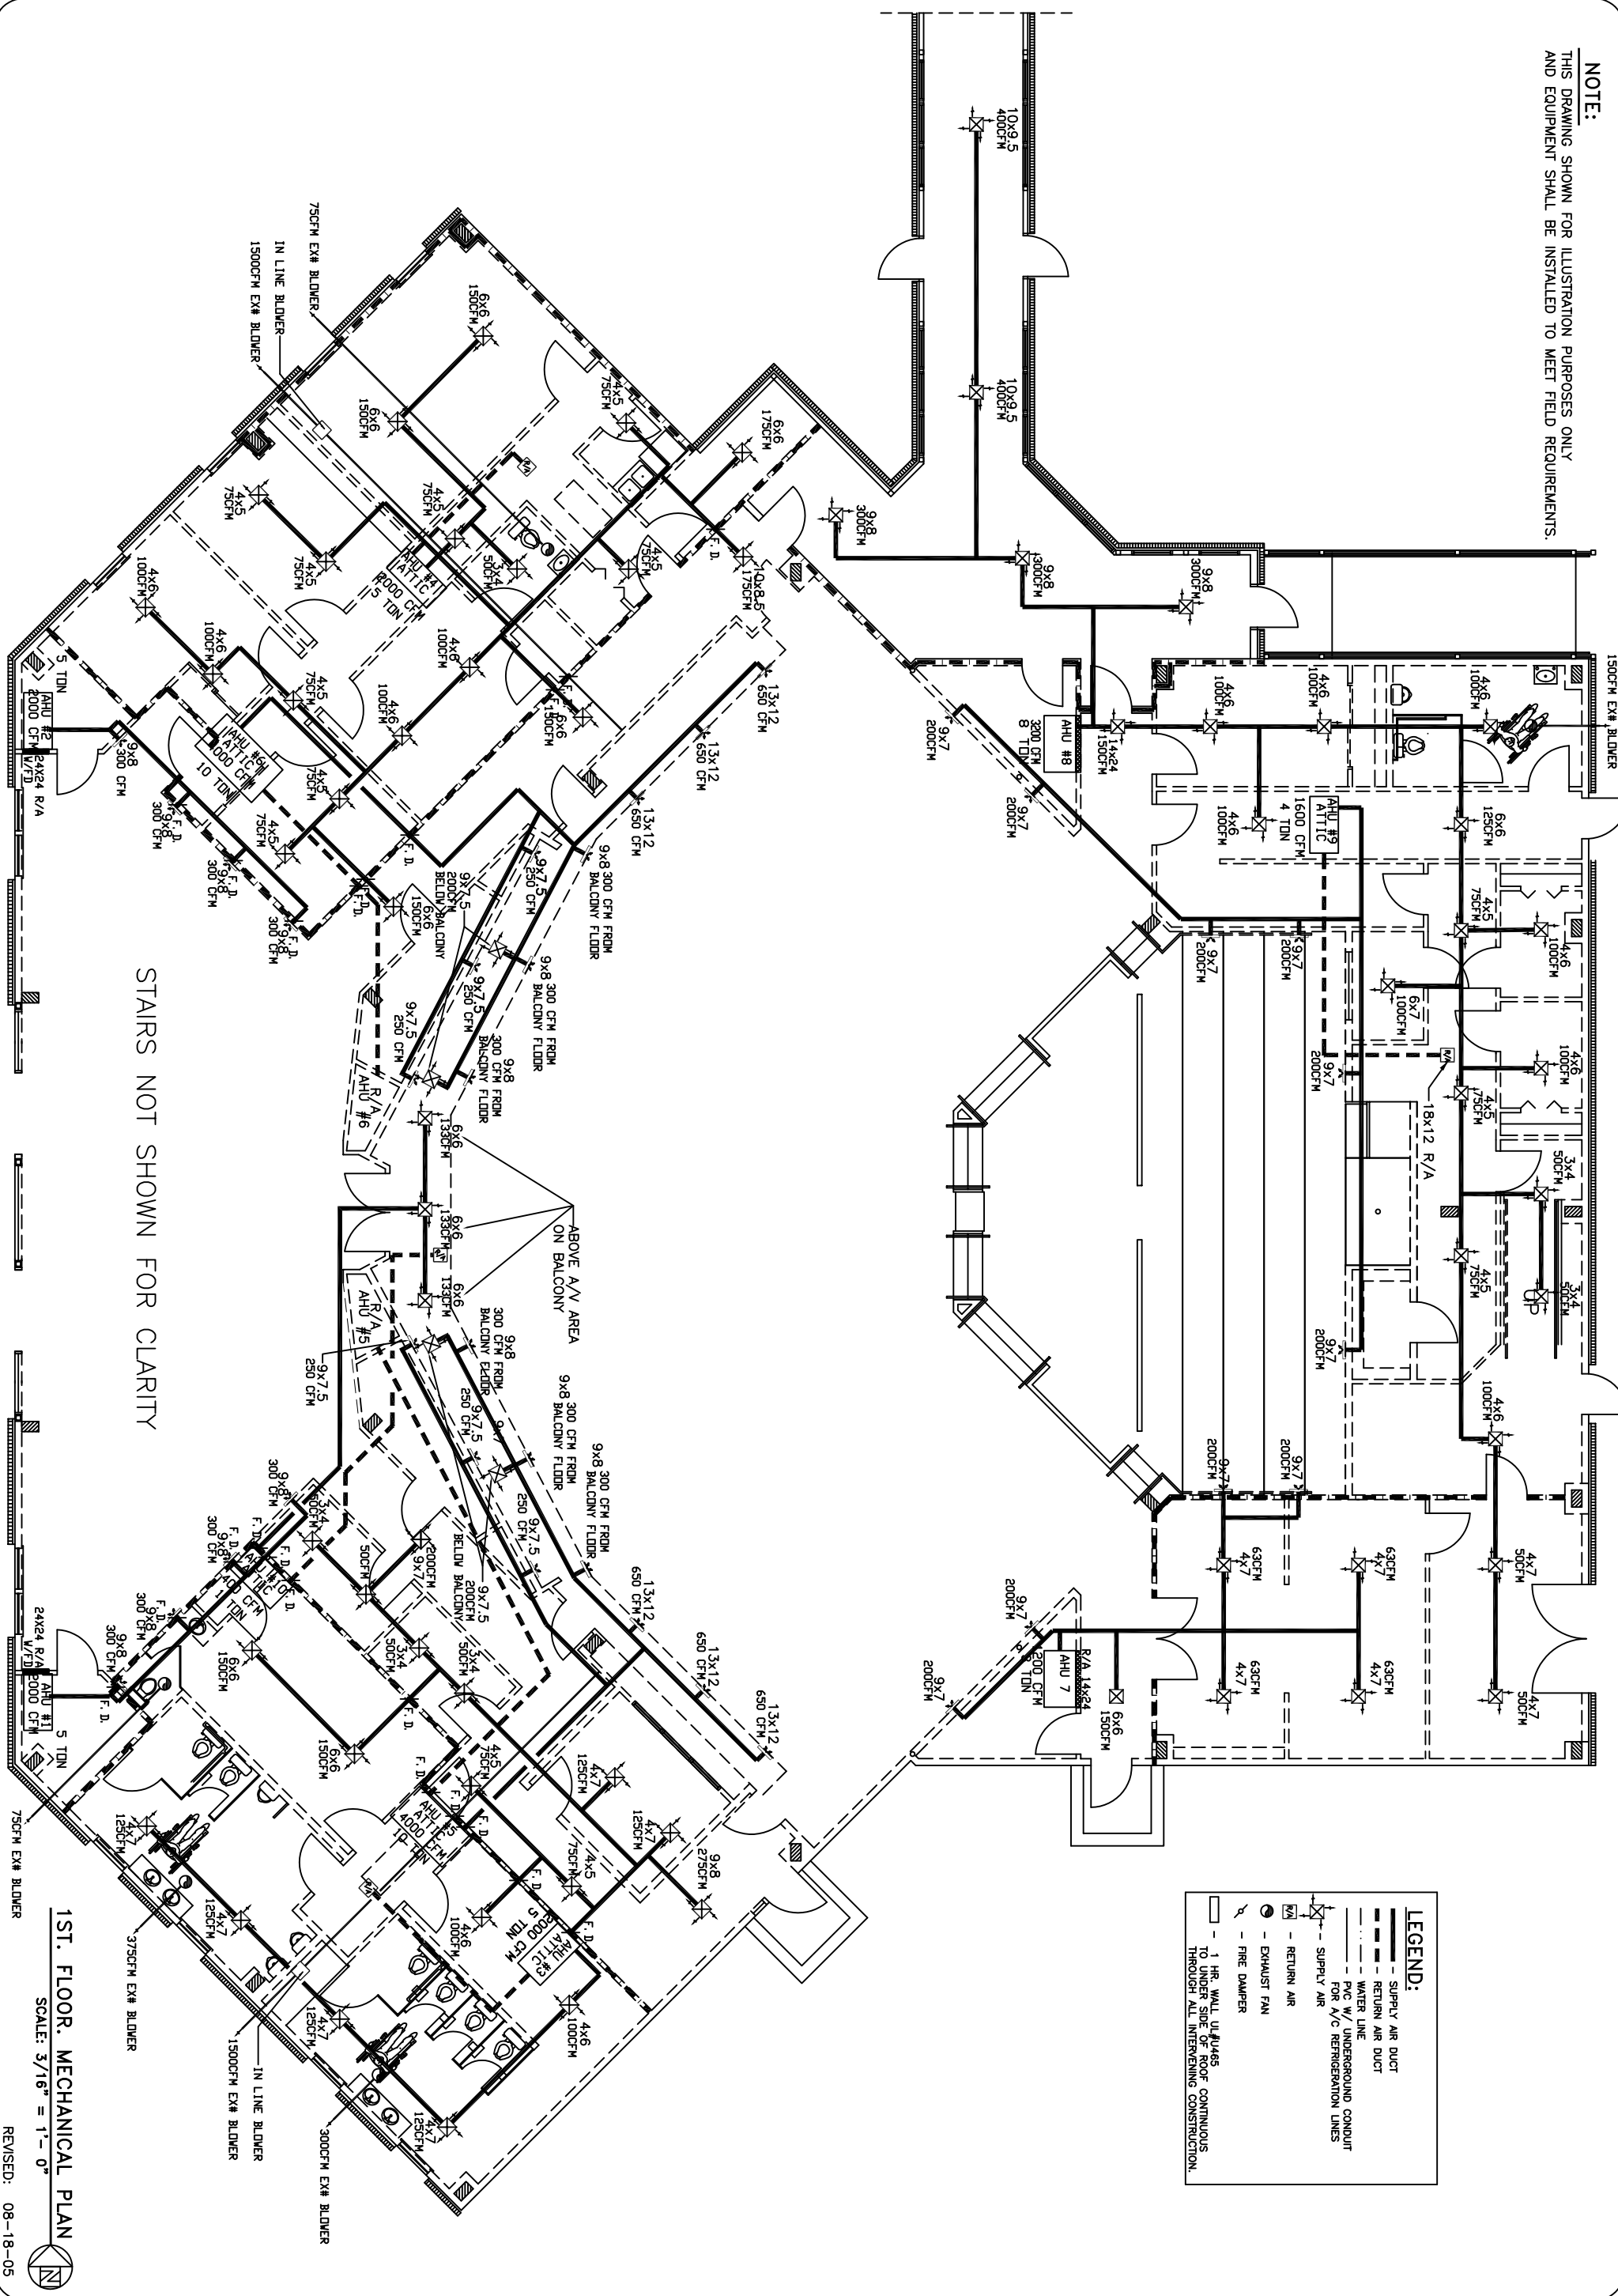

STAIRS NOT SHOWN FOR CLARITY

LEGEND:

- SUPPLY AIR DUCT
- RETURN AIR DUCT
- WATER LINE
- PVC W/ UNDERGROUND CONDUIT FOR A/C REFRIGERATION LINES
- SUPPLY AIR
- RETURN AIR
- EXHAUST FAN
- FIRE DAMPER
- 1 HR. WALL PENETRATIONS TO UNDER SIDE OF ROOF CONTINUOUS THROUGH ALL INTERVENING CONSTRUCTION.

1ST. FLOOR, MECHANICAL PLAN

SCALE: 3/16" = 1'-0"

REVISED: 08-18-05

MECHANICAL- 1ST FLOOR
STARLIGHT BAPTIST CHURCH
2100 SECOND STREET
SLIDELL, LOUISIANA

NEW SANCTUARY
DAMMON ENGINEERING, INC.
1095 FLORIDA AVENUE 985-649-5832 SLIDELL, LA. 70458
DAMMONENGINEERING.COM

SCALE: AS NOTED
FILE:
JOB NO. 14950
DATE: 05-16-05
SHEET
M-1
OF