


NOTE:
THIS DRAWING SHOWN FOR ILLUSTRATION PURPOSES ONLY
AND EQUIPMENT SHALL BE INSTALLED TO MEET FIELD REQUIREMENTS.

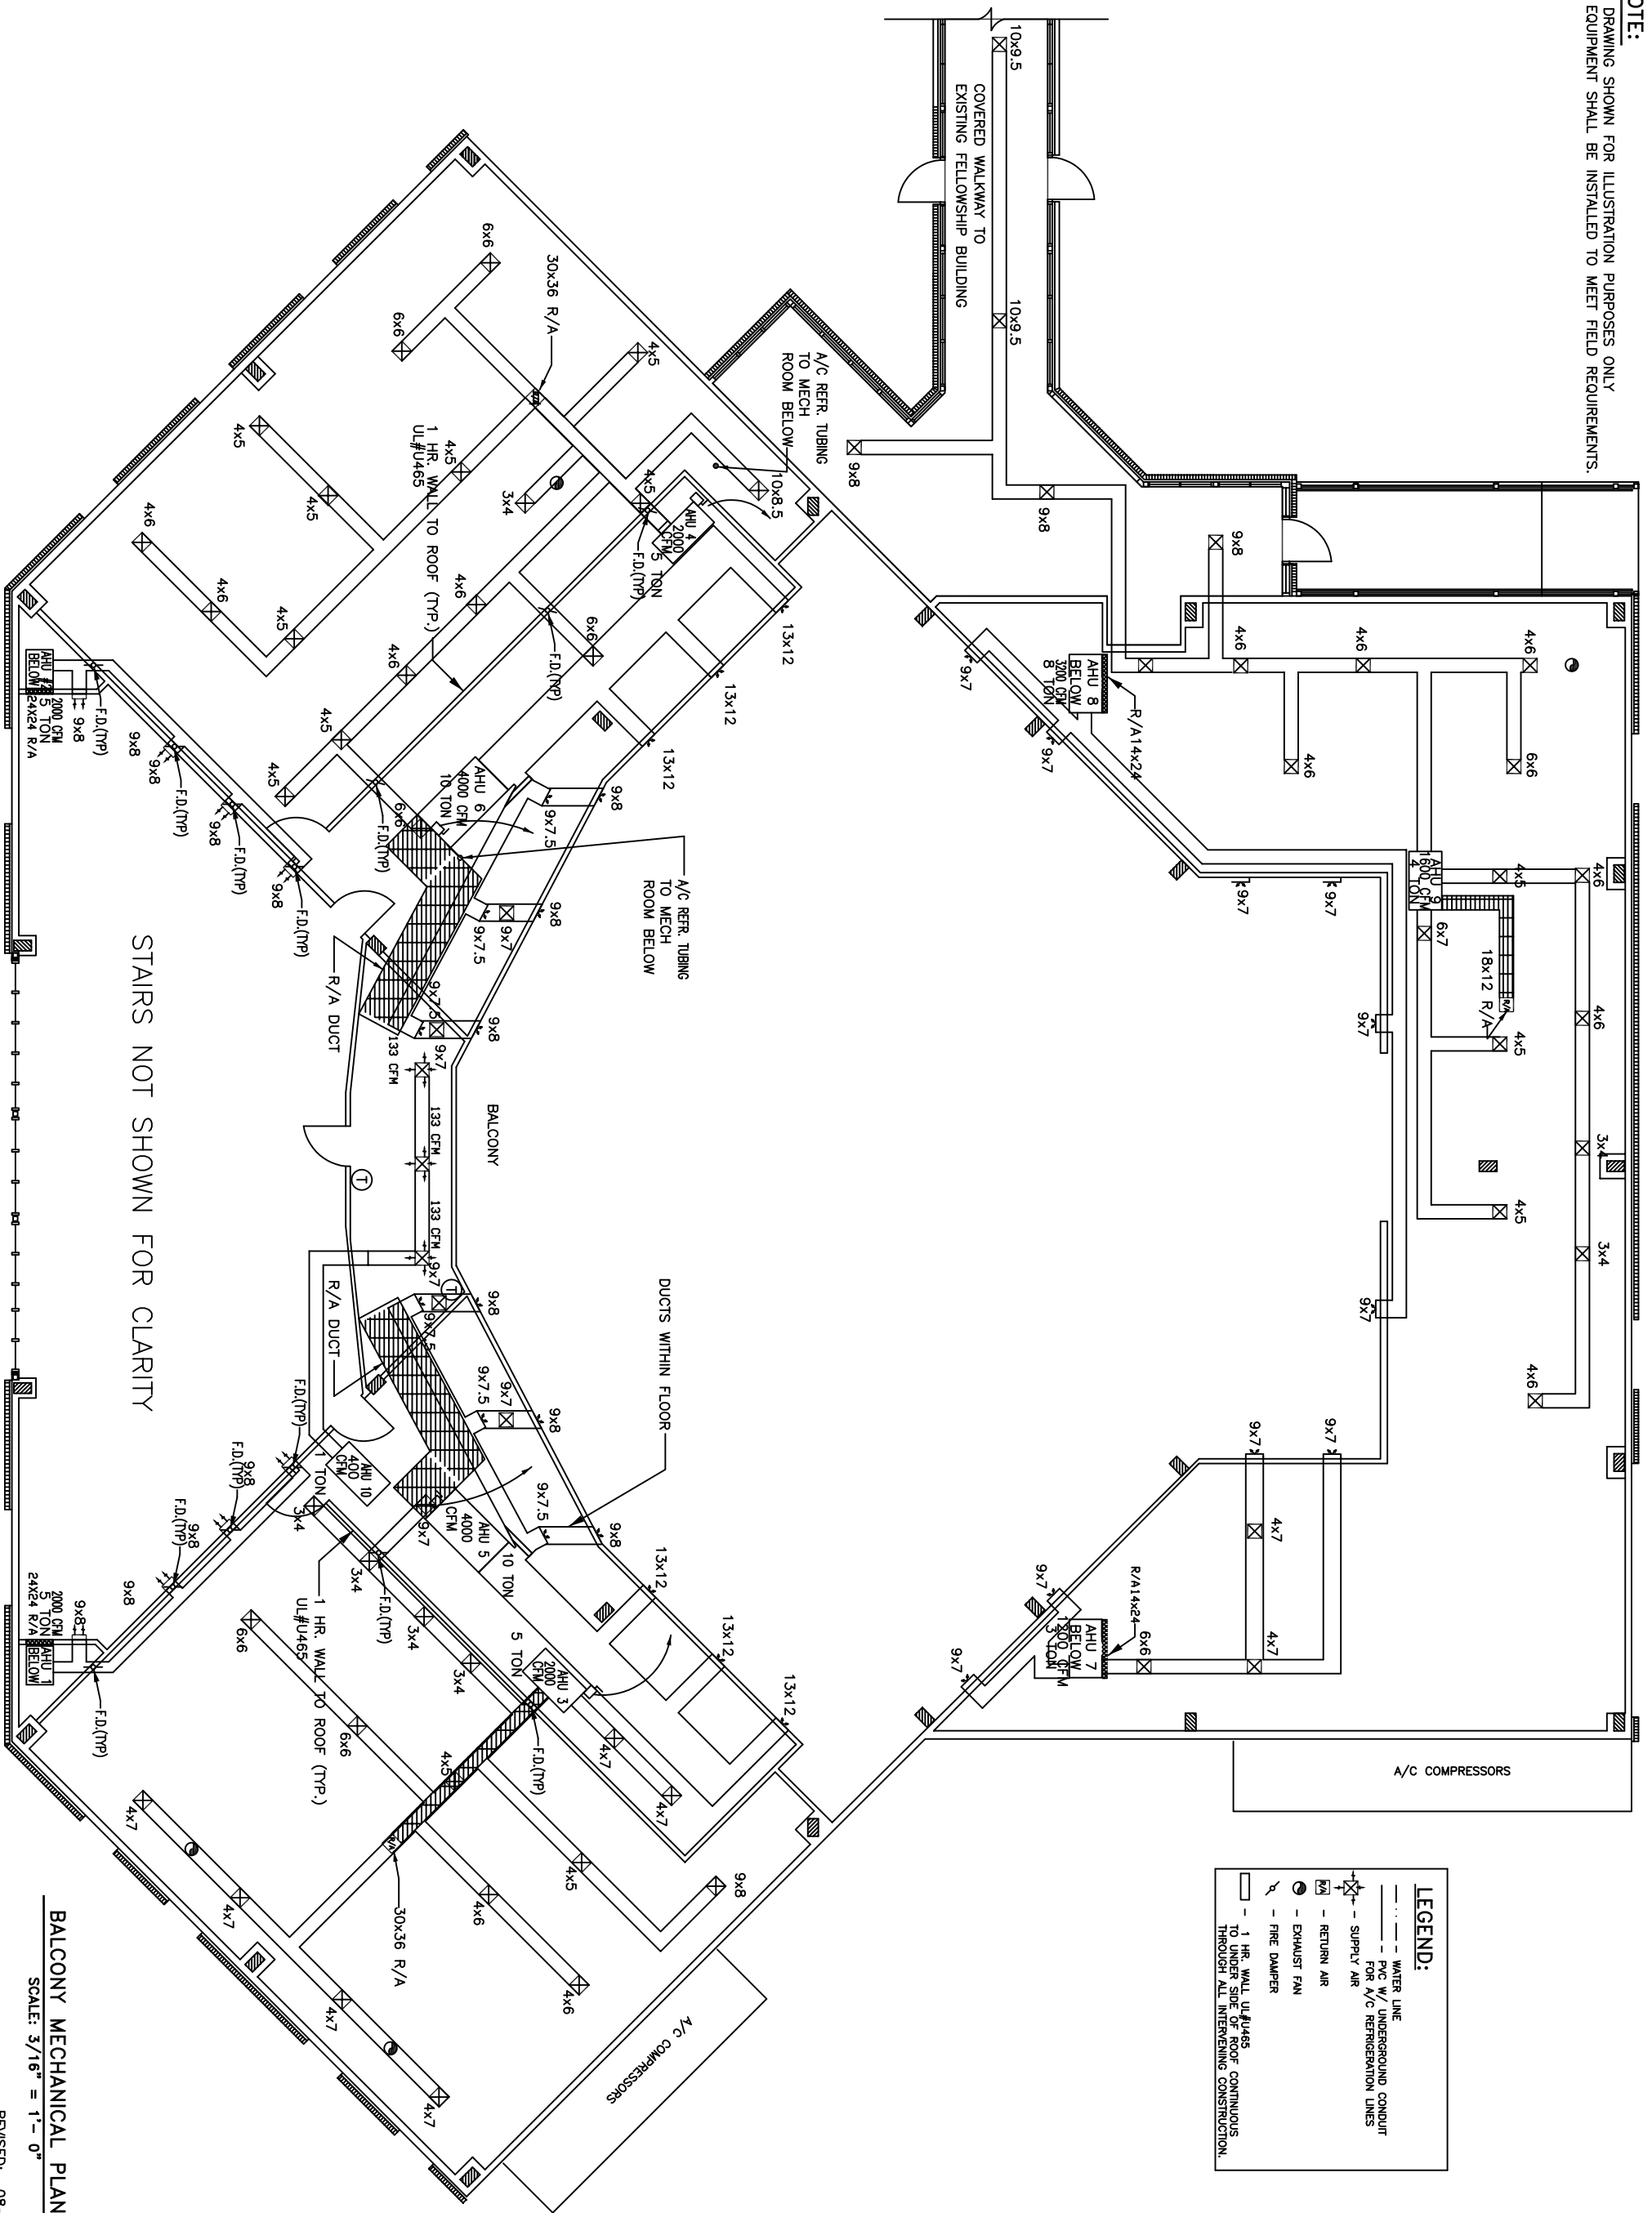

LEGEND:

	WATER LINE
	PVC W/ UNDERGROUND CONDUIT FOR A/C REFRIGERATION LINES
	SUPPLY AIR
	RETURN AIR
	EXHAUST FAN
	FIRE DAMPER
	1 HR. WALL UL#465 TO UNDER SIDE OF ROOF CONTINUOUS THROUGH ALL INTERVENING CONSTRUCTION.

STAIRS NOT SHOWN FOR CLARITY

BALCONY MECHANICAL PLAN
SCALE: 3/16" = 1'-0"
REVISED: 08-18-05

DAMMON ENGINEERING. INC. 1095 FLORIDA AVENUE 985-649-5832 SLIDELL, LA. 70458 DAMMONENGINEERING.COM	NEW SANCTUARY MECHANICAL- 2ND FLOOR STARLIGHT BAPTIST CHURCH 2100 SECOND STREET SLIDELL, LOUISIANA	SCALE: AS NOTED FILE: JOB NO. 1495d DATE: 05-16-05 SHEET M-2 OF
--	--	--