

DAMMON
ENGINEERING, INC.

CHIEF ENGINEER
EMMETT
DAMMON, P.E.

CHIEF ARCHITECT
ROBERT
WILTSE

1095 FLORIDA AVENUE
SLIDELL, LA. 70458
OFFICE: 985-649-5832
FAX: 985-641-5950

WEBSITE:
WWW.DAMMONENGINEERING.COM

EMAIL:
DAMMONENG@BELLSOUTH.NET

ARCHITECTURE

ENGINEERING

STUDIES

PLANNING

INVESTIGATION

EXPERT WITNESS

NEW
CHURCH

TABERNACLE
BAPTIST
CHURCH
2445 FOURTH AVE.
SLIDELL, LA

REFLECTED
CEILING
PLAN

REV:

SCALE: AS NOTED


JOB#: 2050

DATE: 2-8-10

SHEET 17

A-6

OF 25

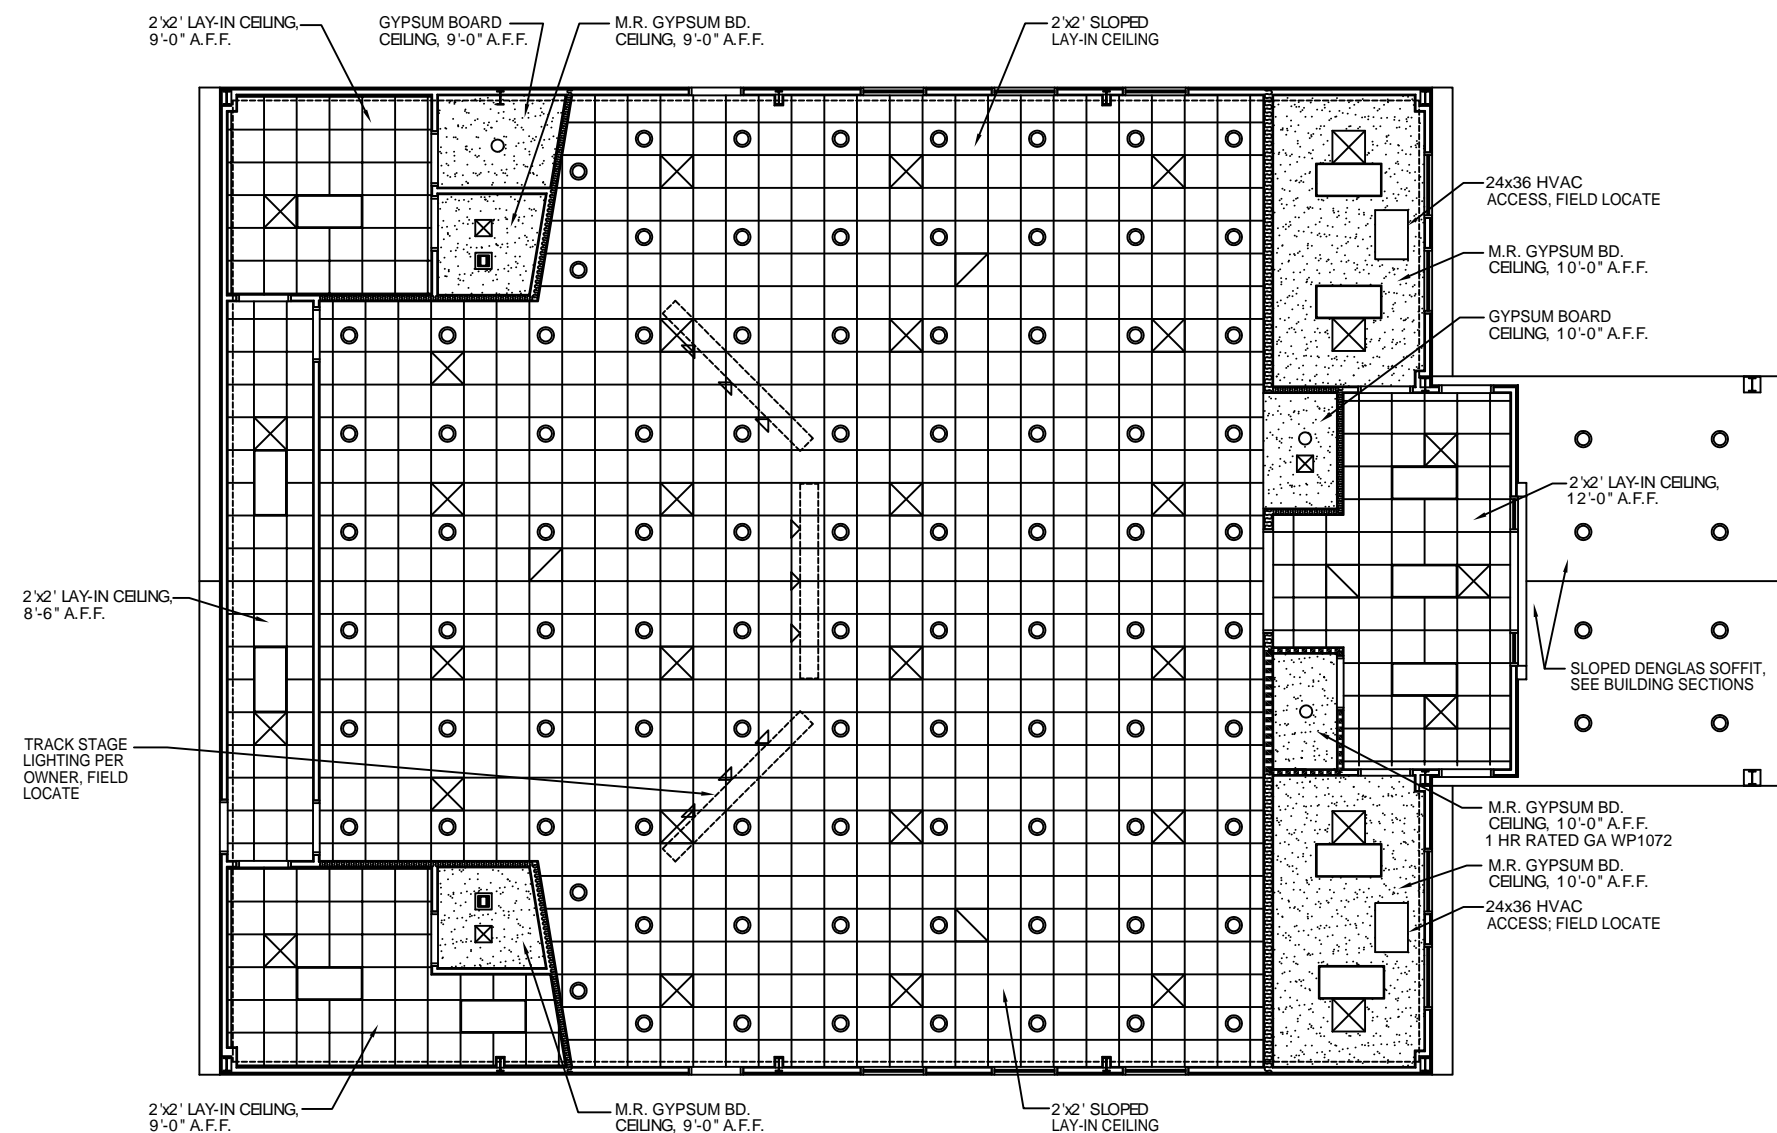

- LEGEND**
- 2'x4' FLUORESCENT LIGHT
 - CAN LIGHT
 - SURFACE MTD. FIXTURE
 - EXHAUST VENT/LIGHT COMBO
 - SUPPLY AIR
 - RETURN AIR

REFLECTED CEILING PLAN
SCALE: 3/16"=1'

