

**DAMMON**  
ENGINEERING, INC.

CHIEF ENGINEER  
EWMETT  
DAMMON, P.E.  
CHIEF ARCHITECT  
ROBERT  
WILTSE

1095 FLORIDA AVENUE  
SLIDELL, LA. 70458  
OFFICE: 985-649-5632  
FAX: 985-641-5950

WEBSITE:  
WWW.DAMMONENGINEERING.COM  
EMAIL:  
DAMMONENG@BLSOUTH.NET



ARCHITECTURE  
ENGINEERING  
STUDIES  
PLANNING  
INVESTIGATION  
EXPERT WITNESS

NEW  
CHURCH

TABERNACLE  
BAPTIST  
CHURCH  
2445 FOURTH ST.  
SLIDELL, LA

MECHANICAL  
PLAN

REV:	
SCALE AS NOTED	
JOB#: 2050	
DATE: 2-8-10	
SHEET 20	
<b>M-1</b>	
OF 25	

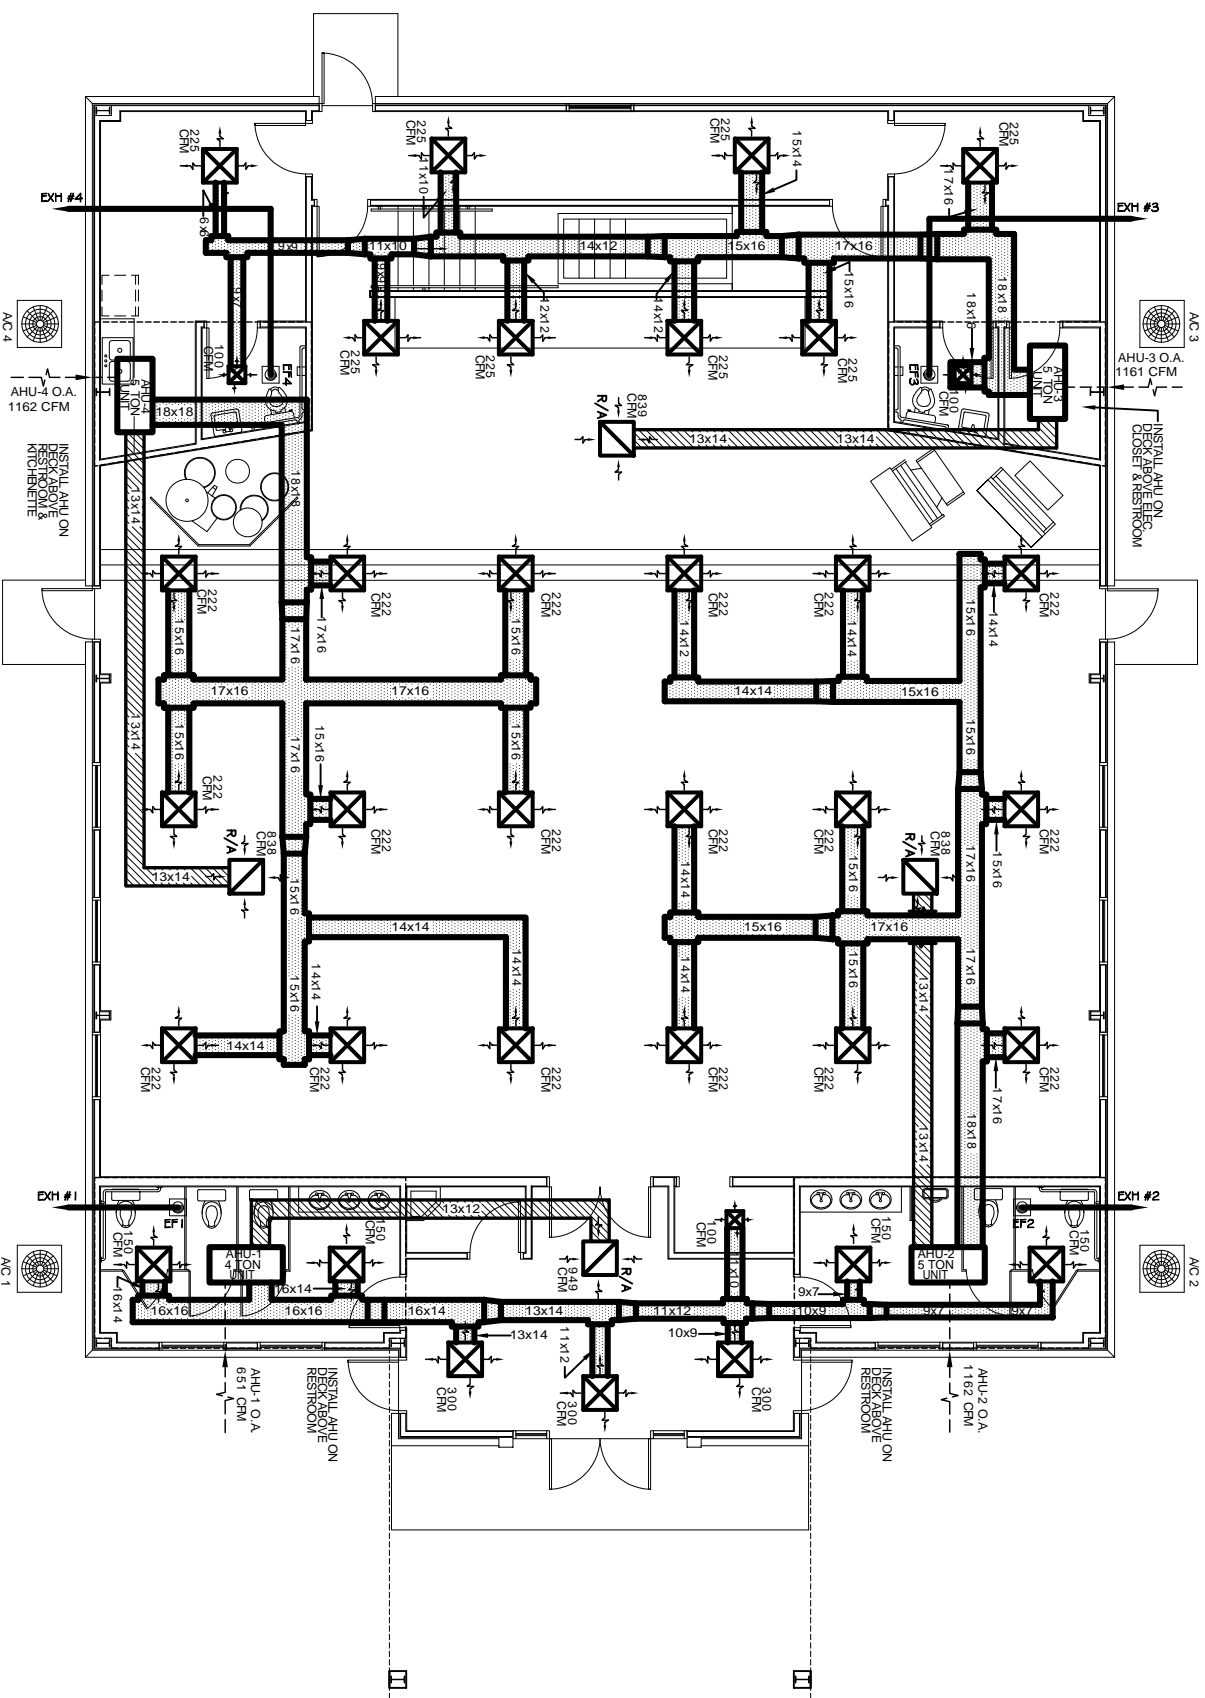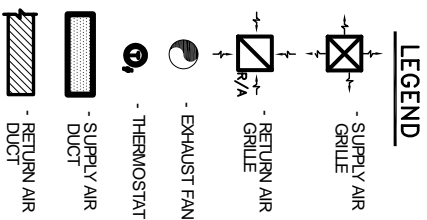

MECHANICAL PLAN  
SCALE 3/16" = 1'

**EXHAUST FAN SCHEDULE**

NO.	LOCATION	CFM	VOLTAGE	TYPE	MANF.
EF1	WOMEN'S RESTROOM 101	300	120	VENT	BROAN
EF2	MEN'S RESTROOM 102	300	120	VENT	BROAN
EF3	MEN'S RESTROOM 113	100	120	VENT	BROAN
EF4	WOMEN'S RESTROOM 111	100	120	VENT	BROAN

**STANDARD A/C UNIT SCHEDULE**

NO.	TOTAL BTU	CFM	O.A.	HEAT ELEC.	VOLTAGE	MCA	ELECTRICAL CRT BRKR	COMMENTS
AC 1	48,000 4 TON	1,600	651	15 KW	208V, 1Ø	-	MDP1-2.4.5.7.18.20	YORK (VERIFY WITH OWNER)
AC 2	60,000 5 TON	2,000	1162	15 KW	208V, 1Ø	-	MDP1-6.8.9.11.21.23	"
AC 3	60,000 5 TON	2,000	1161	15 KW	208V, 1Ø	-	MDP1-10.12.13.15.22.24	"
AC 4	60,000 5 TON	2,000	1162	15 KW	208V, 1Ø	-	MDP1-14.16.17.19.25.27	"