


MECHANICAL KEY PLAN  
N.T.S.

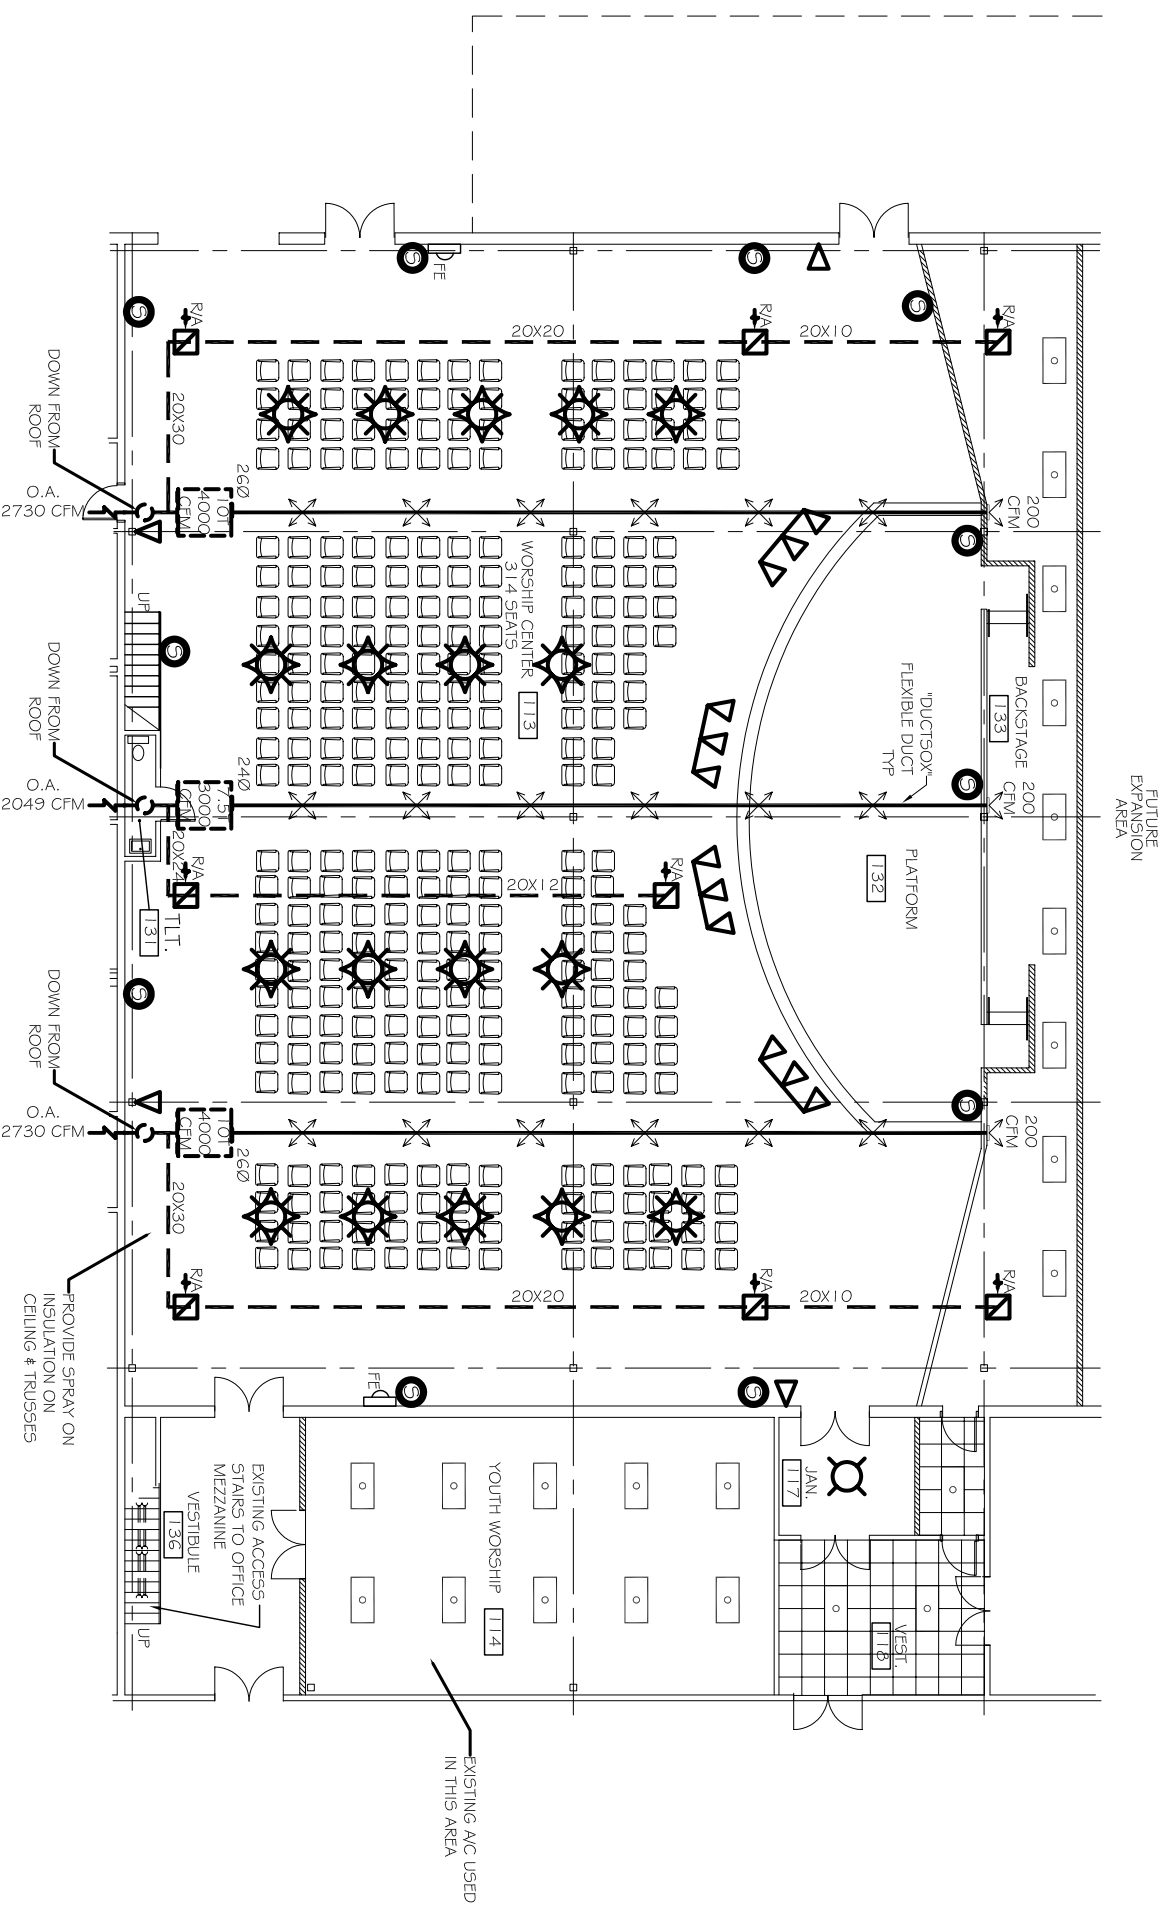


NOTE:  
ALL HVAC EQUIPMENT SHOWN IS NEW. EXISTING HVAC EQUIPMENT SHALL BE REMOVED PRIOR TO CONSTRUCTION.  
INSTALL A/C UNITS AND ALL DUCTWORK IN THIS ZONE NO HIGHER THAN 12' A. F. F.

ZONE 1 MECHANICAL PLAN  
SCALE: 1/8" = 1'-0"

LEGEND

- - SUPPLY AIR DUCT
- - - RETURN AIR DUCT
- · - EXHAUST DUCT
- ⊠ - 24 X 24 SUPPLY AIR GRILLE
- ⊠ - 24 X 24 RETURN AIR GRILLE
- - THERMOSTAT
- ⊠ - VENT/ LIGHT

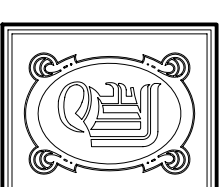

**DAMMON**  
ENGINEERING, INC.

CHIEF ENGINEER  
EMMETT  
DAMMON, P.E.  
CHIEF ARCHITECT  
ROBERT  
WILTSE

1095 FLORIDA AVENUE  
SLIDELL, LA. 70456  
OFFICE: 985-649-5832  
FAX: 985-641-5950

WEBSITE:  
WWW.DAMMONENGINEERING.COM

EMAIL:  
DAMMONENG@BELL.SOUTH.NET

ARCHITECTURE  
ENGINEERING  
STUDIES  
PLANNING  
INVESTIGATION  
EXPERT WITNESS

NORTHSHORE  
CHURCH  
KENSINGTON DR.  
SLIDELL, LA

ZONE 1  
MECHANICAL  
PLAN

REV:

SCALE: AS NOTED

JOB#: 1988

DATE: 07-30-08

SHEET

M-1

OF