



MECHANICAL KEY PLAN
N.T.S.

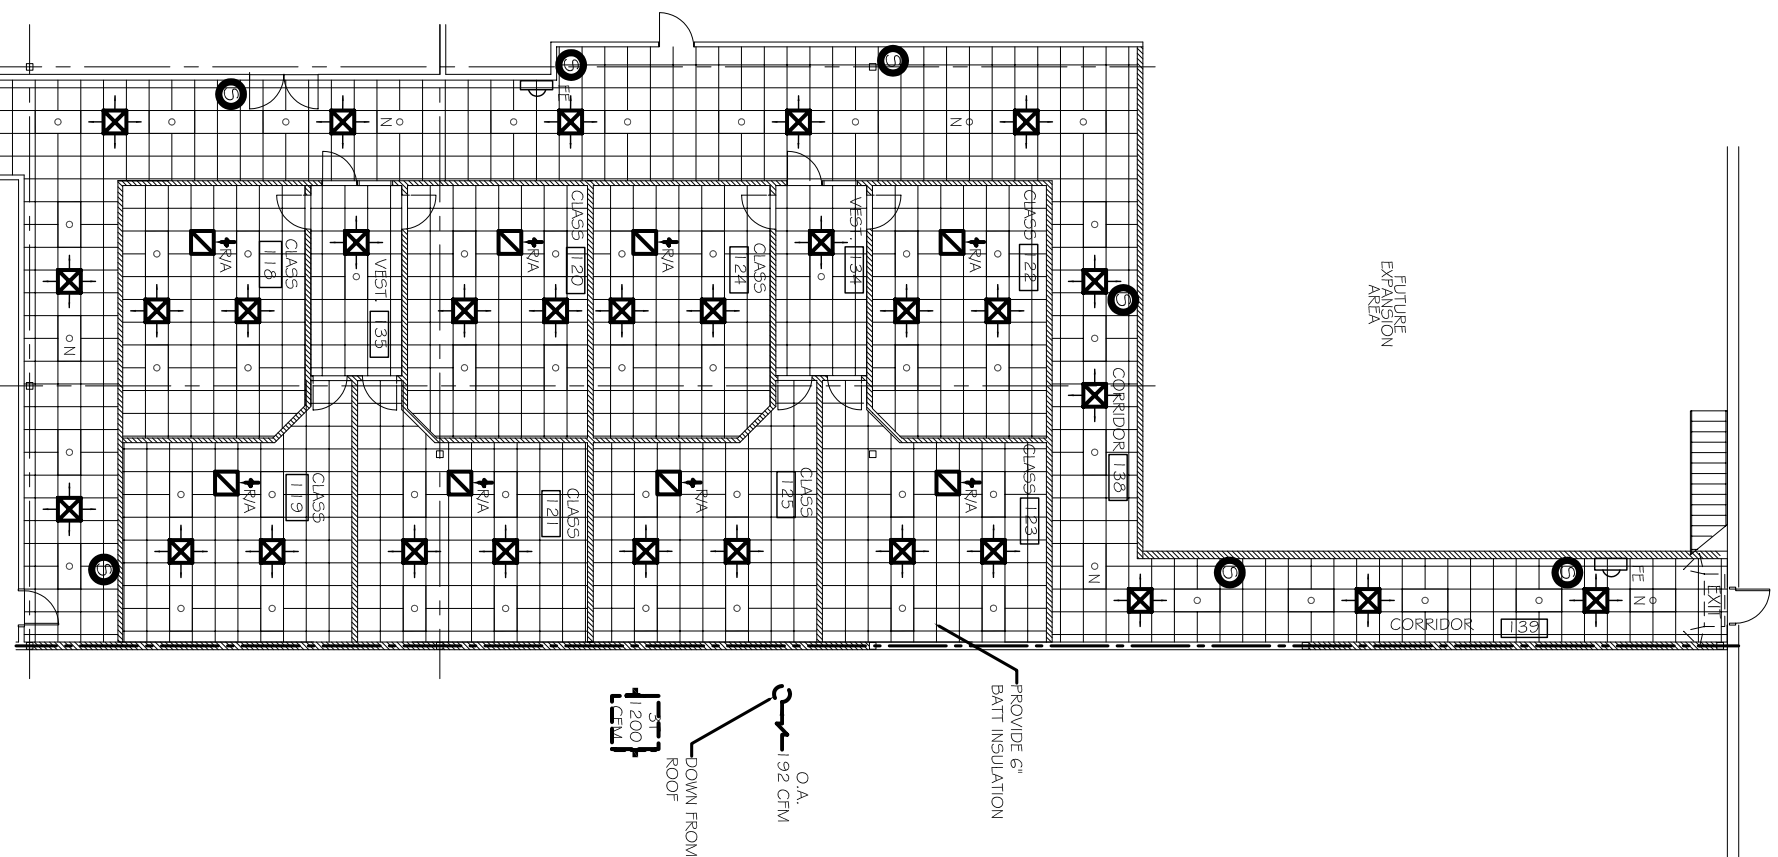

ZONE 2 MECHANICAL PLAN
SCALE: 1/8" = 1'-0"


NOTE:
ALL HVAC EQUIPMENT SHOWN IS NEW. EXISTING HVAC EQUIPMENT SHALL BE REMOVED PRIOR TO CONSTRUCTION.

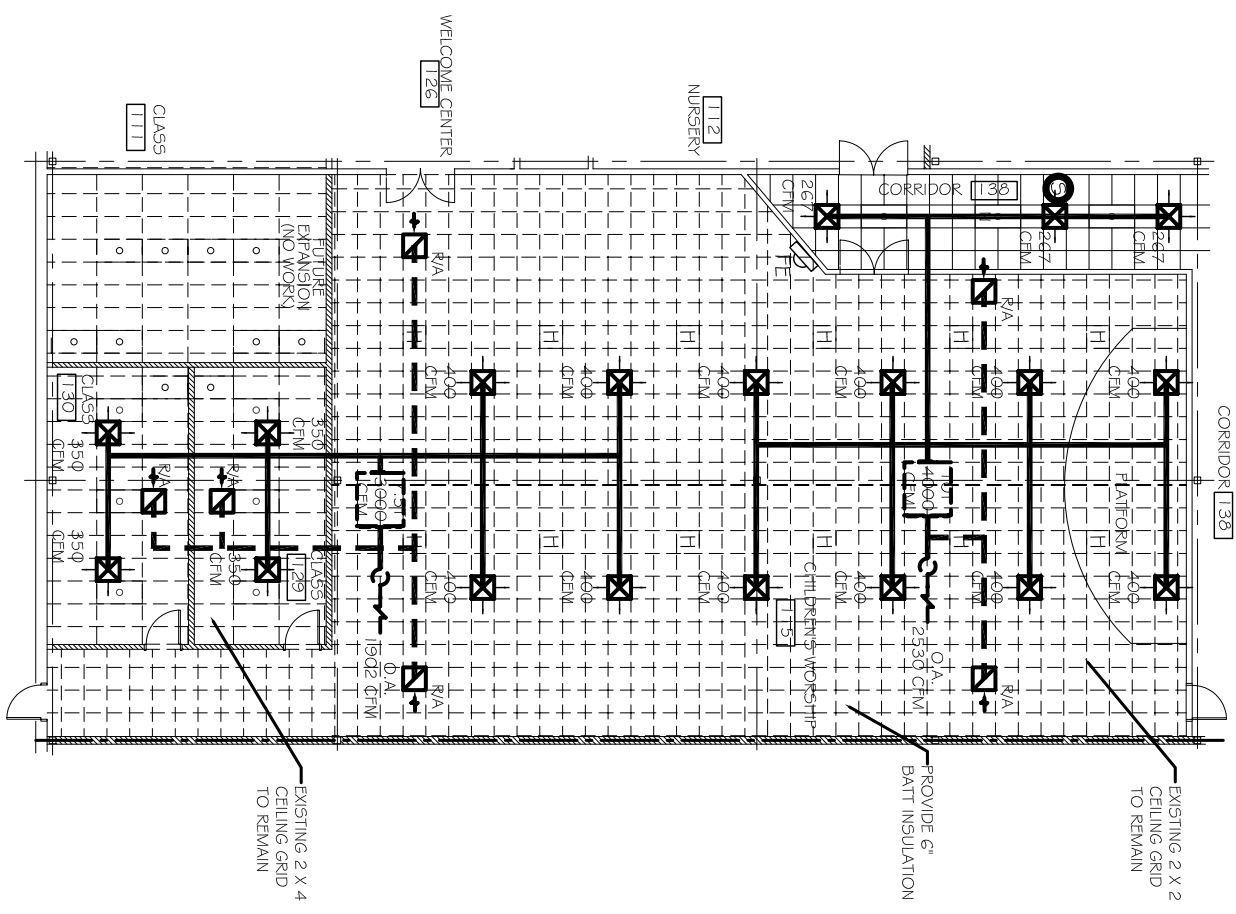

ZONE 3 MECHANICAL PLAN
SCALE: 1/8" = 1'-0"

LEGEND

- - - SUPPLY AIR DUCT
- - - RETURN AIR DUCT
- - - EXHAUST DUCT
- 24 X 24 SUPPLY AIR GRILLE
- 24 X 24 RETURN AIR GRILLE
- THERMOSTAT
- VENT/ LIGHT
- DOWN FROM ROOF

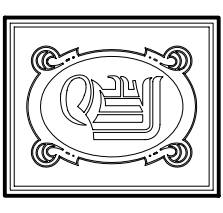

DAMMON ENGINEERING, INC.
CHIEF ENGINEER
EMMETT DAMMON, P.E.

CHIEF ARCHITECT
ROBERT WILTSE

1095 FLORIDA AVENUE
SUDELL, LA, 70458
OFFICE: 985-649-5832
FAX: 985-641-5950

WEBSITE:
WWW.DAMMONENGINEERING.COM
EMAIL:
DAMMONENG@BELLSOUTH.NET

ARCHITECTURE
ENGINEERING
STUDIES
PLANNING
INVESTIGATION
EXPERT WITNESS

NORTHSHORE
CHURCH
KENSINGTON DR.
SUDELL, LA

ZONES 2 & 3
MECHANICAL
PLAN

REV:	SCALE: AS NOTED
JOB#: 1988	DATE: 07-30-08
SHEET	M-2
OF	