

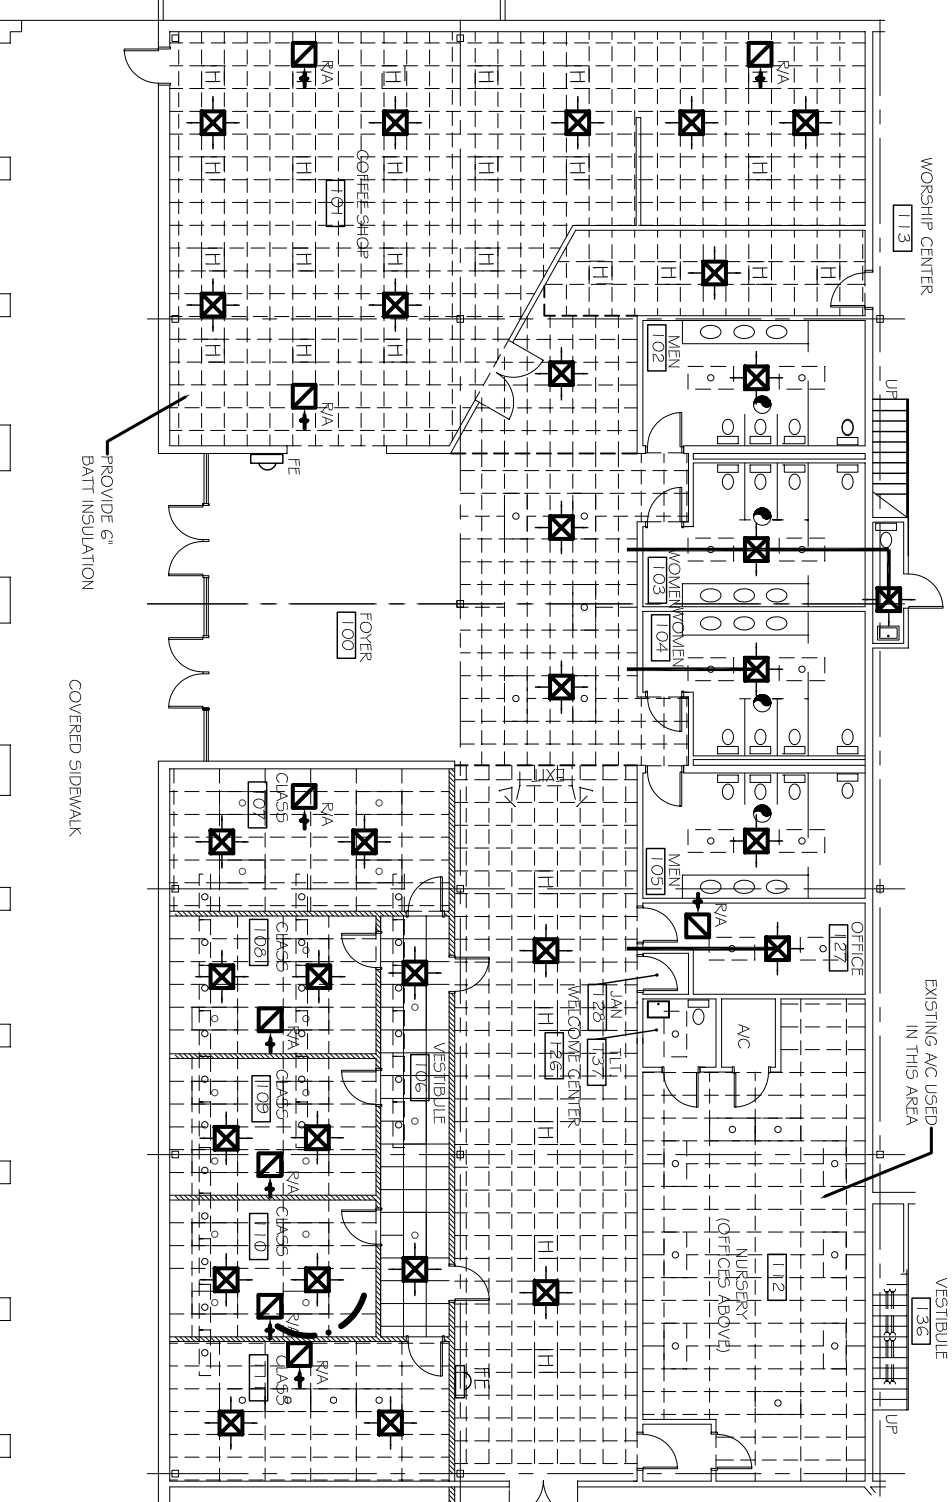


MECHANICAL KEY PLAN
N.T.S.

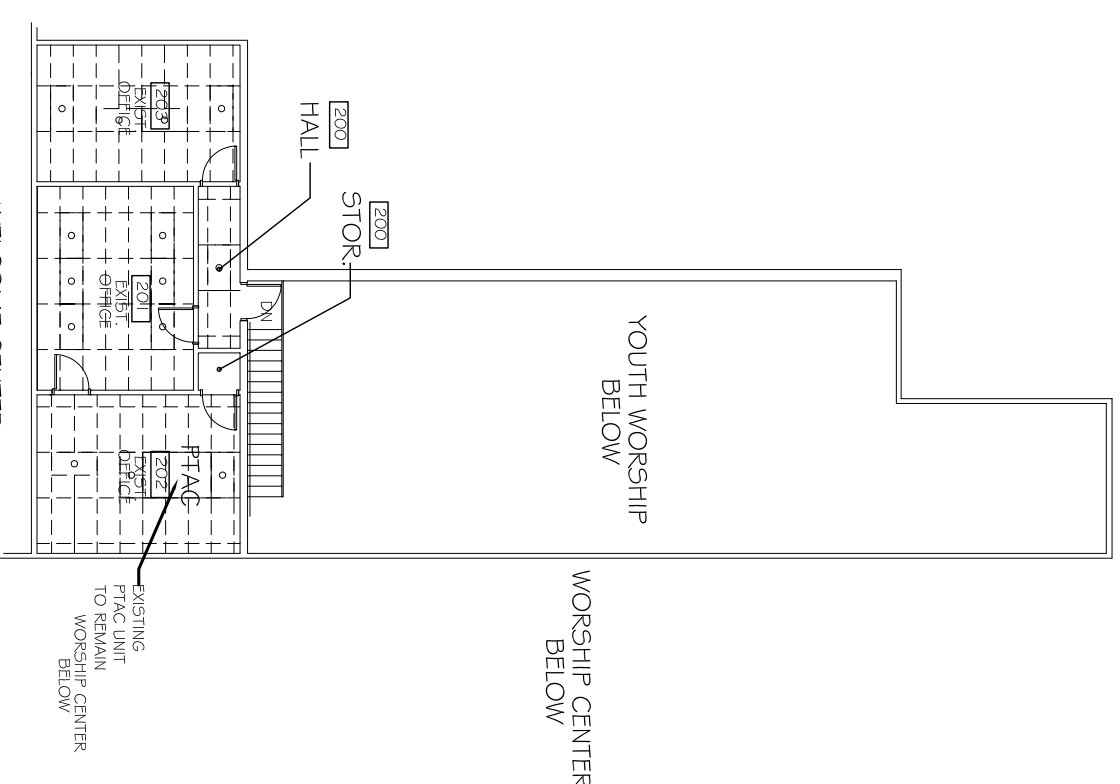

ZONE 4 MECHANICAL PLAN
SCALE: 1/8" = 1'-0"


NOTE:
ALL HVAC EQUIPMENT SHOWN IS NEW. EXISTING HVAC EQUIPMENT SHALL BE REMOVED PRIOR TO CONSTRUCTION.

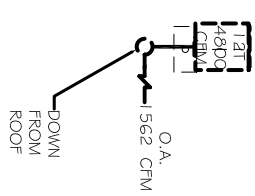

MEZZANINE OFFICES MECHANICAL PLAN
SCALE: 1/8" = 1'-0"

LEGEND

- - SUPPLY AIR DUCT
- - RETURN AIR DUCT
- - - EXHAUST DUCT
- ⊠ - 24 X 24 SUPPLY AIR GRILLE
- ⊠ - 24 X 24 RETURN AIR GRILLE
- ⊙ - THERMOSTAT
- ☐ - VENT/LIGHT

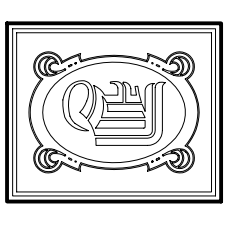

DAMMON ENGINEERING, INC.
CHIEF ENGINEER
EMMETT DAMMON, P.E.
CHIEF ARCHITECT
ROBERT WILTSE

1095 FLORIDA AVENUE
SLIDELL, LA. 70458
OFFICE: 985-649-5832
FAX: 985-641-5950

WEBSITE:
WWW.DAMMONENGINEERING.COM
EMAIL:
DAMMONENG@BELLSOUTH.NET

ARCHITECTURE
ENGINEERING
STUDIES
PLANNING
INVESTIGATION
EXPERT WITNESS

NORTHSHORE
CHURCH
KENSINGTON DR.
SLIDELL, LA

ZONE 4, OFFICES
MECHANICAL
PLANS