



# MECHANICAL KEY PLAN


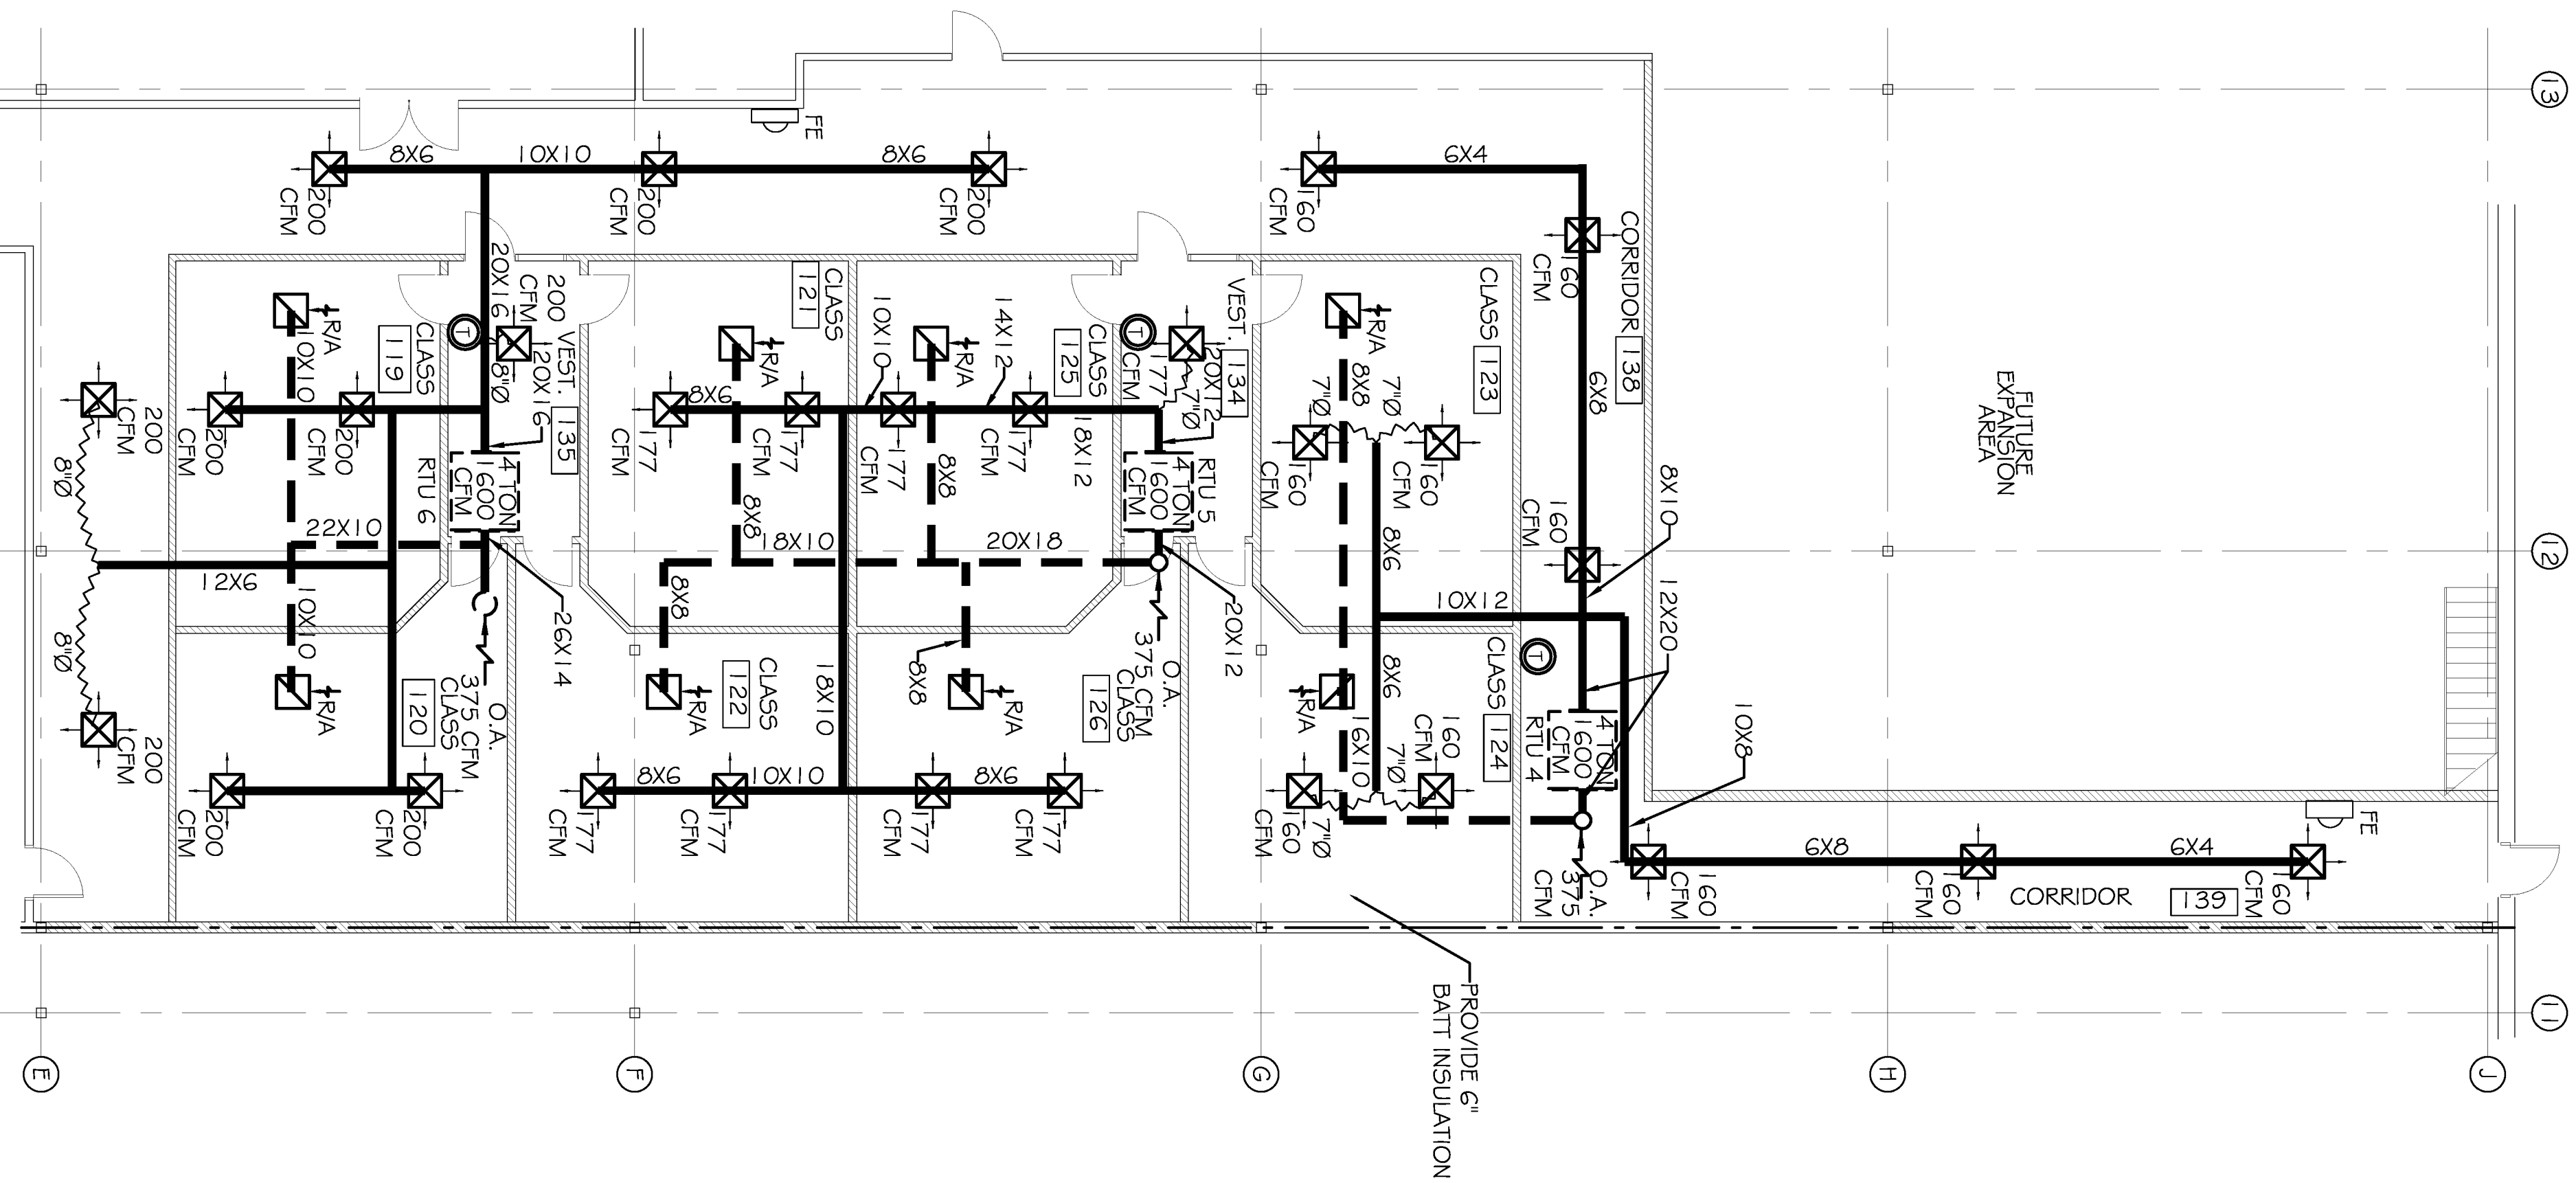


N.T.S.

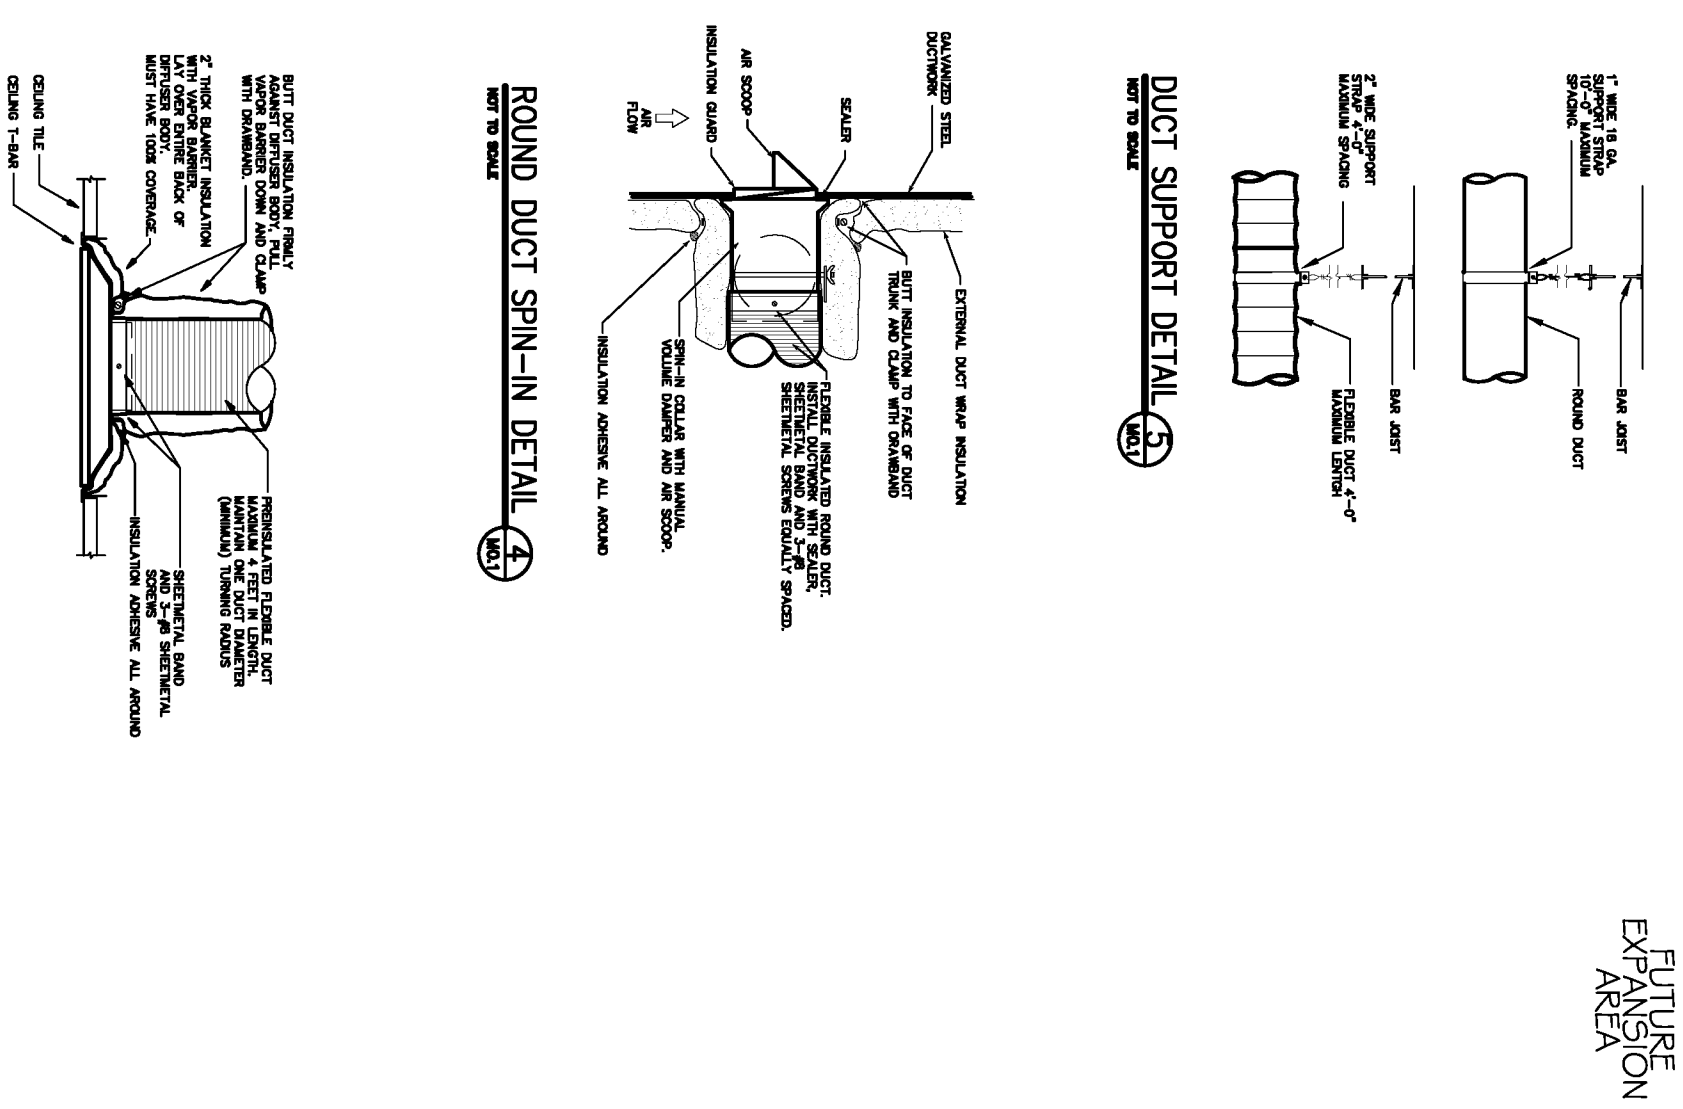



# ZONE 2 MECHANICAL PLAN

SCALE: 1/8"=1'-0"

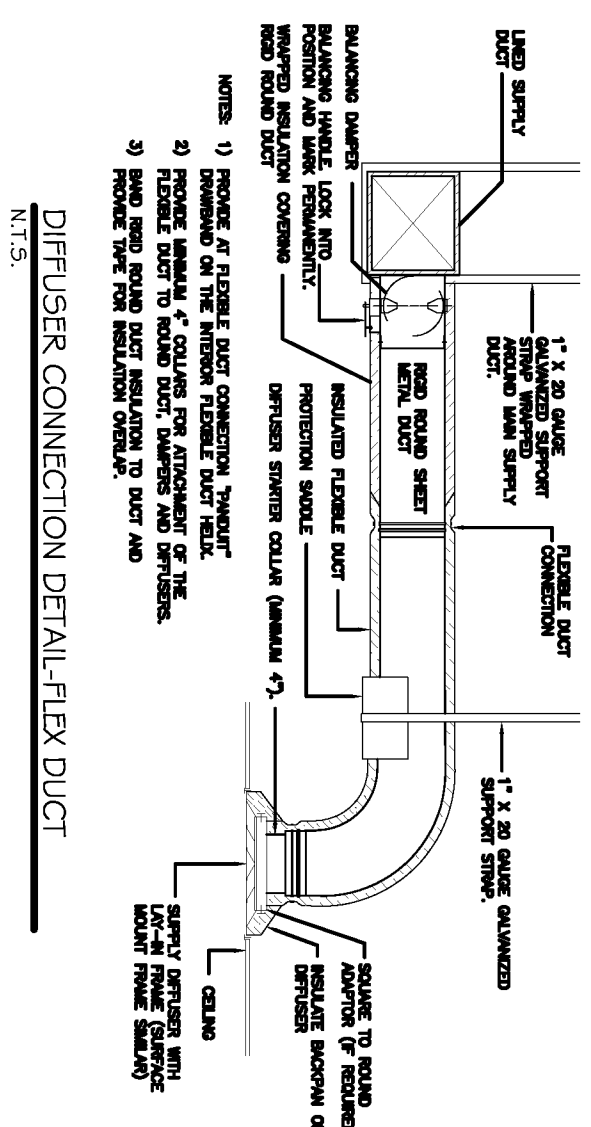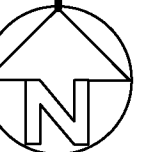




N.T.S.

## FLEX DUCT SUPPORT DETAIL

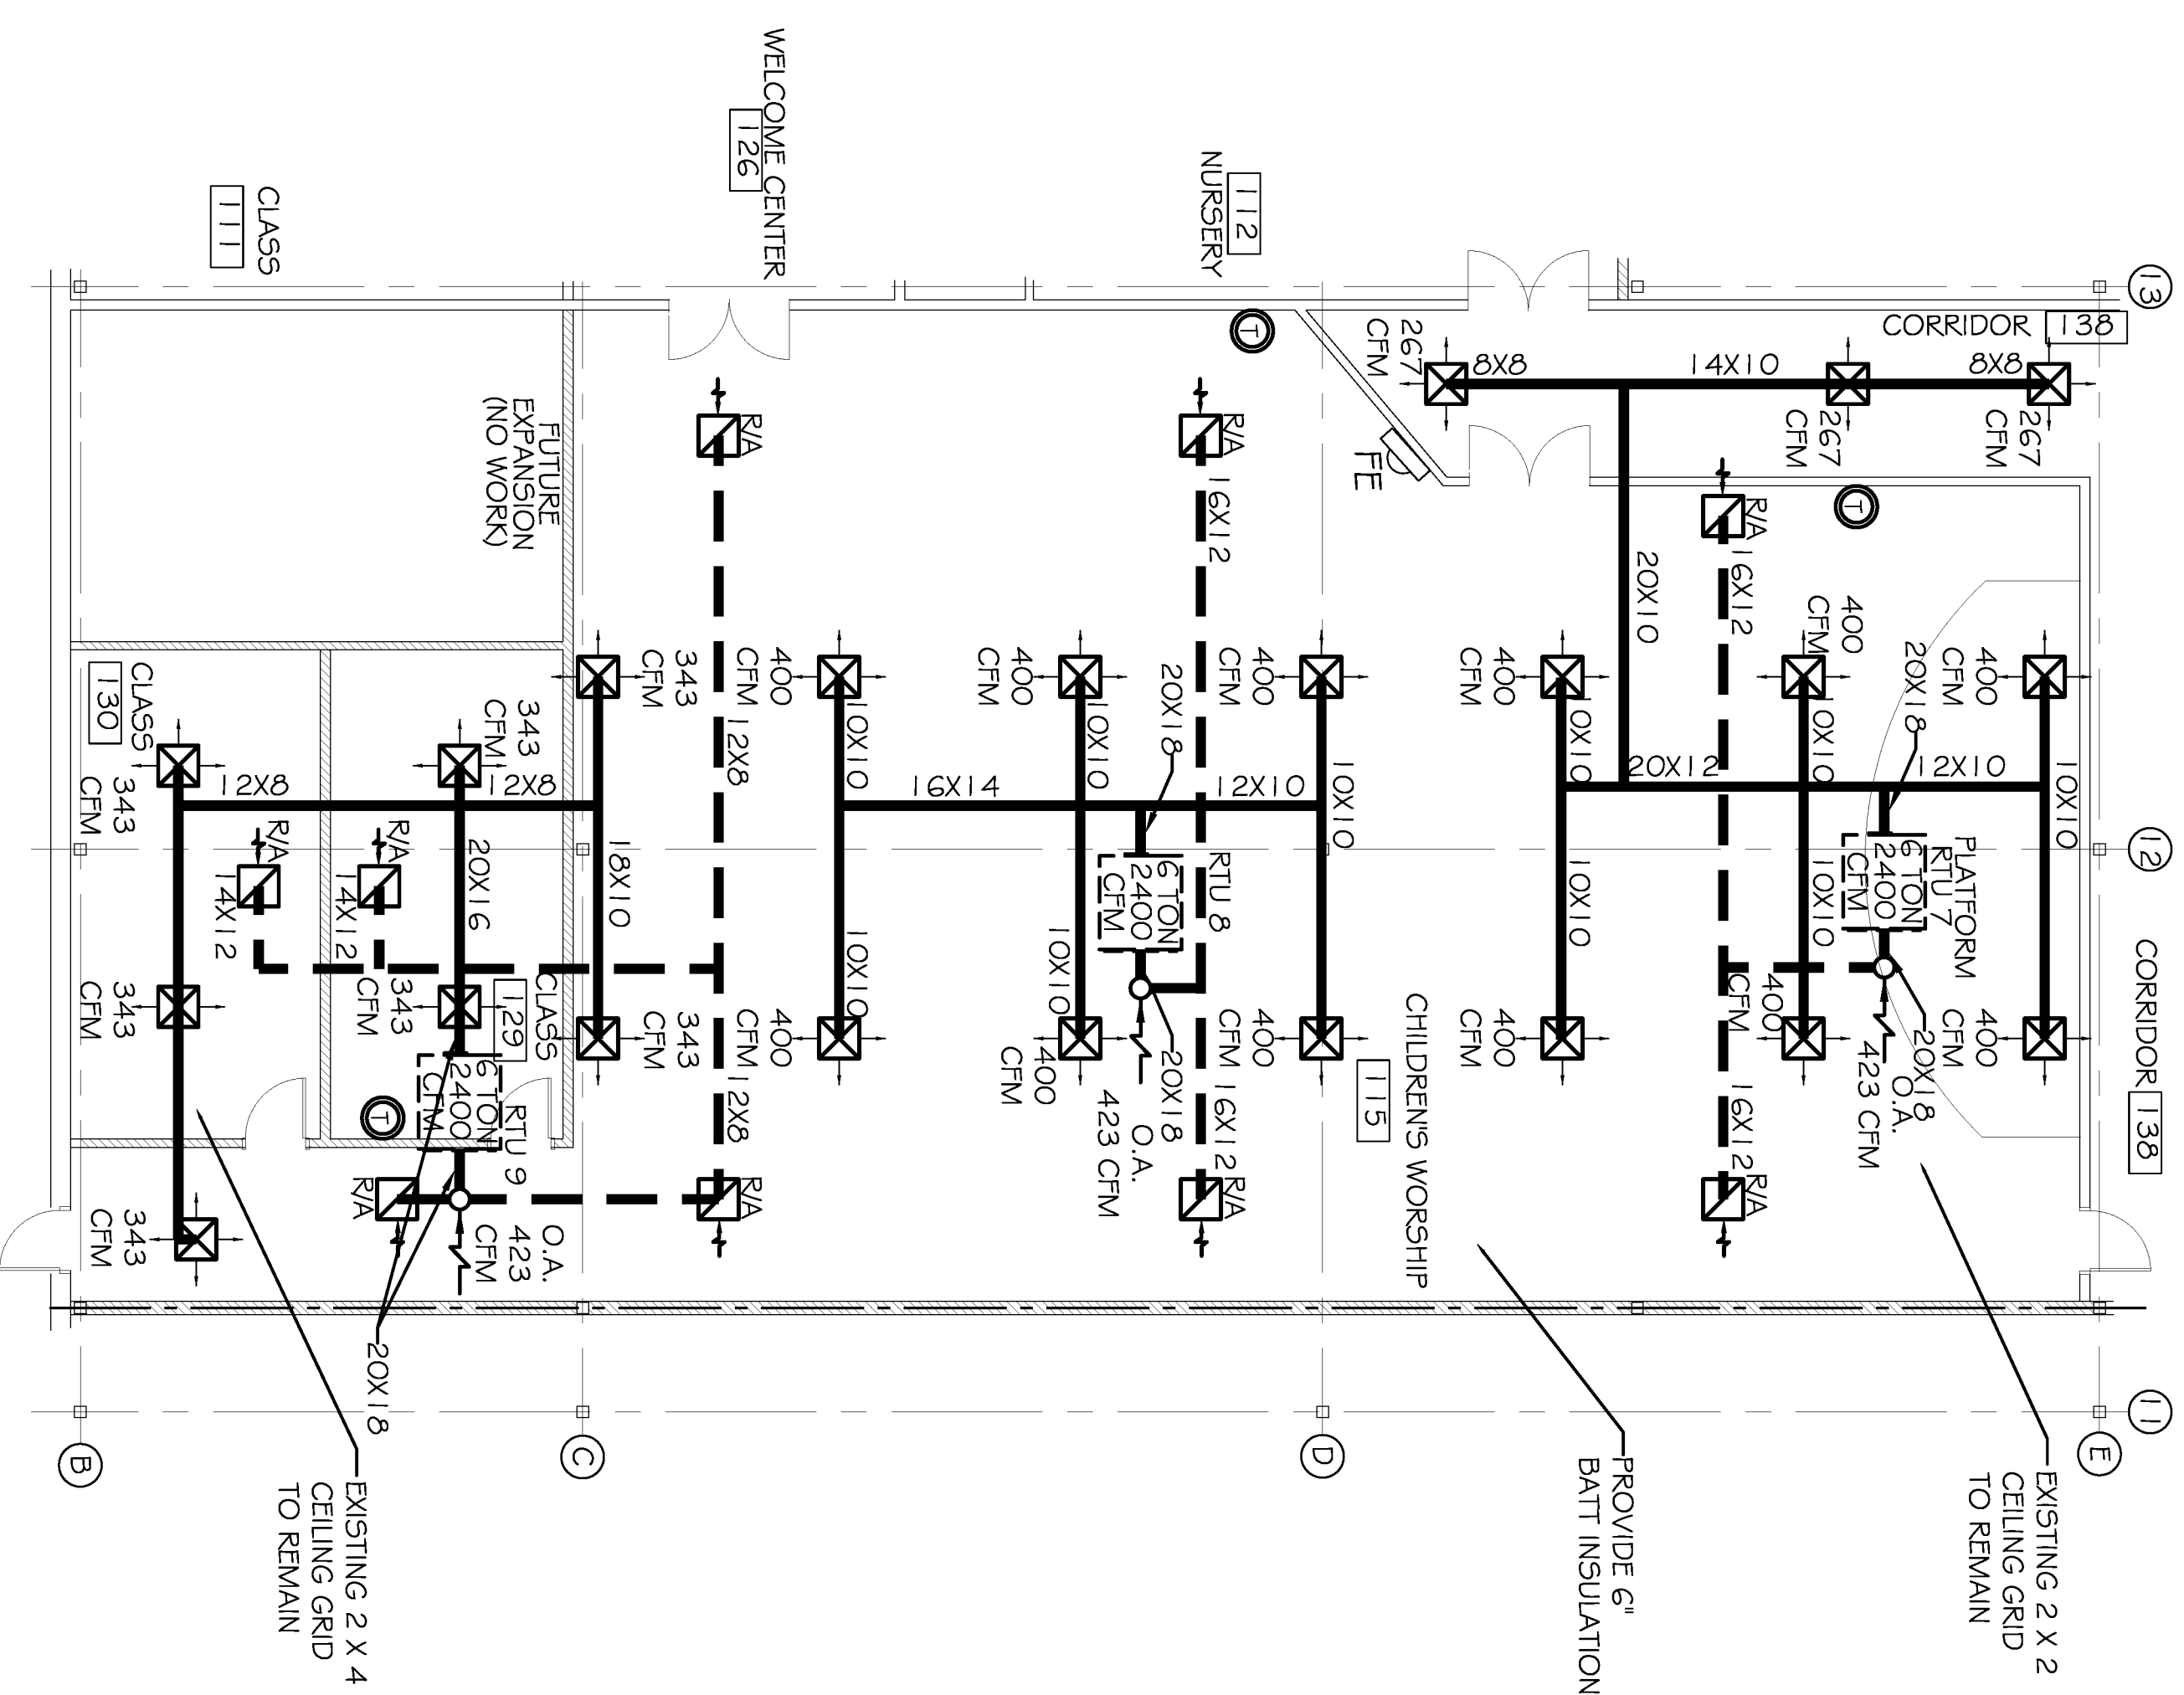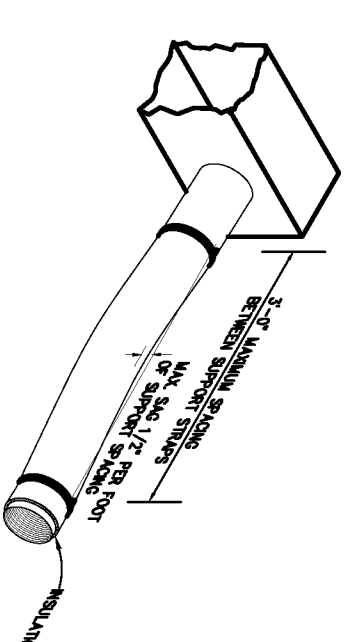

# ZONE 3 MECHANICAL PLAN

SCALE: 1/8"=1'-0"

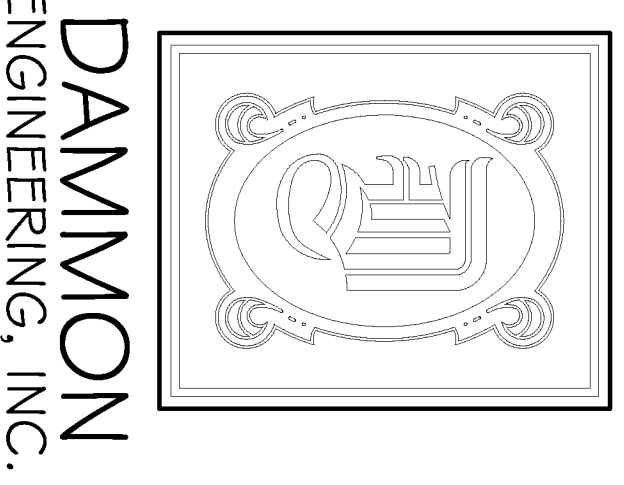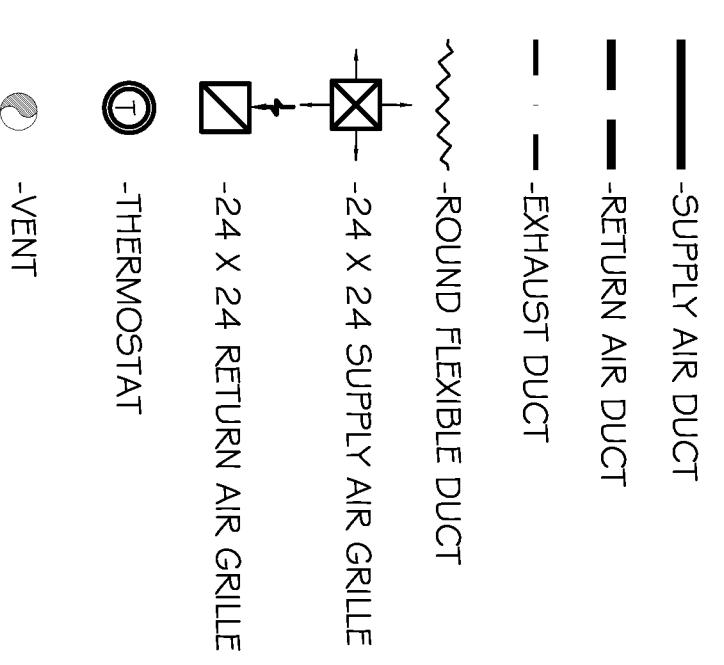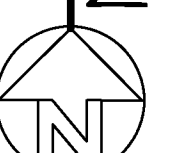

**DAMMON ENGINEERING, INC.**  
 CHIEF ENGINEER  
 EMANUETT DAMMON, P.E.  
 CHIEF ARCHITECT  
 ROBERT WILTSE

1095 FLORIDA AVENUE  
 SLIDELL, LA, 70458  
 OFFICE: 985-649-5632  
 FAX: 985-641-5950  
 WEBSITE: WWW.DAMMONENGINEERING.COM  
 EMAIL: DAMMONENG@BELLSouth.NET

ARCHITECTURE  
 ENGINEERING  
 STUDIES  
 PLANNING  
 INVESTIGATION  
 EXPERT WITNESSES

NORTHSHORE CHURCH  
 KENSINGTON DR.  
 SLIDELL, LA

ZONES 2 & 3  
 MECHANICAL  
 PLAN

REV: #1	06-08-09
SCALE:	AS NOTED
JOB#:	1988
DATE:	09-30-08
SHEET	

M-2

OF