

DAMMON
ENGINEERING, INC.

CHIEF ENGINEER
EMMETT
DAMMON, P.E.
CHIEF ARCHITECT
ROBERT
WILTSE

1095 FLORIDA AVENUE
SLIDELL, LA, 70456
OFFICE: 985-649-5632
FAX: 985-641-5950


WWW.DAMMONENGINEERING.COM
EMAIL:
DAMMONENG@BELLSouth.NET

ARCHITECTURE
ENGINEERING
STUDIES
PLANNING
INVESTIGATION
EXPERT WITNESSES

NORTHSHORE
CHURCH
KENSINGTON DR.
SLIDELL, LA


ZONE 4, OFFICES
MECHANICAL
PLANS

REV: #1	06-08-09
SCALE:	AS NOTED
JOB#:	1988
DATE:	09-30-08
SHEET	
M-3	

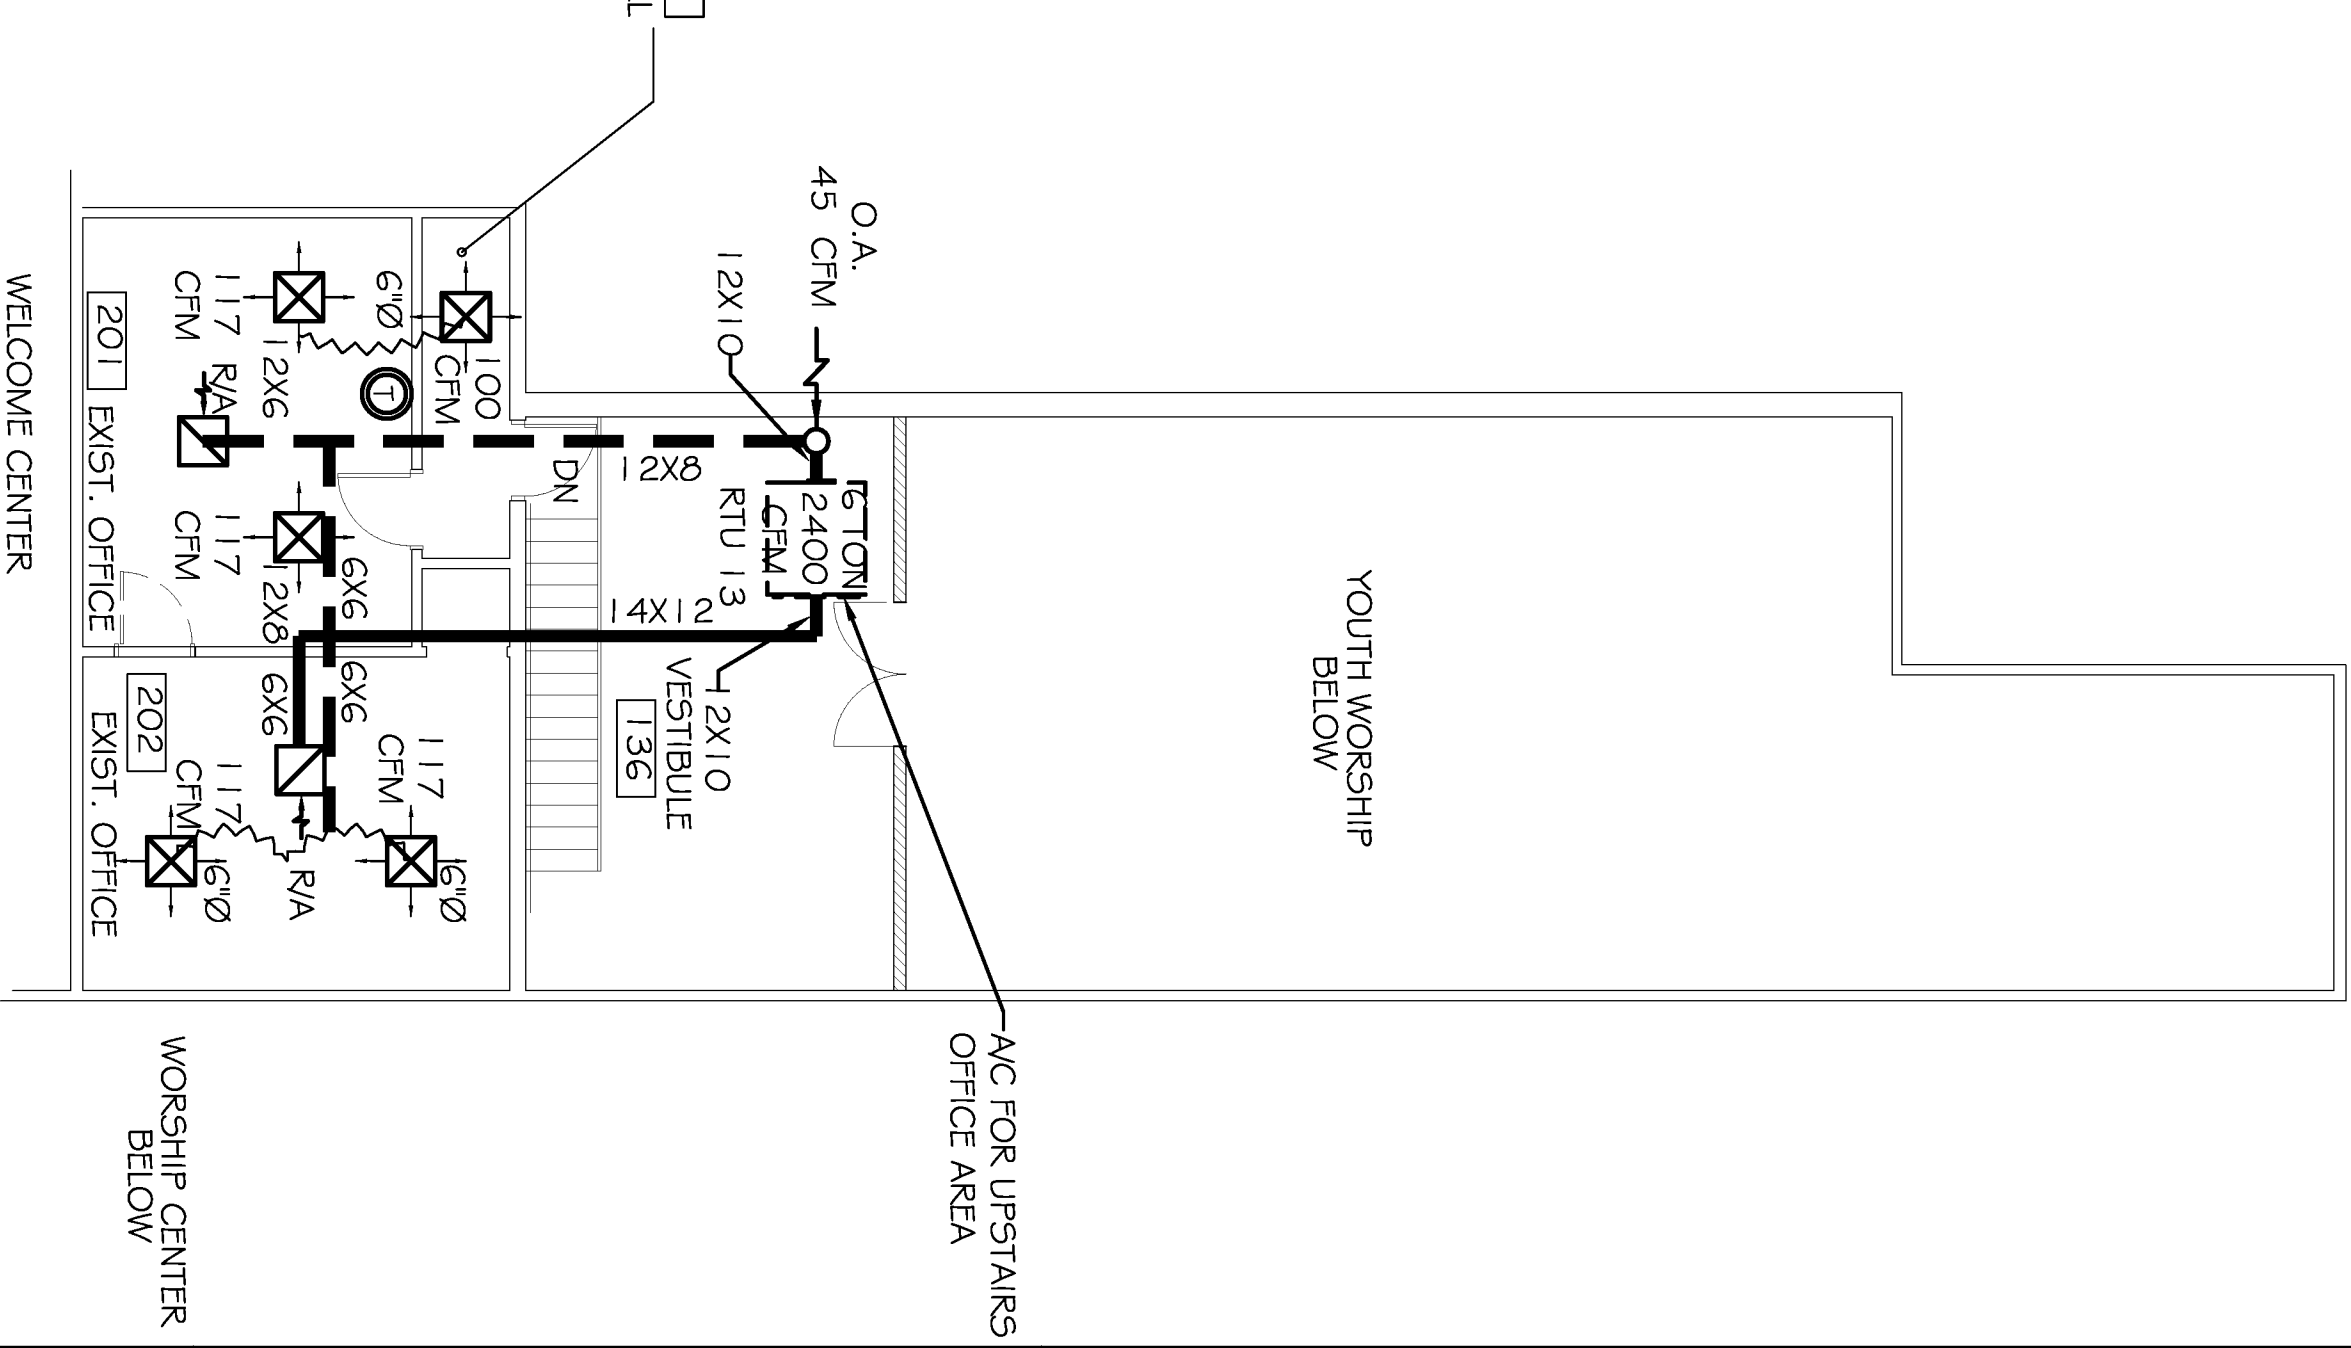

LEGEND

- SUPPLY AIR DUCT
- RETURN AIR DUCT
- EXHAUST DUCT
- ~ ROUND FLEXIBLE DUCT
- ⊠ -24 X 24 SUPPLY AIR GRILLE
- ⊠ -24 X 24 RETURN AIR GRILLE
- ⊕ -THERMOSTAT
- ⊙ -VENT

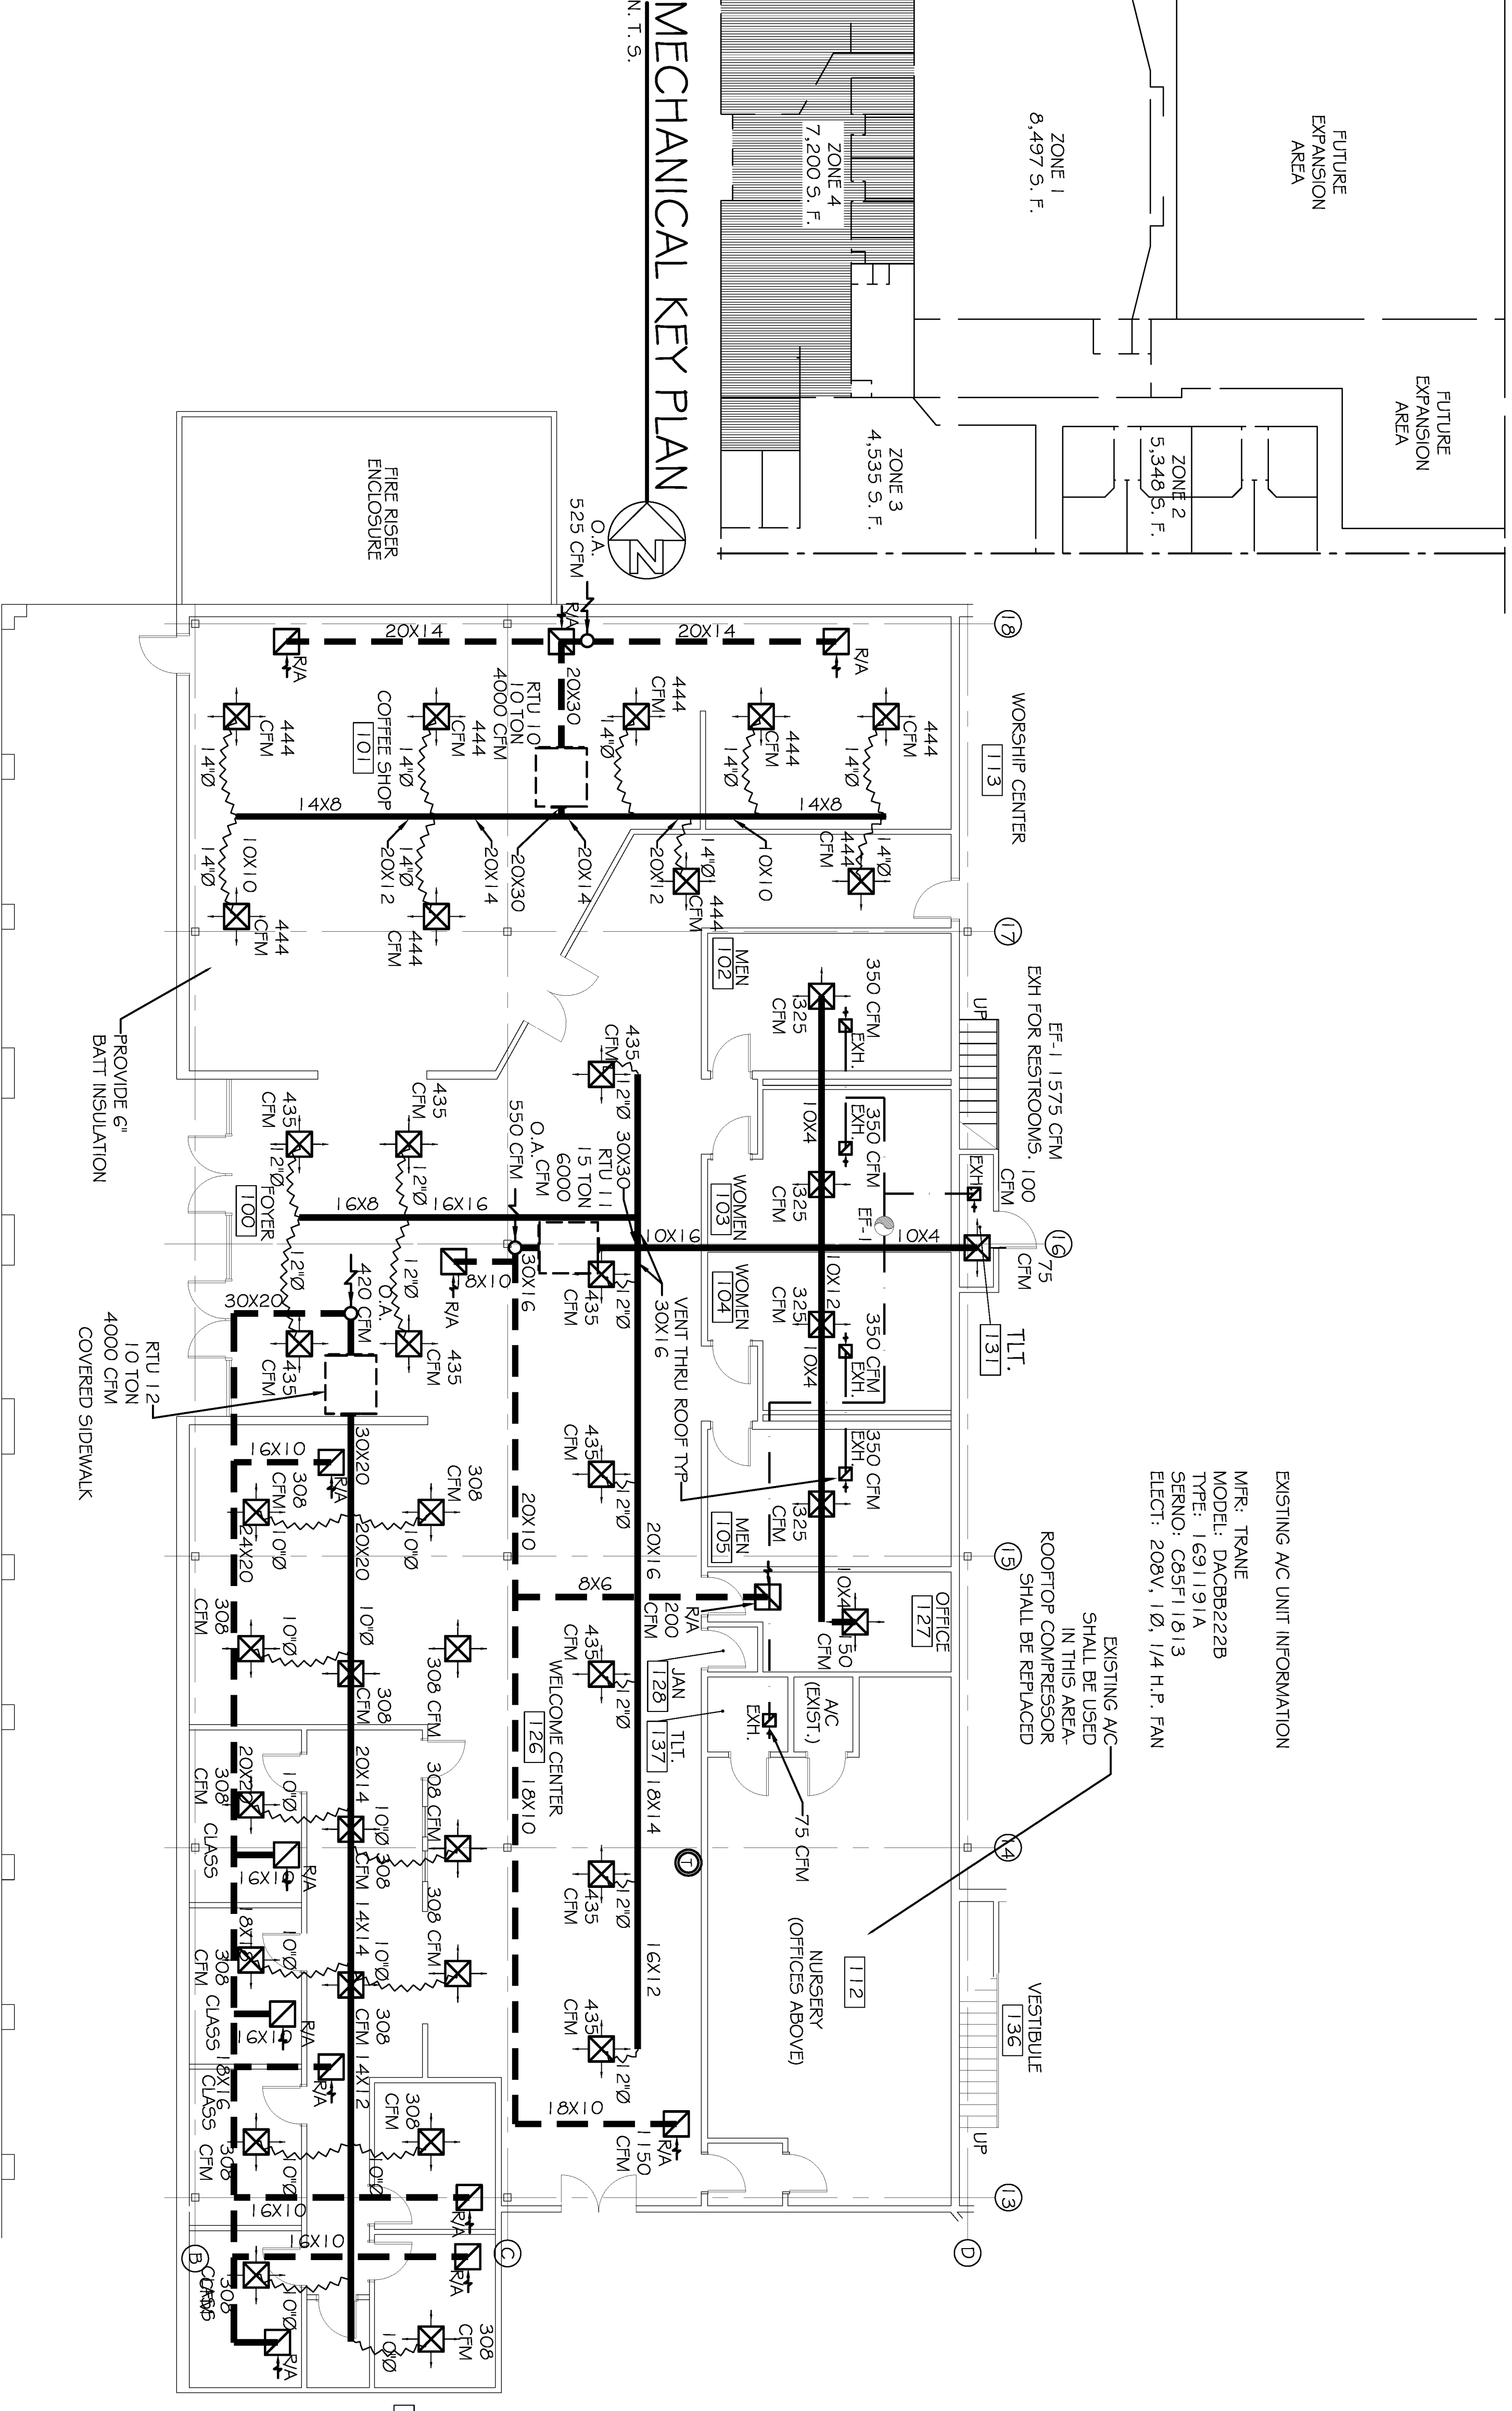

EXISTING AC UNIT INFORMATION
MFR: TRANE
MODEL: DACRB222B
TYPE: 1631191A
SERNO: C65F11813
ELECT: 208V, 1Ø, 1/4 H.P. FAN

NOTE:
ALL HVAC EQUIPMENT SHOWN IS NEW. EXISTING HVAC EQUIPMENT
SHALL BE REMOVED PRIOR TO CONSTRUCTION.

ZONE 4 MECHANICAL PLAN
SCALE: 1/8" = 1'-0"

