

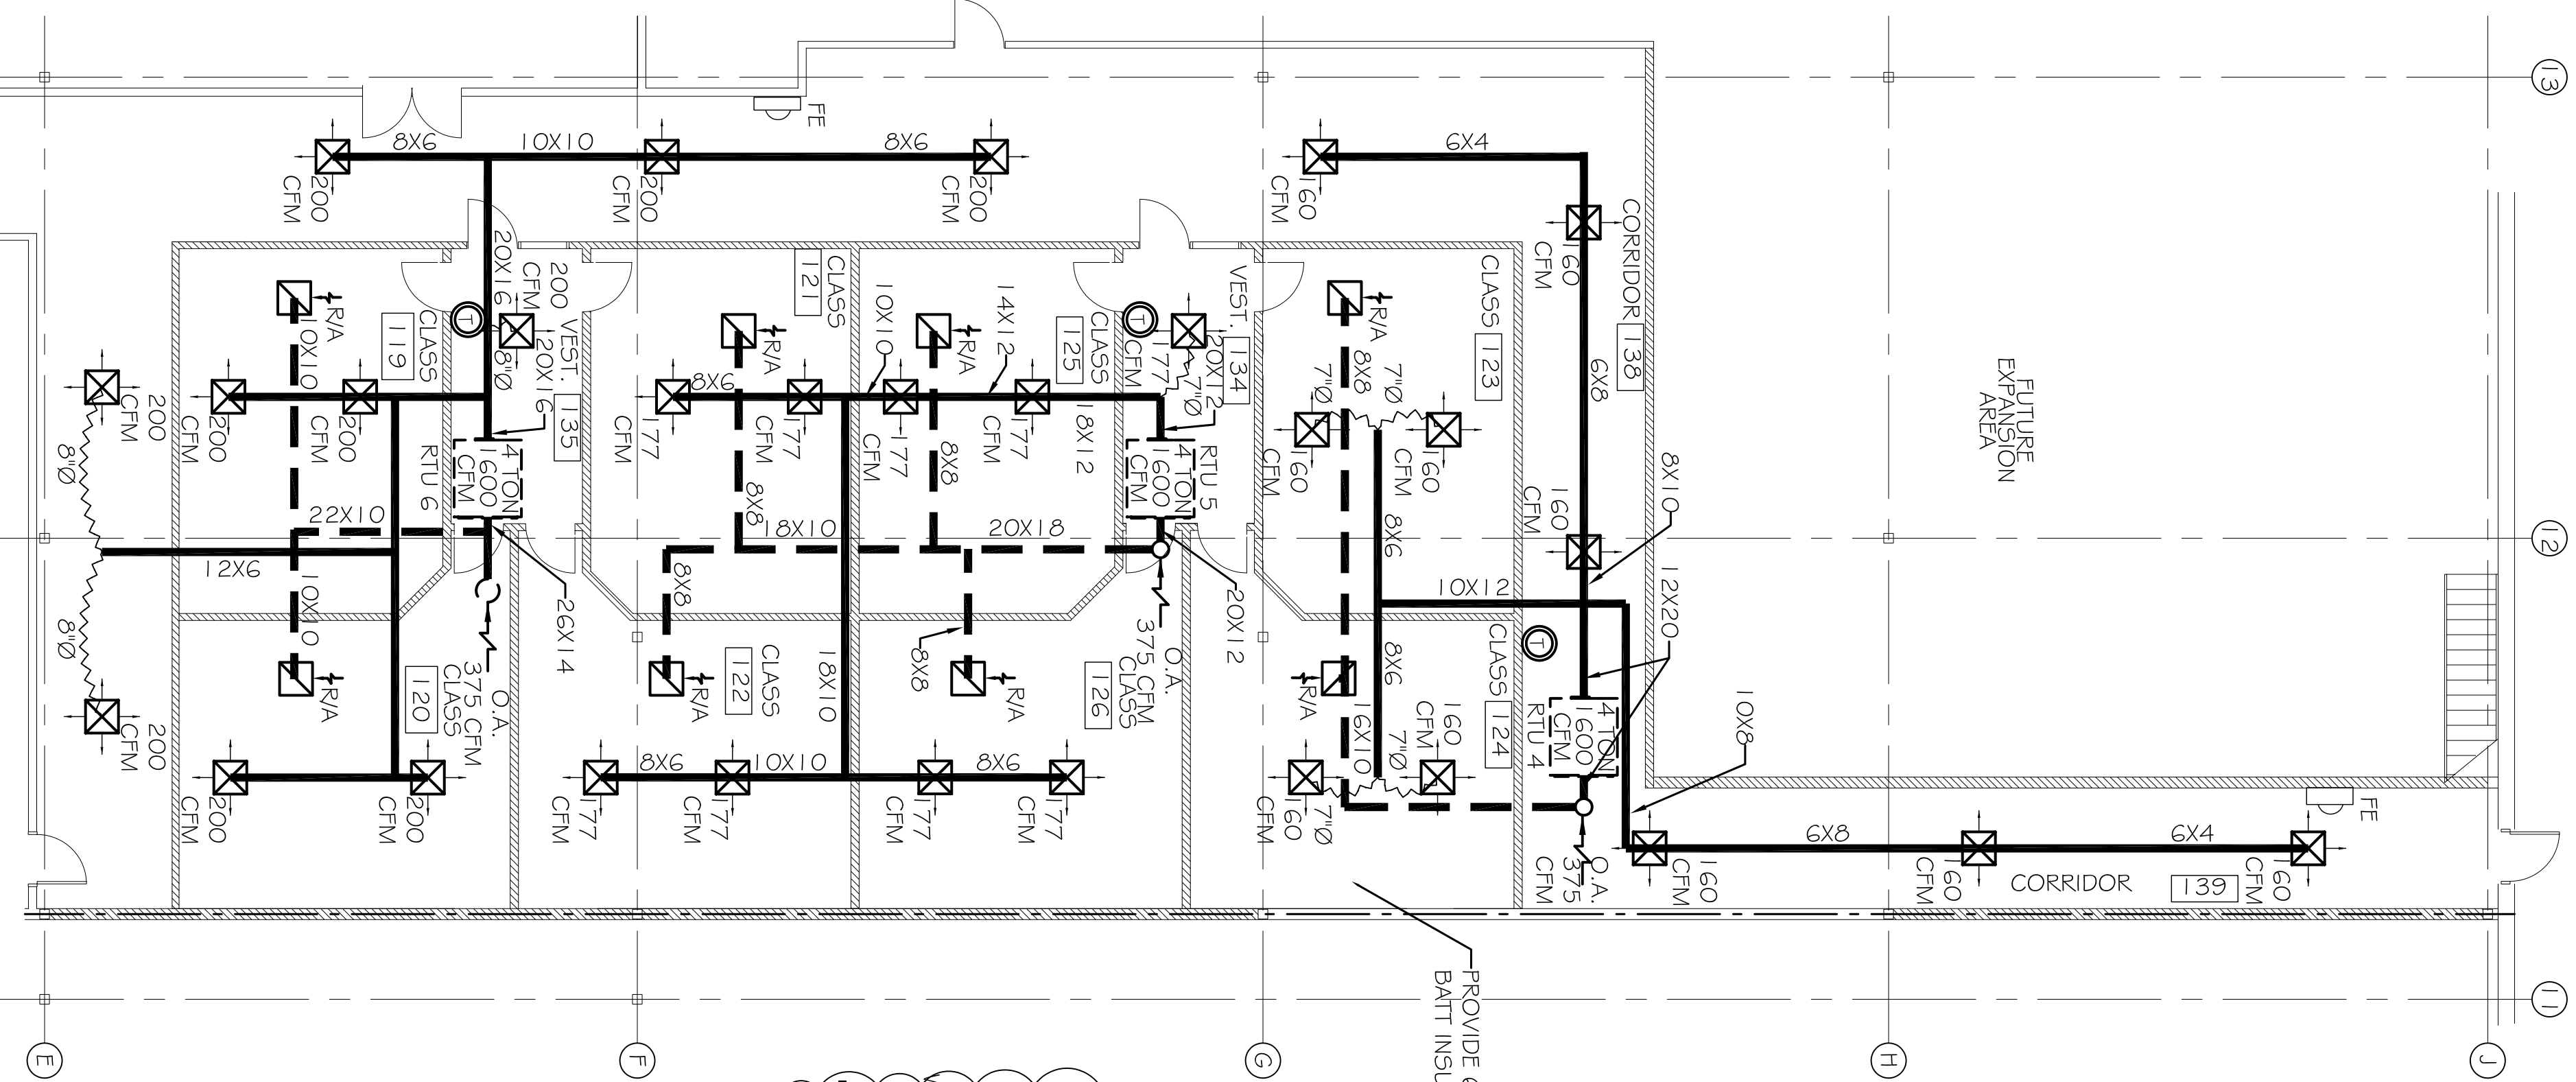






MECHANICAL KEY PLAN
N.T.S.

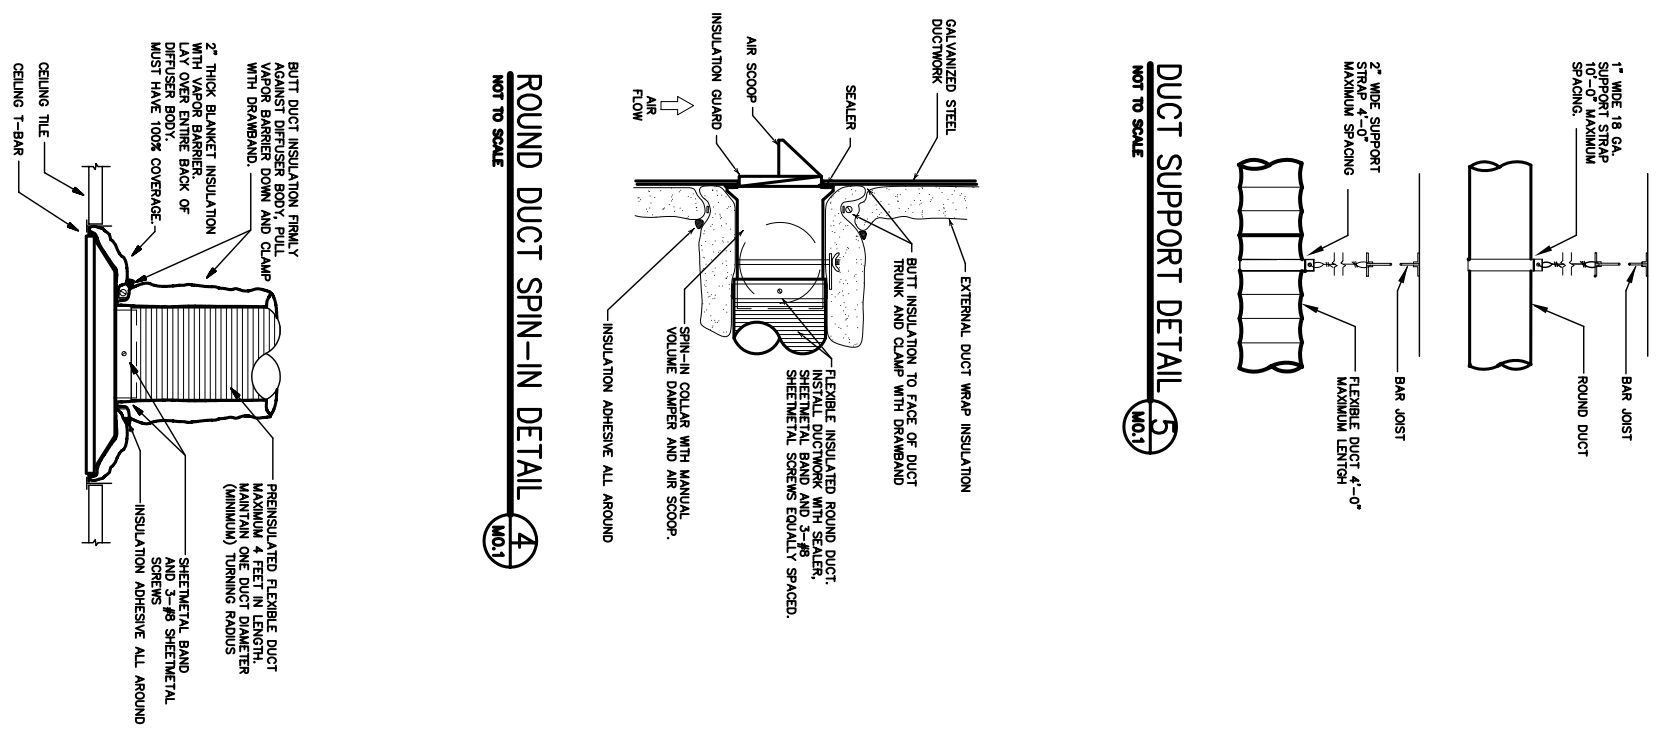

ZONE 2 MECHANICAL PLAN
SCALE: 1/8"=1'-0"

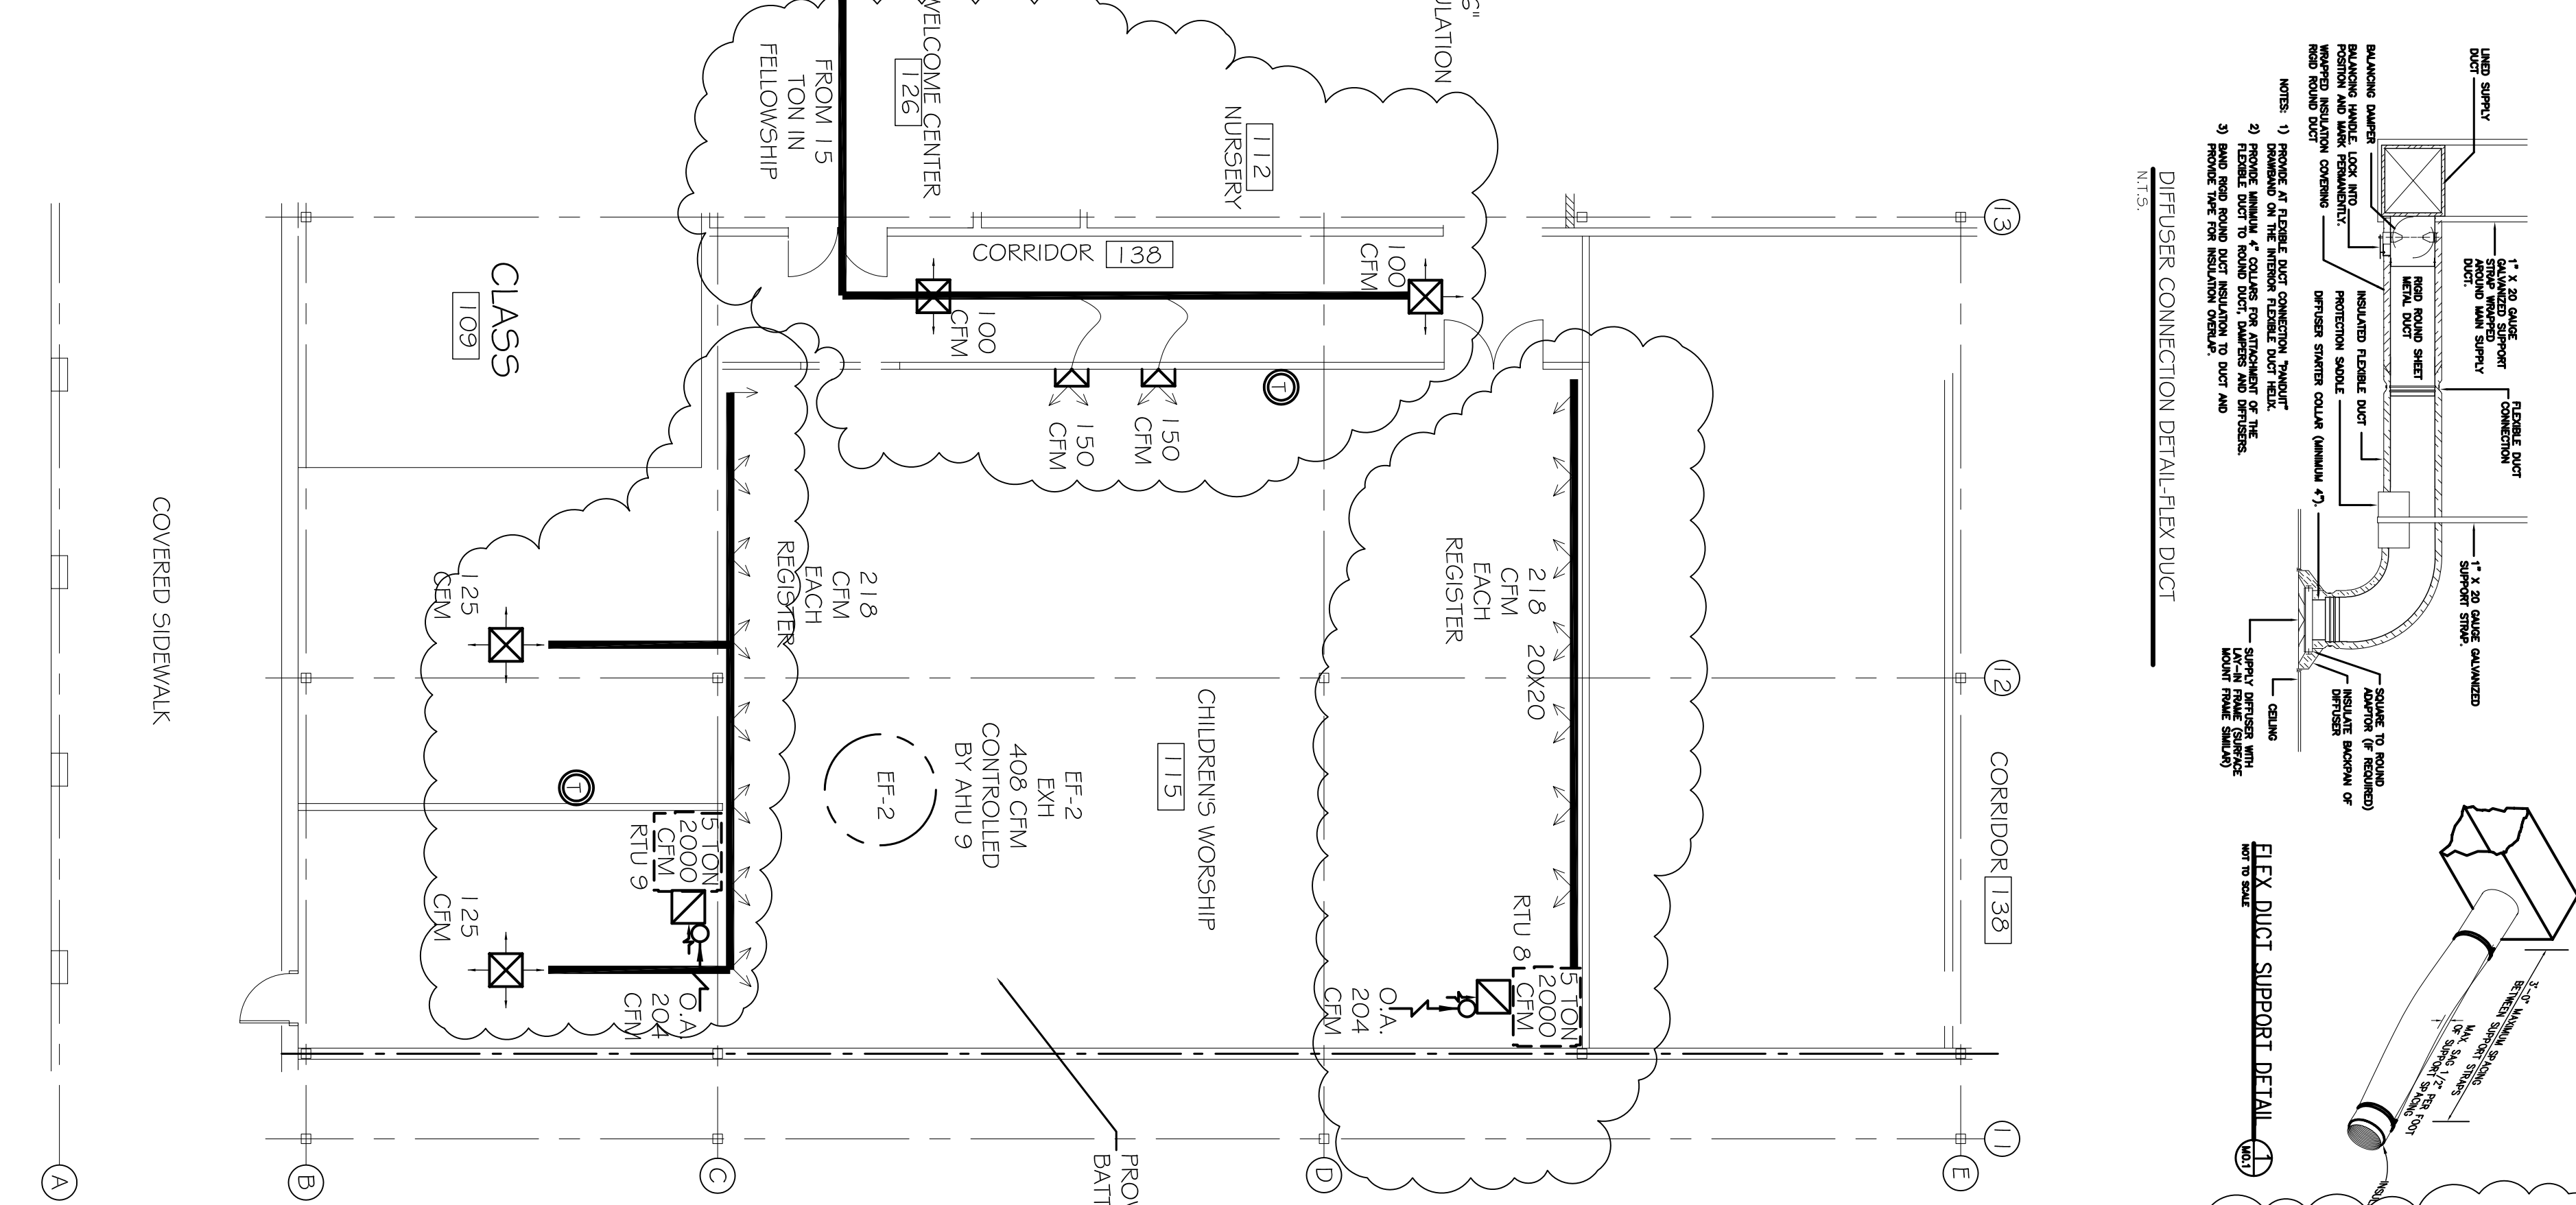

ZONE 3 MECHANICAL PLAN
SCALE: 1/8"=1'-0"

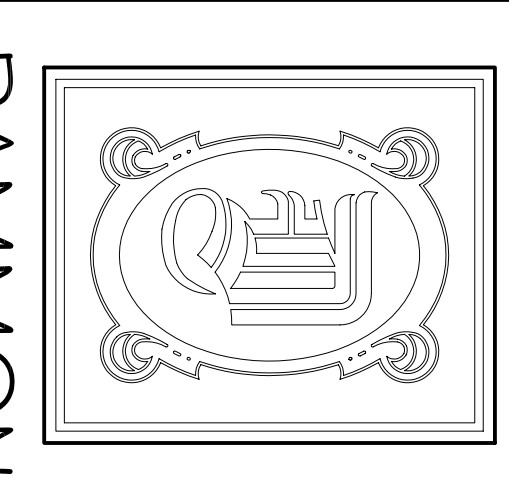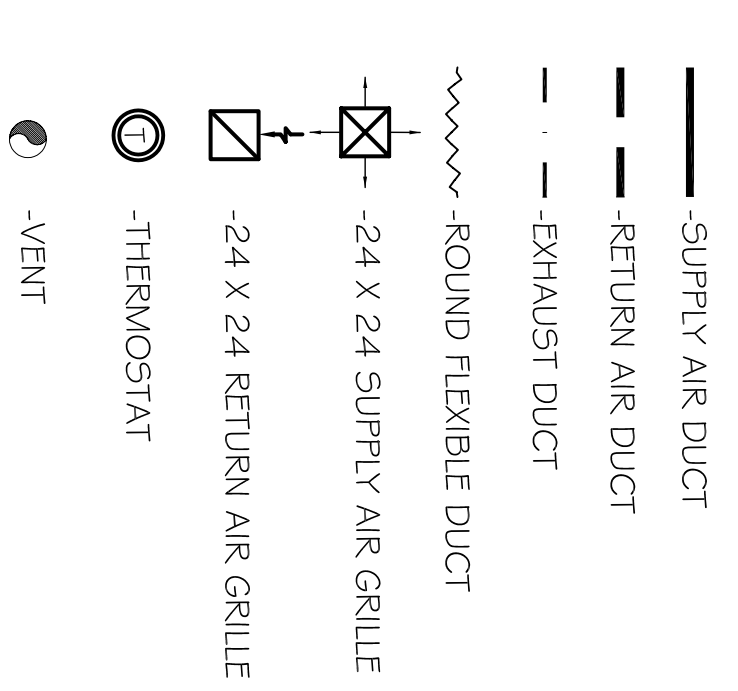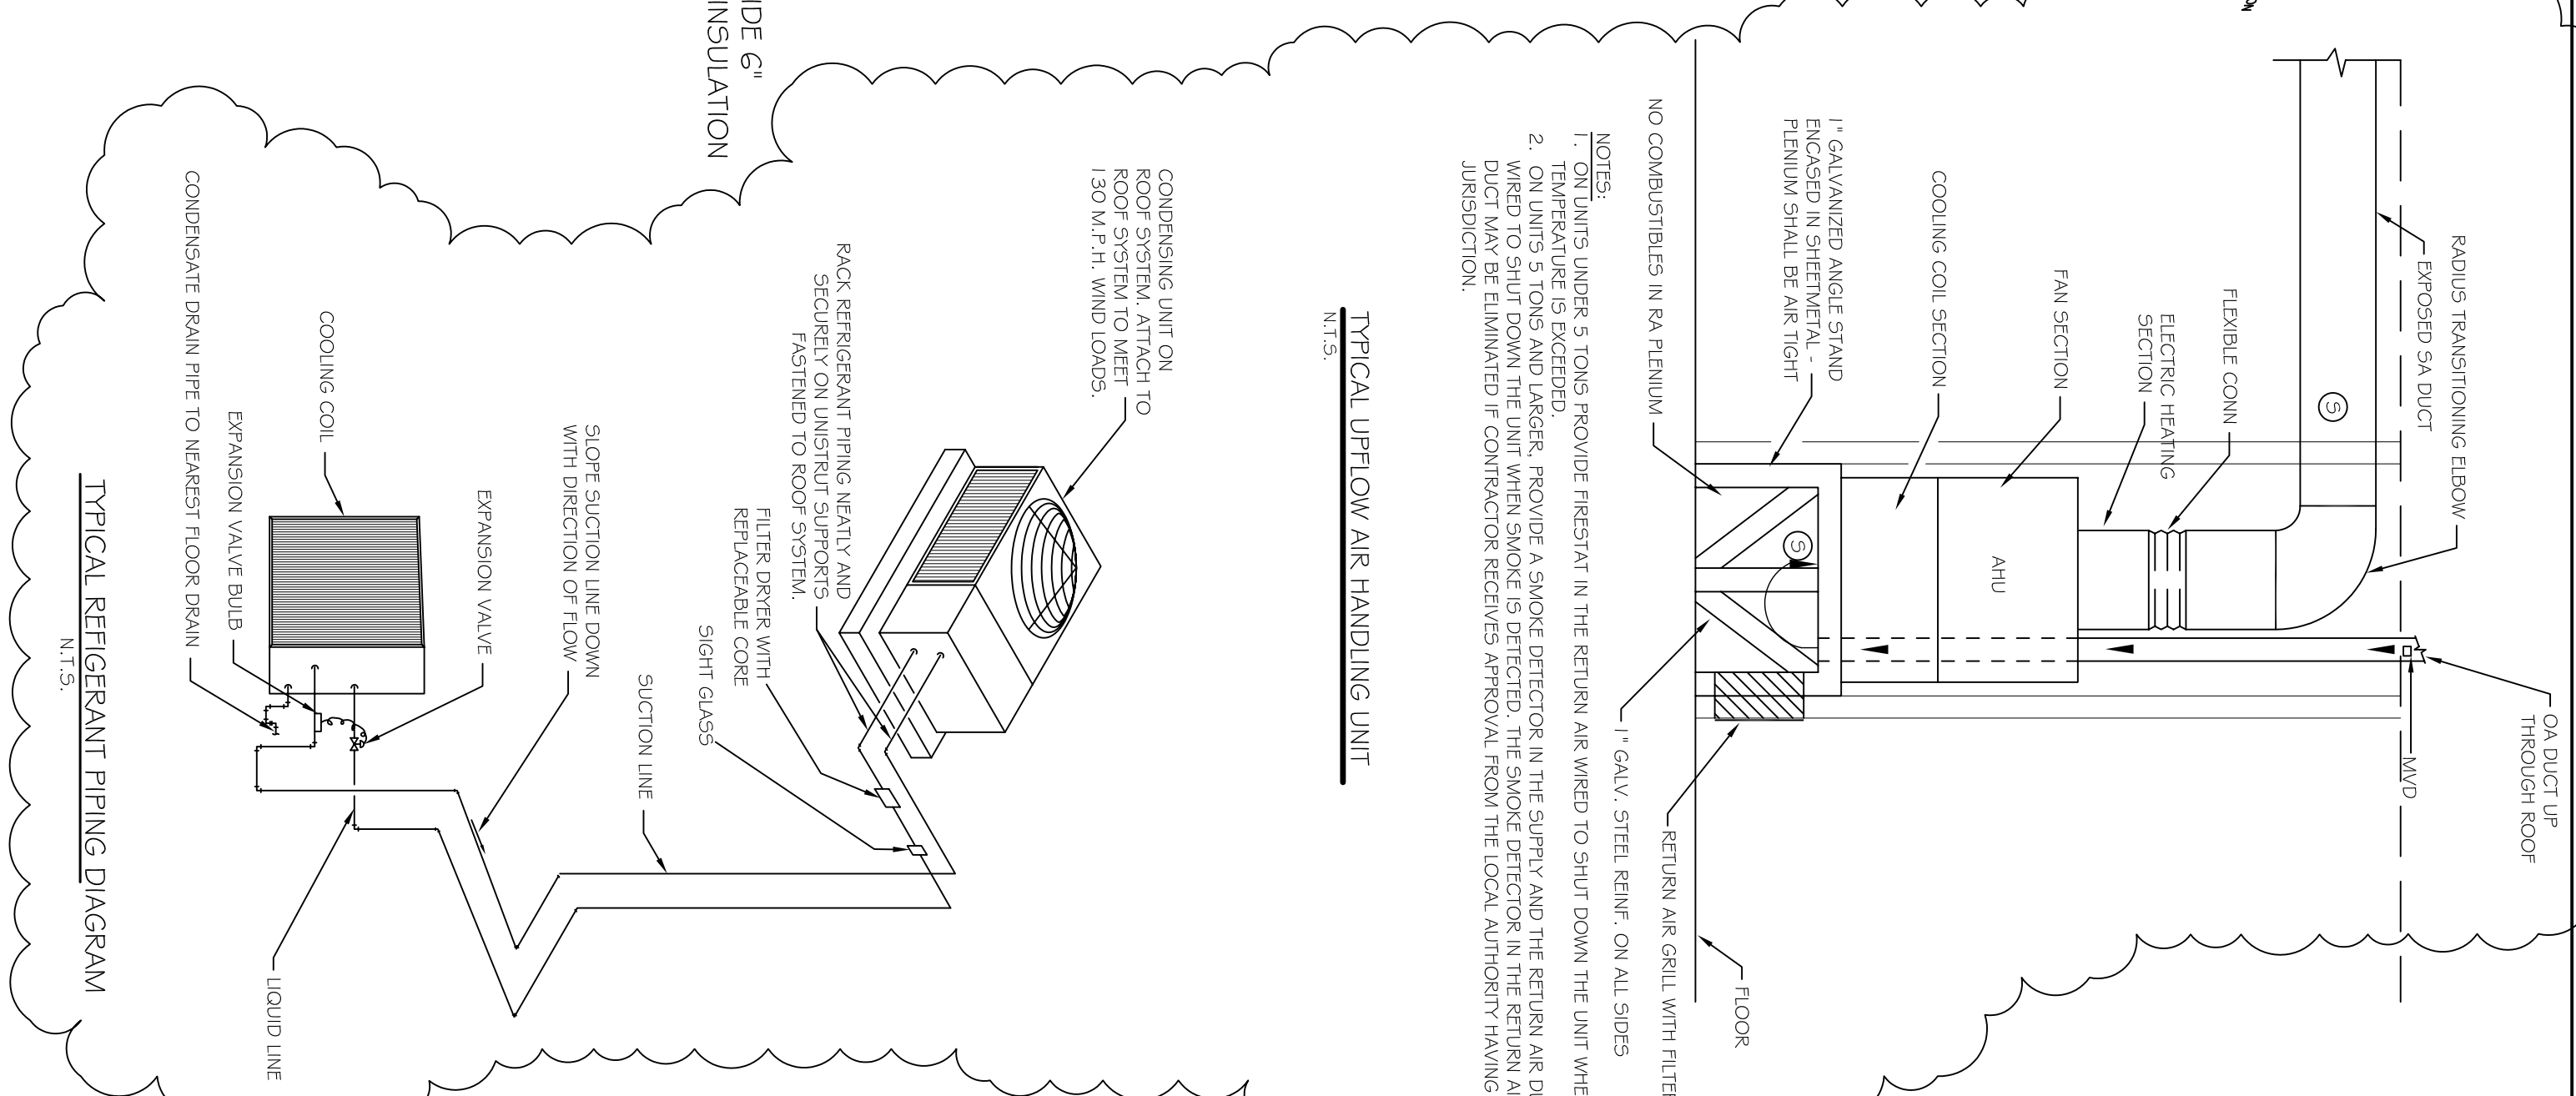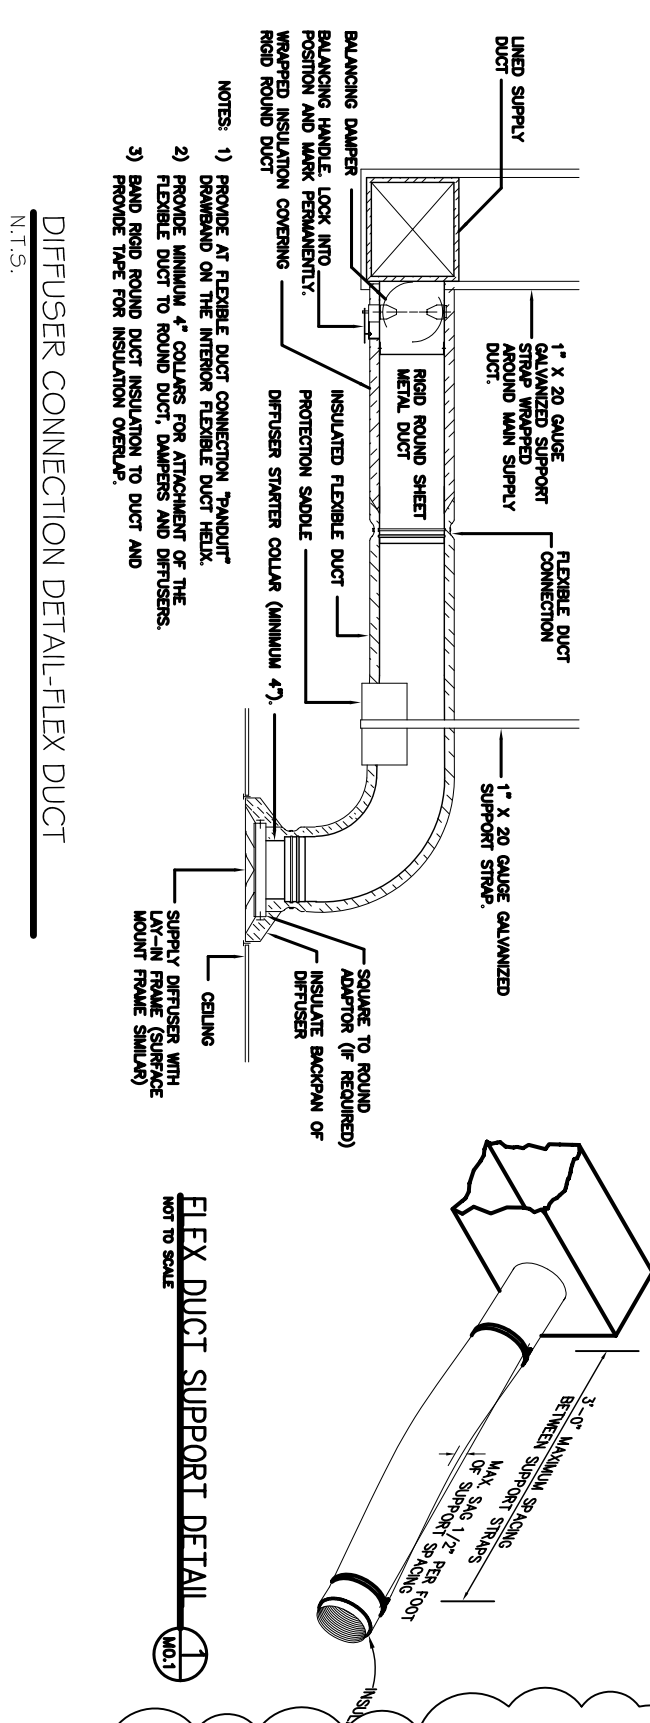

DAMMON ENGINEERING, INC.
CHIEF ENGINEER
EMMETT DAMMON, P.E.
CHIEF ARCHITECT
ROBERT WILTSE

1095 FLORIDA AVENUE
SLIDELL, LA, 70458
OFFICE: 985-649-5632
FAX: 985-641-5950
WEBSITE:
WWW.DAMMONENGINEERING.COM
EMAIL:
DAMMONENR@Bellsouth.net

ARCHITECTURE
ENGINEERING
STUDIES
PLANNING
INVESTIGATION
EXPERT WITNESSES

NORTHSHORE
CHURCH
KENSINGTON DR.
SLIDELL, LA

ZONES 2 & 3
MECHANICAL
PLAN

REV: #3 11-2-09
SCALE: AS NOTED
JOB#: 1988
DATE: 09-30-08
SHEET

M-2
OF