

DAMMON
ENGINEERING, INC.

CHIEF ENGINEER
EMMETT
DAMMON, P.E.

CHIEF ARCHITECT
ROBERT
WILTSE

554 OLD SPANISH TRAIL
SLIDELL, LA. 70458
OFFICE: 985-649-5832
FAX: 985-641-5950

WEBSITE:
WWW.DAMMONENGINEERING.COM


EMAIL:
DAMMONENG@BELLSOUTH.NET

ARCHITECTURE
ENGINEERING
STUDIES
PLANNING
INVESTIGATION
EXPERT WITNESS

LIVING THE WORD
INTERNATIONAL

2528
OLD SPANISH TRAIL
SLIDELL, LA
70461

REFLECTED
CEILING PLAN

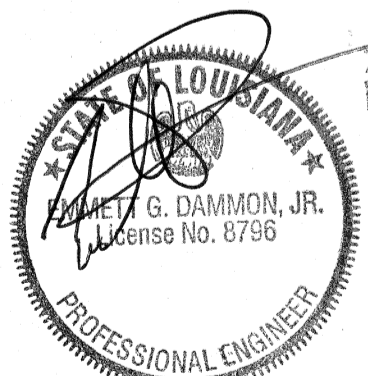

REV:

SCALE: AS NOTED


JOB#: 2128

DATE: 01-27-12

SHEET 11

A-3

OF 21

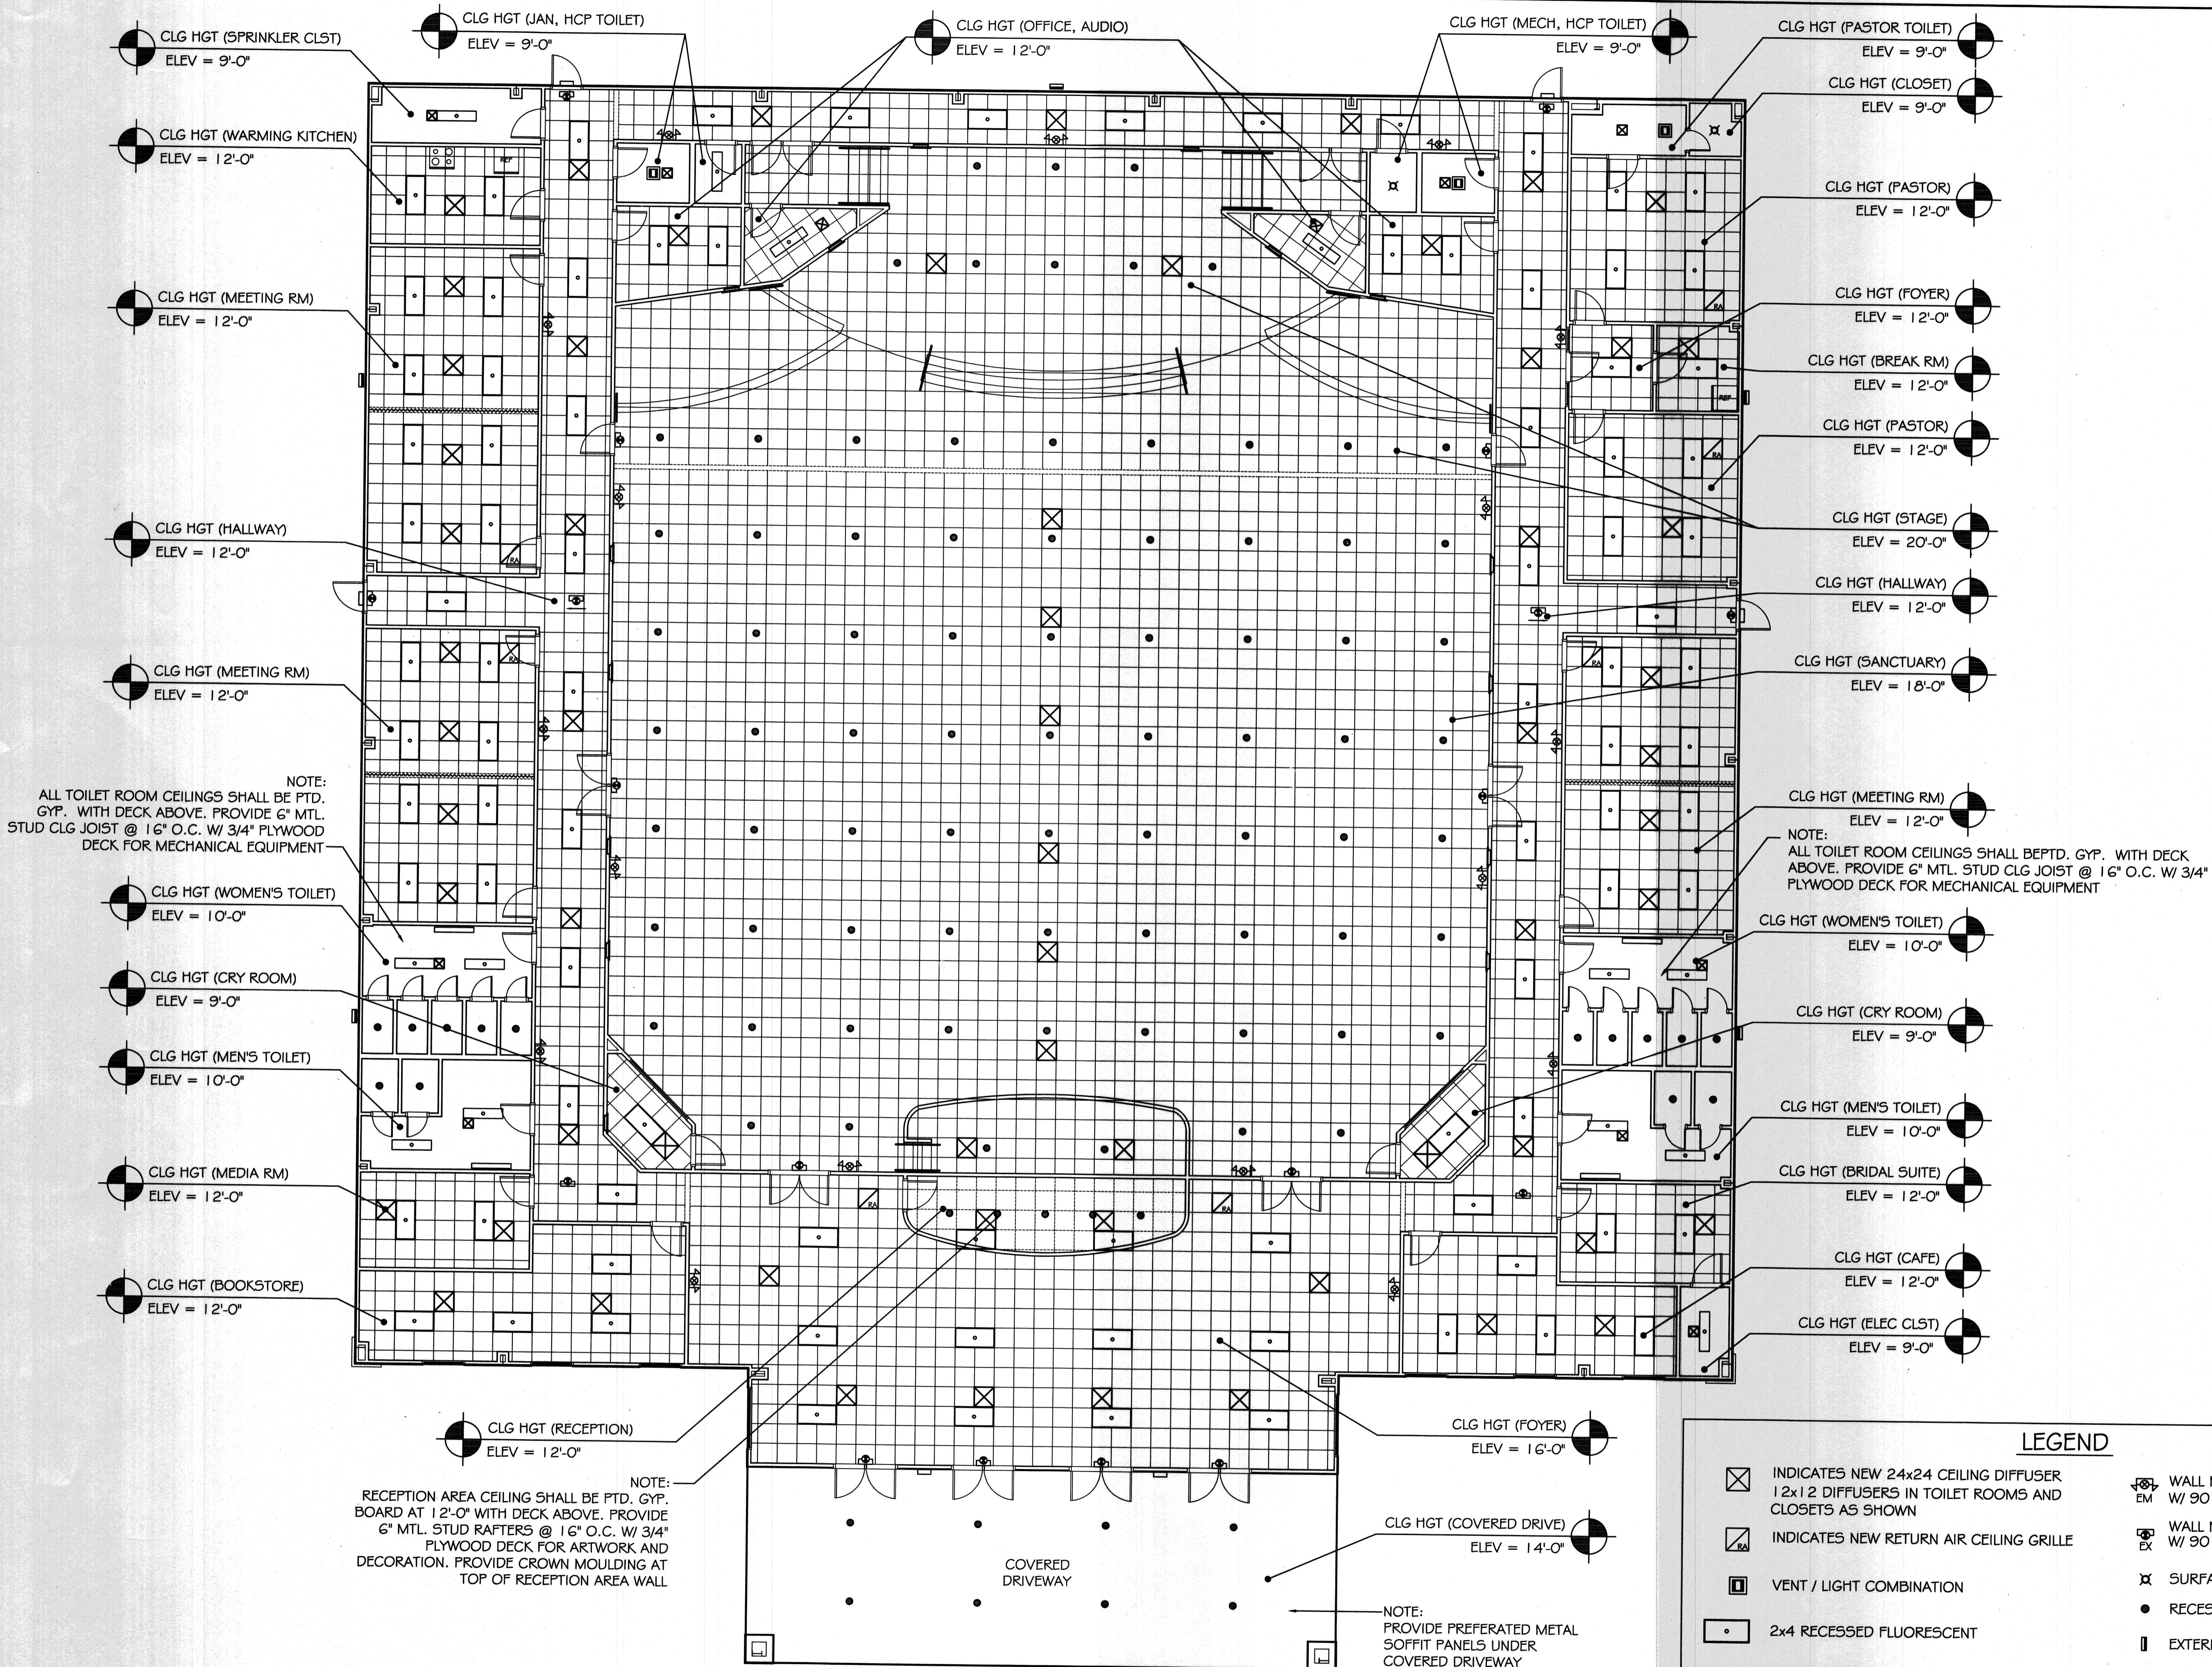

REFLECTED CEILING PLAN

SCALE: 1/8" = 1'-0"

LEGEND

	INDICATES NEW 24x24 CEILING DIFFUSER 12x12 DIFFUSERS IN TOILET ROOMS AND CLOSETS AS SHOWN		WALL MTD. EMER. LIGHT W/ 90 MIN. BATT. BACKUP
	INDICATES NEW RETURN AIR CEILING GRILLE		WALL MTD. LED EXIT SIGN W/ 90 MIN. BATT. BACKUP
	VENT / LIGHT COMBINATION		SURFACE MTD. DOWNLIGHT FIXTURE
	2x4 RECESSED FLUORESCENT		RECESSED DOWNLIGHT FIXTURE
	SURFACE MTD. 4' FLOURESCENT		EXTERIOR WALL PACK

NOTE:
SEE SHEET E-2 FOR FULL LIGHT FIXTURE DESCRIPTION