


ALL NEW RESTROOM CEILINGS SHALL BE 5/8" SHEETROCK ON 6" MTL CEILING JOISTS @ 16" O.C.

PROVIDE 3/4" PLYWOOD DECKING ON 8" MTL JOISTS @ 16" O.C. ABOVE SUSPENDED CEILING @ WATER HEATER LOCATION. CEILING HEIGHT @ 9'-0"

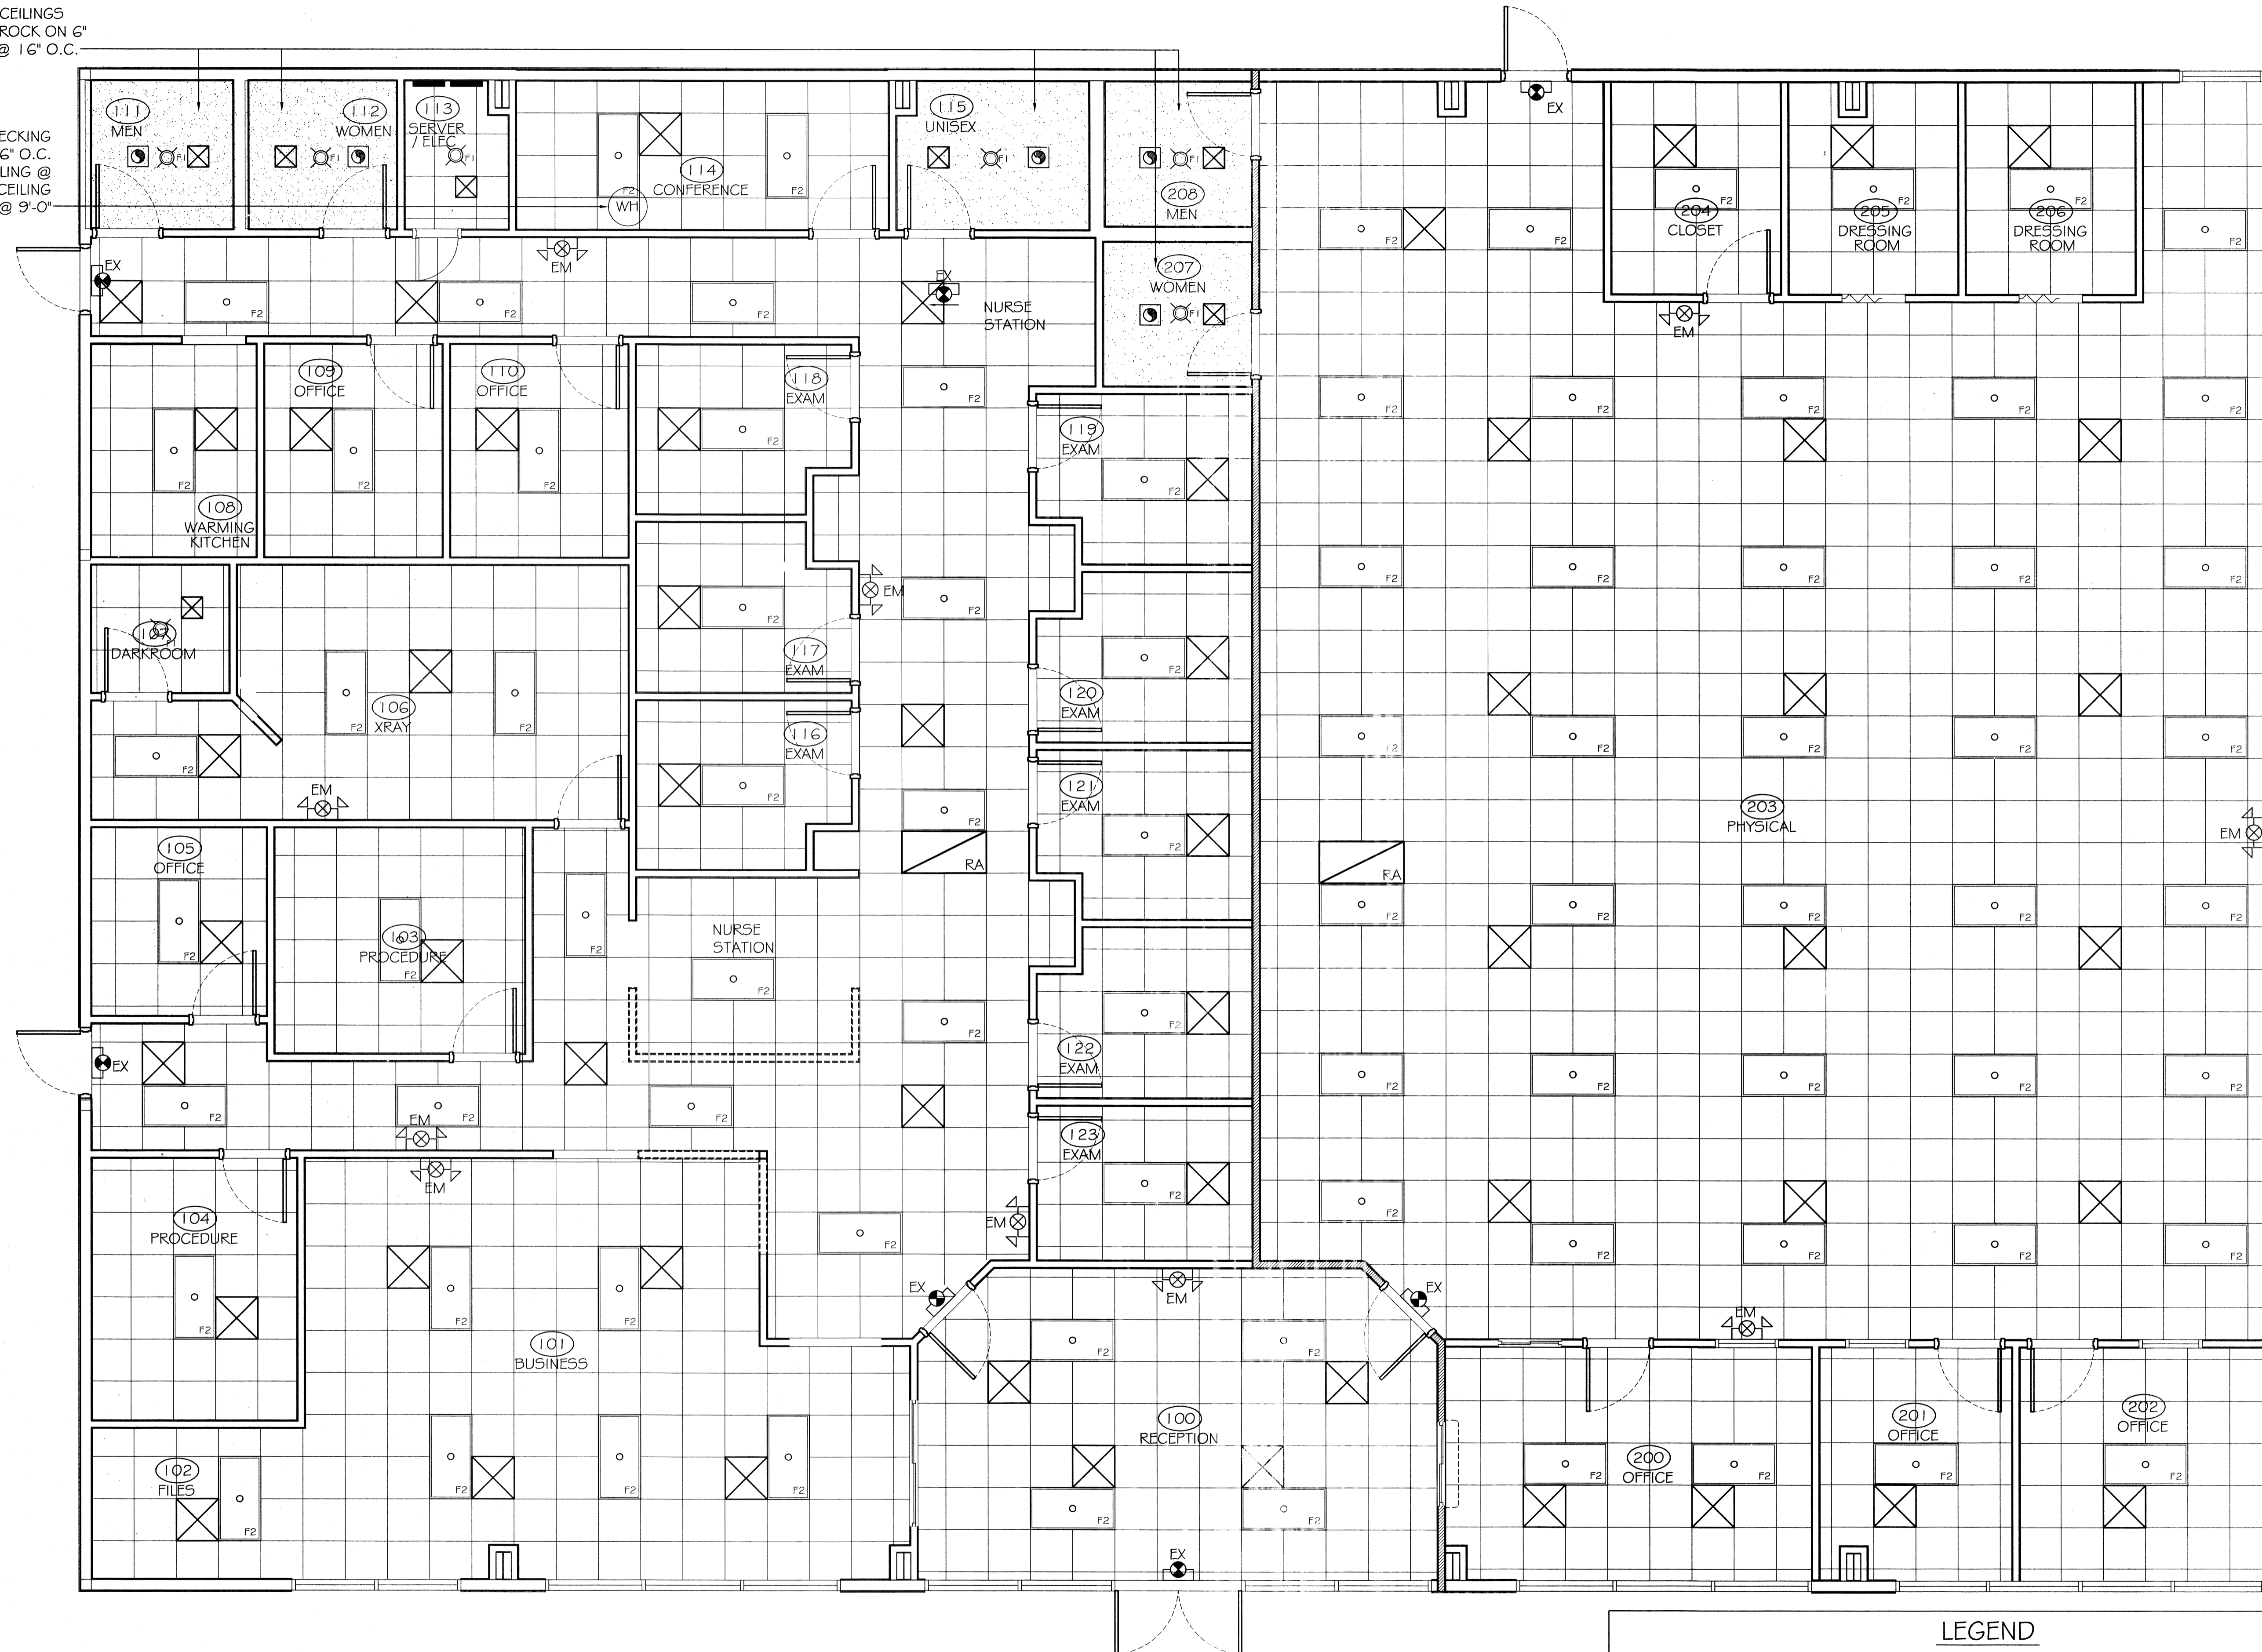


CEILING PLAN NOTES:  
 1. SEE SHEET E-3 FOR FULL LIGHT FIXTURE DESCRIPTION.  
 2. NEW CORRIDOR SUSPENDED CEILING SHALL BE @ 1'-0". ALL OTHER NEW SUSPENDED CEILINGS SHALL BE @ 9'-0".

REFLECTED CEILING PLAN

SCALE: 1/4" = 1'-0"

LEGEND	
	INDICATES NEW 24x24 CEILING DIFFUSER 12x12 DIFFUSERS IN TOILET ROOMS AND CLOSETS AS SHOWN
	INDICATES NEW RETURN AIR CEILING GRILLE
	EXHAUST VENT
	WALL MTD. EMER. LIGHT W/ 90 MIN. BATT. BACKUP
	WALL MTD. LED EXIT SIGN W/ 90 MIN. BATT. BACKUP
	SURFACE MTD. DOWNLIGHT FIXTURE

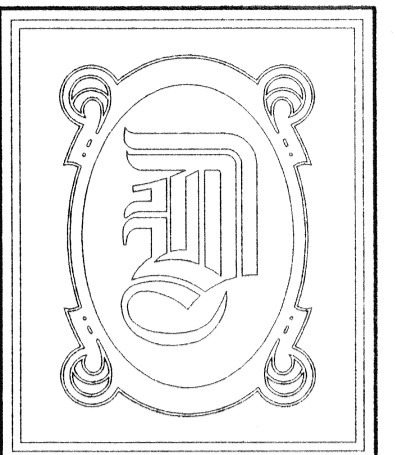

DAMMON ENGINEERING, INC.

CHIEF ENGINEER  
EMMETT DAMMON, P.E.

CHIEF ARCHITECT  
ROBERT WILTSE

554 OLD SPANISH TRAIL  
SLIDELL, LA. 70458  
OFFICE: 985-649-5832  
FAX: 985-641-5950


WEBSITE:  
WWW.DAMMONENGINEERING.COM

EMAIL:  
DAMMONENG@BELLSOUTH.NET

- ARCHITECTURE
- ENGINEERING
- STUDIES
- PLANNING
- INVESTIGATION
- EXPERT WITNESS

BRIAN FONG, M.D. Inc.  
MEDICAL OFFICE  
2965 GAUSE BLVD.  
SLIDELL, LA

REFLECTED  
CEILING PLAN

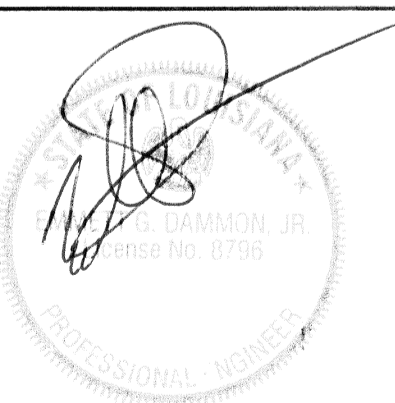

REV:

SCALE: AS NOTED

JOB#: 2132

DATE: 04-17-12

SHEET 4

A-2

OF 12