


1 FLOOR PLAN

SCALE: 1/4" = 1'-0"

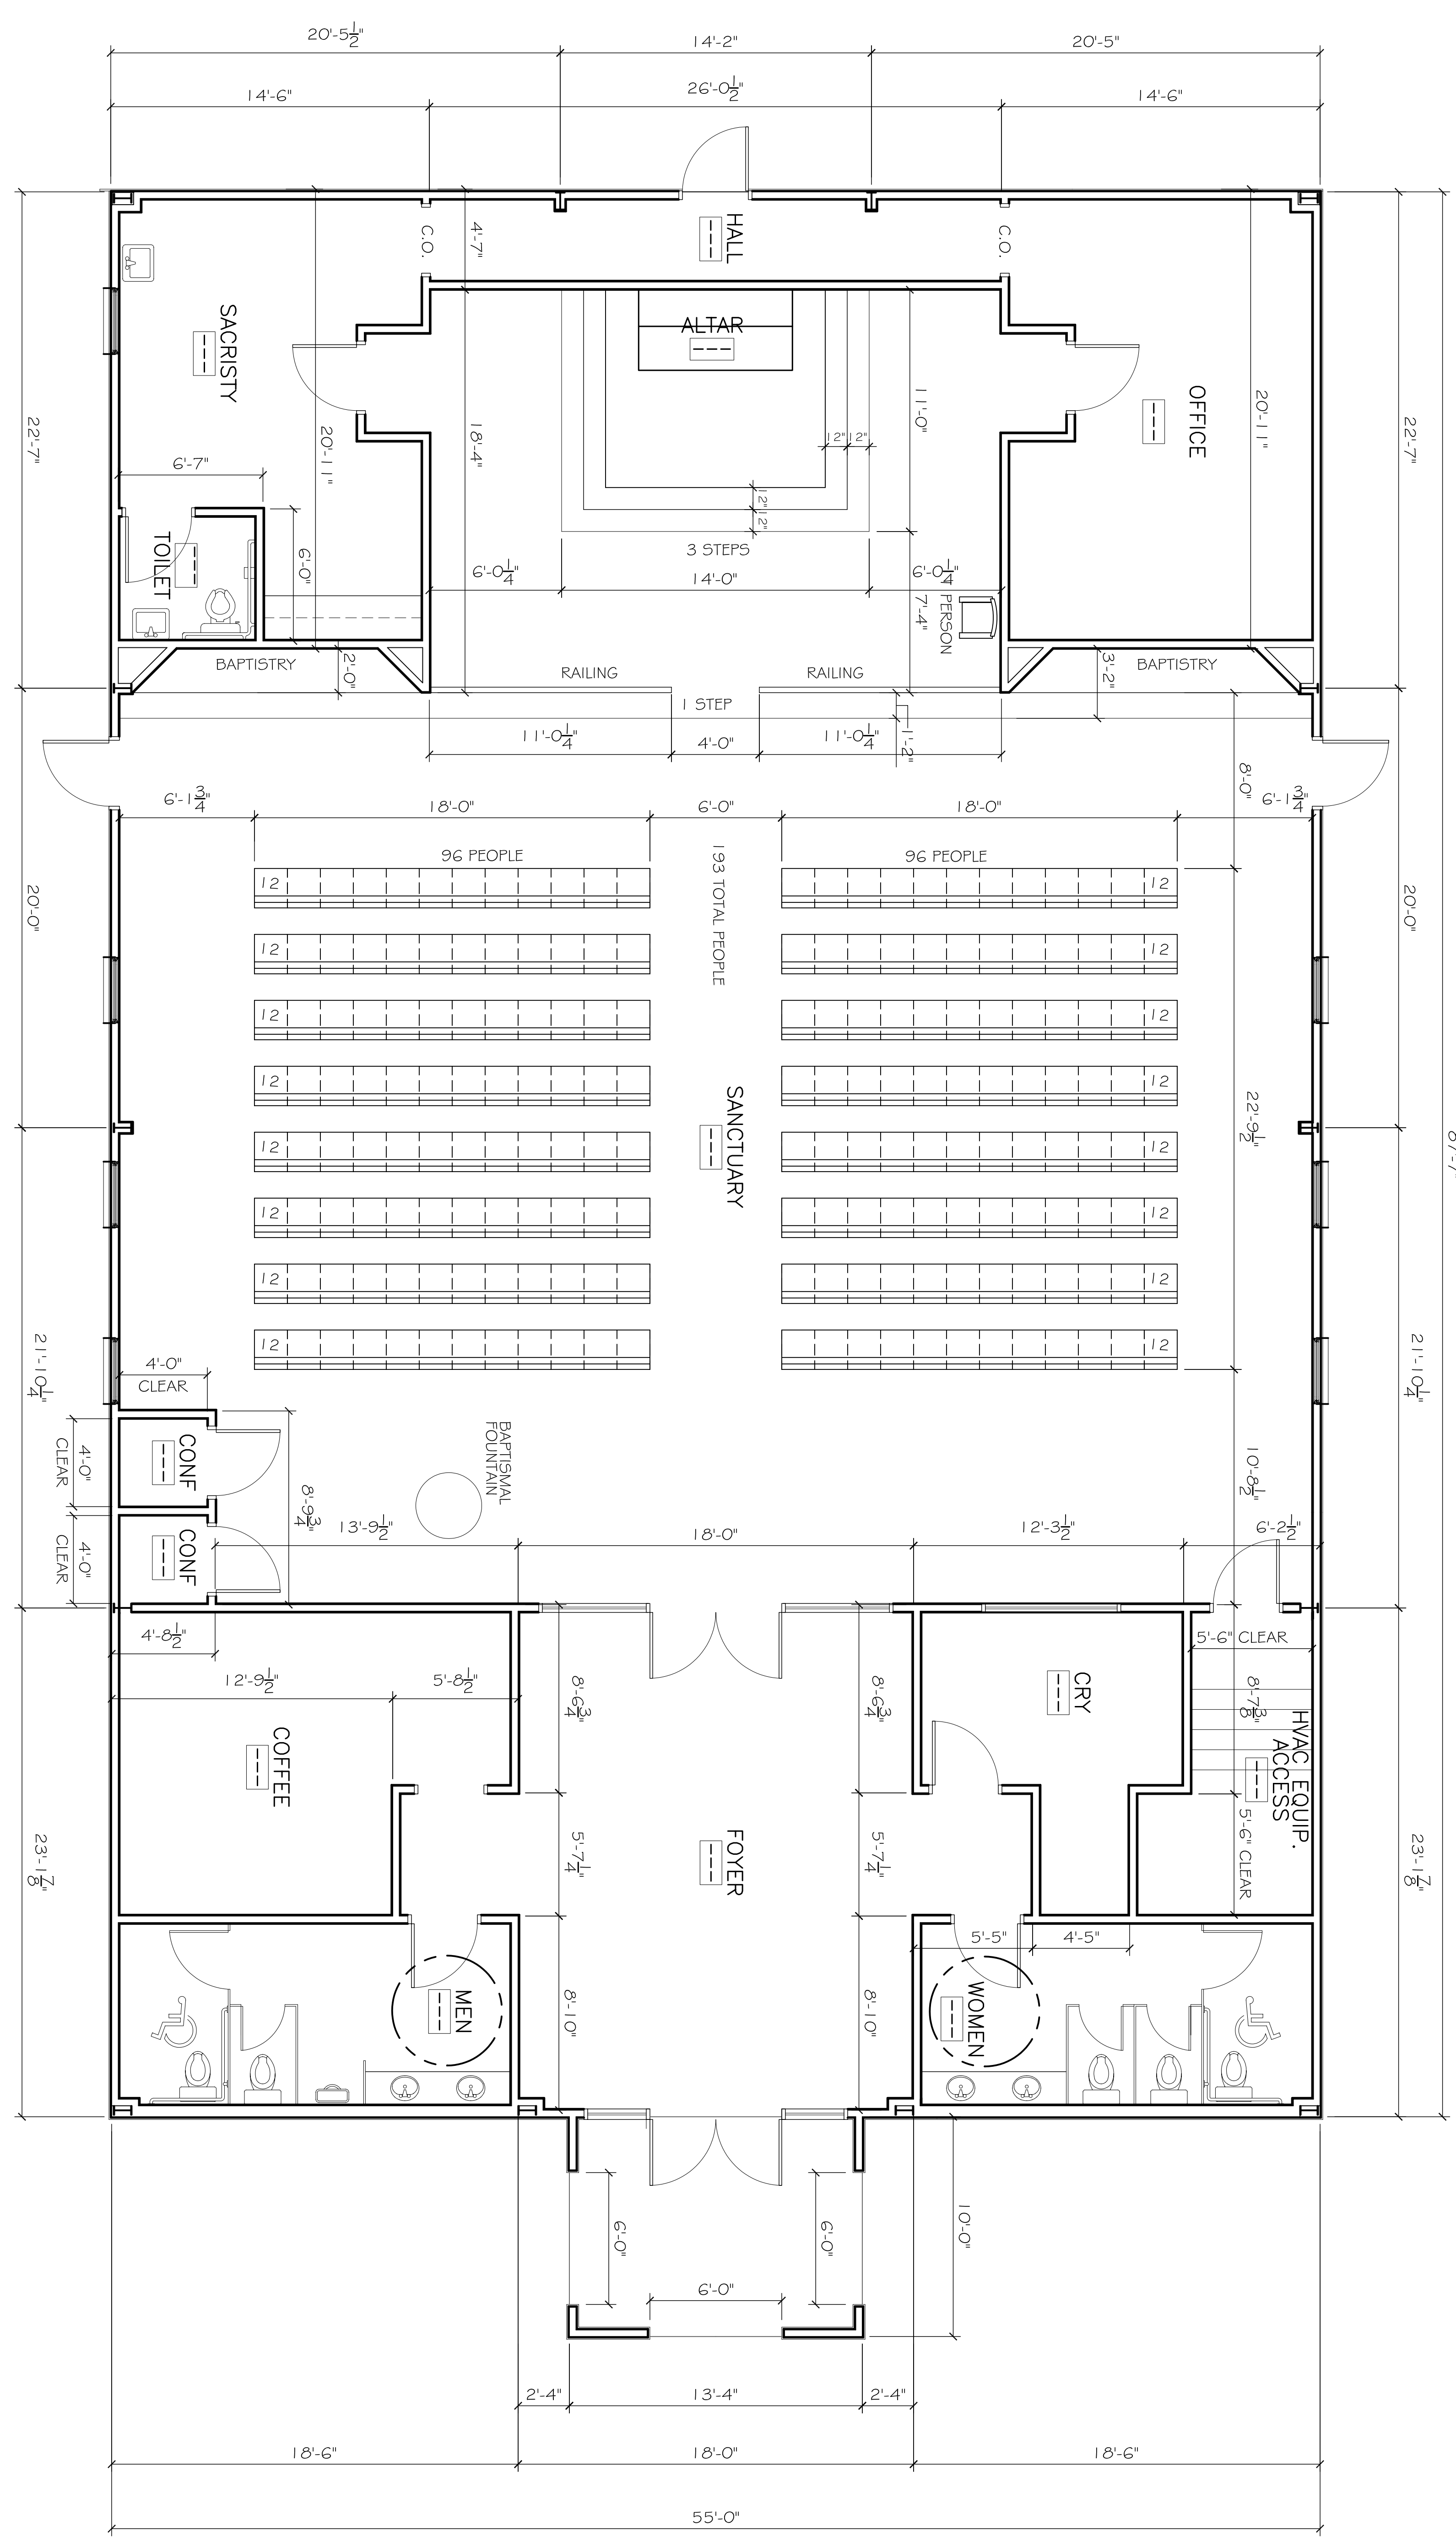

SHEET NO. **A101**

DRAWING NUMBER: **FLOOR PLAN**

**A NEW CATHOLIC CHURCH FOR THE ARCHDIOCESE OF NEW ORLEANS**  
 LACOMBE, LOUISIANA  
 JOB No: 2250 DATE: JULY 2015  
 DRAWN BY: JTL CHECKED BY: CKD

The above drawings and specifications, design and arrangements represented hereby and shall remain the property of Dammon Engineering, and no part thereof shall be copied, reproduced, or used in connection with any work or project other than the specific project for which they were prepared and furnished without written consent of Dammon Engineering. Mutual contact with these drawings or specifications shall constitute irrevocable evidence of acceptance of these conditions.

REVISIONS		DATE
#	DESCRIPTION	

**DAMMON ENGINEERING, INC.**  
*Architects & Engineers*  
 Chief Architect: Kevin J. Kinchen, NCARB  
 Chief Engineer: Brian Mistich, PE  
 554 Old Spanish Trail  
 Slidell, LA 70458  
 www.dammonengineering.com  
 info@dammonengineering.com  
 PH: 985.649.5832  
 F: 985.641.5950