


1 LEVEL 1 REFLECTED CEILING PLAN  
SCALE: 3/16"=1'-0"

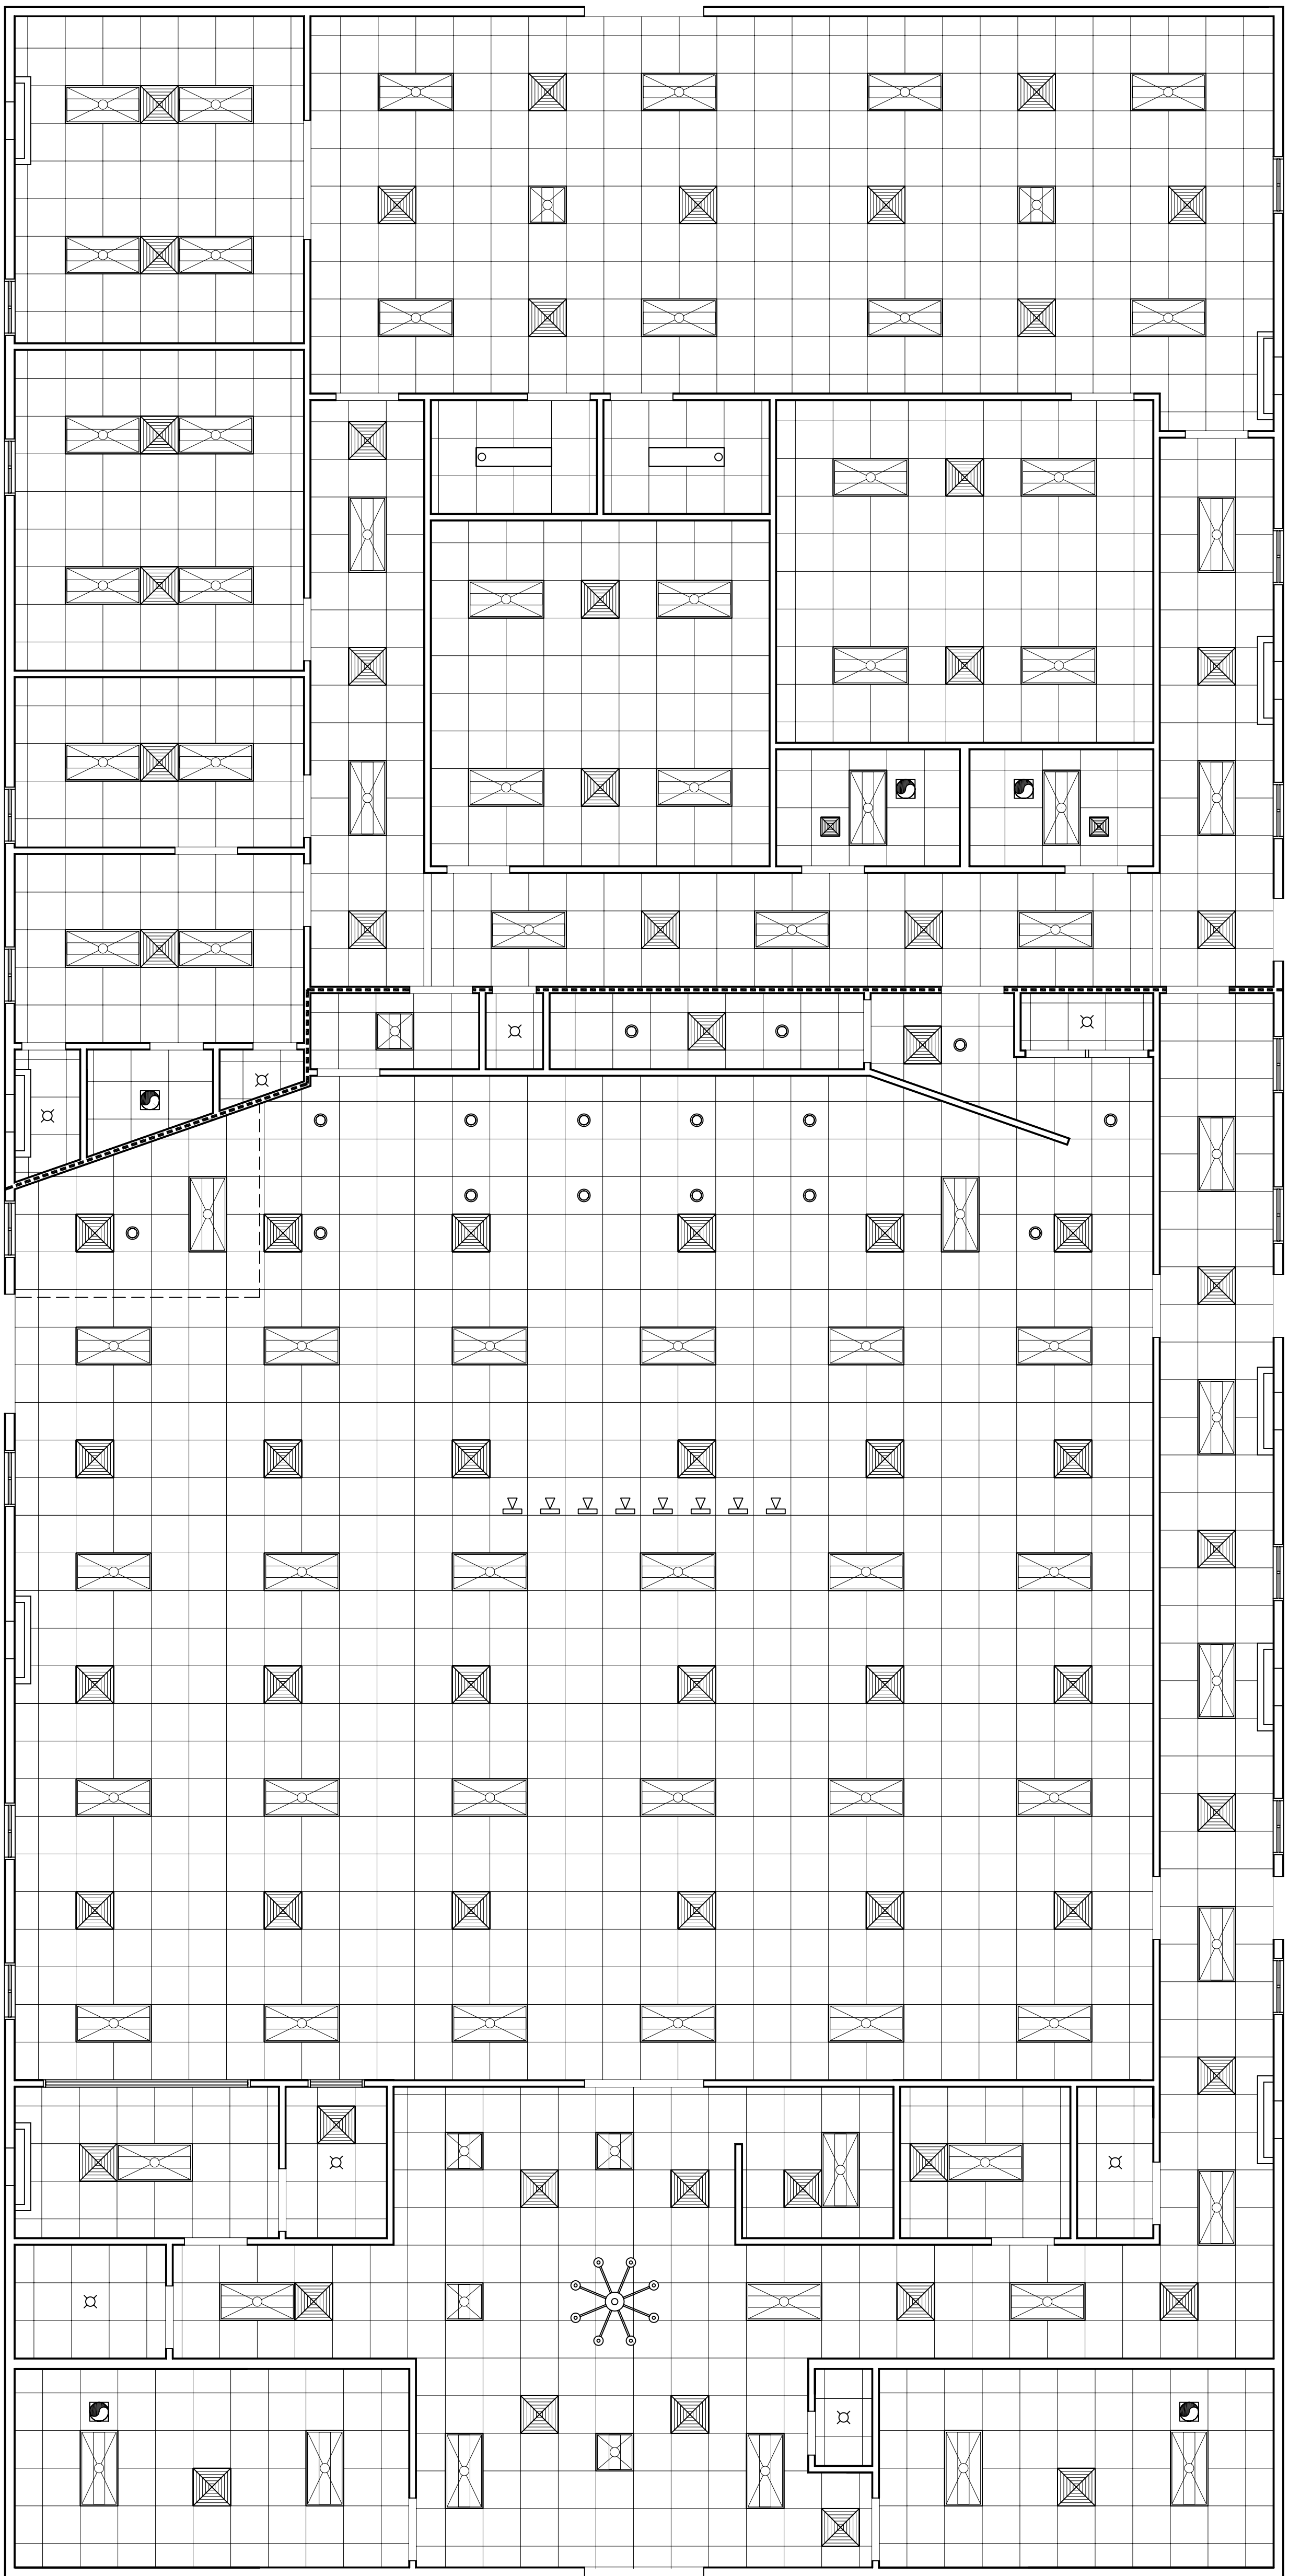

**GENERAL NOTES**

1. MECHANICAL, NEZANNE REFLECTED CEILING PLAN NOT SHOWN. NO FINISHED CEILING ASSEMBLY TO BE PROVIDED AND IS OPEN TO EXPOSED STRUCTURE. SEE SHEET E101 FOR LIGHT FIXTURE TYPES AND LOCATIONS.
2. ALL CEILING HEIGHTS INDICATED ARE APPROXIMATE. ACTUAL CEILING HEIGHT TO BE DETERMINED BY STRUCTURE ELEVATION AND CEILING ASSEMBLY THICKNESS. INDICATED HEIGHT IS MEASURED ABOVE FINISH FLOOR (AFF).
3. REFER TO SHEET A501 FOR WALL/PARTITION ASSEMBLY AND INFORMATION.
4. SEE SHEET E101 FOR LIGHT FIXTURE TYPES. SEE SHEET M101 FOR DIFFUSER AND GRILLE TYPES.
5. REFER TO INTERIOR ELEVATIONS FOR MOUNTING HEIGHT OF WALL MOUNTED LIGHT FIXTURES.

**RCP LEGEND**

| SYMBOL/SYMBOL | DESCRIPTION                                     |
|---------------|---|
|               | 2x4 SUSPENDED FLOURESCENT LIGHT FIXTURE         |
|               | 2x2 SUSPENDED FLOURESCENT LIGHT FIXTURE         |
|               | DIRECTIONAL FLOOD LIGHT FIXTURE                 |
|               | SURFACE MOUNTED FLOURESCENT STRIP LIGHT FIXTURE |
|               | PENDANT LIGHT FIXTURE                           |
|               | RECESSED CAN LIGHT FIXTURE                      |
|               | SURFACE MOUNTED LIGHT FIXTURE                   |
|               | HVAC SUPPLY AIR DIFFUSER                        |
|               | CHANDELIER                                      |

**DAMMON ENGINEERING, INC.**  
LOUISIANA & MISSISSIPPI

Chief Engineer: Brian Mistich, PE  
554 Old Spanish Trail  
Slidell, LA 70458  
www.dammonengineering.com  
info@dammonengineering.com  
PH: 985.649.5832 F: 985.641.5950

| REVISIONS |             |
|-----------|-------------|
| #         | DESCRIPTION |
|           |             |
|           |             |
|           |             |
|           |             |
|           |             |

**PRELIMINARY  
NOT FOR  
CONSTRUCTION**

W O L F E A N T H O N I C  
37110 LEGGETT ROAD  
SLIDELL, LA 70460  
JOB No: 2274 DATE: 07/07/2016  
DRAWN BY: JHM CHECKED BY: JMS

SHEET TITLE:  
REFLECTED CEILING PLAN

DRAWING NUMBER:

**A104**

SHEET No. 10 of 17