


REFLECTED CEILING PLAN  
SCALE: 3/16"=1'-0"

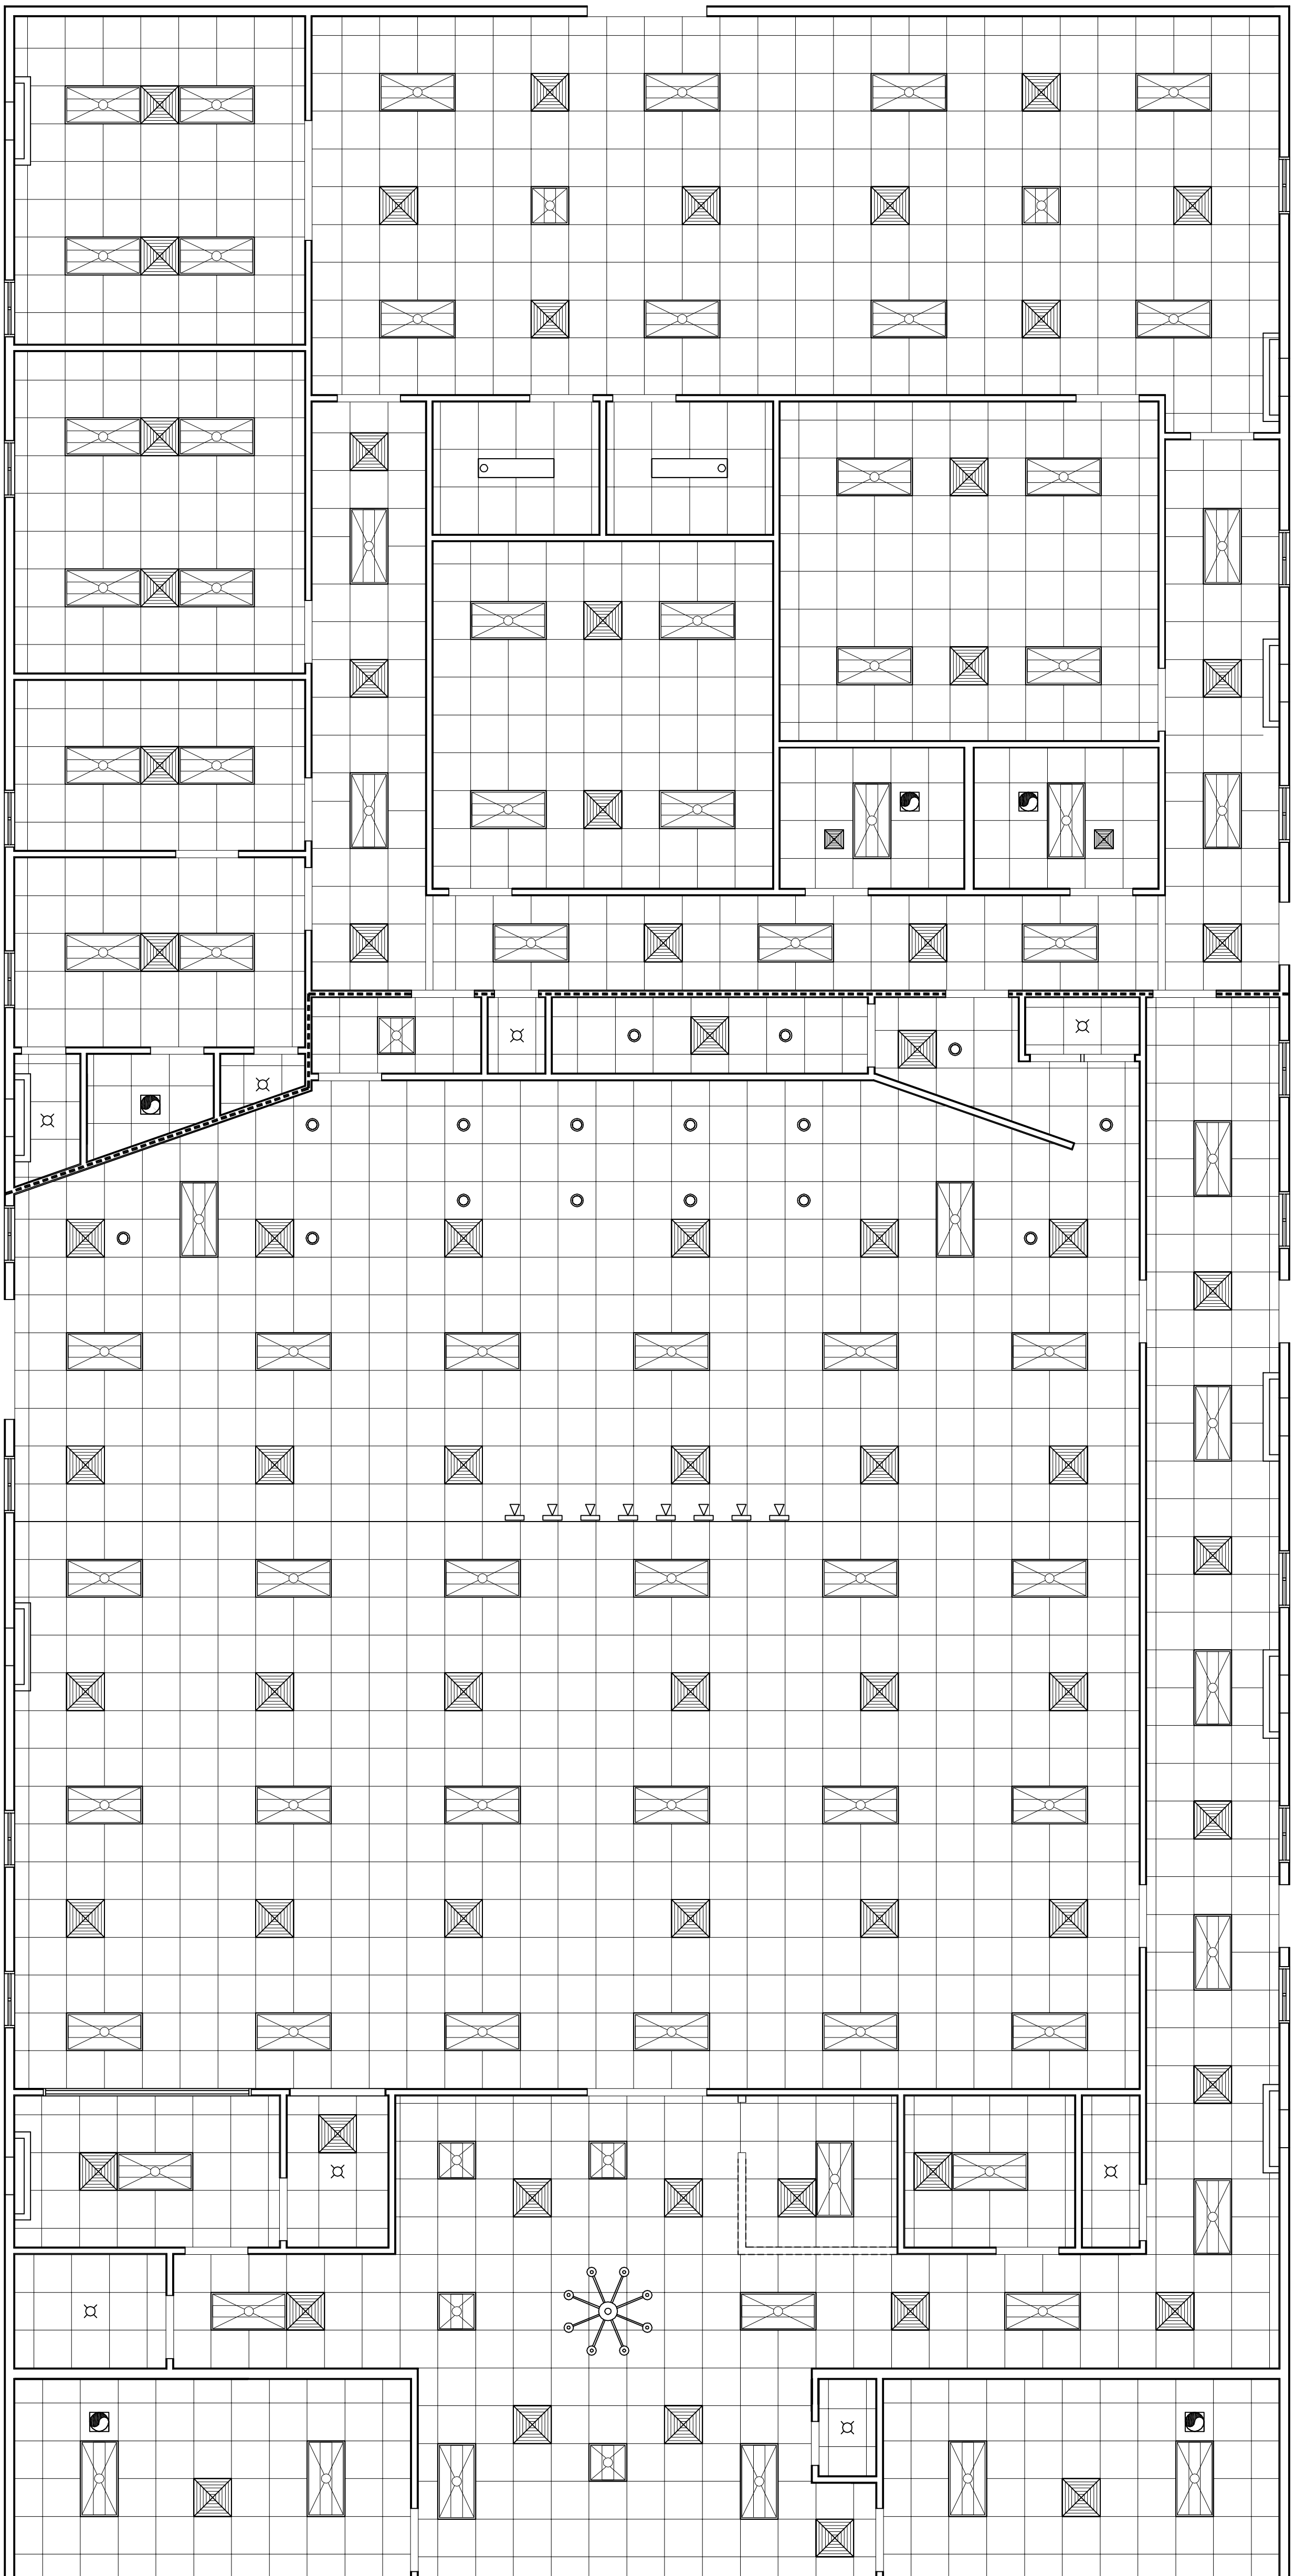

**GENERAL NOTES**

1. ALL CEILING HEIGHTS INDICATED ARE APPROXIMATE. ACTUAL CEILING HEIGHT TO BE DETERMINED BY STRUCTURE ELEVATION AND CEILING ASSEMBLY THICKNESS. INDICATED HEIGHT IS MEASURED ABOVE FINISH FLOOR (AFF).

**RCP LEGEND**

SYMBOL	DESCRIPTION
	2x4 SUSPENDED FLUORESCENT LIGHT FIXTURE
	2x2 SUSPENDED FLUORESCENT LIGHT FIXTURE
	DIRECTIONAL FLOOD LIGHT FIXTURE
	SURFACE MOUNTED FLUORESCENT STRIP LIGHT FIXTURE
	PENDANT LIGHT FIXTURE
	RECESSED CAN LIGHT FIXTURE
	SURFACE MOUNTED LIGHT FIXTURE
	EXHAUST FAN
	HVAC SUPPLY AIR DIFFUSER
	CHANDELIER

**DAMMON ENGINEERING, INC.**  
LOUISIANA & MISSISSIPPI

Chief Engineer: Brian Mistich, PE  
554 Old Spanish Trail  
Slidell, LA 70458  
www.dammonengineering.com  
info@dammonengineering.com  
PH: 985.649.5832 F: 985.641.5950

REVISIONS	
#	DESCRIPTION

**CHRISTIAN LOVE CHURCH**  
37710 LEGGETT ROAD  
SLIDELL, LA 70460

JOB No: 2295 DATE: 08/15/2016  
DRAWN BY: JHM CHECKED BY: JMS

My client retains the copyright in all drawings and designs prepared by me and shall remain the property of Dammon Engineering, Inc. No part thereof shall be copied, reproduced, or used in connection with any work or project other than the specific project for which they have been prepared and, if required, without written consent of Dammon Engineering, Inc. All drawings shall comply with the specifications and conditions of the contract.

SHEET TITLE:  
REFLECTED CEILING PLAN

DRAWING NUMBER:  
**A104**

SHEET No. 10 of 17