


REFLECTED CEILING PLAN
SCALE: 3/16"=1'-0"

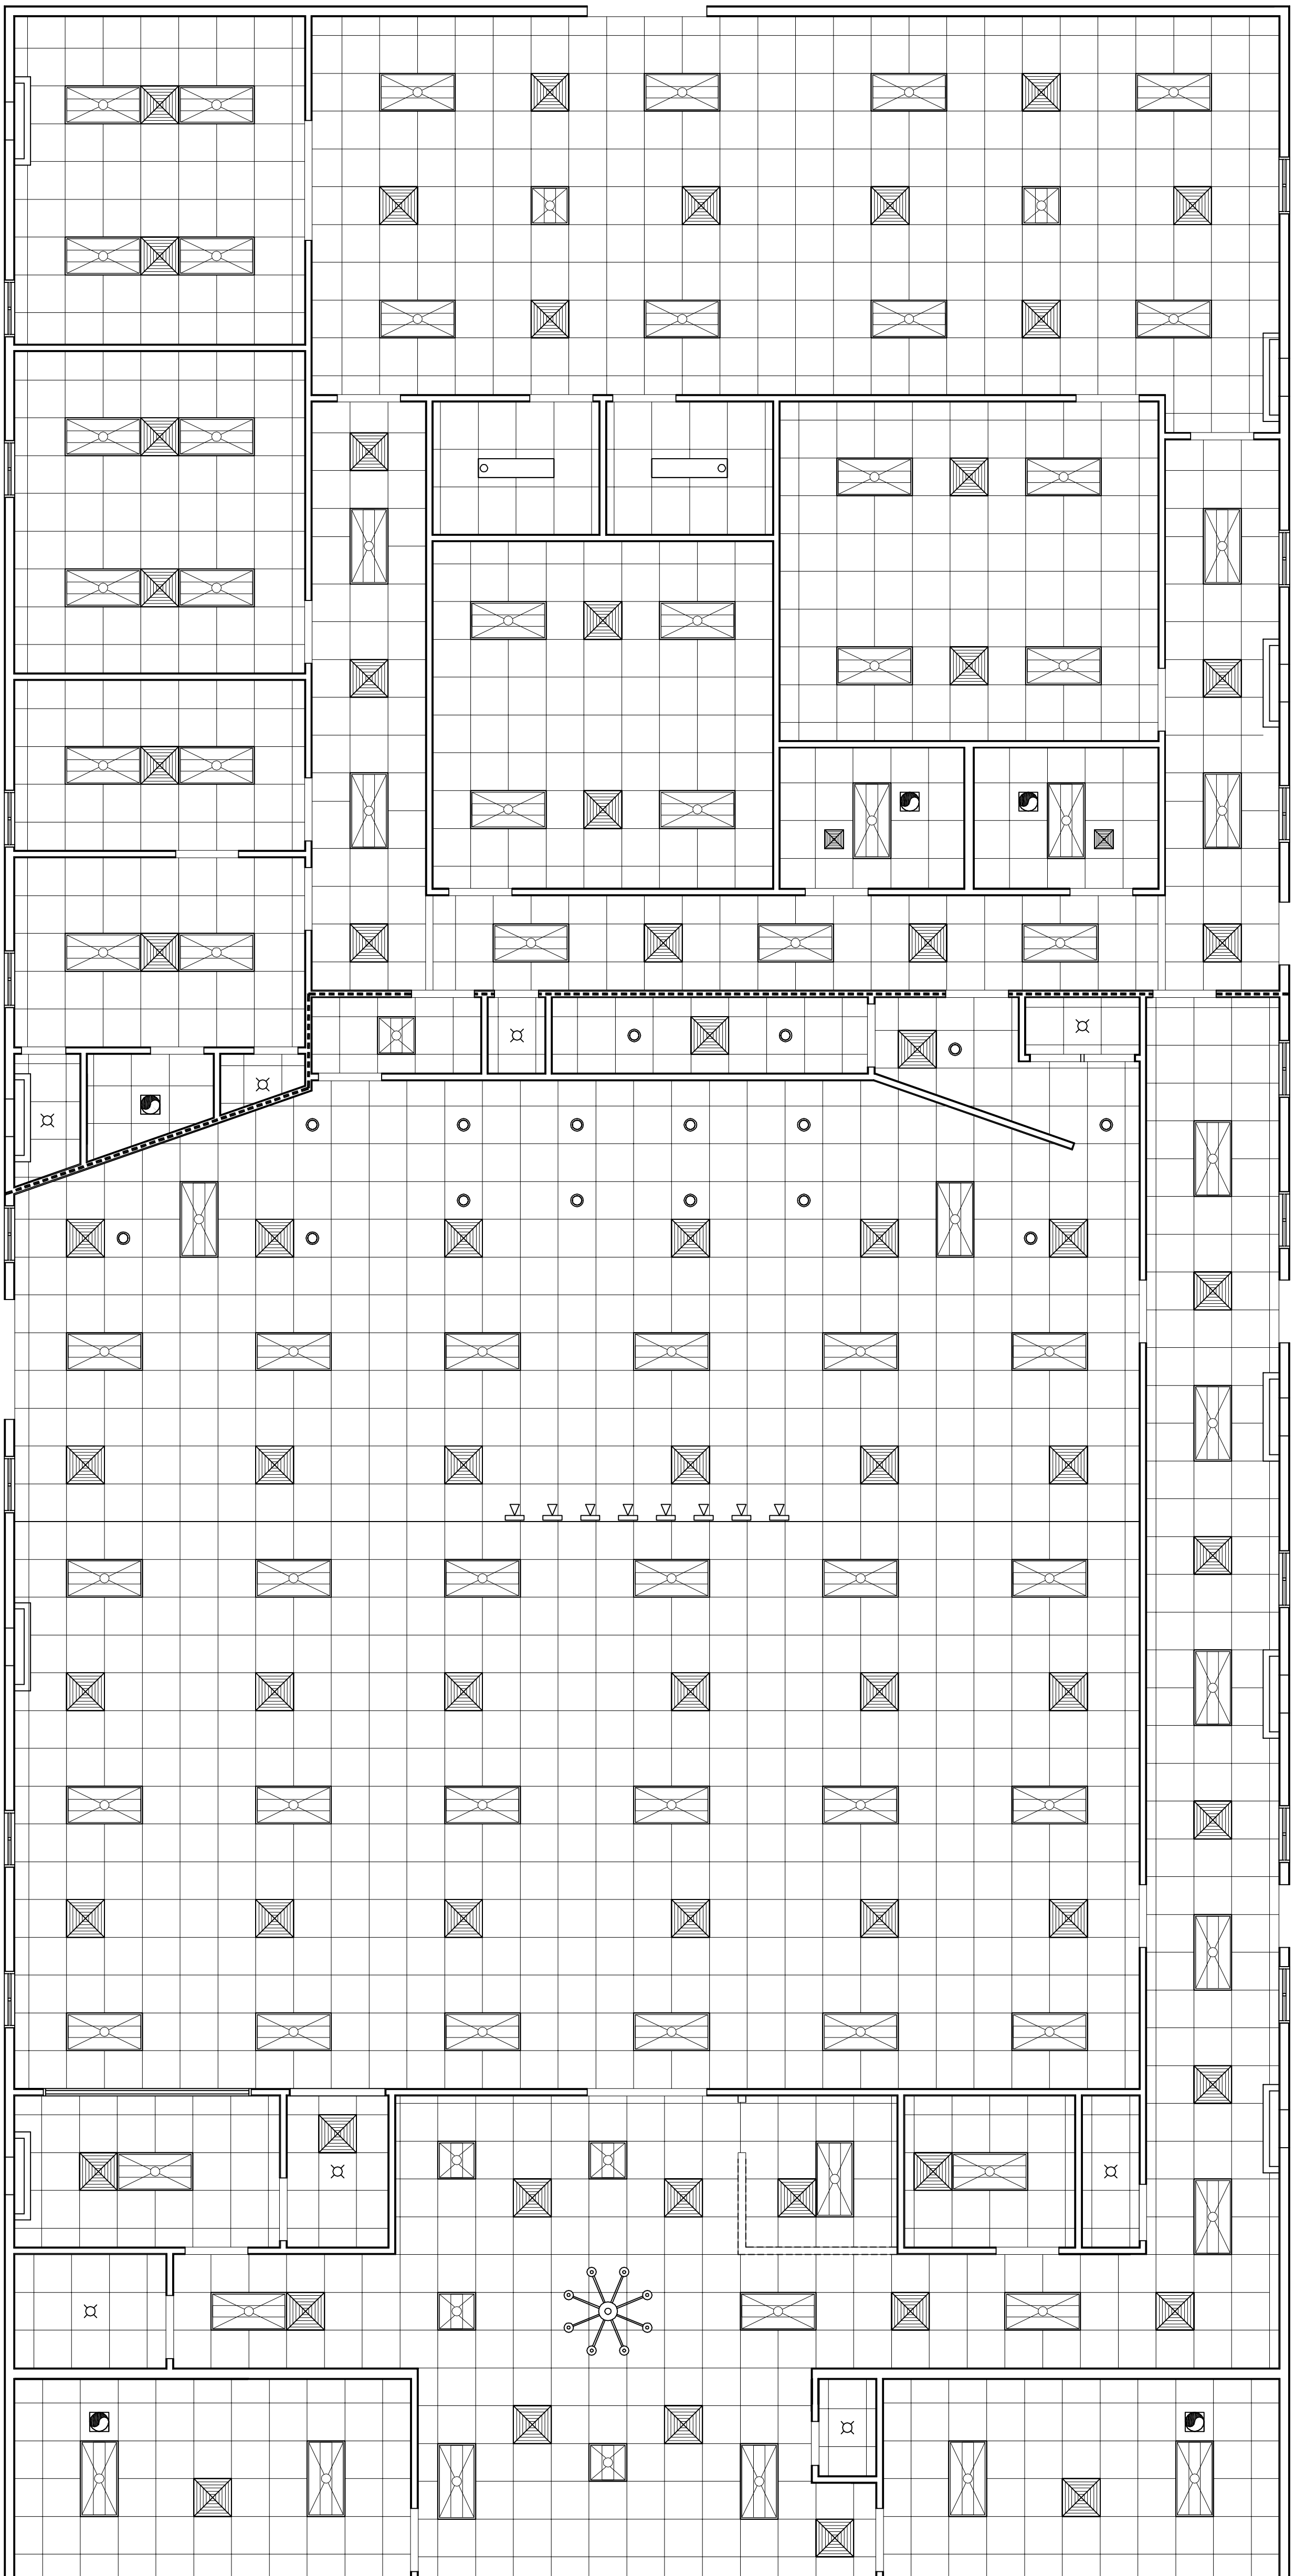

GENERAL NOTES

1. ALL CEILING HEIGHTS INDICATED ARE APPROXIMATE. ACTUAL CEILING HEIGHT TO BE DETERMINED BY STRUCTURE ELEVATION AND CEILING ASSEMBLY THICKNESS. INDICATED HEIGHT IS MEASURED ABOVE FINISH FLOOR (AFF).

RCP LEGEND


SYMBOL	DESCRIPTION
	2x4 SUSPENDED FLUORESCENT LIGHT FIXTURE
	2x2 SUSPENDED FLUORESCENT LIGHT FIXTURE
	DIRECTIONAL FLOOD LIGHT FIXTURE
	SURFACE MOUNTED FLUORESCENT STRIP LIGHT FIXTURE
	PENDANT LIGHT FIXTURE
	RECESSED CAN LIGHT FIXTURE
	SURFACE MOUNTED LIGHT FIXTURE
	EXHAUST FAN
	HVAC SUPPLY AIR DIFFUSER
	CHANDELIER

DAMMON ENGINEERING, INC.
LOUISIANA & MISSISSIPPI

Chief Engineer: Brian Mistich, PE
554 Old Spanish Trail
Slidell, LA 70458

www.dammonengineering.com
info@dammonengineering.com
PH: 985.649.5832 F: 985.641.5950

REVISIONS	
#	DESCRIPTION

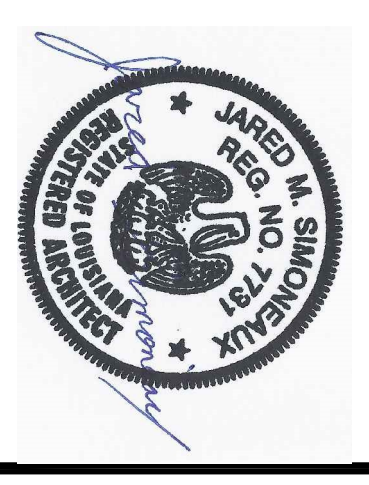

CHRISTIAN LOVE CHURCH

37710 LEGGETT ROAD
SLIDELL, LA 70460

JOB No: 2285 DATE: 09/02/2016

DRAWN BY: JHM CHECKED BY: JMS

Not about drawings and specifications, design and engineering responsible liability and shall remain the property of Dammon Engineering, Inc. No part thereof shall be copied, reproduced, or used in connection with any work or project other than the specific project for which they have been prepared and approved without written consent of Dammon Engineering, Inc. Read carefully with these drawings and specifications and understand the responsibility of engineer of these conditions.

SHEET TITLE:
REFLECTED CEILING PLAN

DRAWING NUMBER:
A104

SHEET No. 10 of 15