



CHARLIE MAXWELL AUTO/TRUCK REPAIR

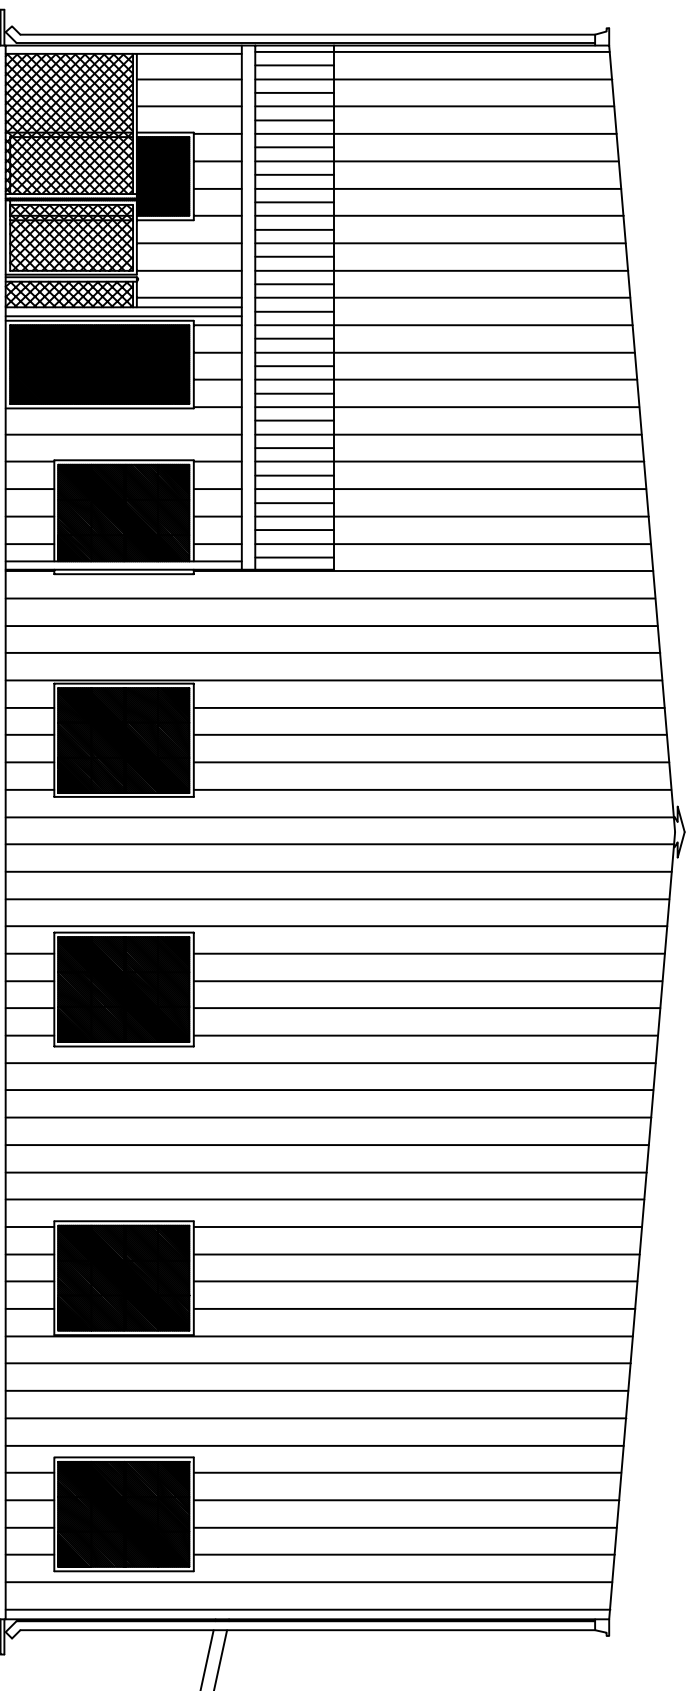

INDEX OF DRAWINGS	
DWG.#	DRAWING NAME
C-1	SITE PLAN
L-1	LANDSCAPE PLAN
S-1	FOUNDATION PLAN
S-2	NOTES AND DETAILS
F-1	FRAMING PLAN
A-1	FLOOR PLAN
A-2	SECTION
A-3	ELEVATIONS
A-4	ELEVATIONS
A-5	REFLECTED CEILING PLAN
E-1	ELECTRICAL PLAN
E-2	MECHANINE ELECTRICAL
M-1	MECHANICAL PLAN
P-1	PLUMBING PLAN

8,400 SQ. FT.

SLIDELL, LOUISIANA
ST. TAMMANY PARISH

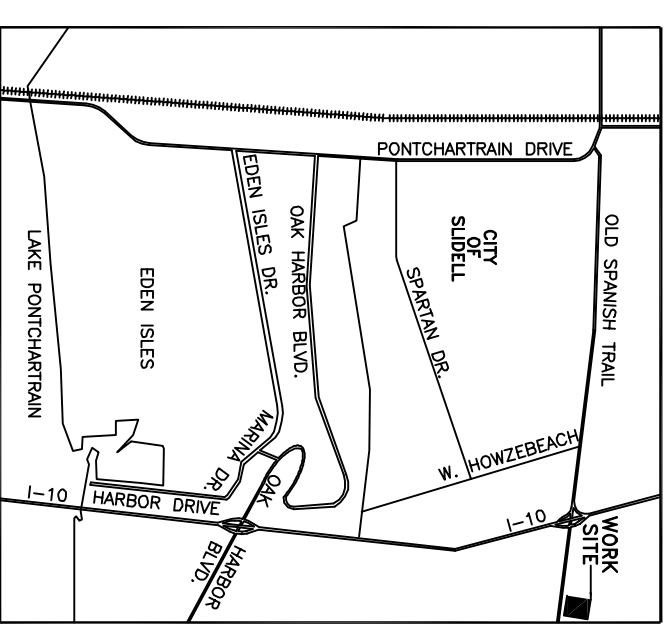

VICINITY MAP

N.T.S.



DAMMON ENGINEERING, INC.

ARCHITECTS - ENGINEERS

2000 OLD SPANISH TRAIL STE. 100

985-649-5832

SLIDELL, LA. 70458

WEB-DAMMONENGINEERING.COM