

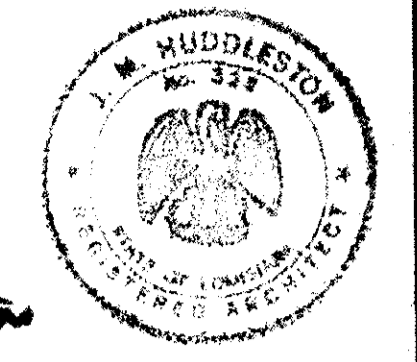


THESE PLANS HAVE BEEN PREPARED BY ME OR UNDER MY CLOSE PERSONAL SUPERVISION AND TO THE BEST OF MY KNOWLEDGE AND BELIEF THEY COMPLY WITH ALL CITY, STATE AND FEDERAL REGULATIONS. I AM NOT PROVIDING CONTRACT ADMINISTRATION SERVICES.

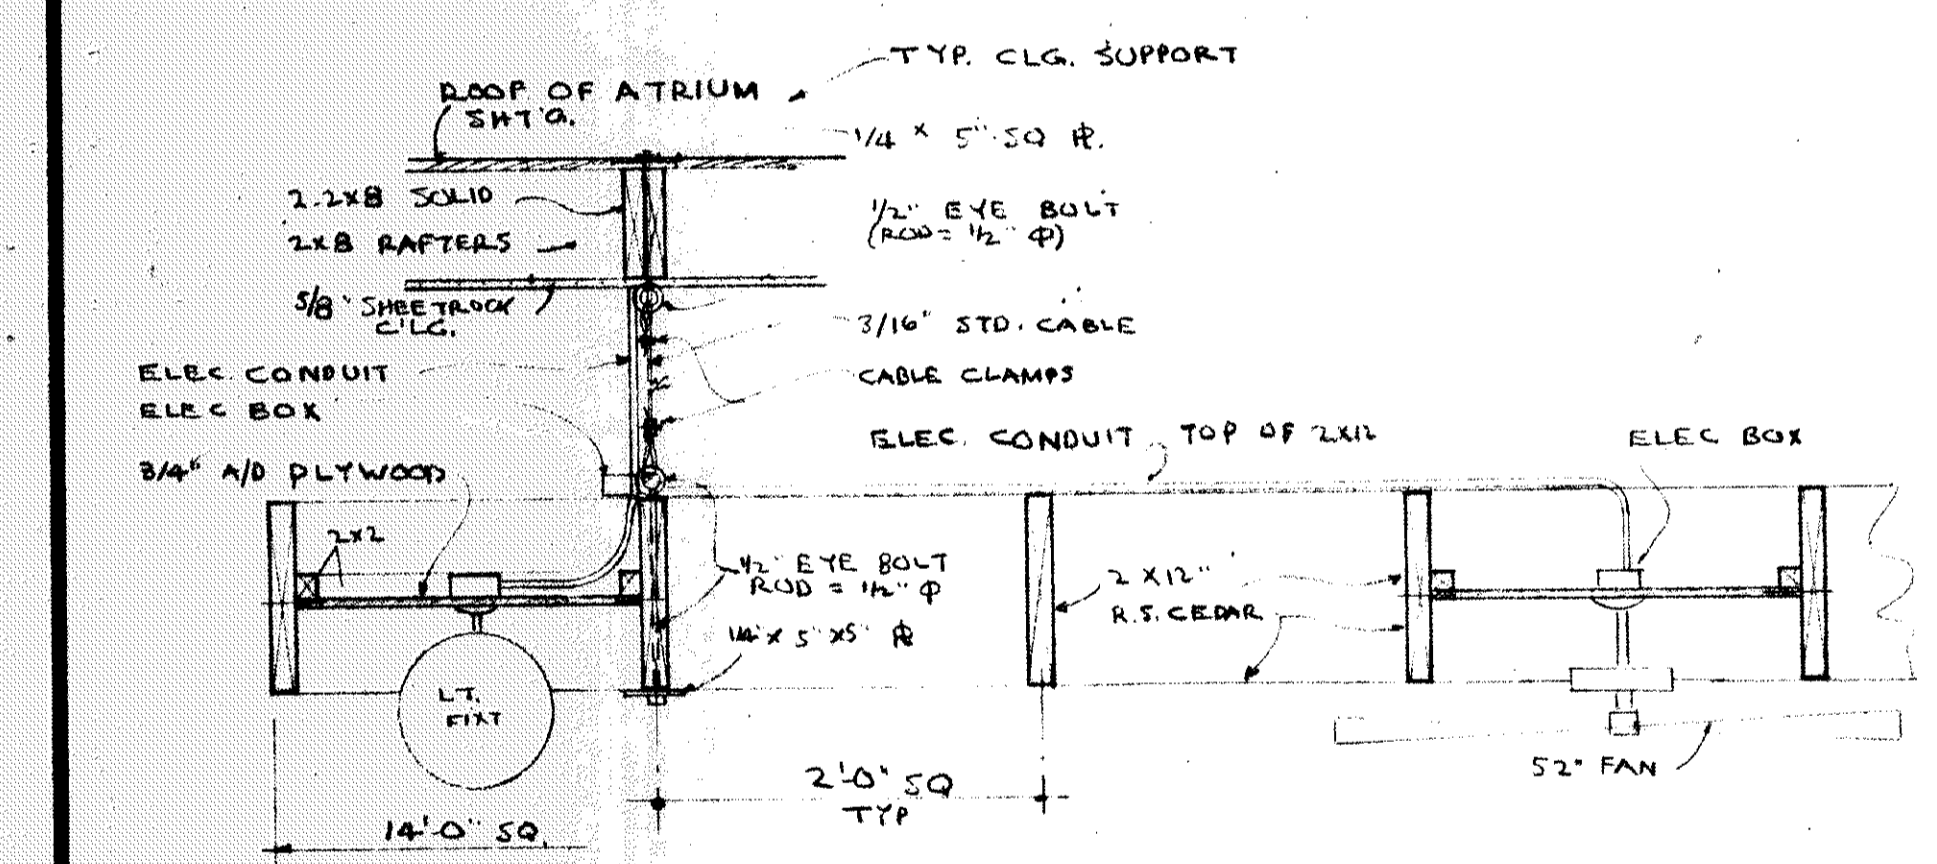


J.M. Huddleston


NOTE: WATER LEVEL MUST BE MAINTAINED ON ITEMS 6, 8, & 33 TO PREVENT MOTOR & LIGHT BURNOUT

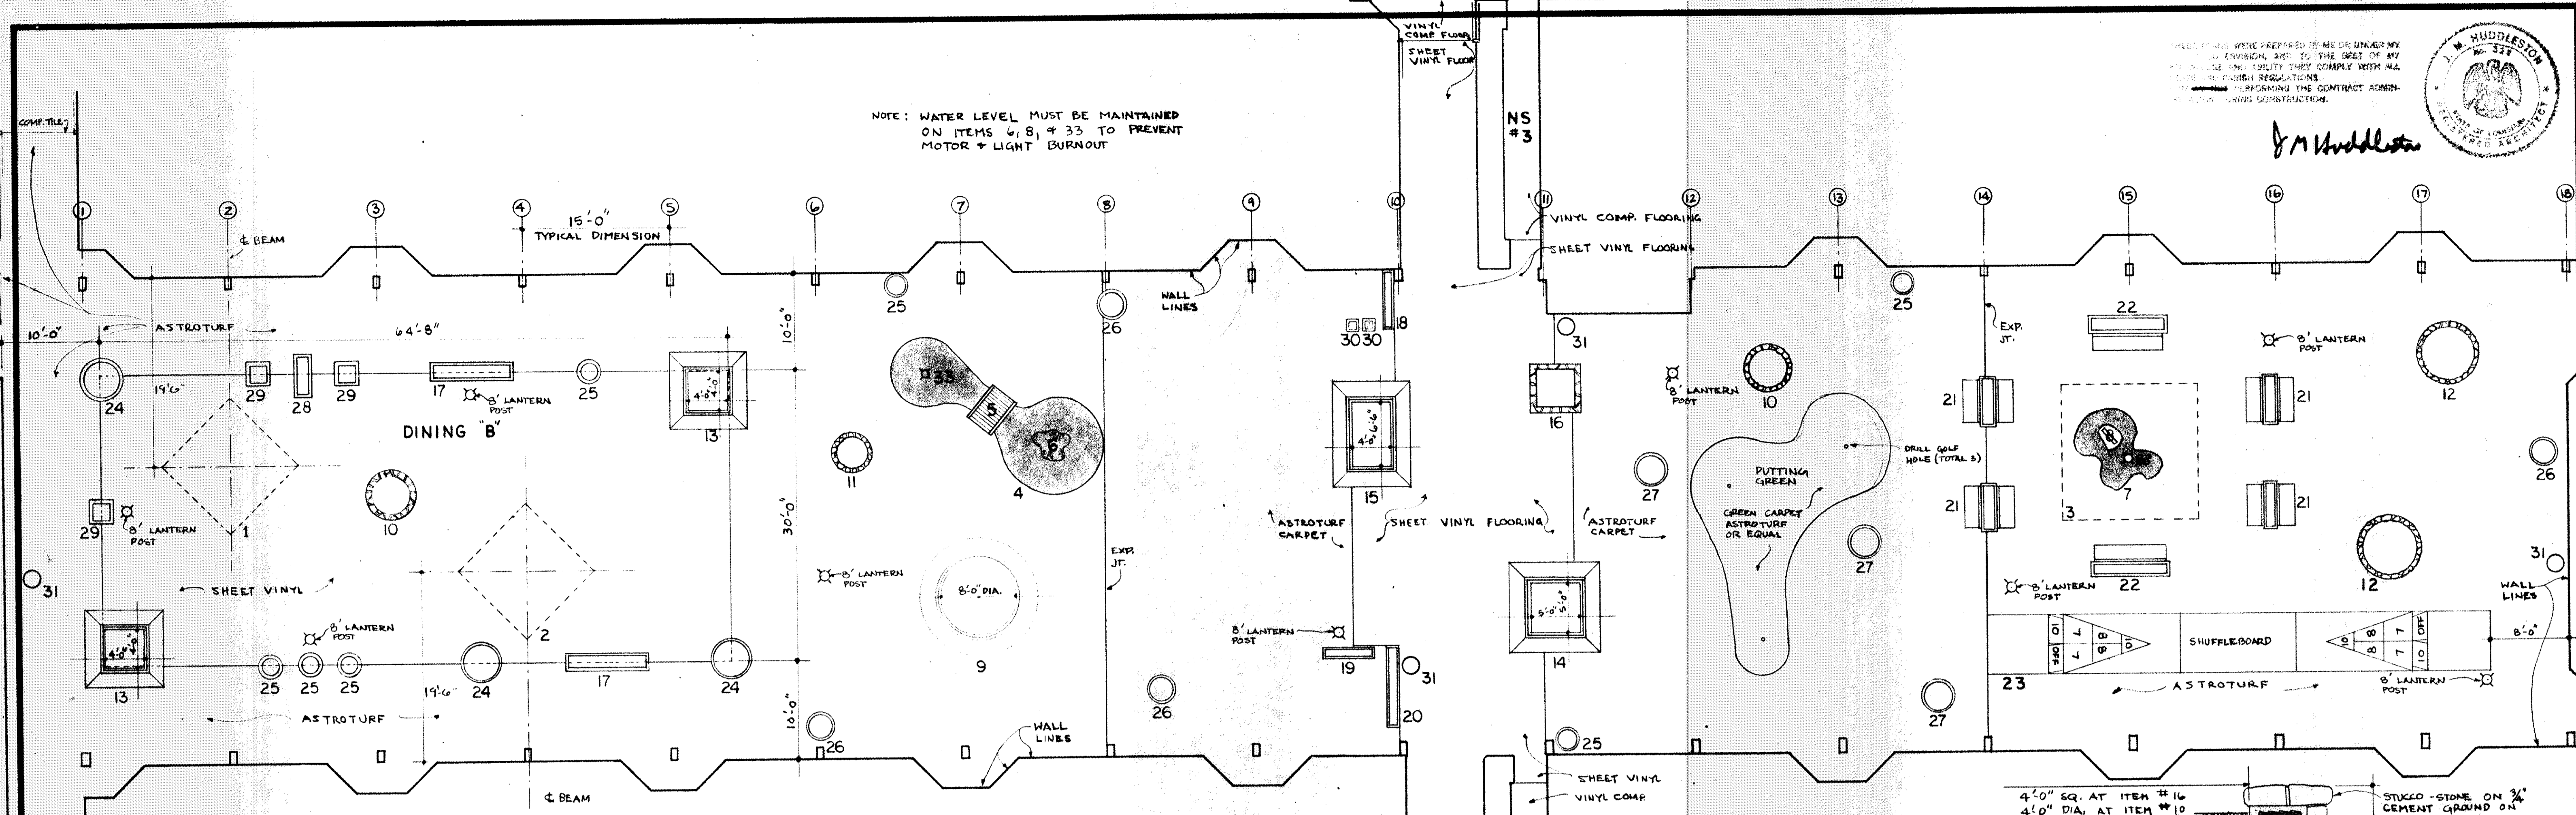

SEC. THRU SUSPENDED ITEMS 1 & 2  
SCALE 1" = 1'-0"

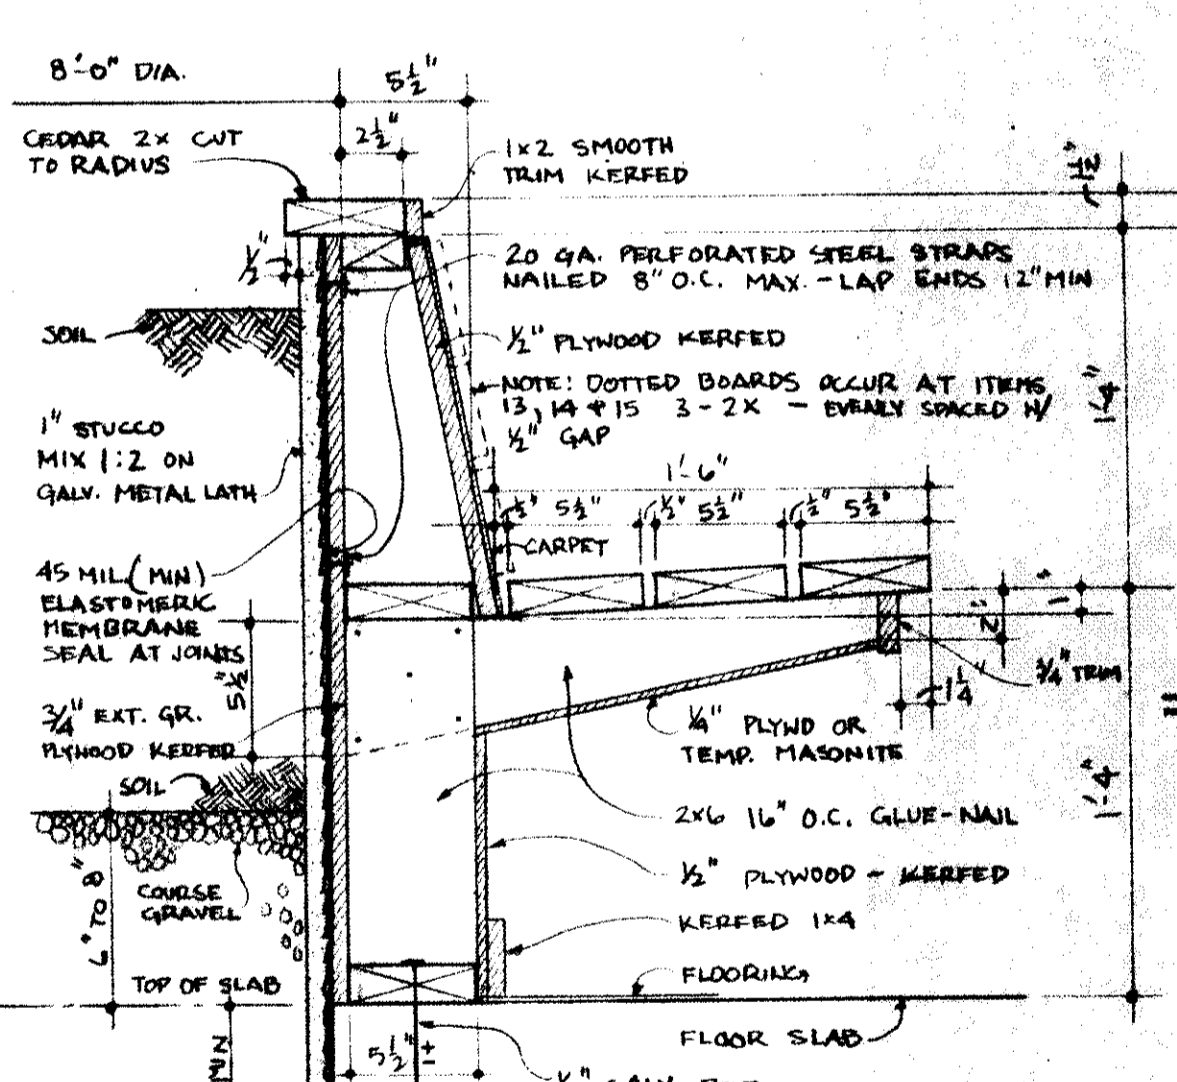


SEC.-ITEM #9 (ALSO ITEMS #13, 14 + 15)  
SCALE 1 1/2" = 1'-0"

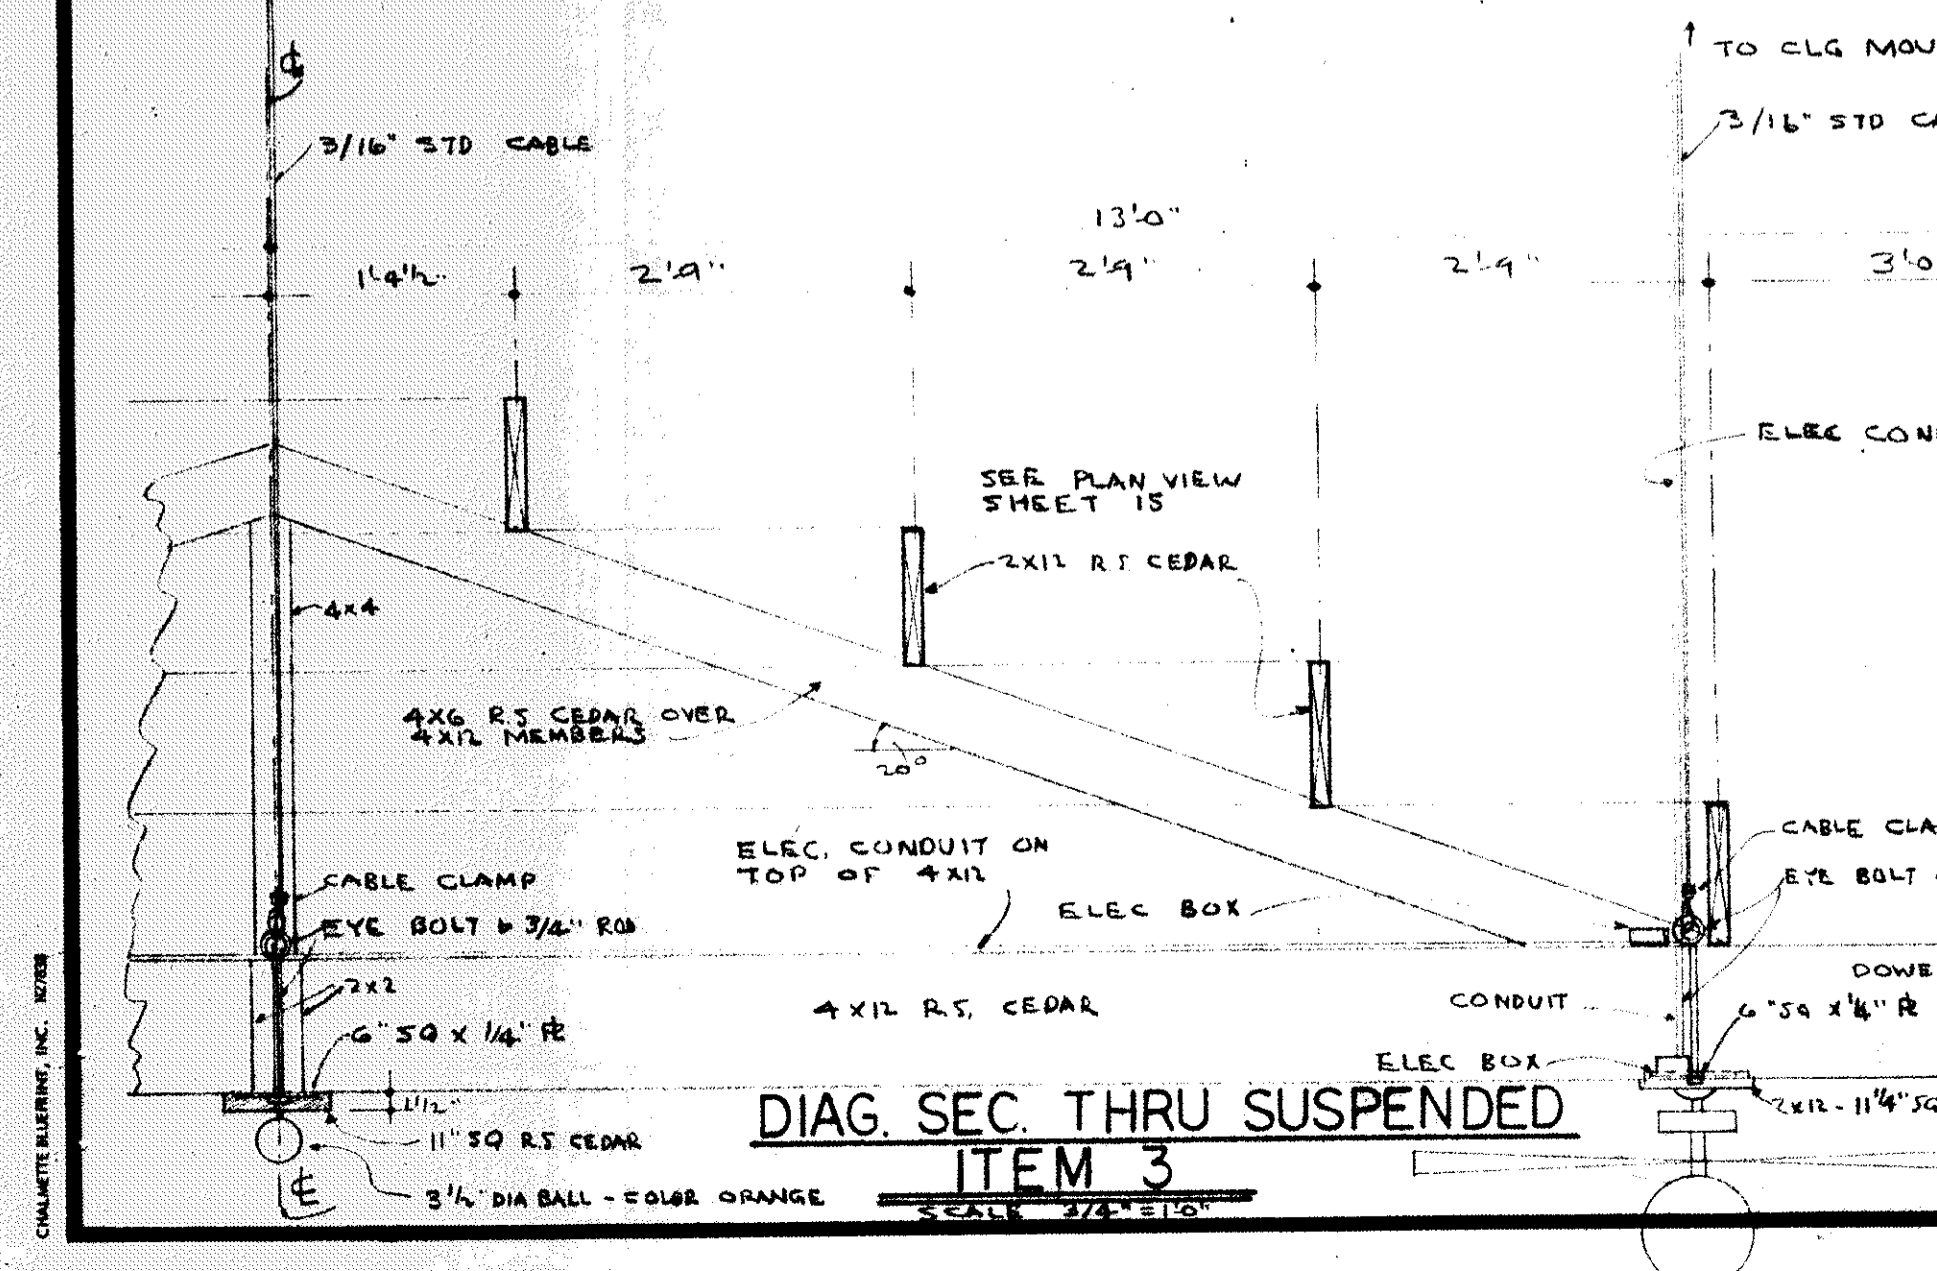


DIAG. SEC. THRU SUSPENDED ITEM 3  
SCALE 1/2" = 1'-0"

ATRIUM FLOOR PLAN  
SCALE 1/8" = 1'-0"

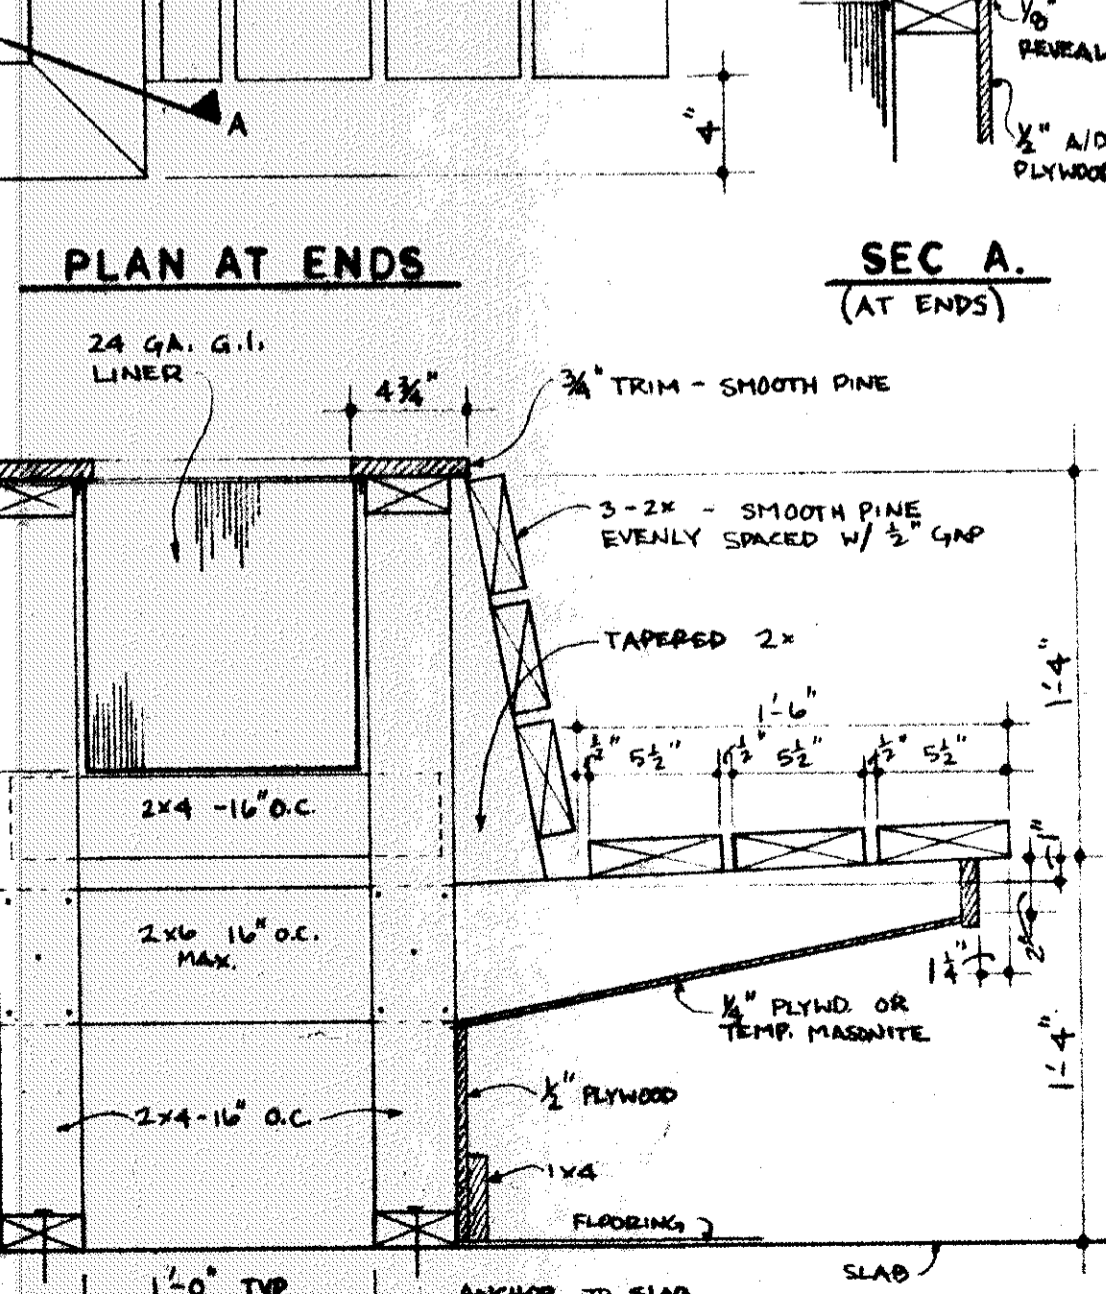

SEC.-ITEMS #21 & 22  
SCALE 1 1/2" = 1'-0"

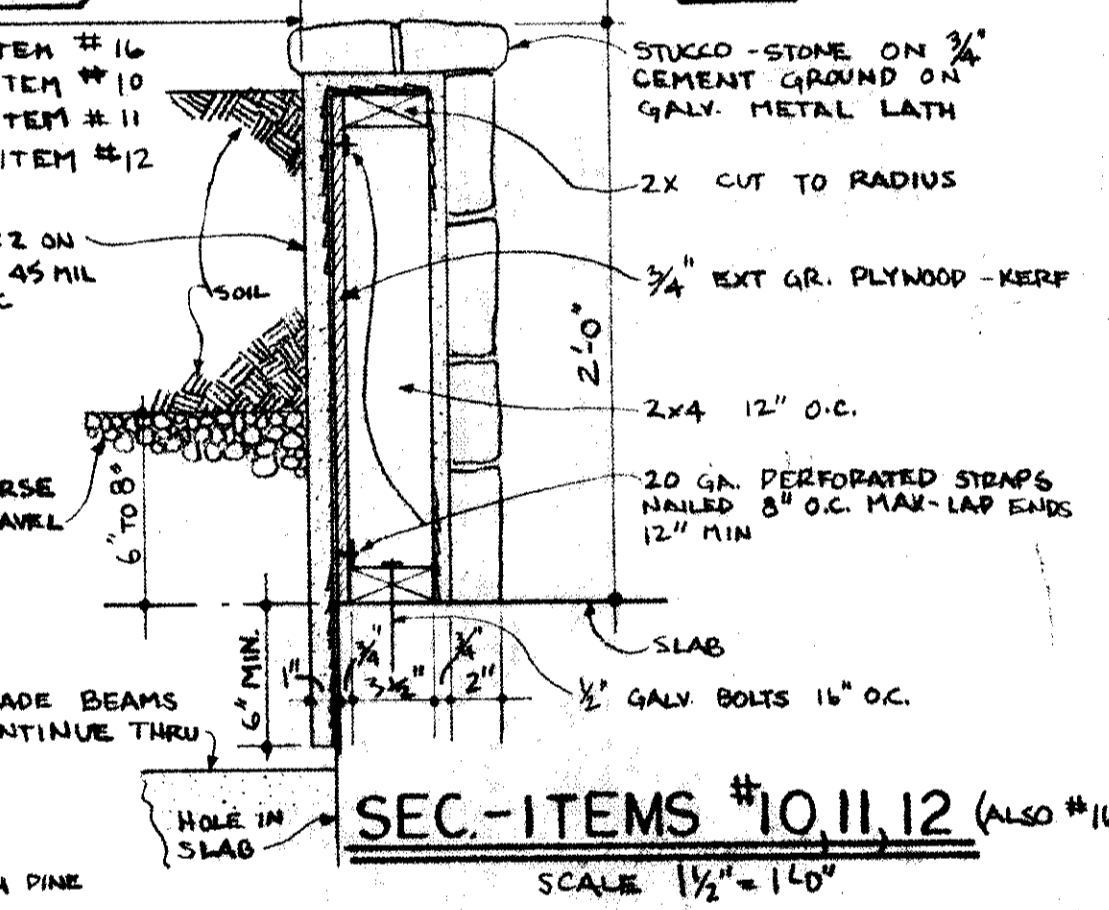

SEC.-ITEMS #10, 11, 12 (ALSO #16)  
SCALE 1/2" = 1'-0"

ITEM #	DESCRIPTION
1	SUSPENDED WOOD FRAME - SEE DETAIL SH. 14
2	DITTO
3	DITTO
4	POOL
5	PREFAB FIBERGLASS W/ PUMP MFGD. BY HERITAGE GARDENS CO; P.O. BOX 361; RT. 5 WEST OF CANASTOTA, N.Y.; 13032; PH: 315/697-9093
6	MODEL # GP7A, 2 POOLS JOINED TOGETHER
7	BRIDGE # BR-2-A WITH RAILS SAME MFR.
8	ROCK WATERFALL OF FIBERGLASS, INCL PUMP
9	# WF-7 SAME MFR.
10	POOL # G-P-10 SAME MFR.
11	WATERWHEEL # WW-1 SAME MFR.
12	ROUND WOODEN TREE PLANTER - BENCH: DETAIL SHEET 14
13	ROUND TREE STONE PLANTER 4" INSIDE DIA.
14	ROUND TREE STONE PLANTER 3" INSIDE DIA.
15	ROUND TREE STONE PLANTER 5 1/2" INSIDE DIA.
16	SQUARE WOODEN TREE PLANTER-BENCH
17	SQUARE WOODEN TREE PLANTER-BENCH
18	RECT. WOODEN TREE PLANTER-BENCH
19	SQUARE STONE PLANTER
20	RECTANGULAR PLANTER 8'-6" X 2'-0" (WOODEN)
21	RECTANGULAR PLANTER 6'-0" X 1'-3" (WOODEN)
22	RECTANGULAR PLANTER 5'-6" X 1'-3" (WOODEN)
23	RECTANGULAR PLANTER-BENCH 5' LONG (WOODEN)
24	RECTANGULAR PLANTER-BENCH 8' LONG (WOODEN)
25	RECTANGULAR PLANTER-BENCH 5' LONG (WOODEN)
26	SQUARE PLANTER # R30" X 18" HIGH, SAME MFR.
27	ROUND PLANTER # R24" X 18" HIGH, SAME MFR.
28	RECT. PLANTER # R18" DIA. X 48" LONG, SAME MFR.
29	SQUARE PLANTER # 530" X 30" X 18" HIGH WITH CAP SAME MFR.
30	SQUARE PLANTER # S18" X 18" X 18" HIGH, SAME MFR.
31	ROUND TRASH RECEPTACLE - RT CP 24" DIA X 30" HIGH SAME MFR.
32	PREFAB FIBERGLAS WATERFALL WITH PUMP MODEL # "ROCKWALL" WATERFALL SAME MFR. AS ITEM 4 ABOVE. 4 1/2" WIDE X 8 1/2" HIGH 18" BASE
33	L-3 LIGHT - 450WATT BY HERITAGE GARDENS (SEE ITEM 4)

**HUDDLESTON & WHITE ARCHITECTS - ENGINEERS**  
 2801 N. HULLEN ST. METairie, LA 70002  
 J. M. HUDDLESTON, AIA (504) 887-5250  
 WILLIAM H. WHITE, P.E. (504) 394-4618