

PLUMBING RISER DIAGRAM  
N.T.S.






THE RISE/SEWER  
SYSTEM FIELD  
VENT LOCATION

THE RISE/SEWER  
SYSTEM FIELD  
VENT LOCATION

TO DOWN SPILL WATER HEATERS

ALL WATER SUPPLY LINES  
SHALL BE 3/4" COPPER

ATTIC  
1  
PLUMBING PLAN  
1/8" = 1'-0"

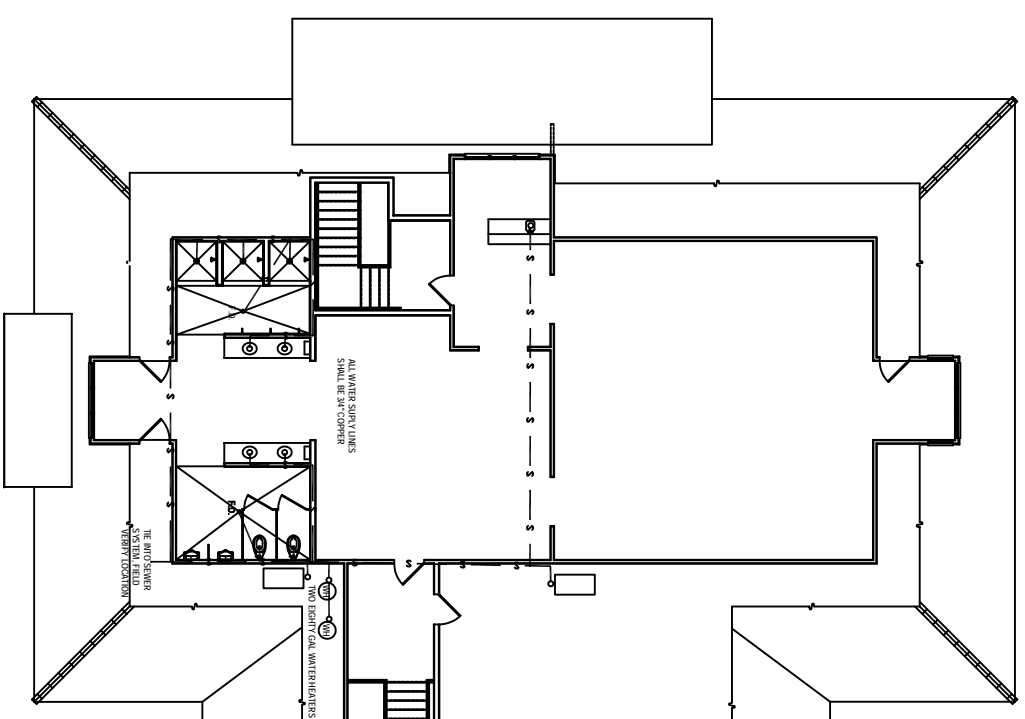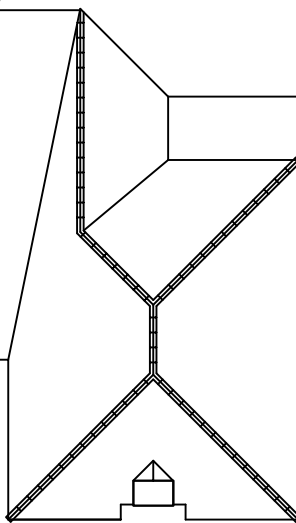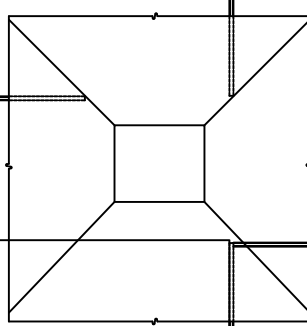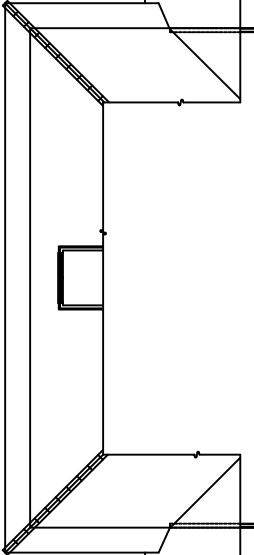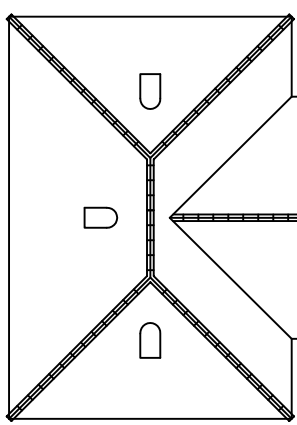

REVISED: NO.

P-2

DRAWING:  
DRAWN: DAMMON  
PROJECT:

SCALE: AS NOTED  
DATE: 01-23-07  
FOLD:

TCHEFUNCTA COUNTRY CLUB  
NEW CLUBHOUSE  
COVINGTON, LOUISIANA

DAMMON ENGINEERING, INC.  
1000 FLORIDA AVENUE 688-840-8888 BELZEL, LA. 70448  
DAMMONENGINEERING.COM

P-2