

**DAMMON
ENGINEERING, INC.**

CHIEF ENGINEER
EMMETT
DAMMON, P.E.

CHIEF ARCHITECT
ROBERT
WILTSE

1095 FLORIDA AVENUE
SLIDELL, LA. 70458
OFFICE: 985-649-5832
FAX: 985-641-5950

WEBSITE:
WWW.DAMMONENGINEERING.COM

EMAIL:
DAMMONENG@BELLSOUTH.NET

ARCHITECTURE

ENGINEERING

STUDIES

PLANNING

INVESTIGATION

EXPERT WITNESS

GREEN-STATEFARM
RETAIL COMPLEX
GAUSE
BLVD., WEST
SLIDELL, LA

**REFLECTED
CEILING PLAN**

REV:

SCALE: AS NOTED


JOB#: 2057

DATE: 04-19-10

SHEET

A-6

OF

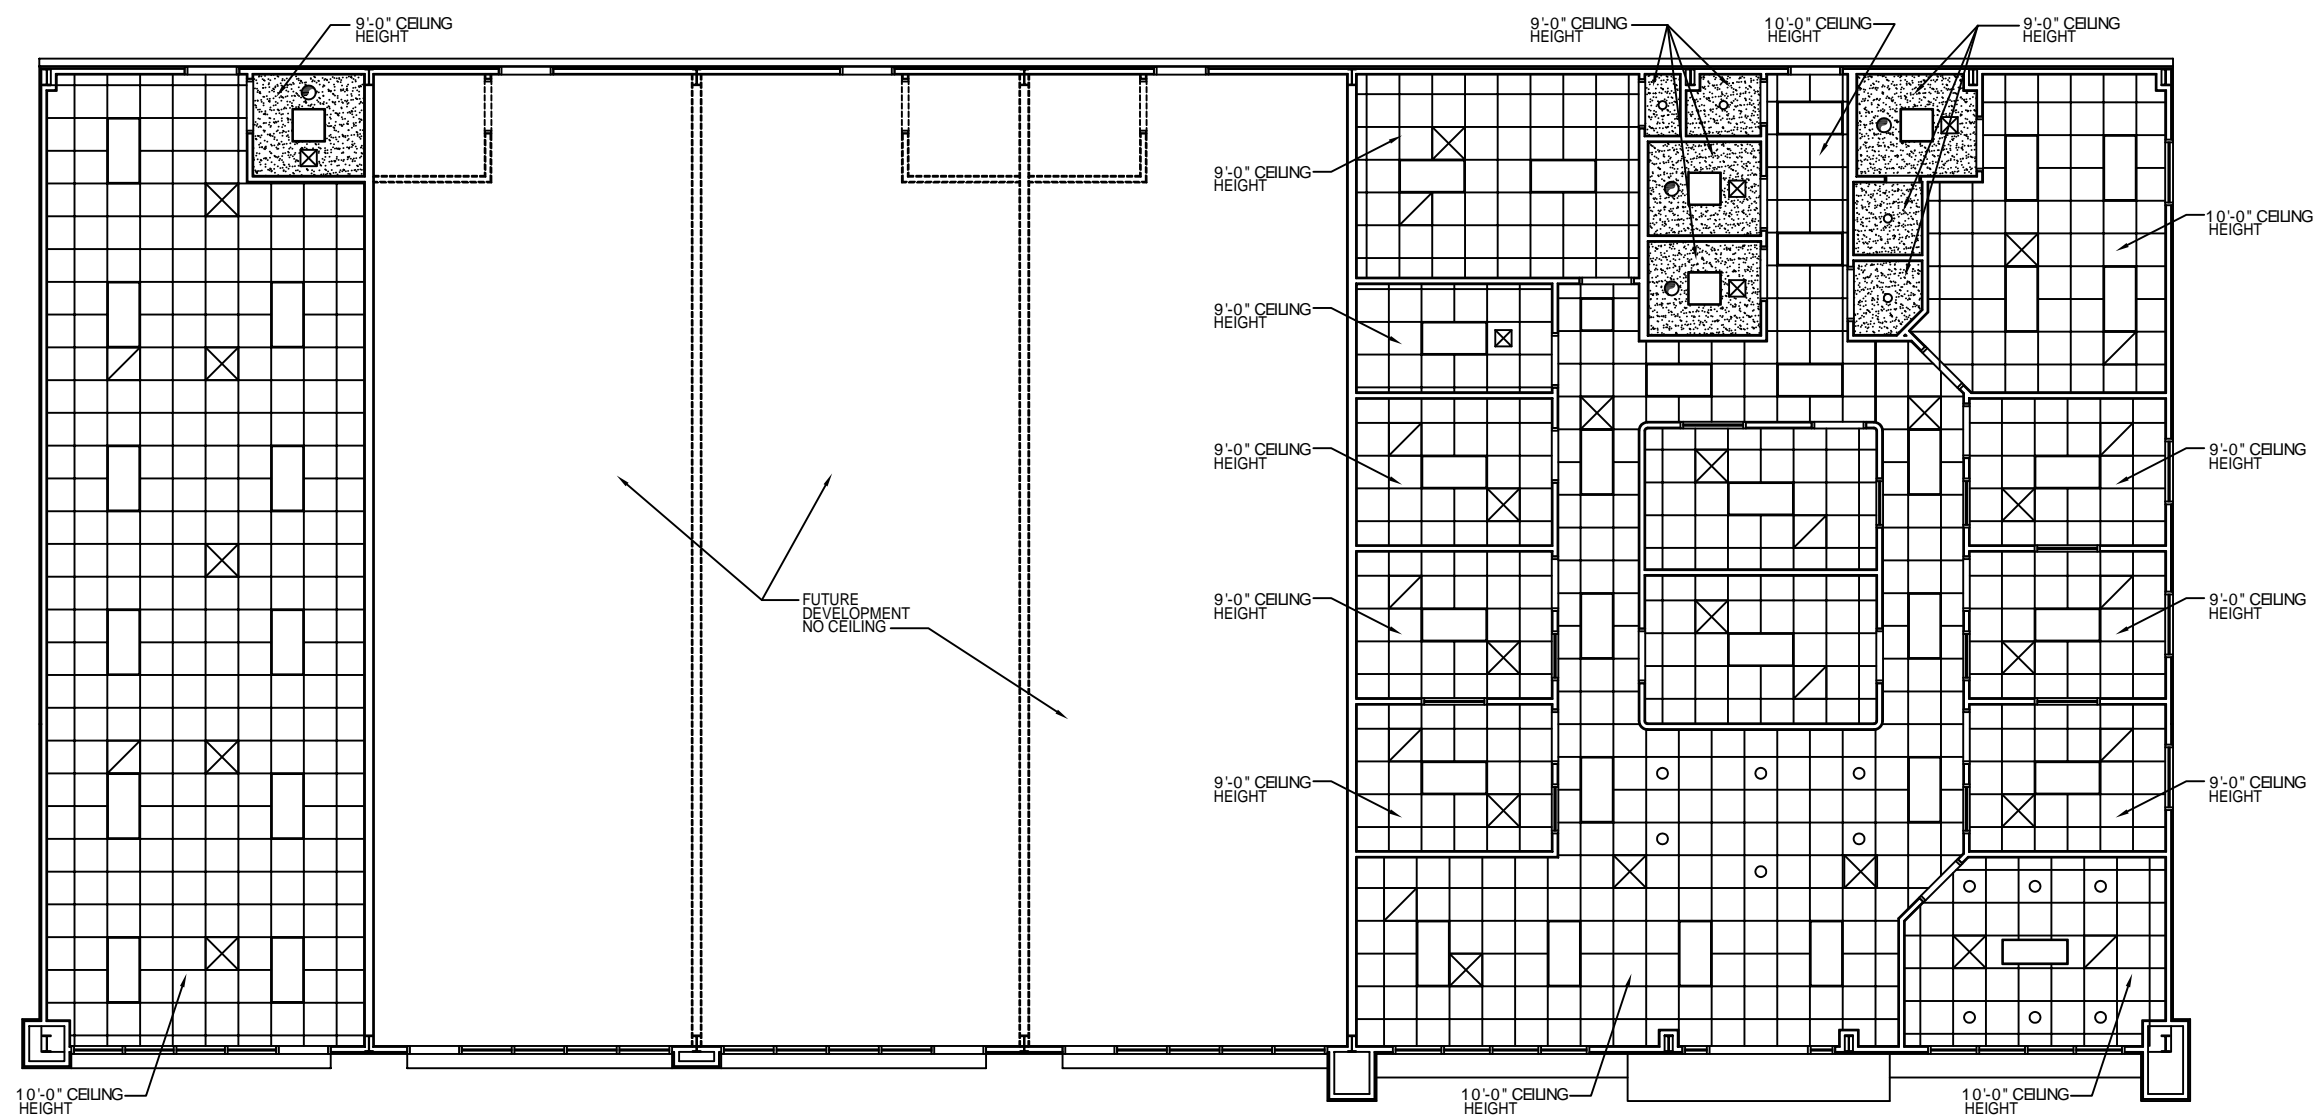

REFLECTED CEILING PLAN

SCALE: 3/16"=1'



LEGEND

- A.C.T. CEILING GRID (2'x2')
- GYPSUM BOARD CEILING
- SUPPLY AIR
- RETURN AIR
- 2'x4' FLUORESCENT LIGHT
- 2'x2' FLUORESCENT LIGHT
- 18"x4' FLUORESCENT CONFERENCE ROOM LIGHT
- EXHAUST FAN
- CAN LIGHT
- STANDARD BULB FIXTURE

PRELIMINARY (NOT FOR CONSTRUCTION)