



VIOLA STREET

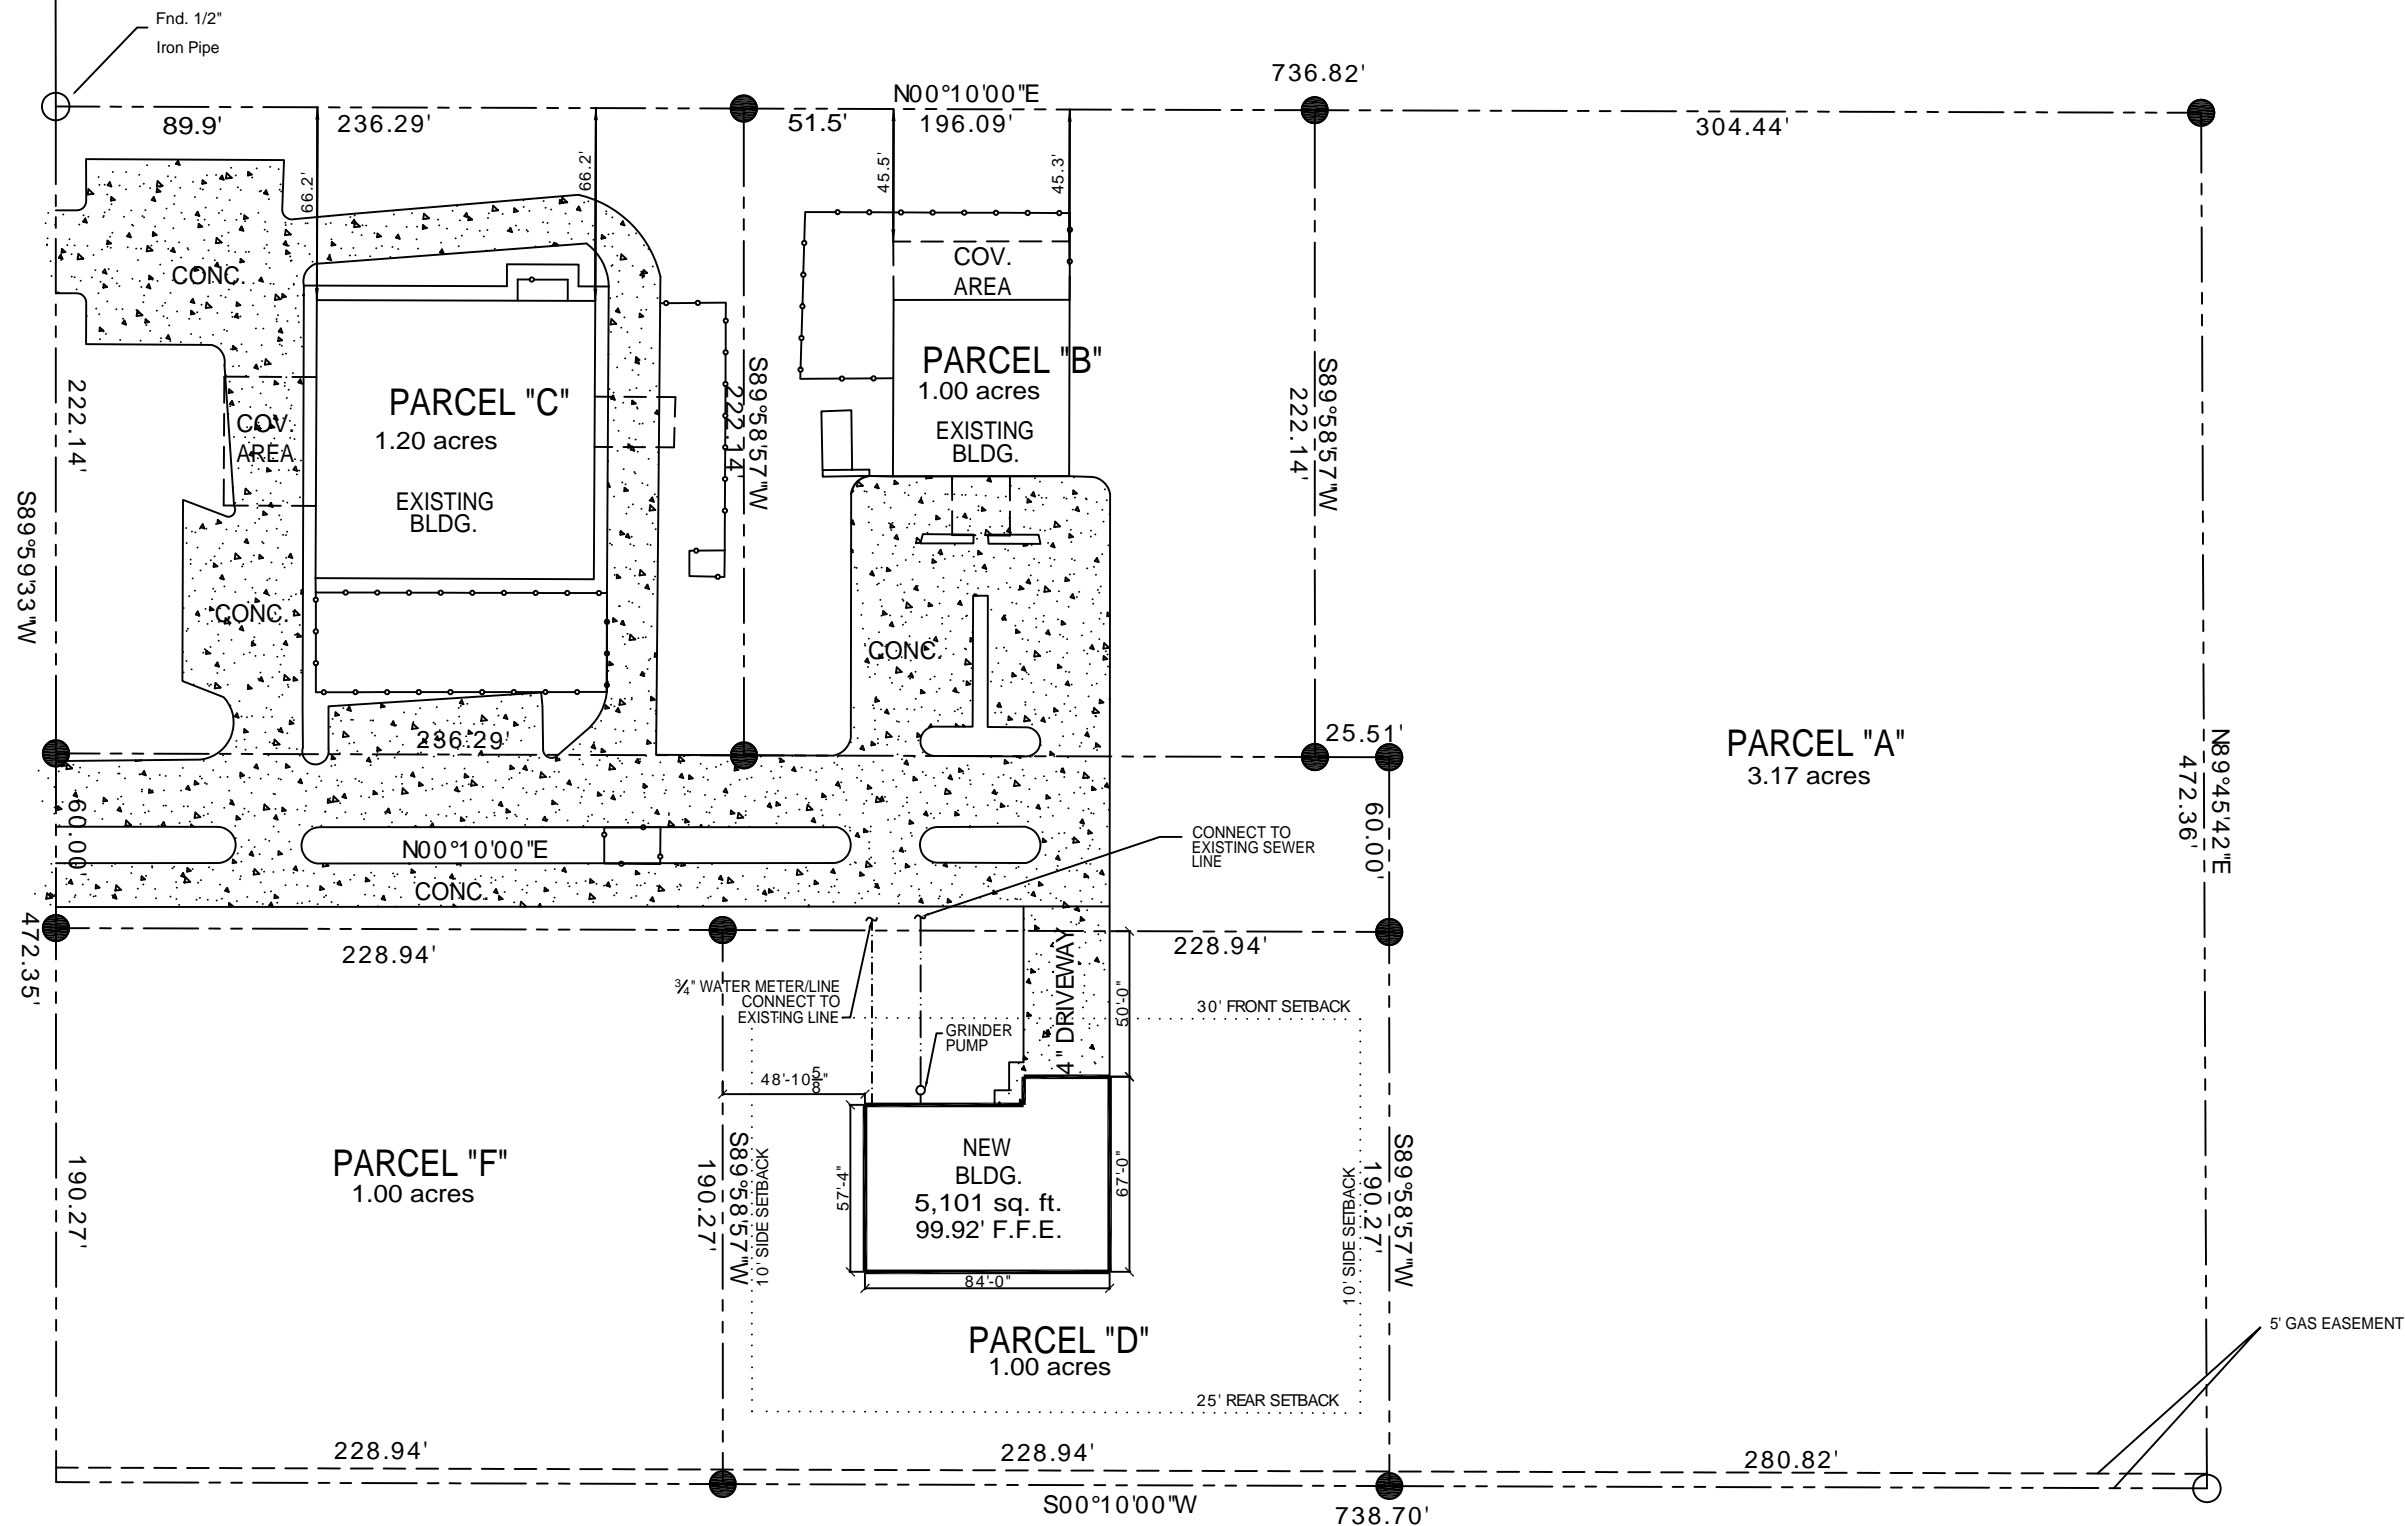

SITE PLAN  
SCALE: 1"=30'-0"

LEGEND

- - - - - PROPERTY LINE
- ..... SETBACK
- NEW BUILDING OUTLINE
- - - - - 5' GAS EASEMENT
- ..... SEWER LINE
- ..... WATER LINE

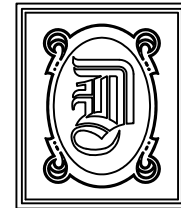

**DAMMON**  
ENGINEERING, INC.

CHIEF ENGINEER  
EMMETT  
DAMMON, P.E.

CHIEF ARCHITECT  
ROBERT  
WILTSE

1095 FLORIDA AVENUE  
SLIDELL, LA. 70458  
OFFICE: 985-649-5832  
FAX: 985-641-5950

WEBSITE:  
WWW.DAMMONENGINEERING.COM

EMAIL:  
DAMMONENG@BELLSOUTH.NET

ARCHITECTURE

ENGINEERING

STUDIES

PLANNING

INVESTIGATION

EXPERT WITNESS

NEW  
LIVING  
FACILITY

STARC WEST  
1705 VIOLA ST  
MANDEVILLE, LA

SITE  
PLAN

REV:

SCALE: AS NOTED

JOB#: 2081

DATE: 11-4-10

SHEET 3

**C-2**

OF 17