

**DAMMON ENGINEERING, INC.**

CHIEF ENGINEER  
EMMETT DAMMON, P.E.

CHIEF ARCHITECT  
ROBERT WILTSE

554 OLD SPANISH TRAIL  
SLIDELL, LA. 70458  
OFFICE: 985-649-5832  
FAX: 985-641-5950

WEBSITE:  
WWW.DAMMONENGINEERING.COM

EMAIL:  
DAMMONENG@BELLSOUTH.NET

- ARCHITECTURE
- ENGINEERING
- STUDIES
- PLANNING
- INVESTIGATION
- EXPERT WITNESS

PAUL REES  
OFFICE BUILDING  
2275 8TH. ST.  
MANDEVILLE, LA  
70471

**FLOOR PLAN**

*Robert Wiltse*

REV:

SCALE: AS NOTED


JOB#: 2104

DATE: 05-20-11

SHEET 10

**A-1**

OF 20

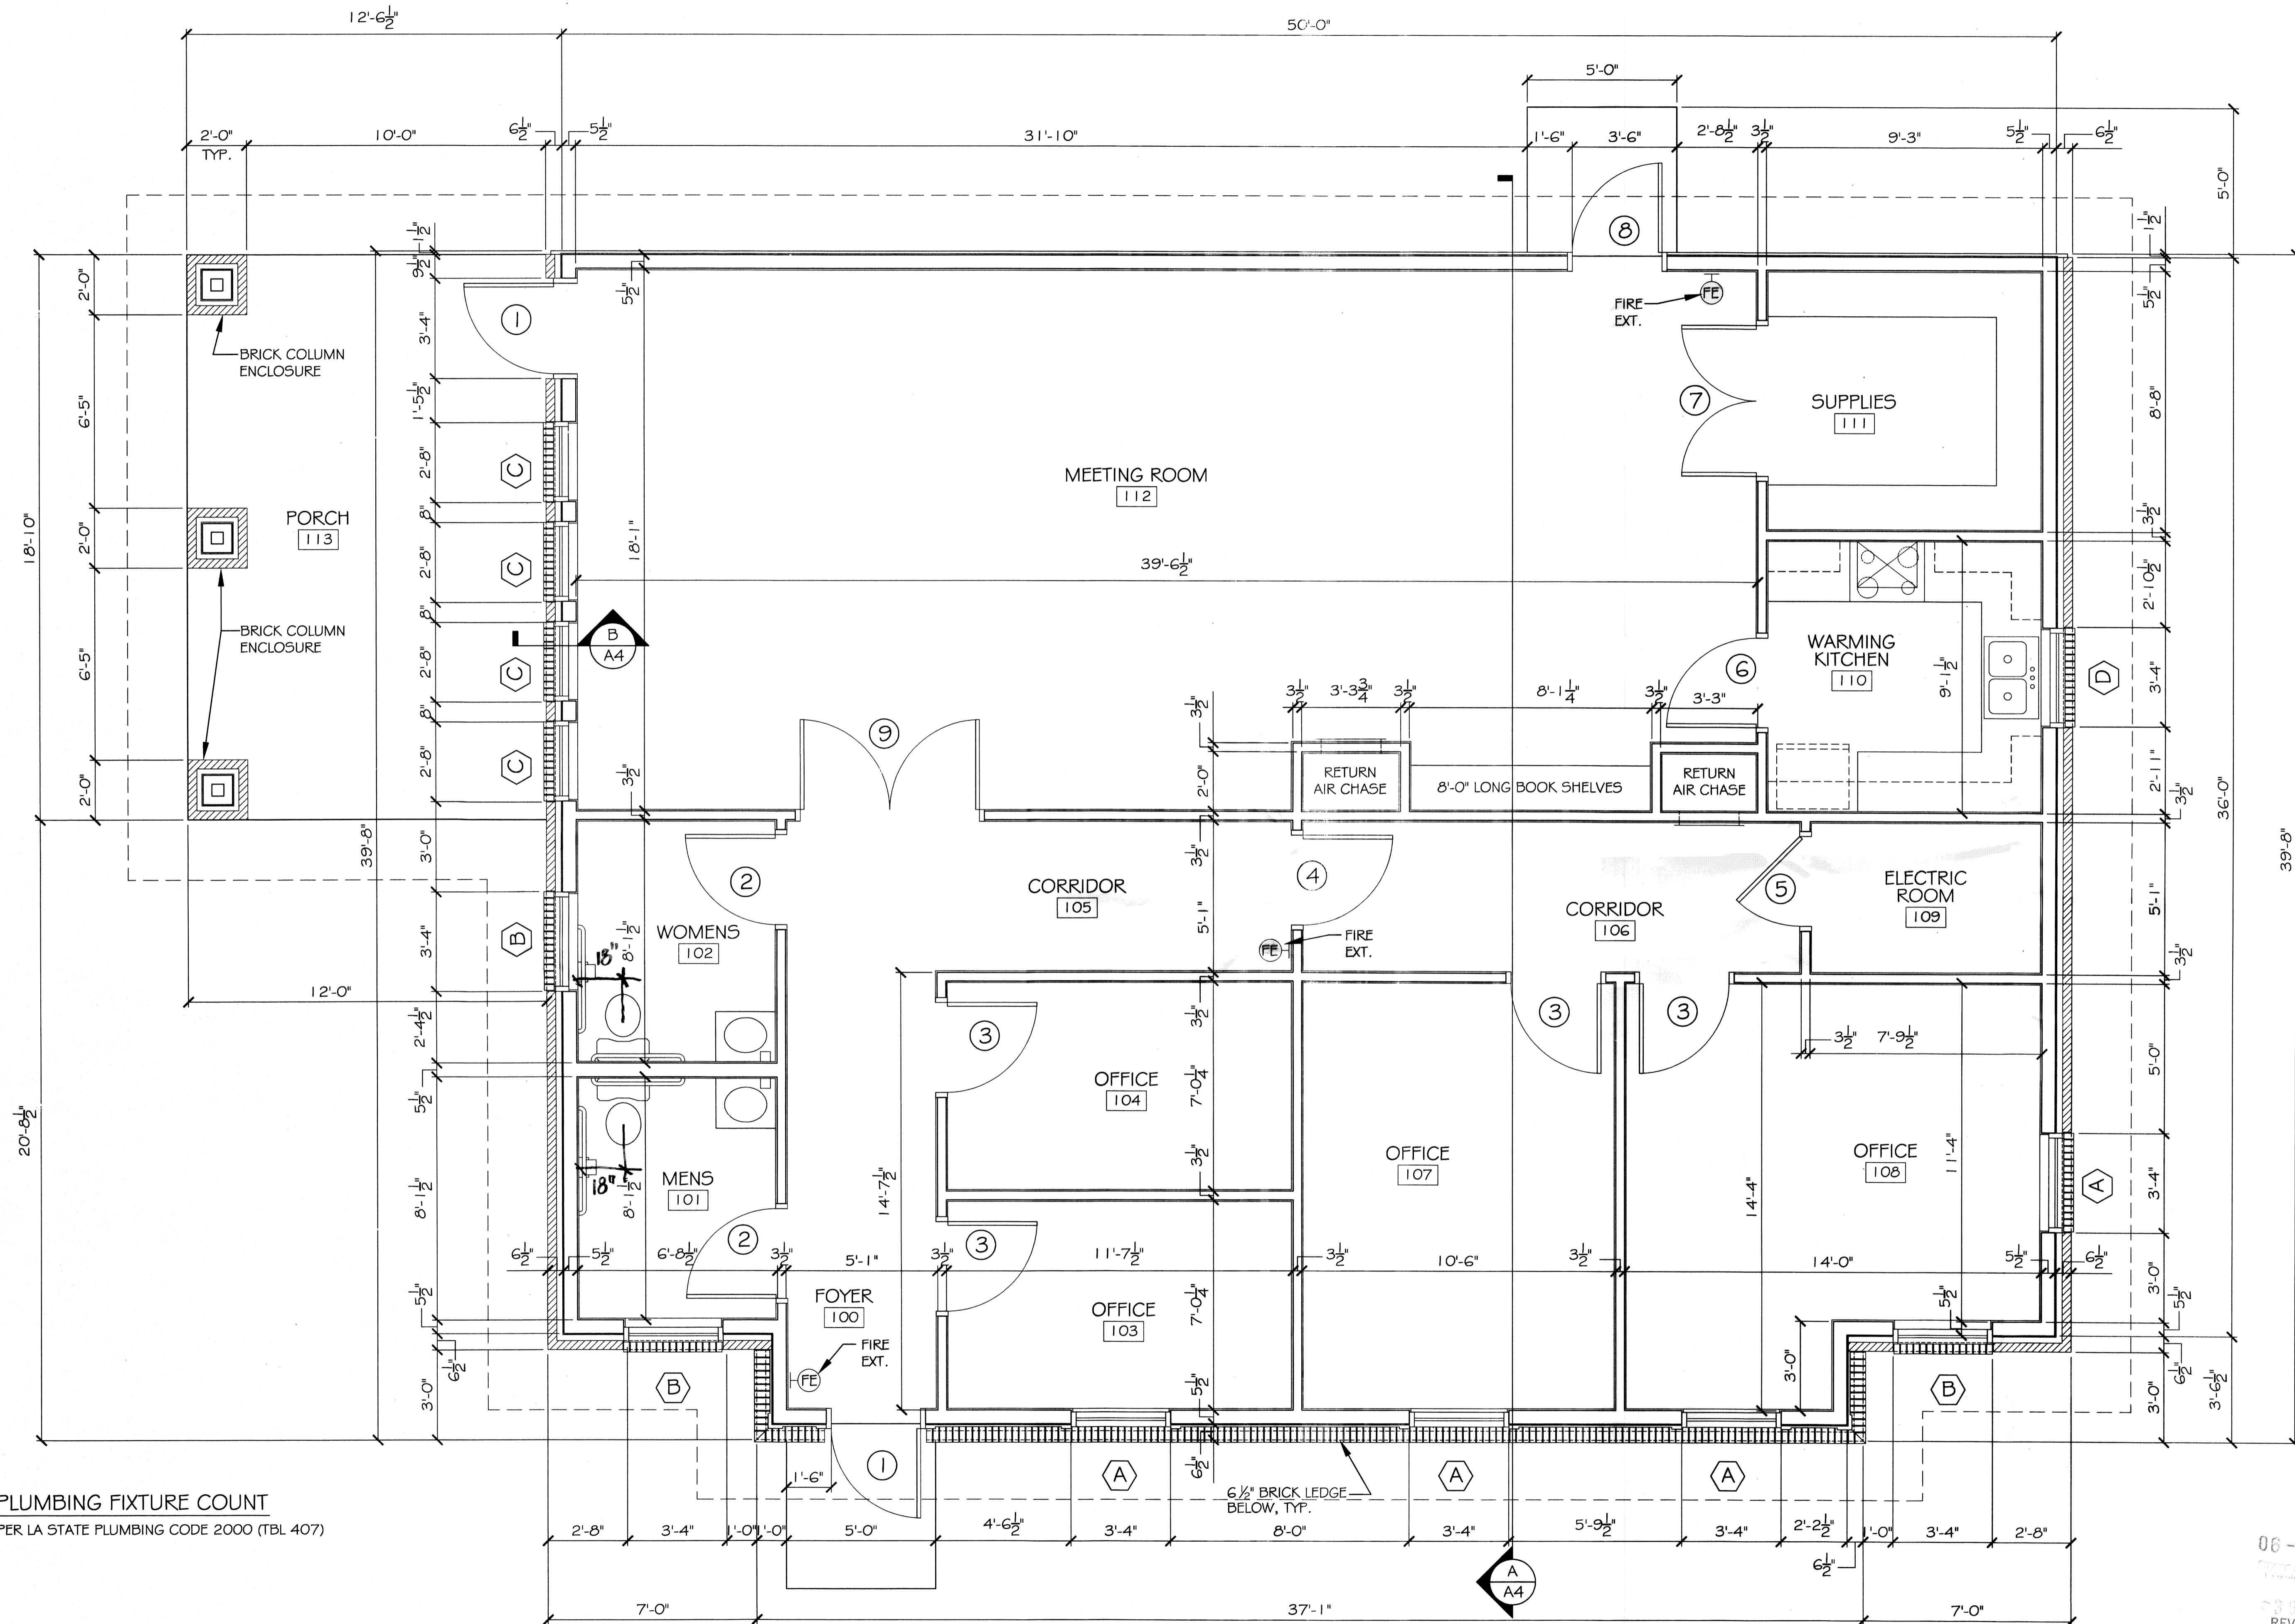

**PLUMBING FIXTURE COUNT**  
PER LA STATE PLUMBING CODE 2000 (TBL 407)

**FLOOR PLAN**  
SCALE: 3/8" = 1'

06-01-11  
 REVIEWED FOR  
 STATE FIRE MARSHAL  
 AS PER REVIEW LETTER  
 BY: COREY THOMAS, PLAN REVIEW DEPUTY  
*Corey Thomas*