

ABBREVIATIONS


SYMBOLS USED AS ABBREVIATIONS:

∠	ANGLE	EMXP	EXPANDED METAL PLATE	MECH	MECHANICAL	STSM	STANDING SEAM
CL	CENTERLINE	EXP	EXPOSED	MED	MEDIUM	SUS	SUSPENDED
[CHANNEL	EXST	EXISTING	MET	METAL	SV	SHEET VINYL
d	FENNY	EXT	EXTERIOR	MFR	MANUFACTURE(ER)	SYM	SYMMETRY(VICAL)
⊥	PERPENDICULAR			MH	MANHOLE	SYN	SYNTHETIC
PL	PLATE	FA	FIRE ALARM	MICRO	MICROWAVE	SYS	SYSTEM
∅	ROUND	FAS	FASTEN	MIN	MINIMUM		
		FB	FACE BRICK	MIR	MIRROR	T	TREAD
		FBD	FIBERBOARD	MISC	MISCELLANEOUS	TB	TOWEL BAR
		FBO	FURNISHED BY OTHERS	MMB	MEMBRANE	TEL	TELEPHONE
		FD	FLOOR DRAIN	MO	MASONRY OPENING	THK	THICKNESS
		FE	FIRE EXTINGUISHER	MOV	MOVABLE	THR	THRESHOLD
		FEC	FIRE EXTINGUISHER AND CABINET	MOUNT	MOUNT(ED)(ING)	TKBD	TACKBOARD
		FF	FACTORY FINISH	MULL	MULLION	TOL	TOLERANCE
		FFL	FINISHED FLOOR LINE	MWK	MILLWORK	TOS	TOP OF STEEL
		FHC	FIRE HOSE CABINET			TPD	TOILET PAPER DISPENSER
		FIN	FINISH(ED)	N	NORTH	TRI	TRIPLE
		FJT	FLUSH JOINT	NAT	NATURAL	TSL	TOP OF SLAB
		FLG	FLASHING	NIC	NOT IN CONTRACT	TV	TELEVISION
		FLR	FLOOR	NL	NAILABLE	TW	TOP OF WALL
		FLUOR	FLUORESCENT	NMT	NONMETALLIC	TYP	TYPICAL
		FLX	FLEXIBLE	NOM	NOMINAL		
		FND	FOUNDATION	NR	NOISE REDUCTION	UC	UNDERCOUNTER
		FOC	FACE OF CONCRETE	NRC	NOISE REDUCTION COEFFICIENT	UNF	UNFINISHED
		FOF	FACE OF FINISH	NTS	NOT TO SCALE	UCN	UNLESS OTHERWISE NOTED
		FOM	FACE OF MASONRY			UR	URINAL
		FOS	FACE OF STUDS	OA	OVERALL	UT	UNDERCUT
		FPL	FLOOR PLATE	OC	ON CENTER(S)		
		FR	FRAMED/FRAMING	OD	OUTSIDE DIAMETER	VB	VELOC BARRIER
		FRC	FIRE-RESISTANT COATING	OFCI	OWNER FURNISHED, CONTRACTOR INSTALLED	VCJ	VERTICAL CONTROL JOINT
		FRG	FORGED	OFI	OWNER FURN. AND INSTALLED	VCT	VINYL COMPOSITION TILE
		FRT	FIRE-RETARDANT	OH	OVERHEAD	VERT	VERTICAL
		FTG	FOOTING	OJ	OPEN-WEB JOIST	VF	VINYL FABRIC
		FUR	FURRED	OPG	OPENING	VIF	VERIFY IN FIELD
				OPH	OPPOSITE HAND	VJ	V-JOINT(ED)
				OPP	OPPOSITE	VNR	VENEER
				FB	PANIC BAR	VOJ	VERIFY ON JOB
				PERF	PERFORATE(D)	VR	VELOC BARRIER
				PERI	PERIMETER	VRM	VERMICULITE
				PFBD	PREFABRICATE(D)	VWB	VINYL WALL BASE
				PFN	PREFINISHED	VT	VINYL TILE
				PL	PLATE		
				PL	PROPERTY LINE	W	WEST
				PLAM	PLASTER LAMINATE	W	WITH
				PLAS	PLASTER	WB	WOOD BASE
				PNL	PANEL	WC	WATER CLOSET
				PRF	PREFORMED	WD	WOOD
				PRP	PROPERTY LINE	WH	WALL HUNG
				PSF	POUNDS PER SQUARE FOOT	WM	WIRE MESH
				PSI	POUNDS PER SQUARE INCH	WPF	WATERPROOFING
				PTD	PAINT(ED)	WPT	WORKING POINT
				PT	POINT	WS	WATERSTOP
				P DISP	PAPER TOWEL DISPENSER	WSCT	WAINSCOT
				PTN	PARTITION	WWF	WELDED WIRE FABRIC
				PTR	PAPER TOWEL RECEPTACLE		
				PV	PAVE(D)(ING)		
				PVC	POLY(VINYL) CHLORIDE		
				PVMT	PAVEMENT		
				QT	QUARRY TILE		
				R	RISER		
				RA	RETURN AIR		
				RAD	RADIUS		
				RB	RUBBER BASE		
				RBT	RABBET		
				RD	ROOF DRAIN		
				REF	REFERENCE		
				REFR	REFRIGERATOR		
				REG	REGISTER		
				REINF	REINFORCE(D)(ING)		
				RES	RESILIENT		
				RET	RETURN		
				REV	REVISION(S)/REVISED		
				RFL	REFLECT(ED)(IVE)(OR)		
				RH	RIGHT HAND		
				RL	RAIL(ING)		
				RM	ROOM		
				RO	ROUGH OPENING		
				ROW	RIGHT OF WAY		
				RT	RUBBER TILE		
				RWC	RAINWATER CONDUCTOR		
				S	SOUTH		
				SC	SOLID CORE		
				SCH	SCHEDULE		
				SD	STORM DRAIN		
				S DISP	SOAP DISPENSER		
				SEC	SECTION		
				SG	SHEET GLASS		
				SH	SHELF/SHELVING		
				SHO	SHORE(D)(ING)		
				SHT	SHEET		
				SHTH	SHEATHING		
				SIM	SIMILAR		
				SL	SLEEVE		
				SNT	SEALANT		
				SP	SOUNDPROOF		
				SPC	SPACER		
				SPEC	SPECIFICATION(S)		
				SPKR	SPEAKER		
				SPL	SPECIAL		
				SQ	SQUARE		
				SSK	SERVICE SINK		
				SST	STAINLESS STEEL		
				ST	STEEL		
				STD	STANDARD		
				STG	SEATING		
				STO	STORAGE		
				STR	STRUCTURAL		


ABBREVIATIONS:

A	FRESH AIR	ABV	ABOVE	AC	AIR CONDITIONING	ACT	ACOUSTICAL TILE	ADD	ADDENDUM	ADH	ADHESIVE	ADJ	ADJUSTABLE	AFF	ABOVE FINISHED FLOOR	AGG	AGGREGATE	ALT	ALTERNATE	ALUM	ALUMINUM	ANC	ANCHOR	ANOD	ANODIZED	ARCH	ARCHITECTURAL	ASPH	ASPHALT	AUTO	AUTOMATIC																																
BC	BRICK COURSE	BD	BOARD	BEL	BELOW	BG	BUMPER GUARD	BJT	BED JOINT	BIT	BITUMINOUS	BLDG	BUILDING	BLK	BLOCK	BLKG	BLOCKING	BM	BENCH MARK	BO	BY OTHERS	BOT	BOTTOM	BRG	BEARING	BRDG	BRIDGE/BRIDGING	BS	BOTH SIDES	BW	BOTHWAYS																																
CAB	CABINET	CCTV	CLOSED CIRCUIT TELEVISION	CEM	CEMENT/CEMENTITIOUS	CER	CERAMIC	CFLG	COUNTERFLASHING	CG	CORNER GUARD	CHBD	CHALKBOARD	CJT	CONTROL JOINT	CK	CALUKING	CLG	CEILING	CLR	CLEAR	CLL	CONTRACT LIMIT LINE	CMU	CONCRETE MASONRY UNIT	CNTR	COUNTER	COL	COLUMN	COMB	COMBINATION	COMP	COMPOSITION	CONC	CONCRETE	CONST	CONSTRUCTION	CONT	CONTINUOUS	CONTR	CONTRACT(OR)	CORK	CORRUGATED	CPT	CARPET(ED)	CRC	COLD ROLLED CHANNEL	CRS	COURSE(S)	CS	COUNTERSINK	CSWK	CASEWORK	CT	CERAMIC TILE	CTR	CENTER	CTRK	CURTAIN TRACK	CTSK	COUNTERSINK SCREW	CJB C	CUBICAL CURTAIN
D	DRAIN	DBL	DOUBLE	DEMO	DEMOLISH	DEP	DEPRESSED	DIAG	DIAGONAL	DIAM	DIAMETER	DIM	DIMENSION	DISP	DISPENSER	DIV	DIVISION	DPR	DAMPER	DS	DOWNSPOUT	DTA	DOVETAIL ANCHOR	DTL	DETAIL	DTS	DOVETAIL ANCHOR SLOT	DW	DISHWASHER	DWR	DRAWER	DWG	DRAWING																														
E	EAST	EA	EACH	EB	EXPANSION BOLT	EJ	EXPANSION JOINT	EL	ELEVATION	ELEC	ELECTRICAL	ELEV	ELEVATOR	EMER	EMERGENCY	ENC	ENCLOSURE	EO	ELECTRICAL OUTLET	EP	ELECTRICAL PANELBOARD	EQ	EQUAL	EQPM	EQUIPMENT	LTR	EXISTING TO REMAIN	EWG	ELECTRIC WATER COOLER	EWH	ELECTRIC WATER HEATER	EXH	EXHAUST																														


SYMBOLS

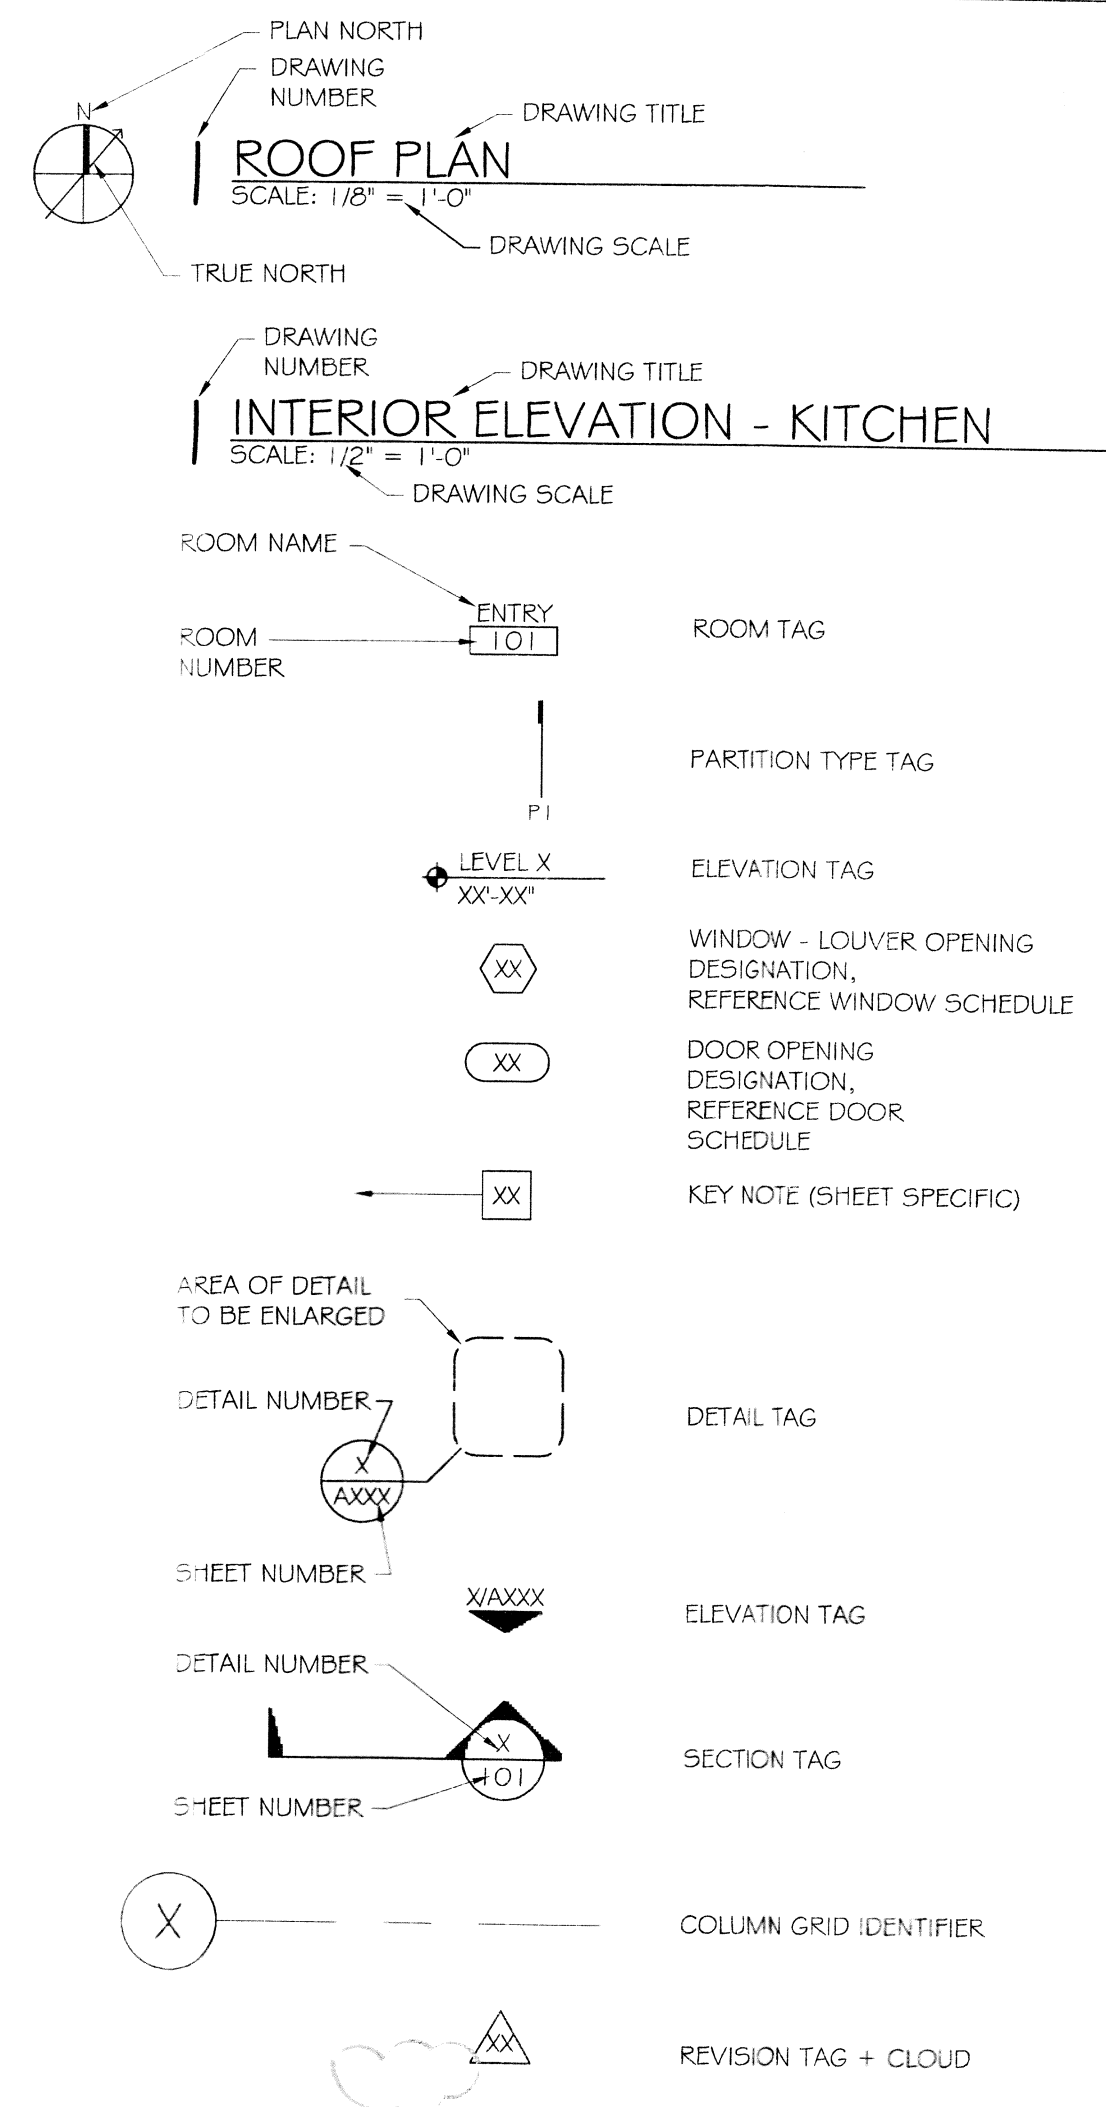

MATL. DESIGNATIONS

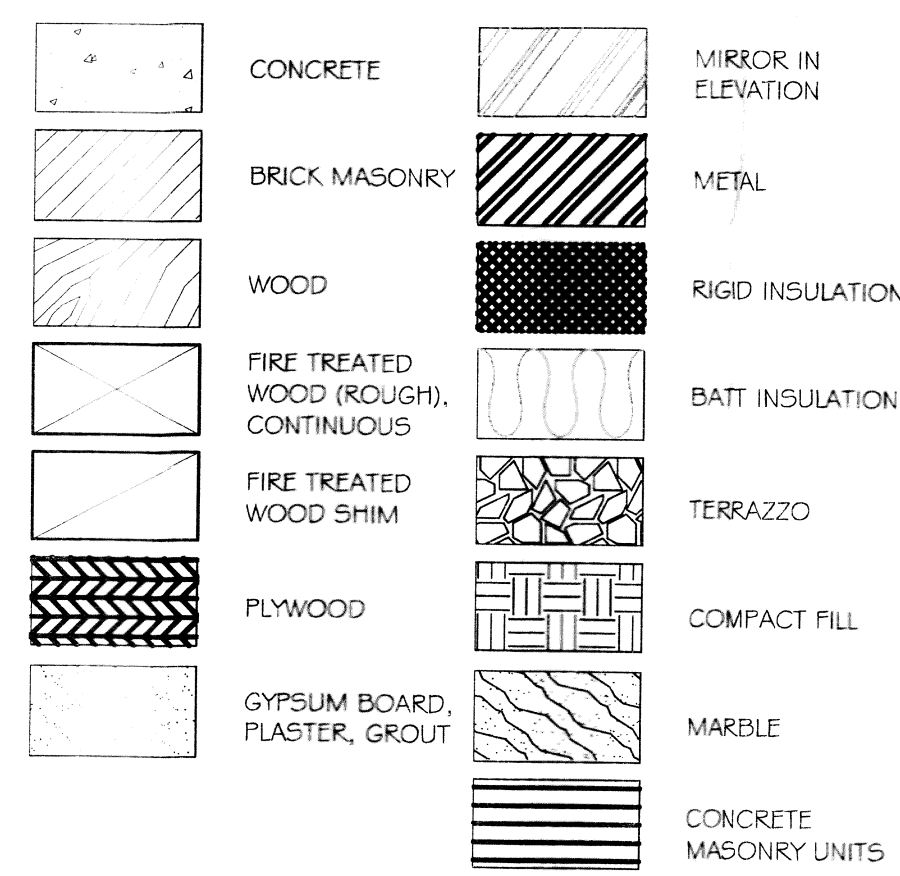

VICINITY MAP

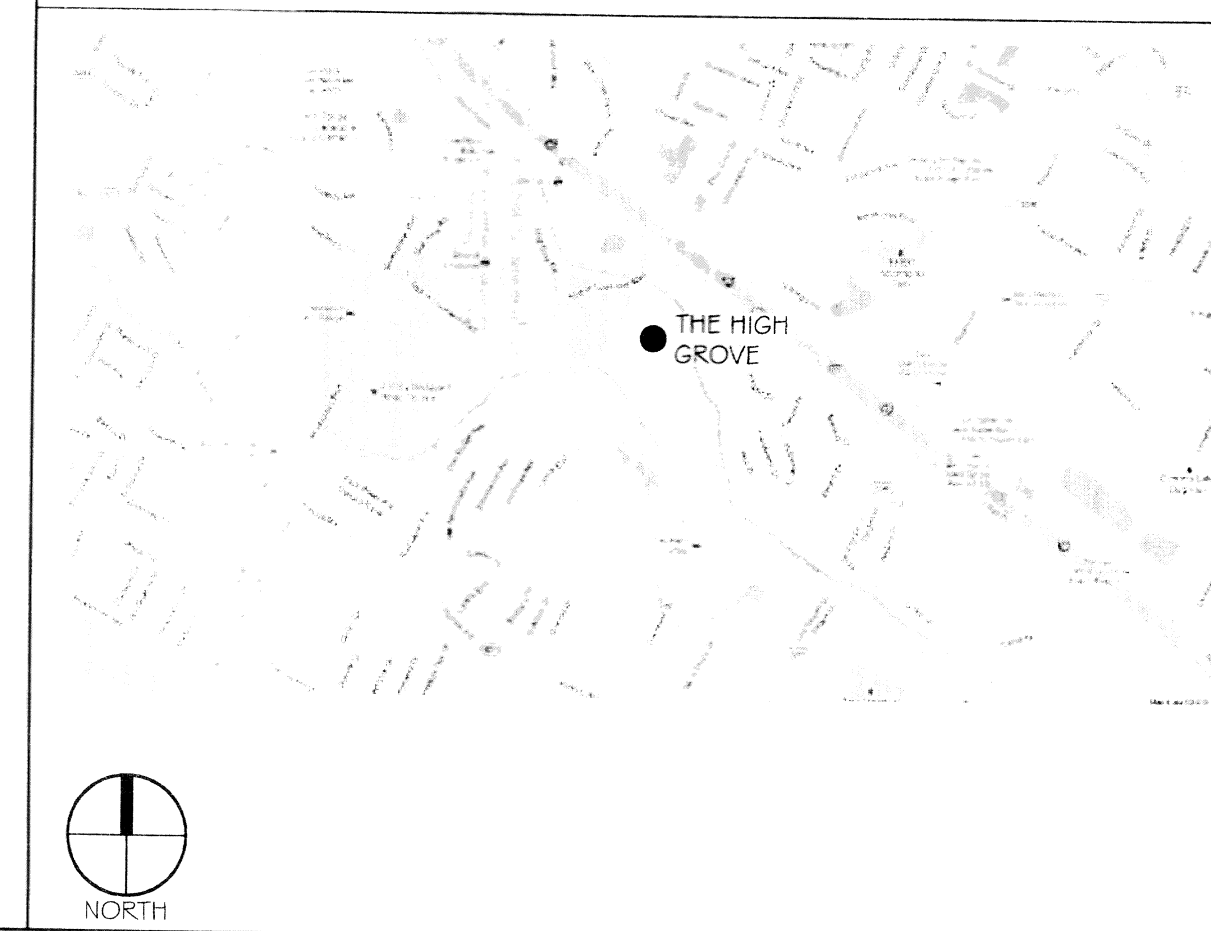

PROJECT STATISTICS

SQUARE FOOTAGE	
MERCHANTILE OCCUPANCY	573
BUSINESS OCCUPANCY	4,238
TOTAL ENCLOSED SPACE	4,811
PROJECT LOCATION: THE HIGH GROVE APARTMENTS SUITE A BATON ROUGE, LA	
OWNER: ERIN WARNER WOODHOUSE SPA 796 INTERSTATE 10 SERVICE ROAD #230 SLIDELL, LA 70461	

GENERAL NOTES

- ALL MATERIALS AND WORK, INCIDENTAL TO THE CONSTRUCTION OF THIS PROJECT, SHALL CONFORM TO ALL GOVERNING CODES, AND REGULATIONS OF AGENCIES IN AUTHORITY.
- CONTRACTOR SHALL PROVIDE ALL PUBLIC PROTECTIONS NECESSARY AS REQUIRED BY LAW.
- THE DRAWINGS, SPECIFICATIONS AND ANY SUBSEQUENTLY ISSUED ADDENDA, AMENDMENTS OR SUCH CHANGE ORDERS APPROVED BY THE OWNER AND THE CONTRACTOR ARE PART OF THESE CONTRACT DOCUMENTS.
- DO NOT SCALE DRAWINGS. CONSULT WITH THE ARCHITECT REGARDING ANY ITEMS IN THE CONTRACT DOCUMENTS THAT REQUIRE CLARIFICATION.
- VERIFY LOCATION OF ALL EQUIPMENT WITH THE ARCHITECT, PRIOR TO INSTALLATION.
- TRASH SHALL BE REMOVED FROM THE SITE NOT LESS THAN TWICE MONTHLY.
- THE GENERAL CONTRACTOR SHALL VERIFY EXISTING CONDITIONS PRIOR TO COMMENCING WORK AND REPORT ANY AND ALL DISCREPANCIES TO THE ARCHITECT.
- CONTRACTOR VEHICLES AND EQUIPMENT NECESSARY FOR CONSTRUCTION MAY BE PARKED ON THE SITE. OTHER VEHICLES PARKED ON THE SITE REQUIRE THE OWNER'S PERMISSION.
- WORK INDICATED AS 'NOT IN CONTRACT', 'NIC', OR 'BY OTHERS' SHALL BE PERFORMED BY OWNERS SEPARATE CONTRACTORS. THE GENERAL CONTRACTOR SHALL COOPERATE TO THE FULLEST EXTENT WITH ALL OTHER CONTRACTORS AND ASSIST IN COORDINATING THE WORK BY SEPARATE CONTRACTORS WITH THE WORK OF THIS CONTRACT.
- NAMING A CERTAIN BRAND, MAKE OR MANUFACTURER IS TO DESIGNATE THE GENERAL STYLE, TYPE, CHARACTER AND QUALITY STANDARD OF THE PRODUCT DESIRED. SUBSTITUTION REQUESTS MUST BE SUBMITTED PRIOR TO BIDDING.
- ALL MATERIALS/EQUIPMENT SHALL BE INSTALLED PER MANUFACTURER'S RECOMMENDATIONS. WORK NOT CONSISTENT WITH MANUFACTURER'S RECOMMENDATIONS WILL BE REJECTED BY OWNER/ARCHITECT.

SHEET INDEX

SHEET NUMBER	SHEET TITLE
G-1	GENERAL INFORMATION SHEET
G-2	LIFE SAFETY PLANS
A-1	ARCHITECTURAL FLOOR PLAN
A-2	REFLECTED CEILING PLAN
A-3	OPENINGS, PARTITIONS, INTERIOR ELEVATIONS
A-4	ROOF PLAN
M-1	MECHANICAL PLAN
M-2	MECHANICAL DETAILS
E-1	POWER PLAN
E-2	LIGHTING PLAN
E-3	NOTES & SCHEDULES
P-1	SANITARY SEWER PLAN
P-2	POTABLE WATER PLAN

DAMMON ENGINEERING, INC.
Architects & Engineers

CHIEF ENGINEER: EMMETT DAMMON, P.E.
CHIEF ARCHITECT: KEVIN J. KINGHEM, P.E.

554 OLD SPANISH TRAIL
SLIDELL, LA 70459

PHONE: 985-449-5932
FAX: 985-441-1390

WOODHOUSE SPA
THE HIGH GROVE APARTMENTS
BATON ROUGE, LA

JOB No: 2163
DATE: 4/30/2013
DRAWN BY: KJK
CHECKED BY: KJK

#	DESCRIPTION	DATE

KEVIN J. KINGHEM
REG. NO. 5580
STATE OF LOUISIANA
REGISTERED ARCHITECT

5/15/13

GENERAL INFORMATION SHEET

SHEET No: 1 OF 15

G-1

MAY 23 2013
433047
REVIEWED FOR
STATE FIRE MARSHAL
AS PER REVISED LETTER
BY JAMES T. BARDNER