



FILE NAME: J:_COMMERCIAL\3208 - Master Vending\Drawing\Sheet\C101 - Site Plan.dwg DATE PLOTTED: 03/02/17 10:51:17 AM PLOT DATE: 03/02/17 10:51:17 AM

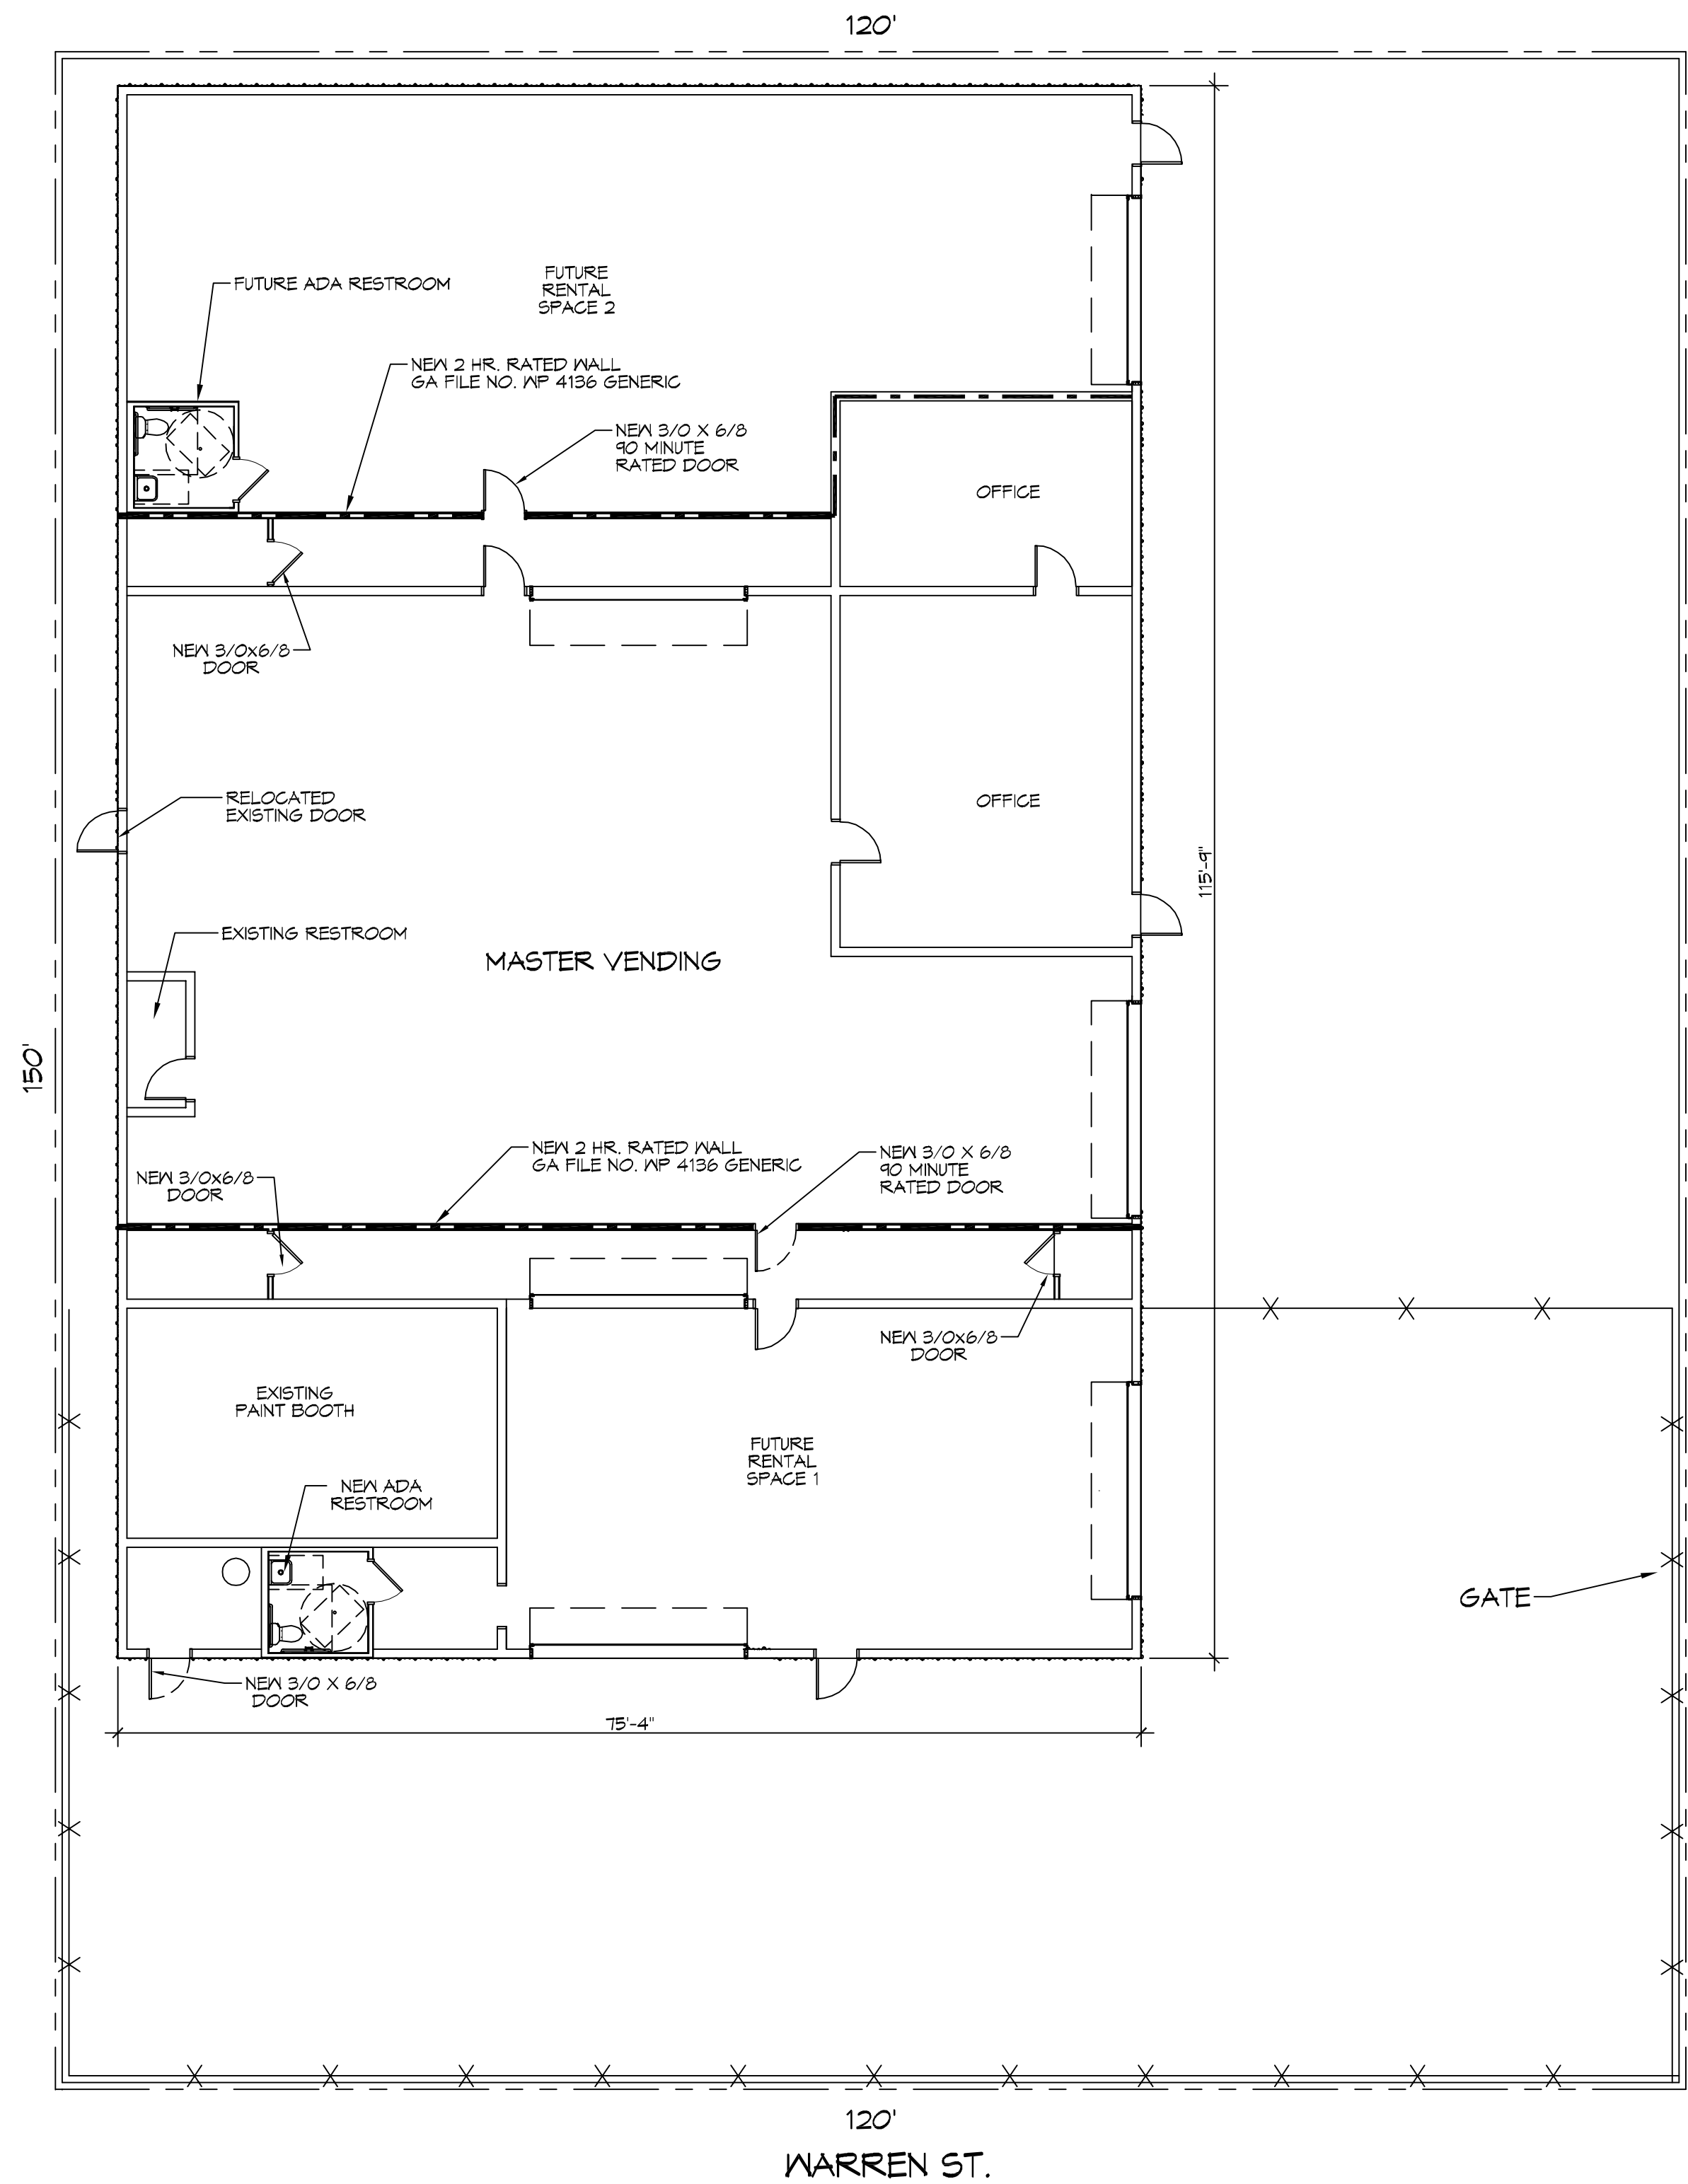

7TH STREET

WARREN ST.

VICINITY MAP

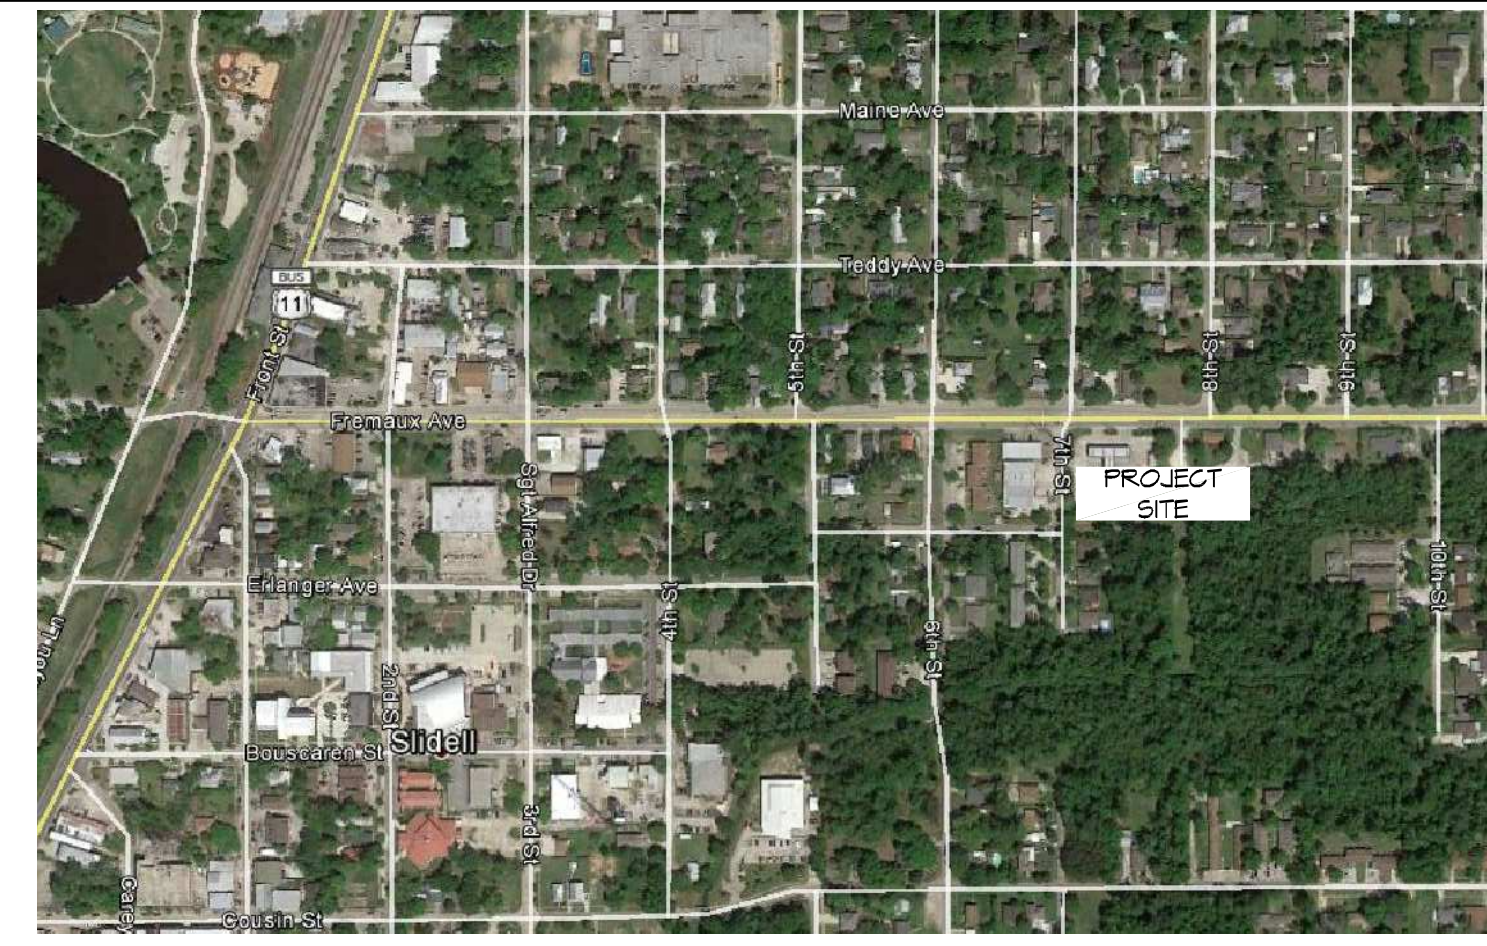

1 SITE PLAN
SCALE: 1"=10'-0"

DAMMON
ENGINEERING, INC.
LOUISIANA & MISSISSIPPI
Chief Engineer: Brian Metch, PE
www.dammonengineering.com
554 Old Spanish Trail
Suldel, LA 70468
info@dammonengineering.com
PH: 985.649.9832

#	DESCRIPTION	DATE

SEAL:

A COMMERCIAL BUILDING FOR
MASTER VENDING
JOB No: 2504 DATE: 03-02-17
DRAWN BY: JASHM CHECKED BY: CKD

SHEET TITLE:
SITE PLAN

DRAWING NUMBER:
C101

SHEET No: 1 of 2