
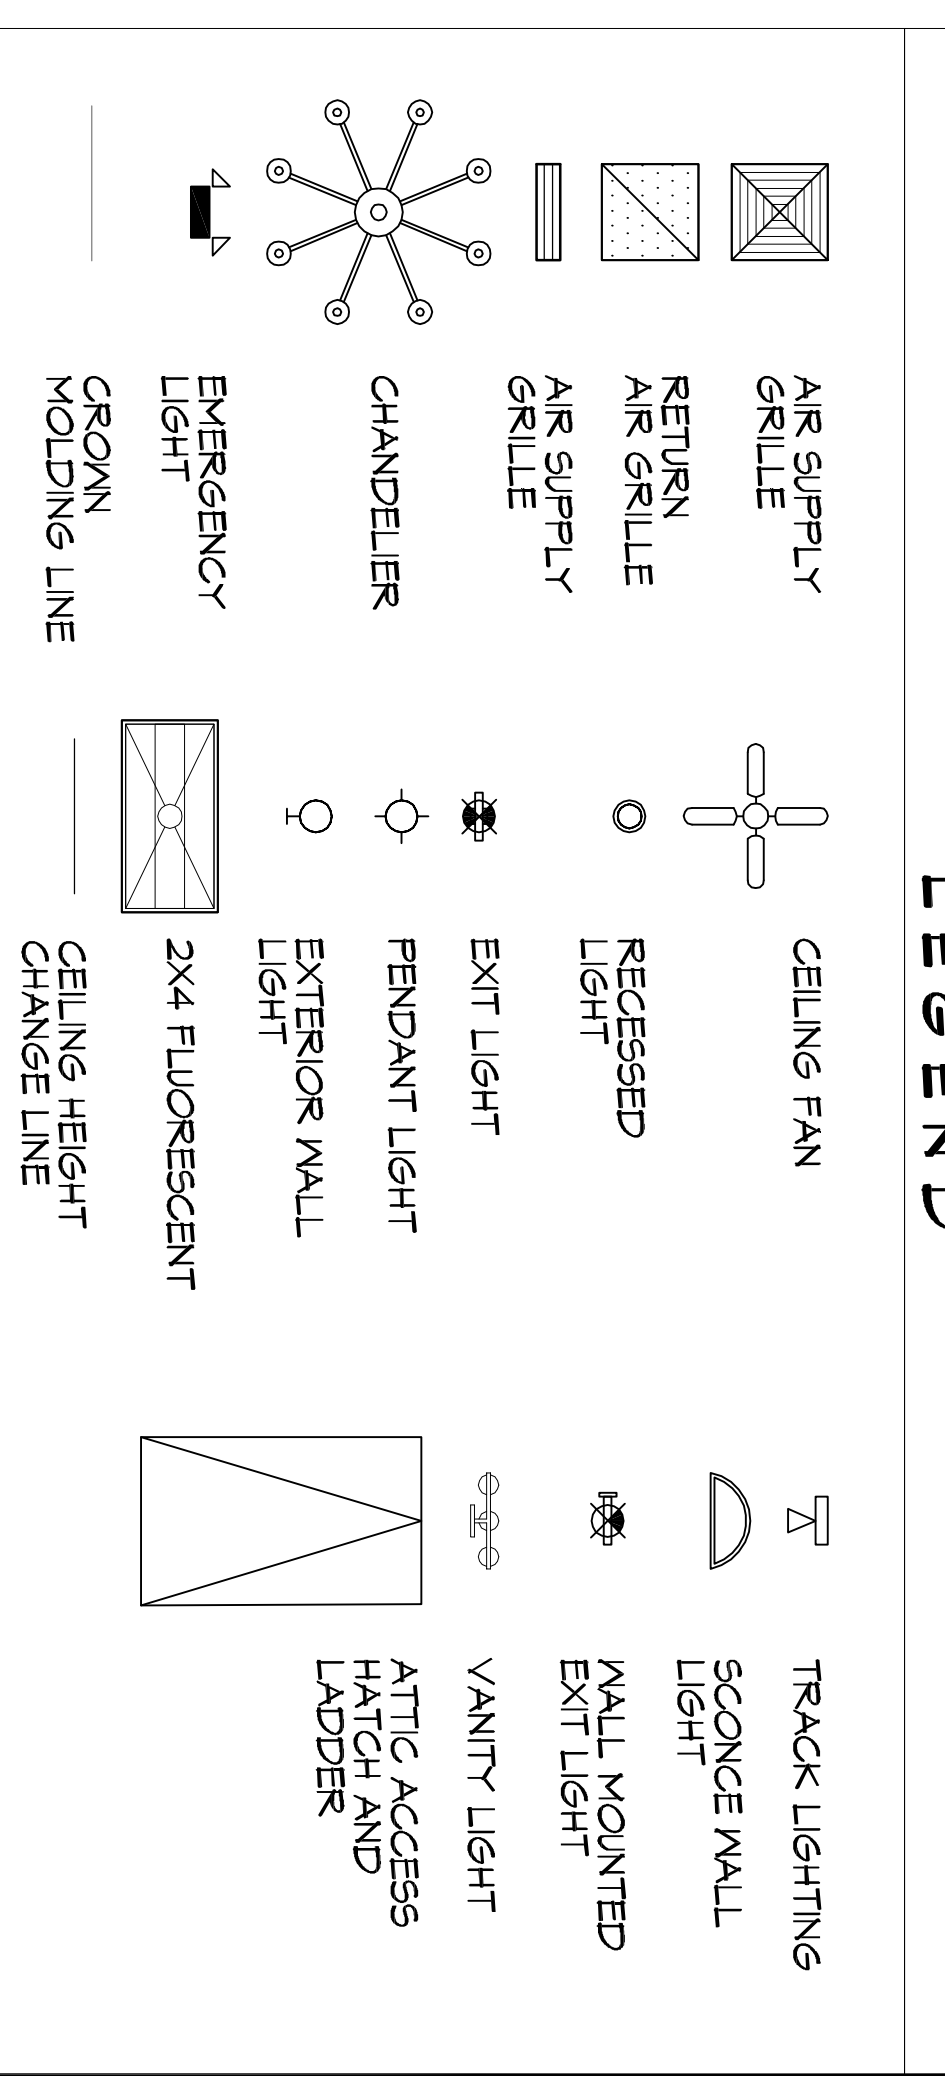


REFLECTED CEILING PLAN
SCALE: 1/8"=1'-0"

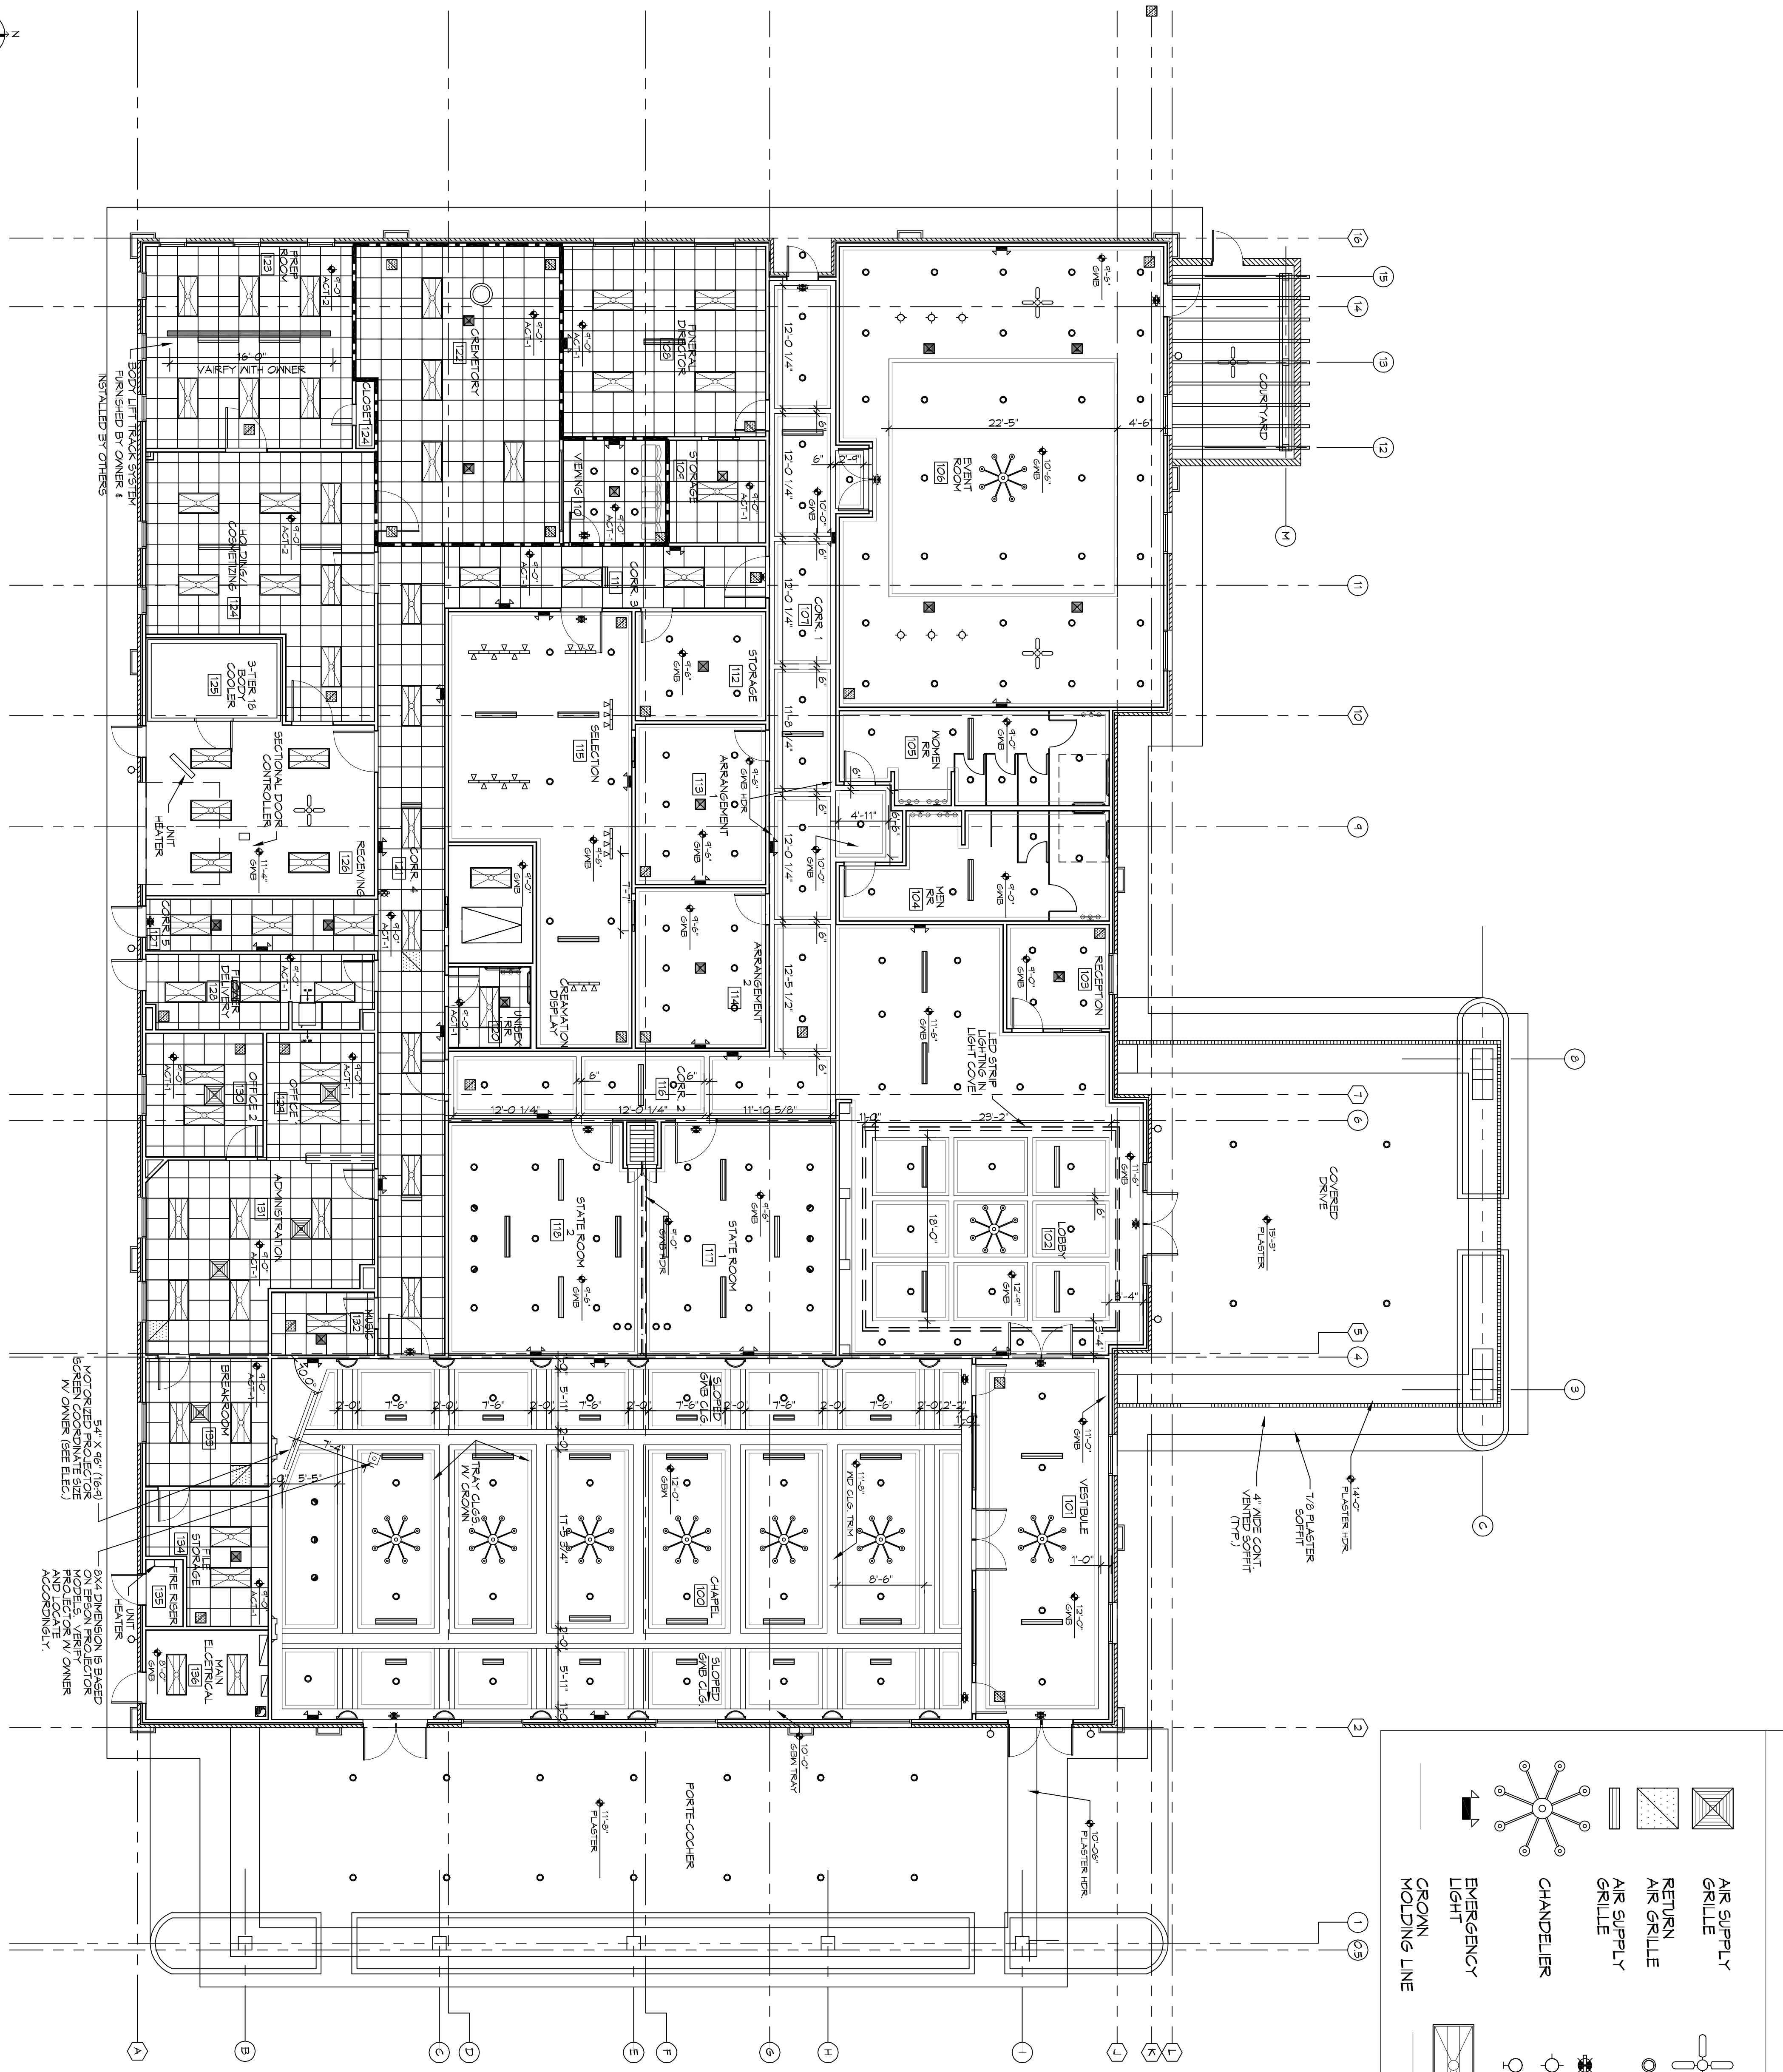

5'-4" X 9'-6" (16'-4")
VARIABLE COMPACT SIZE
TV OWNER (SEE ELEC.)

6'-4" DIMENSION IS BASED
ON SCREEN COMPACT SIZE
PROJECTOR TV OWNER
ACCESSORIES.

SHEET TITLE:
**LA W I S S I P P I
Z O N E**

2081 GAUGE BLVD E
SLIDELL, LA 70461

JOB No: 2360 DATE: 04-19-2018

DRAWN BY: JAG/M checked BY: KD

The above drawings and specifications, designs and arrangements represented hereby are
our work and shall remain the property of Dammon Engineering, Inc. and shall not be used for
any other project without our written consent. We warrant that the drawings and specifications
are in accordance with the contract documents for the project. Dammon Engineering, Inc. shall
not be responsible for any errors or omissions in these drawings and specifications.

#	DESCRIPTION	DATE

DAMMON
ENGINEERING, INC.
LOUISIANA & MISSISSIPPI

Chief Engineer: Brian Mistich, PE
554 Old Spanish Trail
Slidell, LA 70458

www.dammonengineering.com
info@dammonengineering.com
PH: 985.649.5832

SHEET No: **A102**