

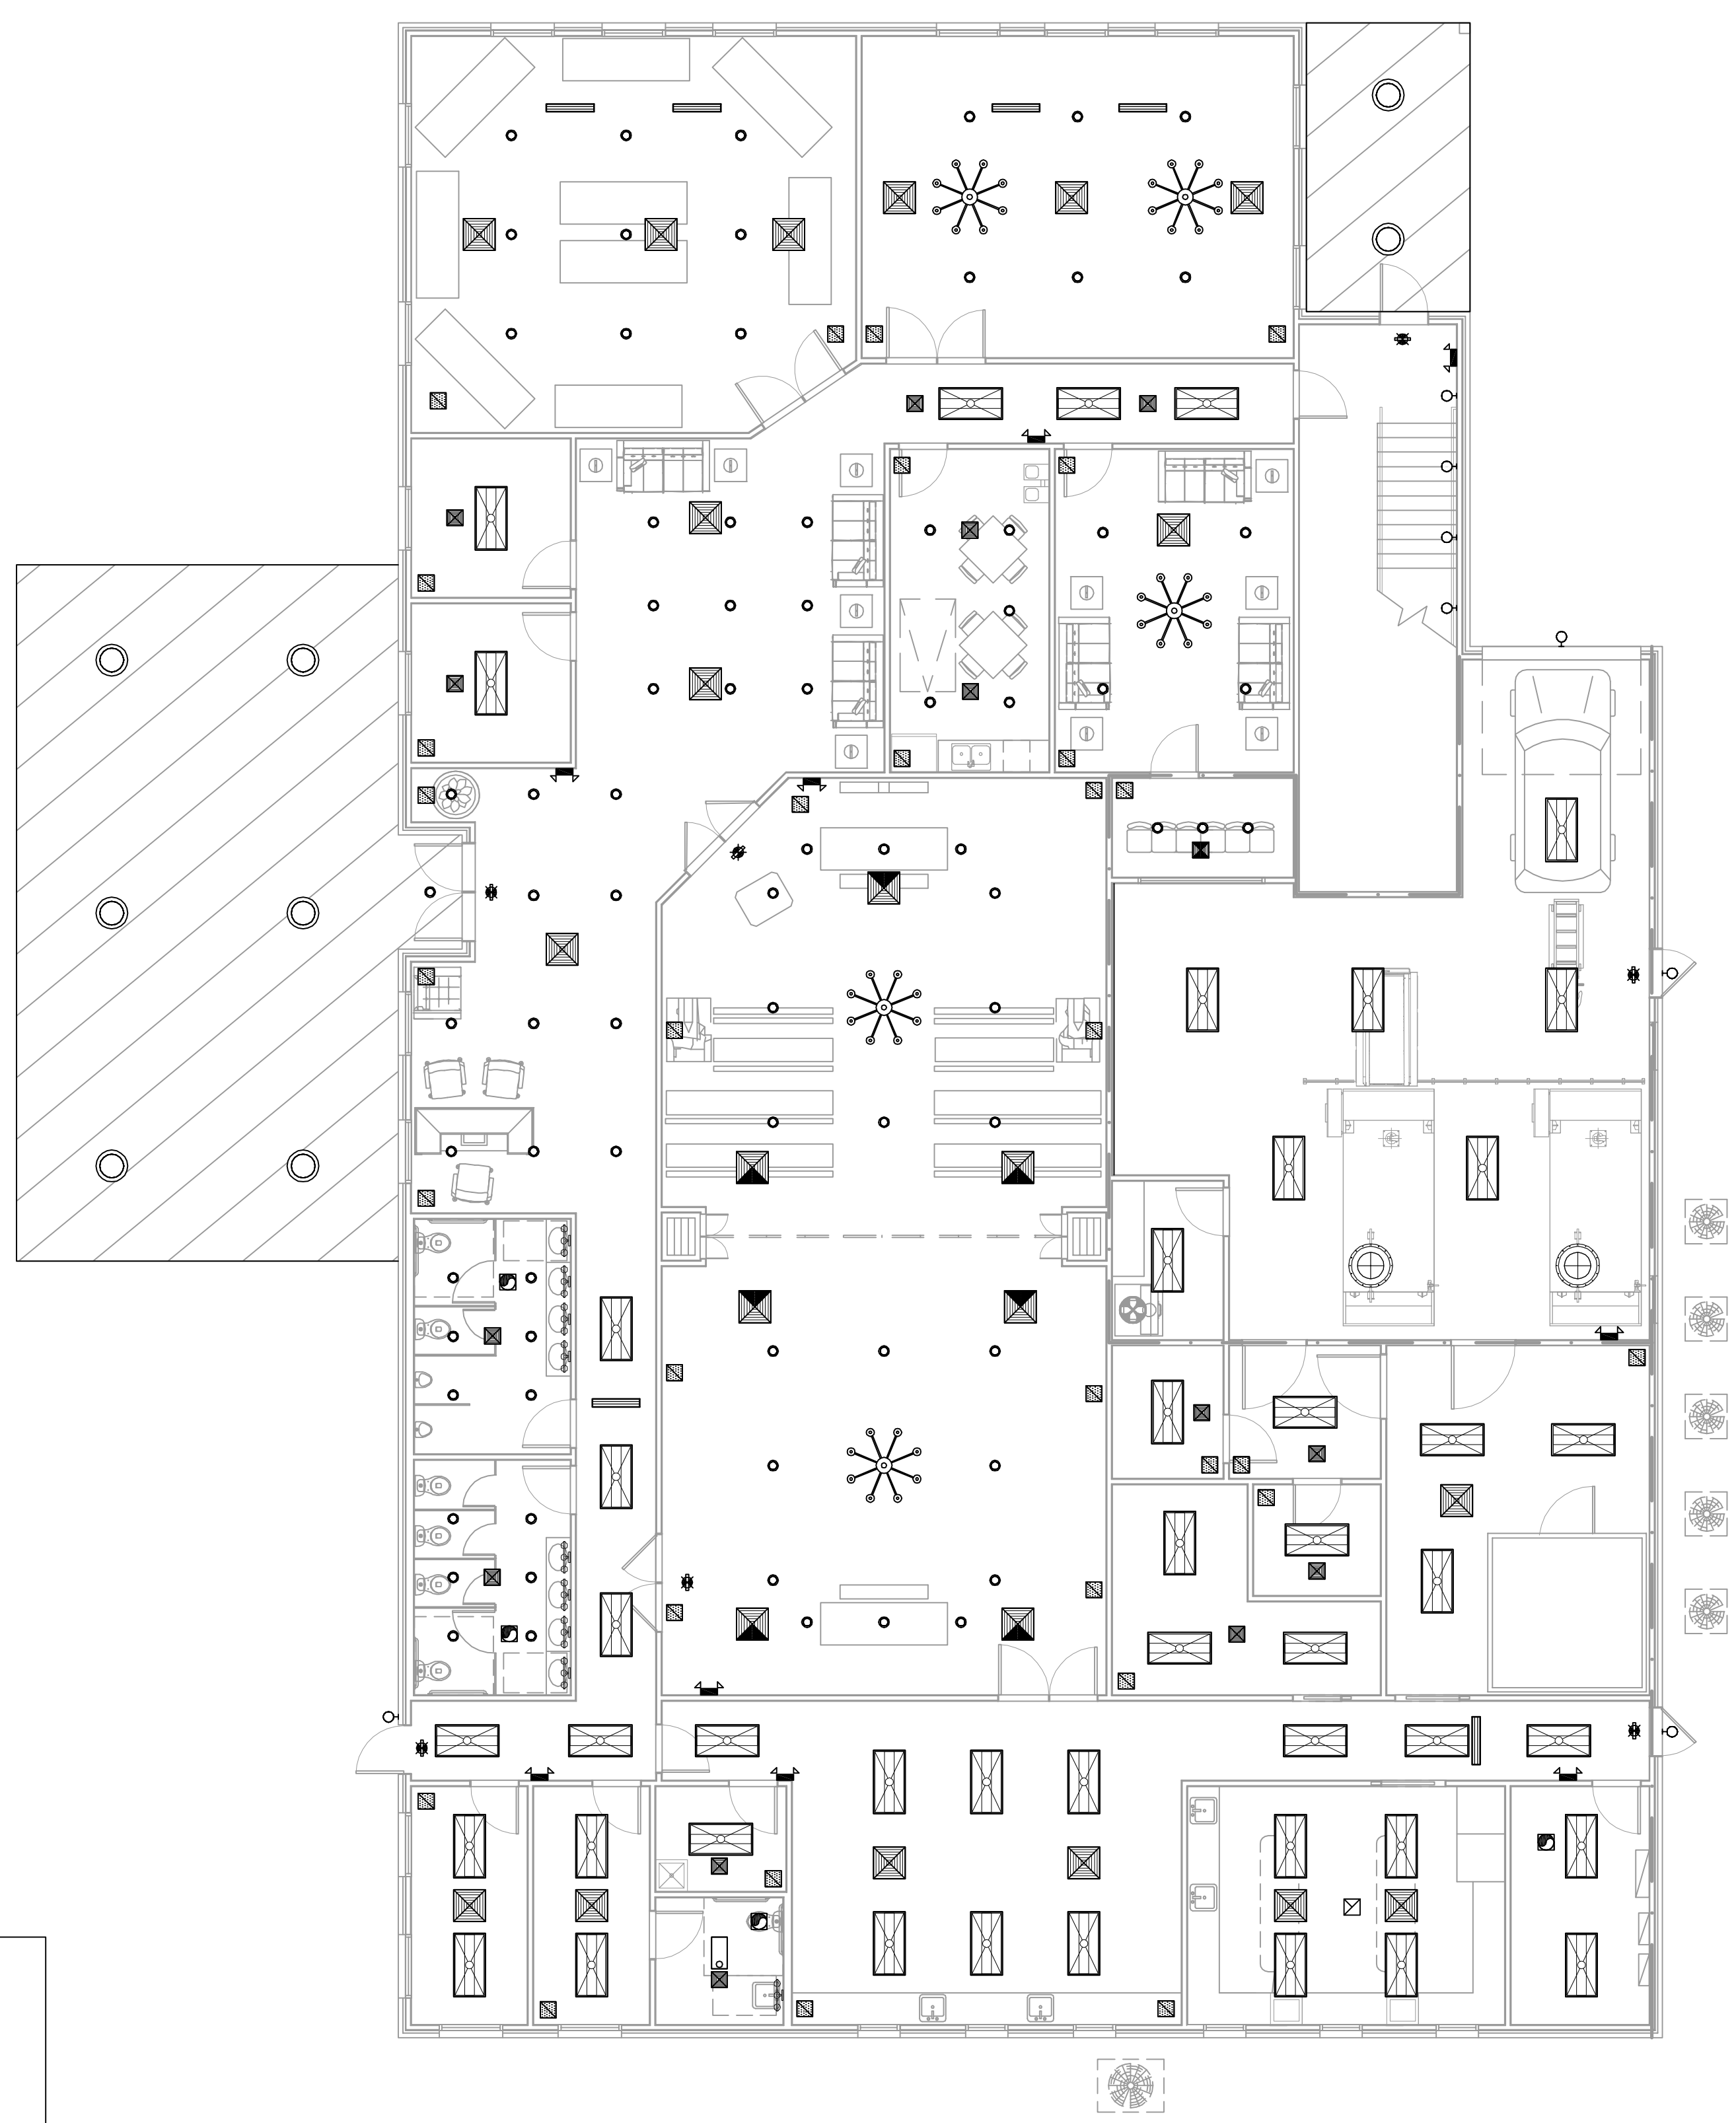
 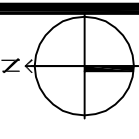


14 REFLECTED CEILING PLAN FIRST FLOOR PLAN
SCALE: 1/8"=1'-0"

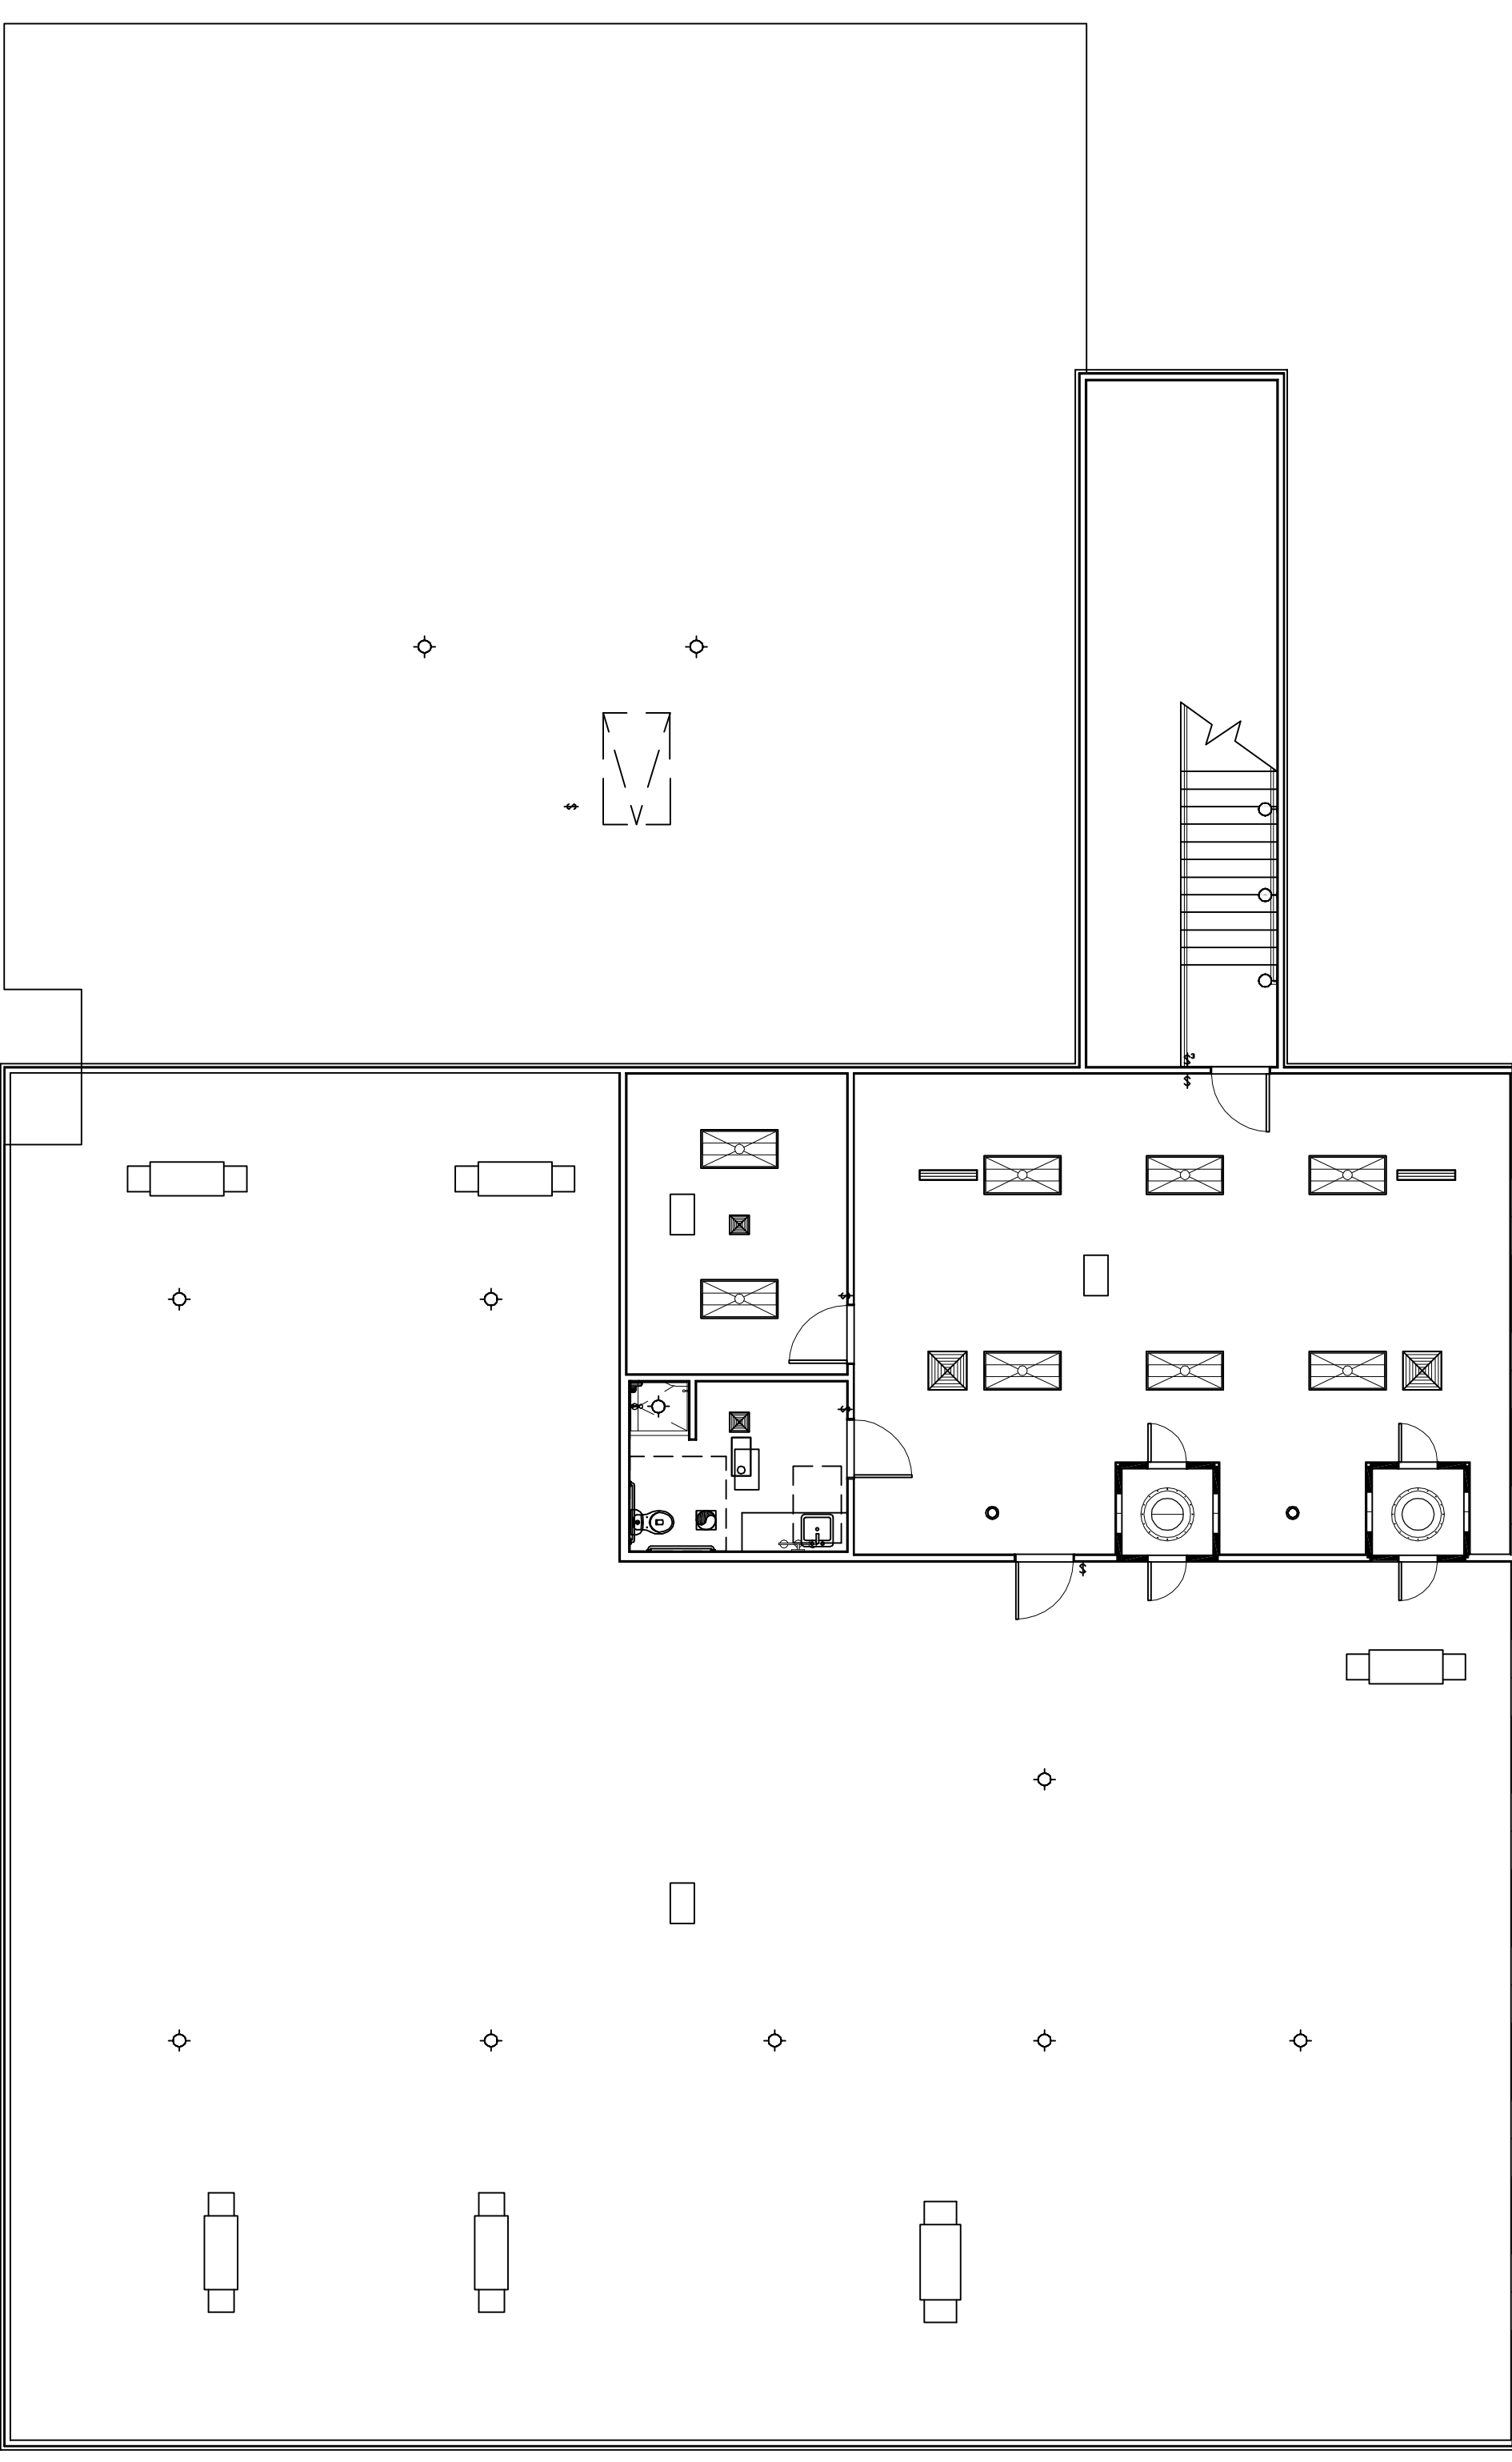

15 REFLECTED CEILING PLAN SECOND FLOOR PLAN
SCALE: 1/8"=1'-0"



LEGEND

	ATTIC ACCESS HATCH AND LADDER		EXHAUST FAN		VANITY LIGHT
	SUPPLY AIR GRILLE		CREMATORY STACK		CHANDELER
	RETURN AIR GRILLE		RECESSED LIGHT		EMERGENCY LIGHT
	AIR SUPPLY GRILLE		EXIT LIGHT		
			WALL SCONCE LIGHT		
			2x4 FLUORESCENT		

NEA FUNERAL HOME
BOYD FAMILY FUNERAL HOME
 4800 DOWNMAN ROAD
 NEW ORLEANS, LA
 JOB No: 2396 DATE: 09-03-2019
 DRAWN BY: JAG/MW CHECKED BY: CKD

SHEET TITLE:
 REFLECTED CEILING PLANS
 DRAWING NUMBER:

A104

SHEET No: 11 of # 23

REVISIONS		
#	DESCRIPTION	DATE

DAMMON ENGINEERING, INC.
 LOUISIANA & MISSISSIPPI
 Chief Engineer: Brian Mistic, PE
 554 Old Spanish Trail
 Slidell, LA 70458
 www.dammonengineering.com
 info@dammonengineering.com
 Ph: 985.649.5832