


FILE NAME: J:\Projects\10-Floor Plan\10-Floor Plan.dwg
 PLOT DATE: 07-15-21
 PLOT SCALE: 3/16"=1'-0"

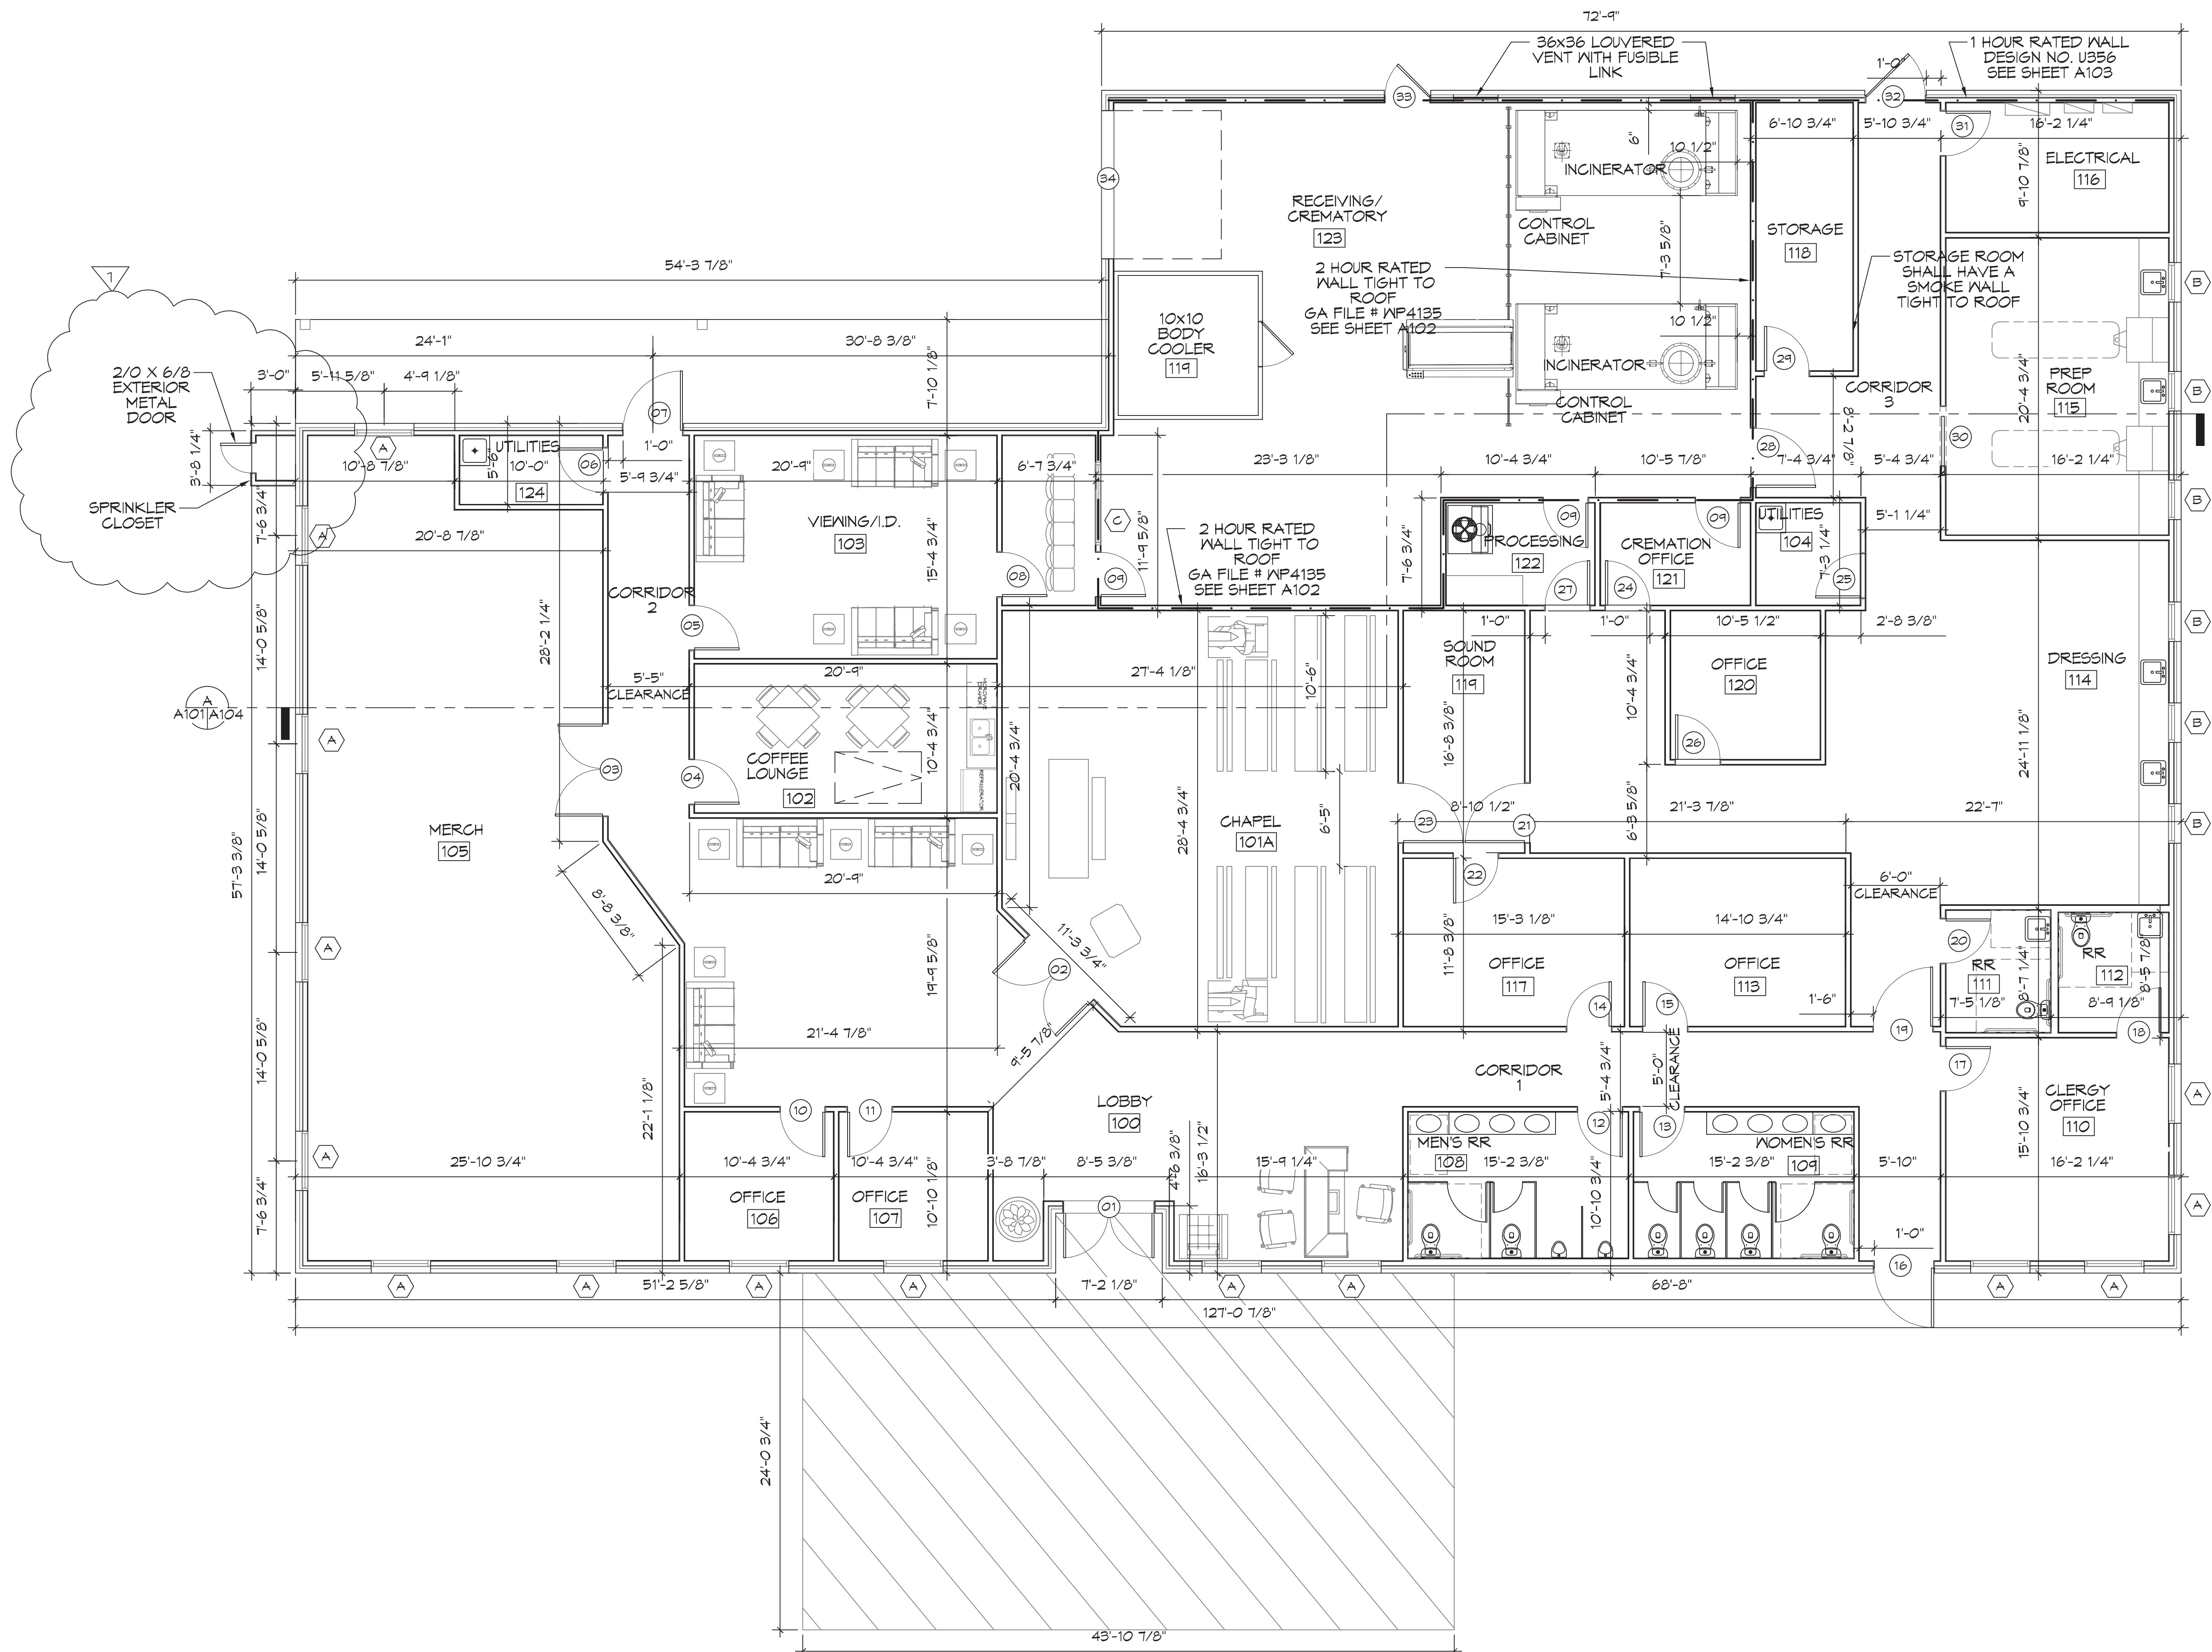

10 FLOOR PLAN
 SCALE: 3/16"=1'-0"

DAMMON ENGINEERING, INC.
 LOUISIANA & MISSISSIPPI
 Chief Engineer: Brian Abtch, PE
 554 Old Spanish Trail
 Slidell, LA 70488
 www.dammonengineering.com
 info@dammonengineering.com
 PH: 985.649.8932

REVISIONS	DATE
# DESCRIPTION	07-15-21
1 ADDED SPRINKLER CLOSET	



NEW FUNERAL HOME
BOYER FAMILIOME
 4800 DOWNMAN ROAD
 NEW ORLEANS, LA
 JOB No: 2546 | DATE: 05-05-2021
 DRAWN BY: CSD | CHECKED BY: CSD

SHEET TITLE:
FLOOR PLAN
 DRAWING NUMBER:
A101
 SHEET No: 6 of 1