


FILE NAME: A:\Projects\10Floor\10Floor.dwg - Plot: 10Floor.dwg - Plot Date: 07/19/21

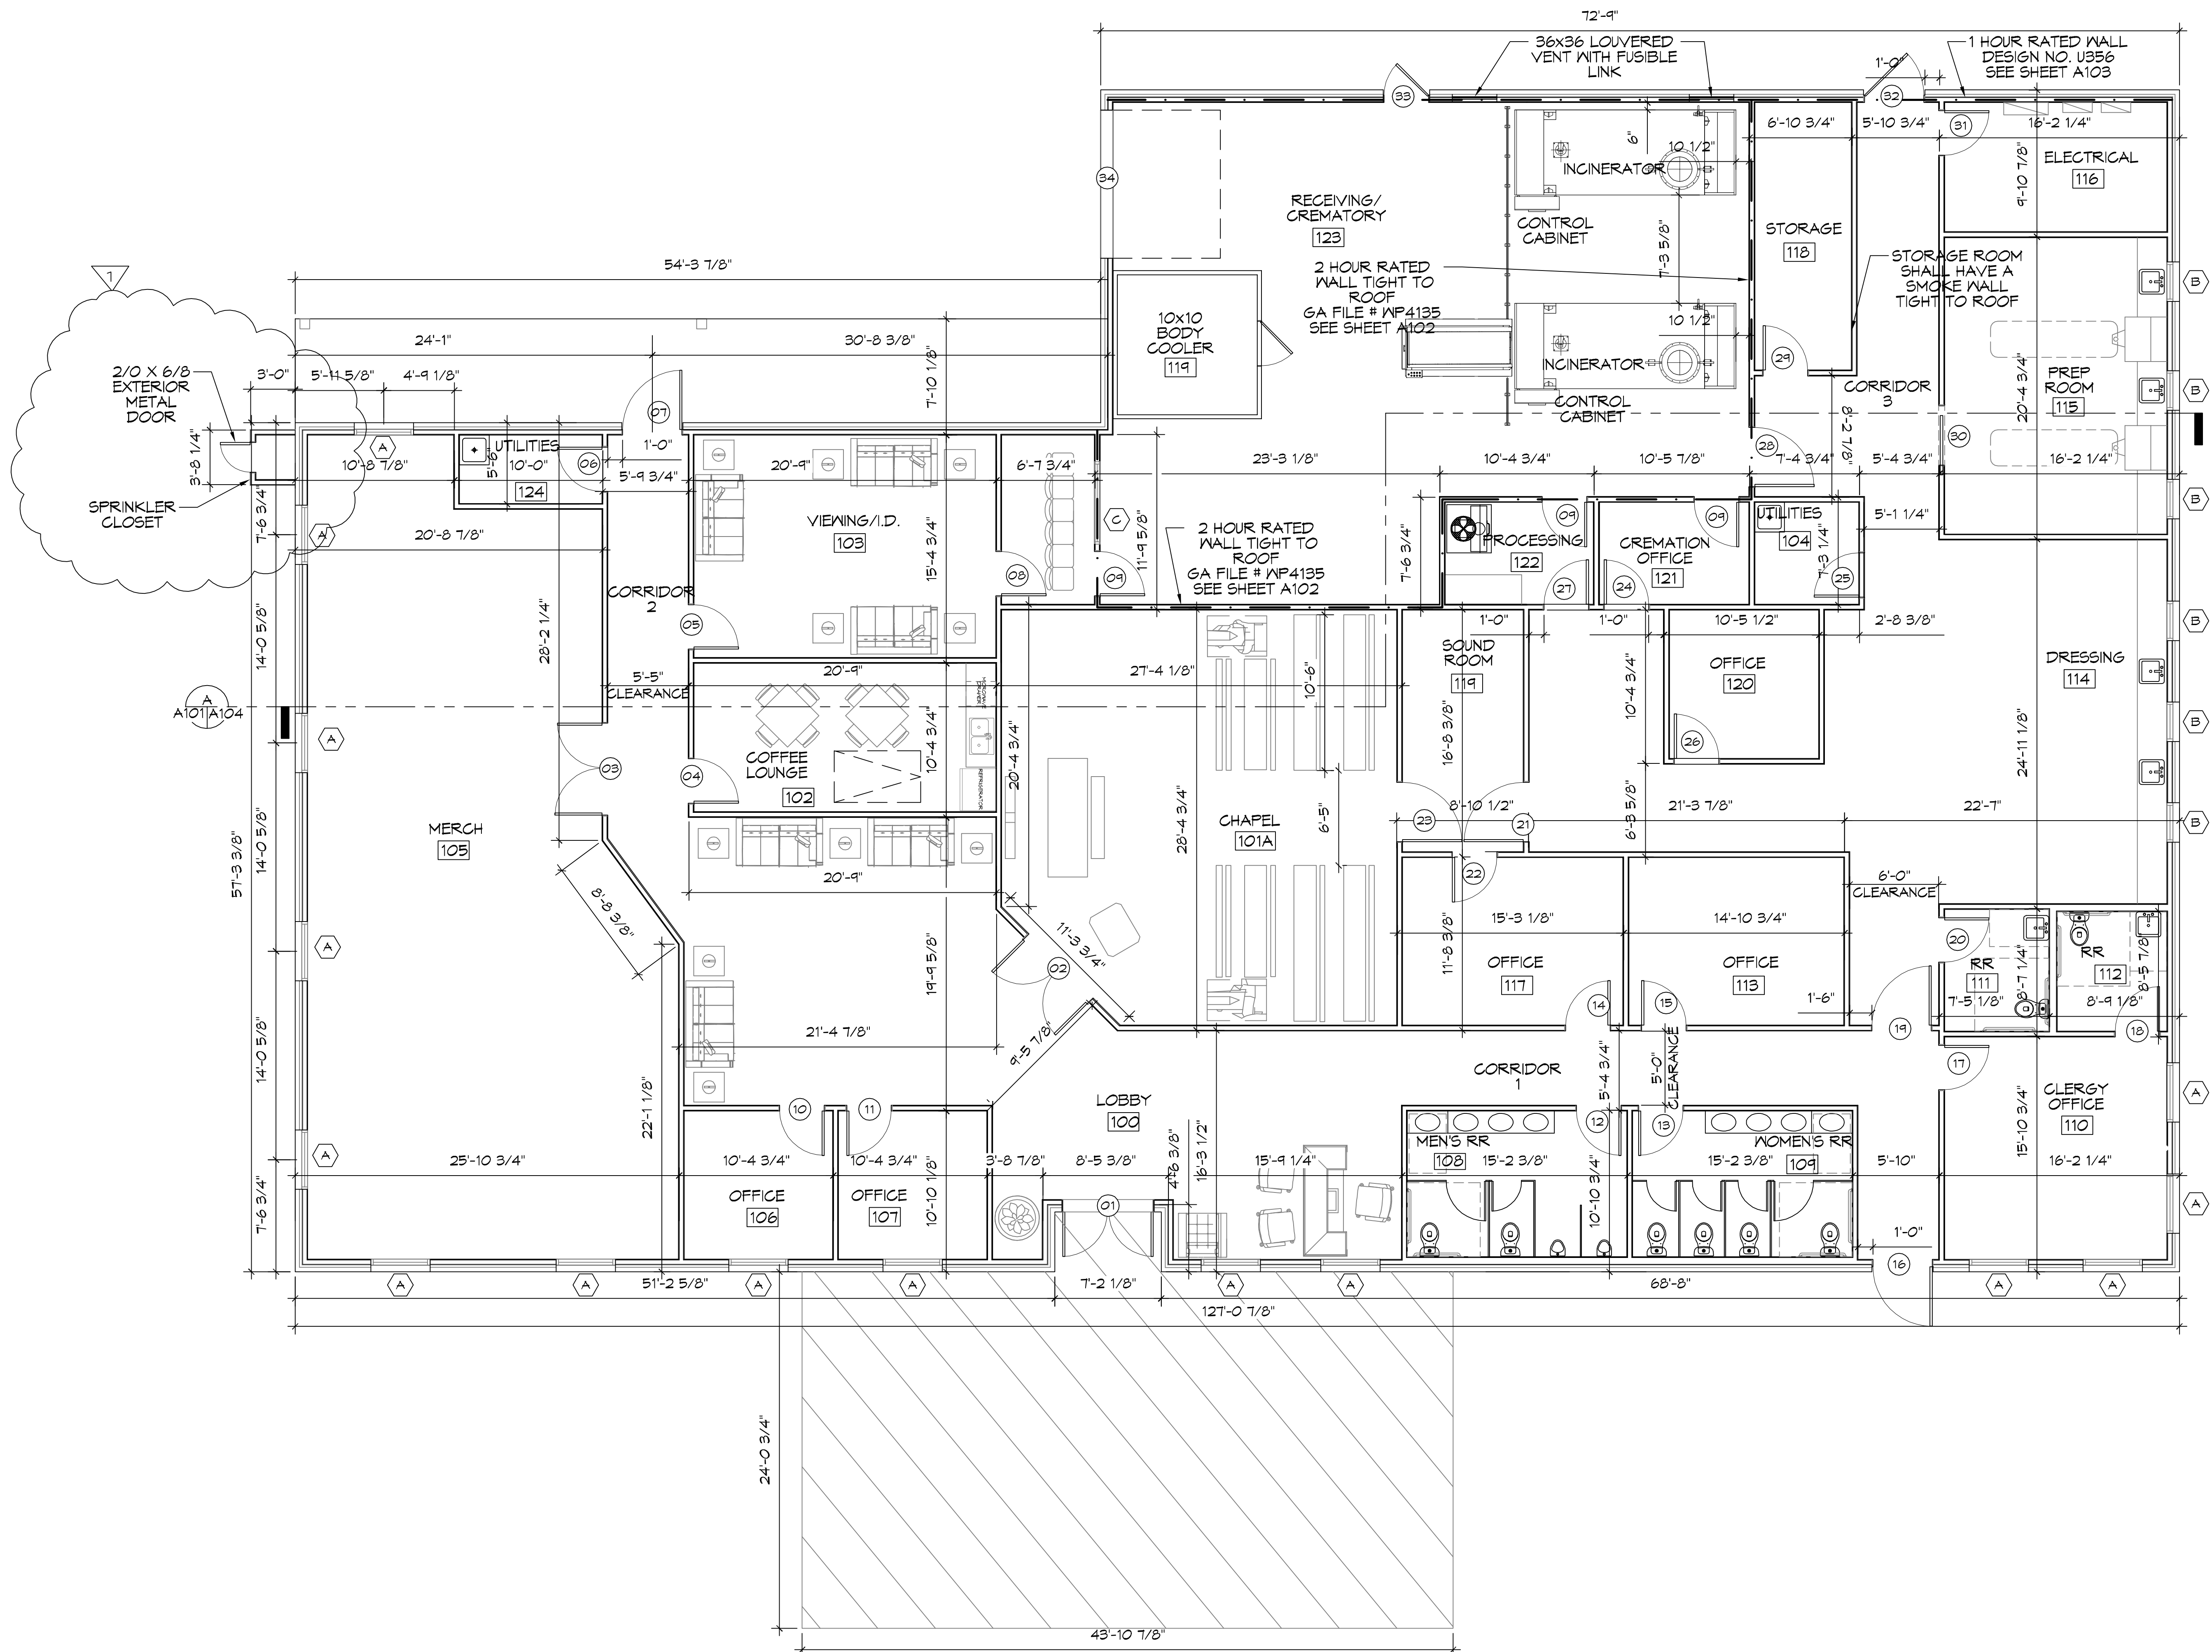


**10 FLOOR PLAN**  
SCALE: 3/16"=1'-0"

**DAMMON**  
ENGINEERING, INC.  
LOUISIANA & MISSISSIPPI

Chief Engineer: Brian Metchick, PE  
594 Old Spanish Trail  
Slidell, LA 70688  
www.dammonengineering.com  
info@dammonengineering.com  
PH: 985.649.5832

REVISIONS	DATE
# DESCRIPTION	07-19-21
1. ADDED SPRINKLER CLOSET	

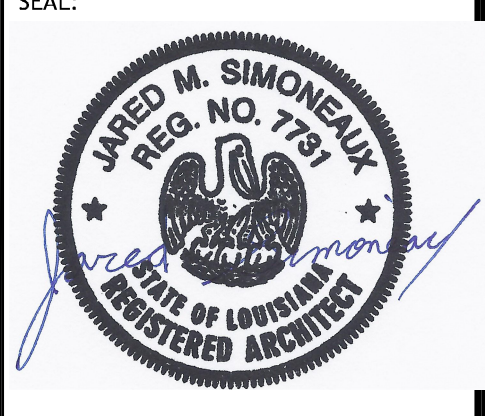

NEW FUNERAL HOME  
**BONER FAMILIOME**  
4800 DOWNMAN ROAD  
NEW ORLEANS, LA

JOB NO: 2516 | DATE: 05-05-2021  
DRAWN BY: CKD | CHECKED BY: CKD

SHEET TITLE:  
FLOOR PLAN

DRAWING NUMBER:  
**A101**

SHEET NO: 6 of 1