



FILE NAME: C:\Users\adam\OneDrive\Desktop\Monkey\Monkey.dwg DATE: 08-22-2024 10:52:38 AM

SITE LIGHTING

EXTERIOR LIGHTING SHALL BE SHADED OR INWARDLY DIRECTED IN SUCH A MANNER SO THAT NO DIRECT LIGHTING OR GLARE BE CAST BEYOND THE PROPERTY LINE. THE INTENSITY OF SUCH LIGHTING SHALL NOT EXCEED ONE FOOT CANDLE AS MEASURED AT THE ABUTTING PROPERTY LINE.

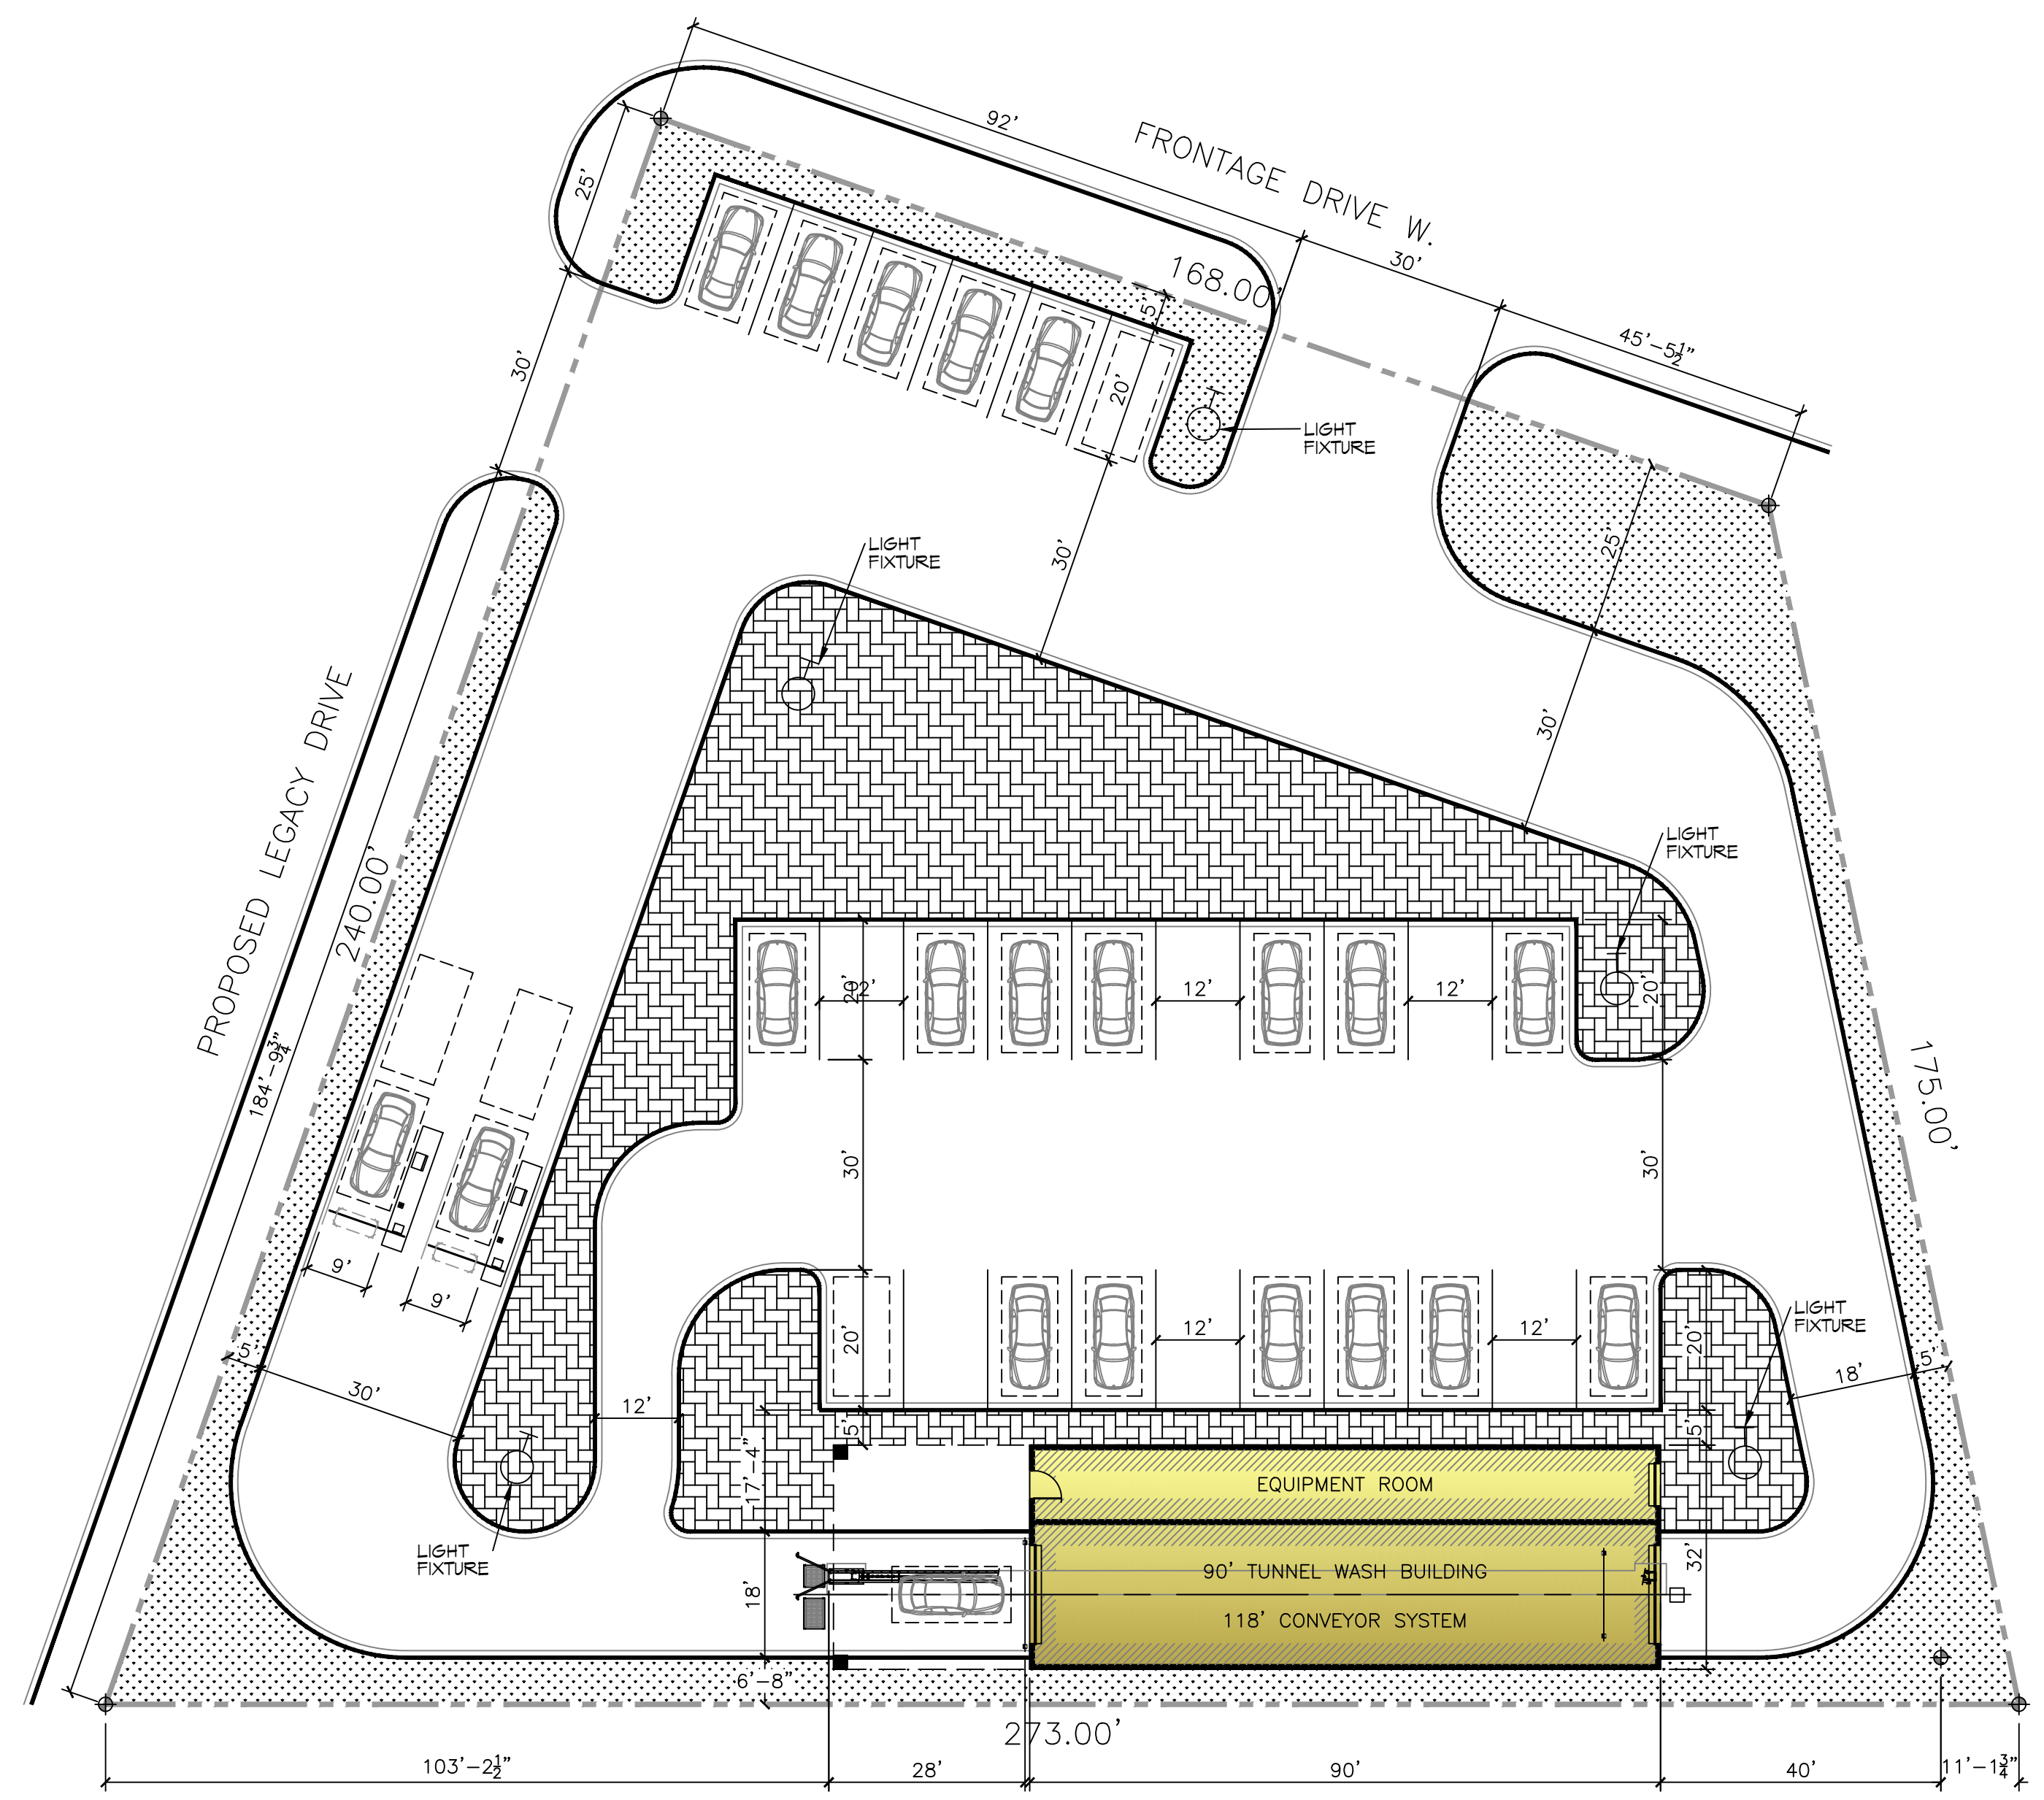

17 SITE LIGHTING & POWER PLAN
SCALE: 1" = 20'-0"

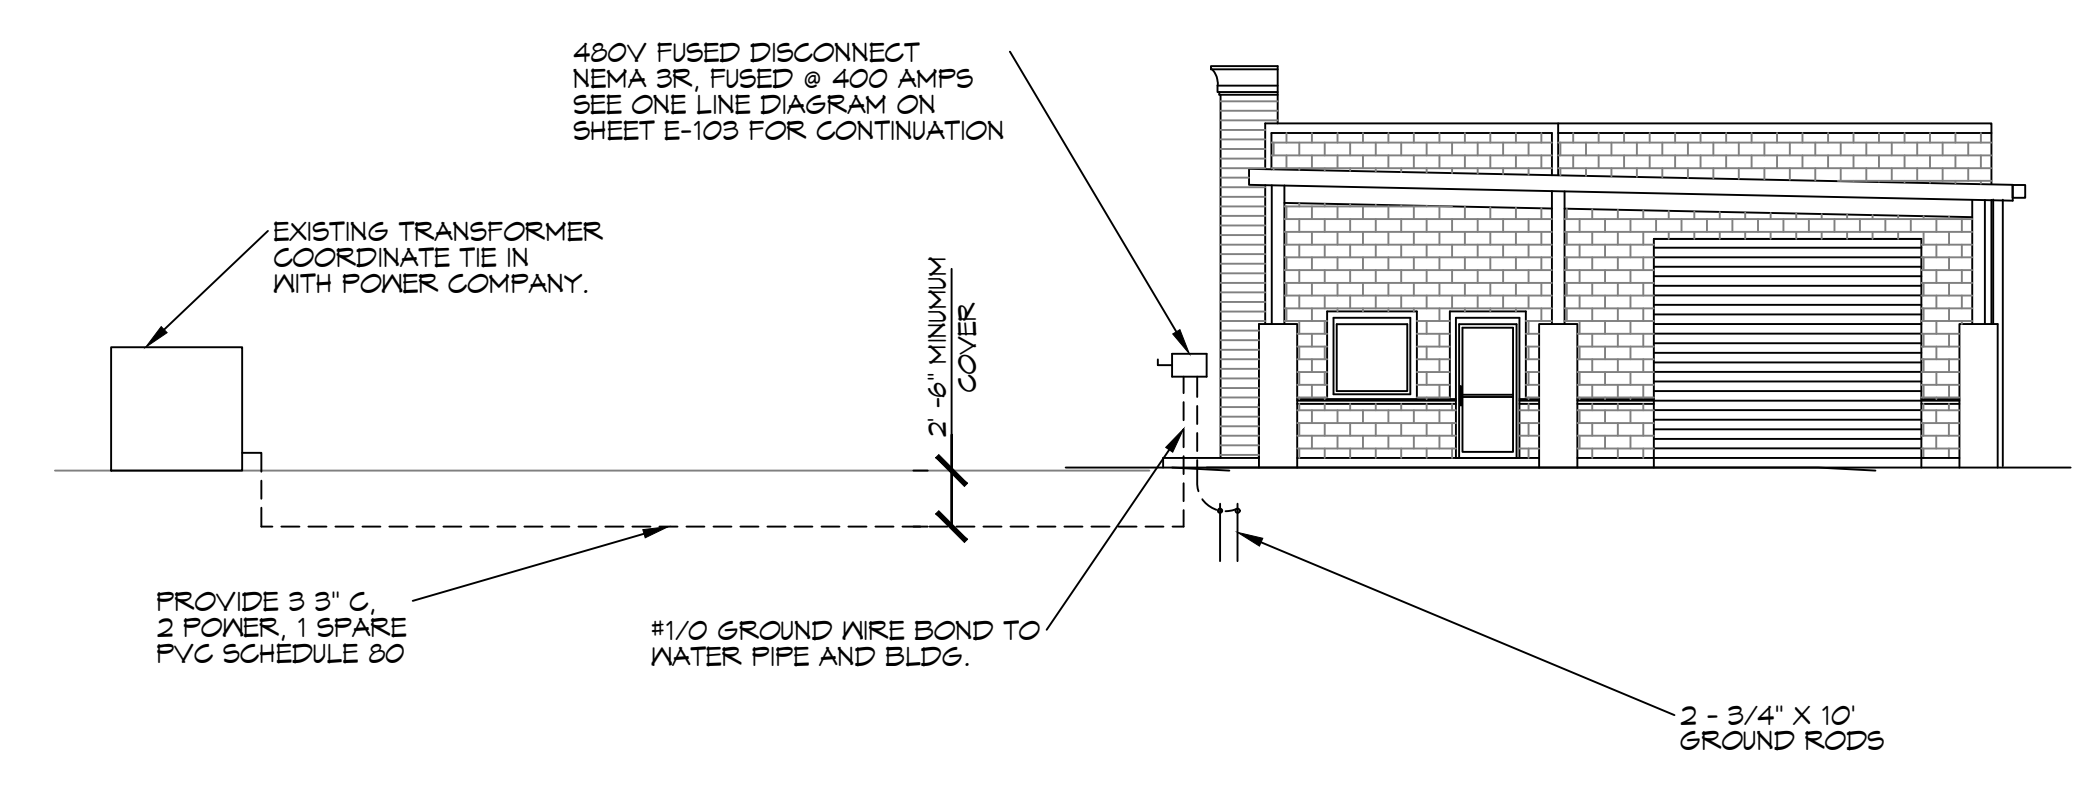

18 RISER DIAGRAM
SCALE: N. T. S.

DAMMON

ENGINEERING, INC.

LOUISIANA & MISSISSIPPI

www.dammonengineering.com
info@dammonengineering.com
Chief Engineer: Brian Mistich, PE
554 Old Spanish Trail
Slidell, LA 70468
PH: 985.649.3532

| # | DESCRIPTION | DATE |
|---|-------------|------|
| | | |
| | | |
A NEW CARWASH FOR
CHERKASH MONKEY
CARWASH

JOB No: 2024 | DATE: 08-22-2024 | DRAWN BY: BAW | CHECKED BY: CKD

SHEET TITLE:
SITE LIGHTING & POWER PLAN

DRAWING NUMBER:
E101

SHEET No: 8 of 10