


FILE NAME: C:\Users\dammon\OneDrive\Documents\2022\09-28-22\09-28-22\09-28-22.dwg

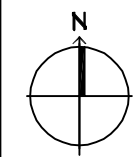


1 SITE PLAN
SCALE: 1" = 10'-0"

OVERALL SITE PLAN

2 PARTIAL PLAN
SCALE: 1" = 10'-0"

SIDE OF BLDG

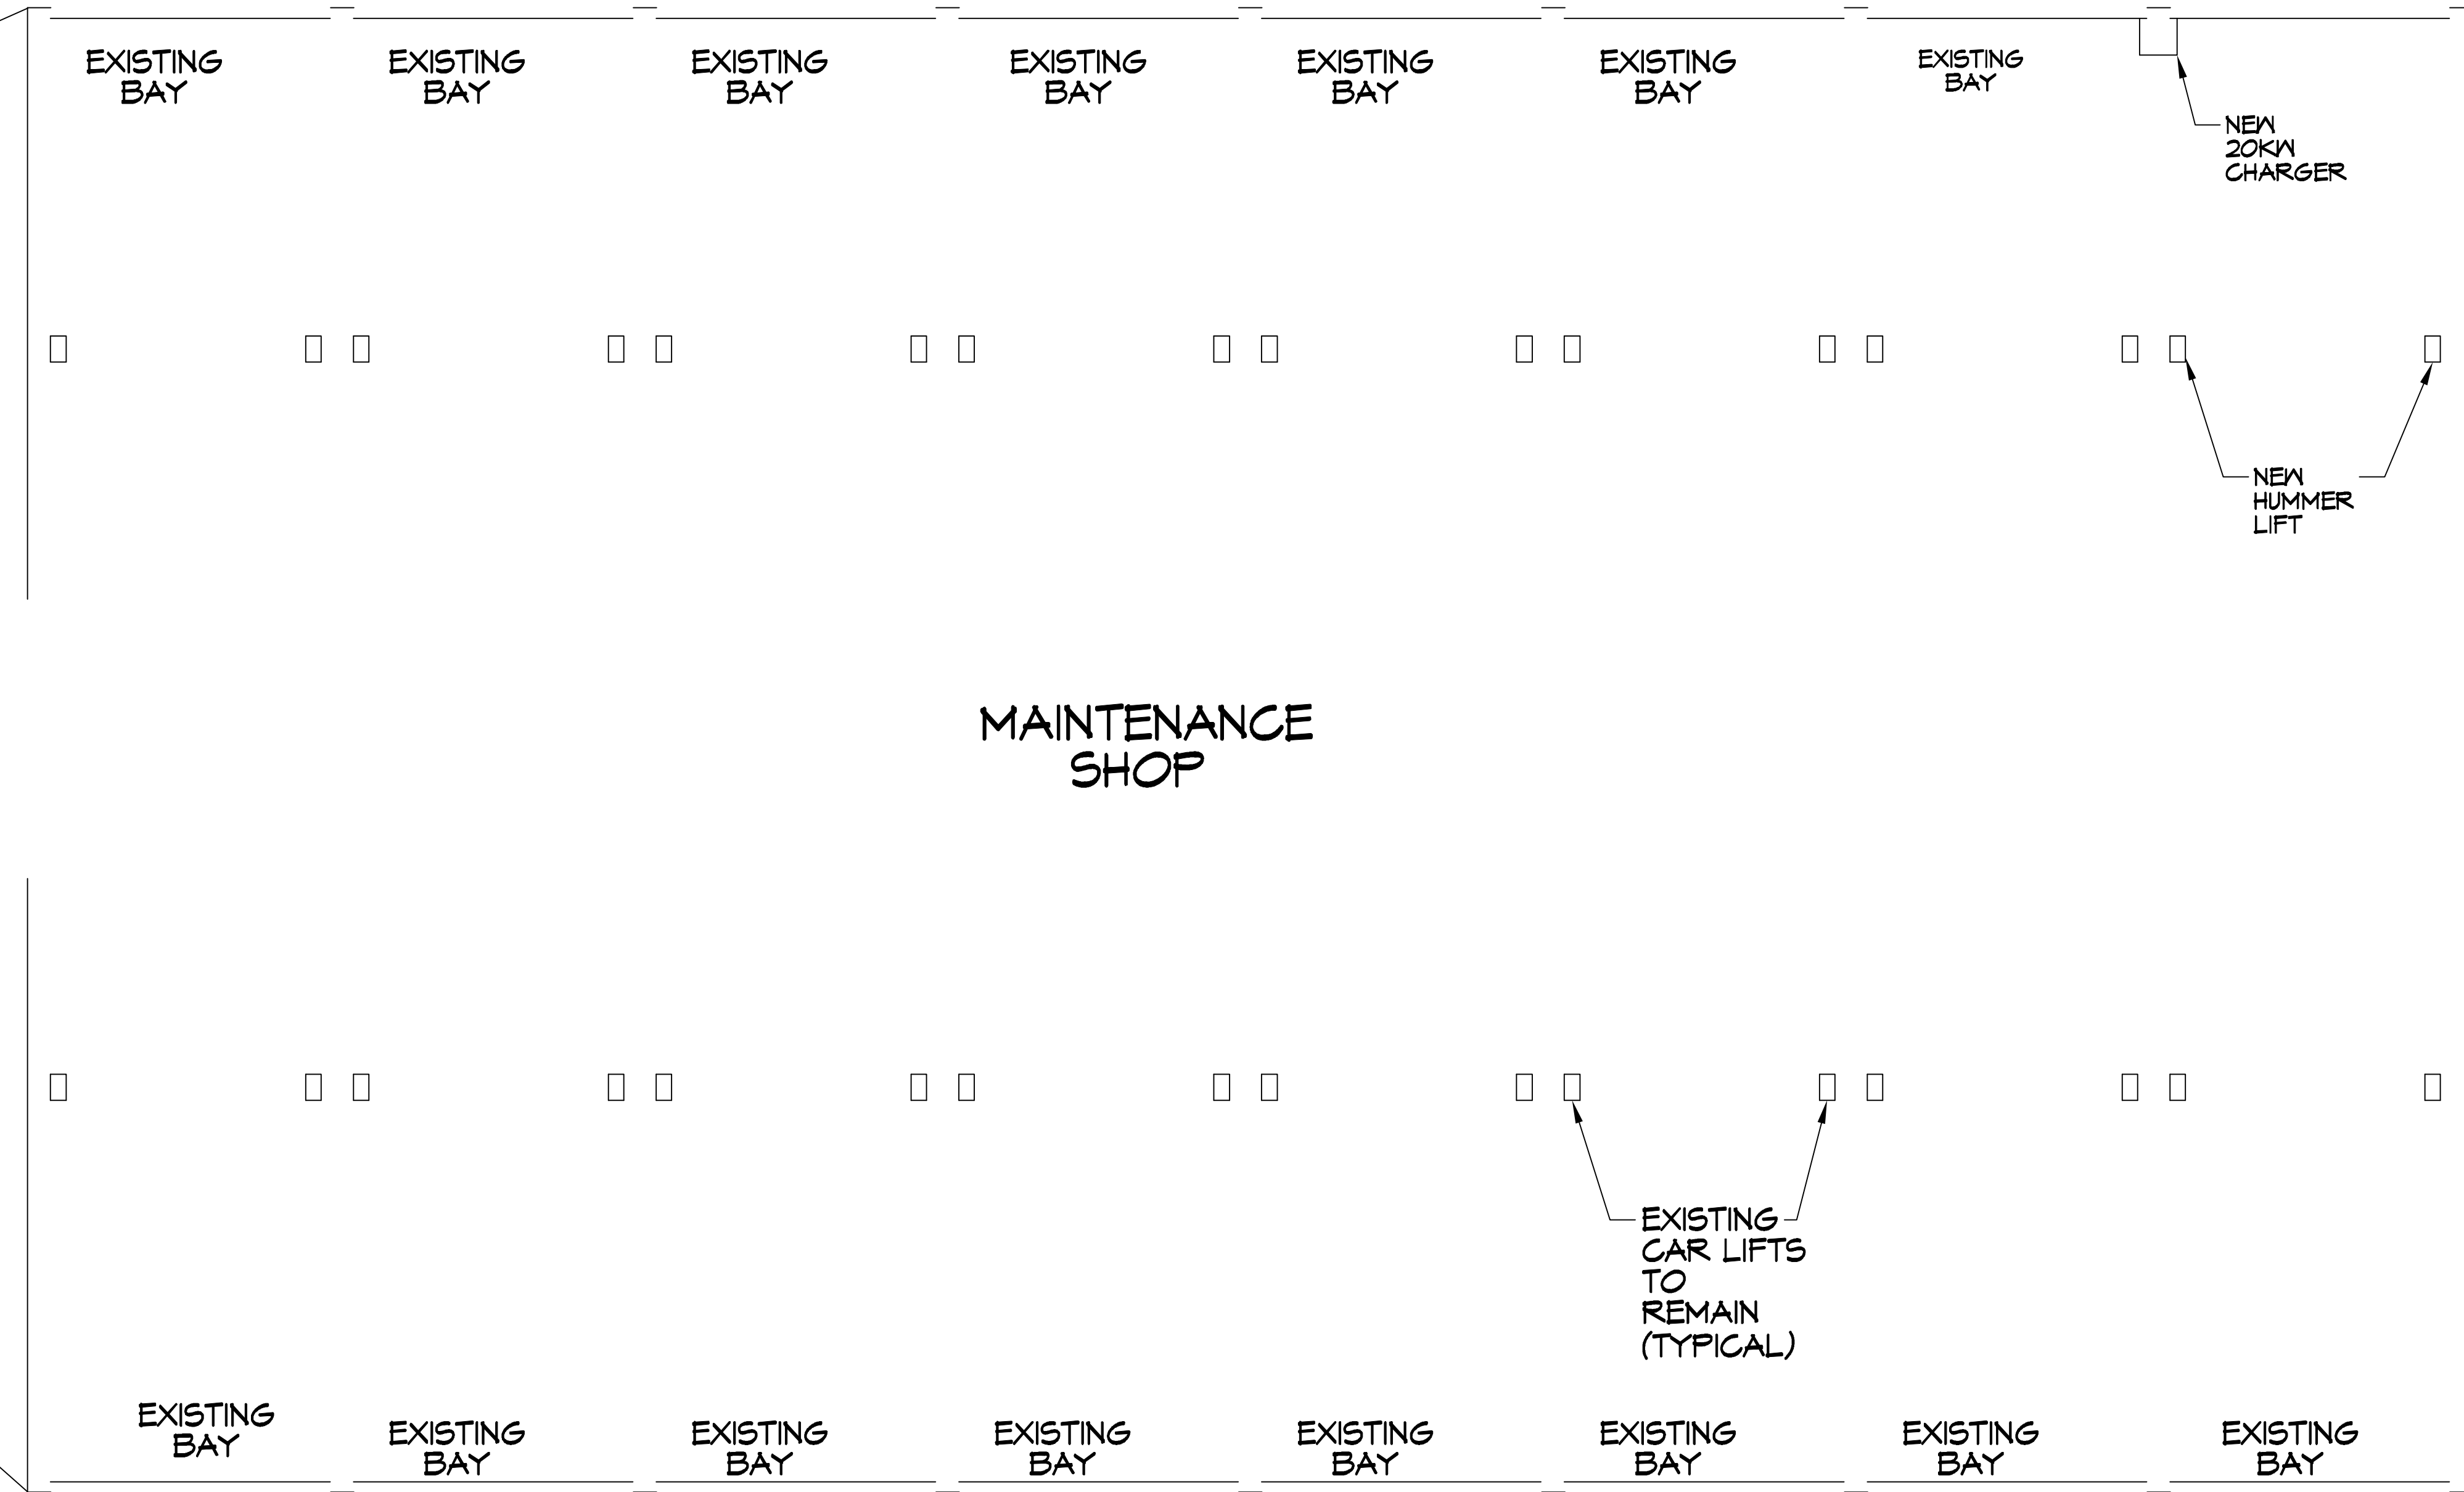


3 PARTIAL PLAN
SCALE: 1" = 10'-0"

MAINTENANCE BLDG

DAMMON
ENGINEERING, INC.
LOUISIANA & MISSISSIPPI

Chief Engineer: Brian Mistic, PE
554 Old Spanish Trail
Slidell, LA 70458
www.dammonengineering.com
info@dammonengineering.com
PH: 985.649.5832

#	DESCRIPTION	DATE
1		

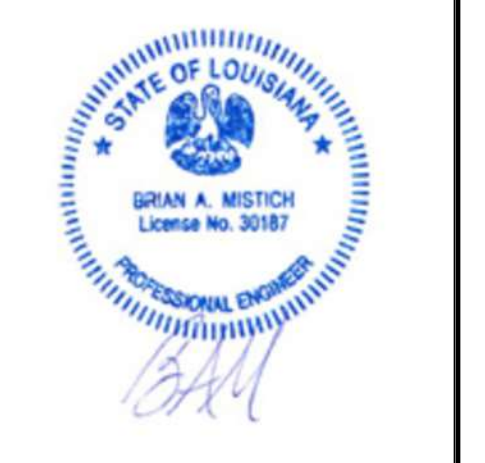

NEW CHARGING STATIONS

LEGACY BUICK GMC

9611 LAPALCO
MARKET LA, 70098
JOB No: 2022
DATE: 09-28-22
DRAWN BY: CKD
CHECKED BY: BAY

SHEET TITLE:
SITE CHARGING PLAN

DRAWING NUMBER:
C101