



MECHANICAL / ELECTRICAL SYMBOLS/LEGEND	
	CEILING MOUNTED INCANDESCENT OR FLUORESCENT. SEE SPECIFICATIONS.
	WALL MOUNTED INCANDESCENT OR FLUORESCENT. SEE SPECIFICATIONS.
	RECESSED CAN INCANDESCENT OR FLUORESCENT. SEE SPECIFICATIONS.
	DAMP LOCATION RECESSED CAN INCANDESCENT OR FLUORESCENT. SEE SPECS.
	RECESSED CAN INCANDESCENT OR FLUORESCENT, SEE SPECIFICATIONS. RECESSED CAN INCANDESCENT OR FLUORESCENT, SEE SPECIFICATIONS. RECESSED CAN INCANDESCENT OR FLUORESCENT, SEE SPECIFICATIONS.
	TELEPHONE and DATA OUTLET CAT 5 ENHANCED OR FASTER
	2' X 4' RECESSED FLUORESCENT LIGHT (4 LAMP) SEE SPECIFICATIONS.
	1' X 4' PENDANT FLUORESCENT LIGHT (2 LAMP) SEE SPECIFICATIONS.
	CEILING FAN
	HEATER/VENT LIGHT (VENT THROUGH ROOF)
	WIRE OR CIRCUIT
	CABLE TV OUTLET MOUNTED 96" ABOVE FINISH FLOOR
	DOORBELL
	DOORBELL CHIME
	JUNCTION BOX
	SINGLE POLE LIGHT SWITCH
	3 WAY LIGHT SWITCH
	4 WAY LIGHT SWITCH
	LIGHT SWITCH WITH DIMMER
	DUPLEX OUTLET, AC DENOTES 4" ABOVE COUNTER TOP, TYPICAL
	220 VOLT OUTLET
	GROUND FAULT INTERRUPT AT ALL WET LOCATIONS
	FLOOD LIGHT
	DISCONNECT SWITCH
	SMOKE DETECTOR
	ELECTRICAL PANEL
	SUPPLY AIR GRILLE
	EXTERIOR HOSE BIB
	WALL MOUNT PROGRAMMABLE SETBACK THERMOSTAT @ 92" AFF
	UNDERCABINET FLUORESCENT TASK LIGHT. SEE SPECIFICATIONS.
	FIRE EXTINGUISHER
	POWER METER
	MAIN ELECTRICAL PANEL
	TELEPHONE PANEL / INTERNET INTERFACE AND ROUTER.
	SECURITY AND FIRE SYSTEM PANEL.
	WATER HEATER
	CARBON MONOXIDE DETECTOR

PLUMBING FIXTURES AND KITCHEN EQUIPMENT


- RANGE / OVEN: FRIGIDARE PROPANE COMPATIBLE. PLG659SEC 36" WIDE STAINLESS STEEL.
- REFRIGERATOR / FREEZER: FRIGIDARE FREEZER: PLF112E5 (6.1 CUFT). REFRIGERATOR: PLR112E5 (6.7 CUFT).
- DISHWASHER: FRIGIDARE 24" WIDE TALL TUB. MODEL NO. FDBB4365FC, STAINLESS STEEL FINISH.
- KITCHEN SINK AND FITTINGS: SINK: ELKAY STAINLESS STEEL: ELUH 3520R UNDERCOUNTER MOUNT. FITTINGS: ELKAY ALLURE 9IDE HANDLE LK6365CR
- GARAGE DISPOSAL: INSINKERATOR 3/4 HP, "ESSENTIAL" SERIES.
- WASHER / DRYER: WHIRLPOOL, STAINLESS STEEL FIN. WASHER: LFW3400SU Whirlpool Duet HT Ultra Capacity Plus. DRYER: WED9400SU Whirlpool Duet Super Capacity Plus.

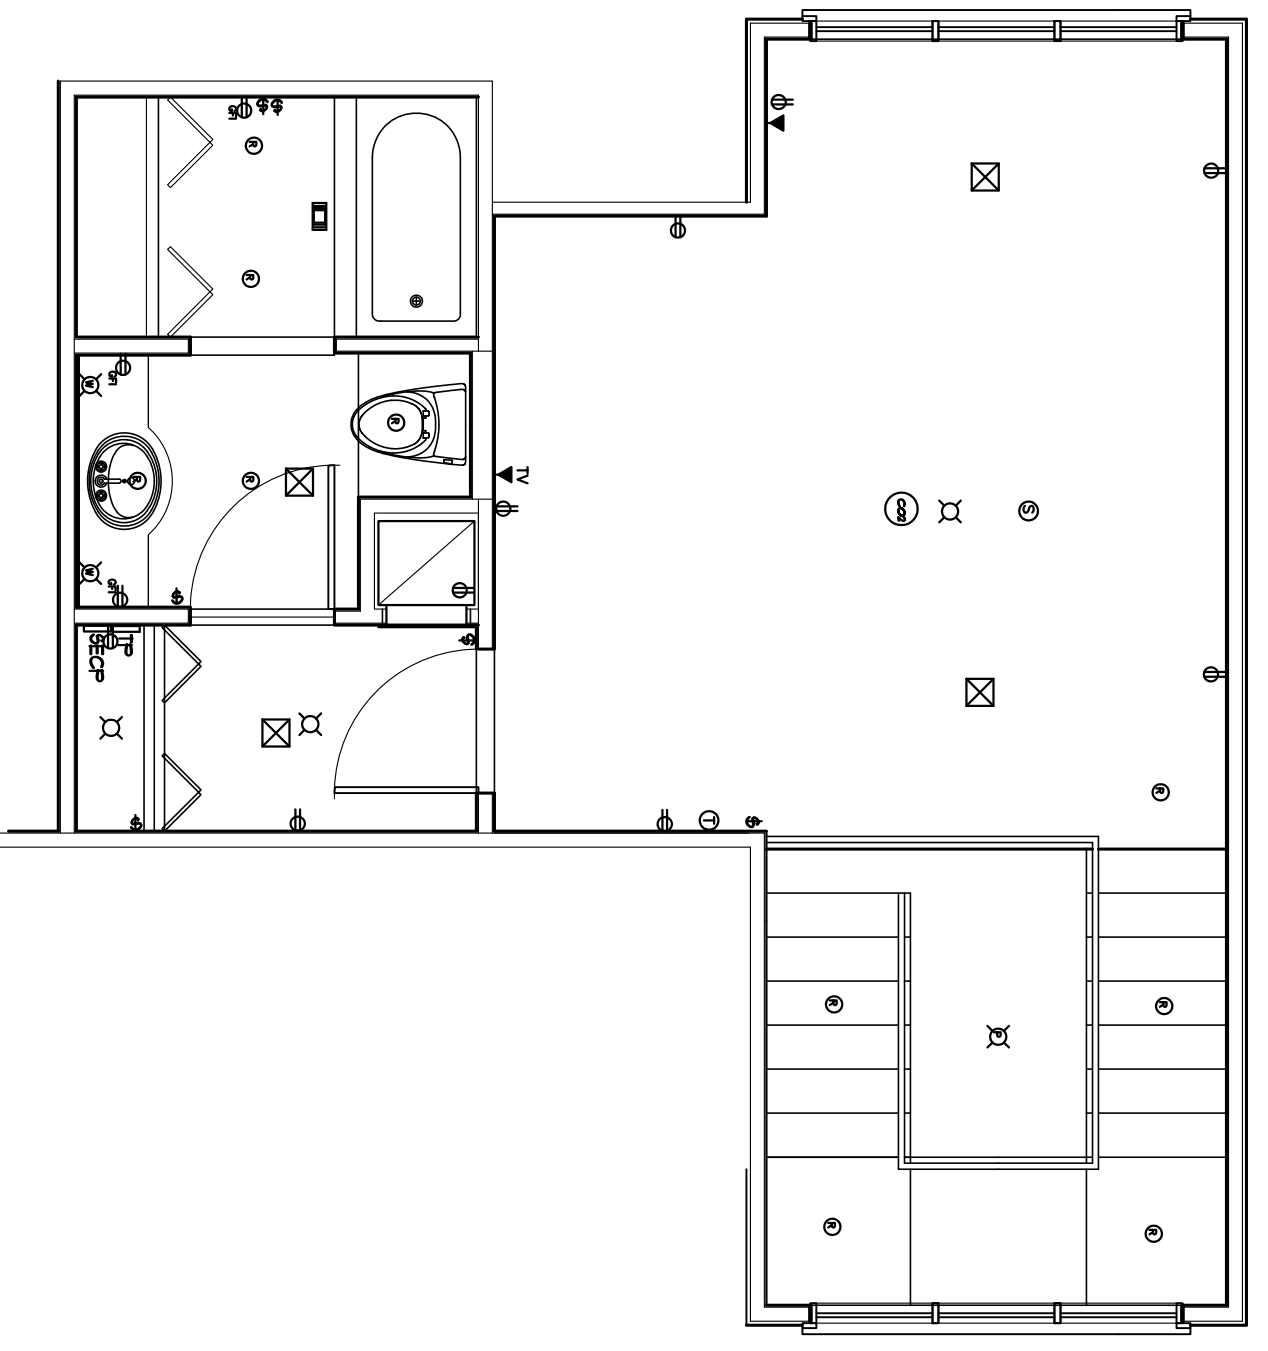

Second Floor HVAC Plan  
Scale: 1/4" = 1'-0"

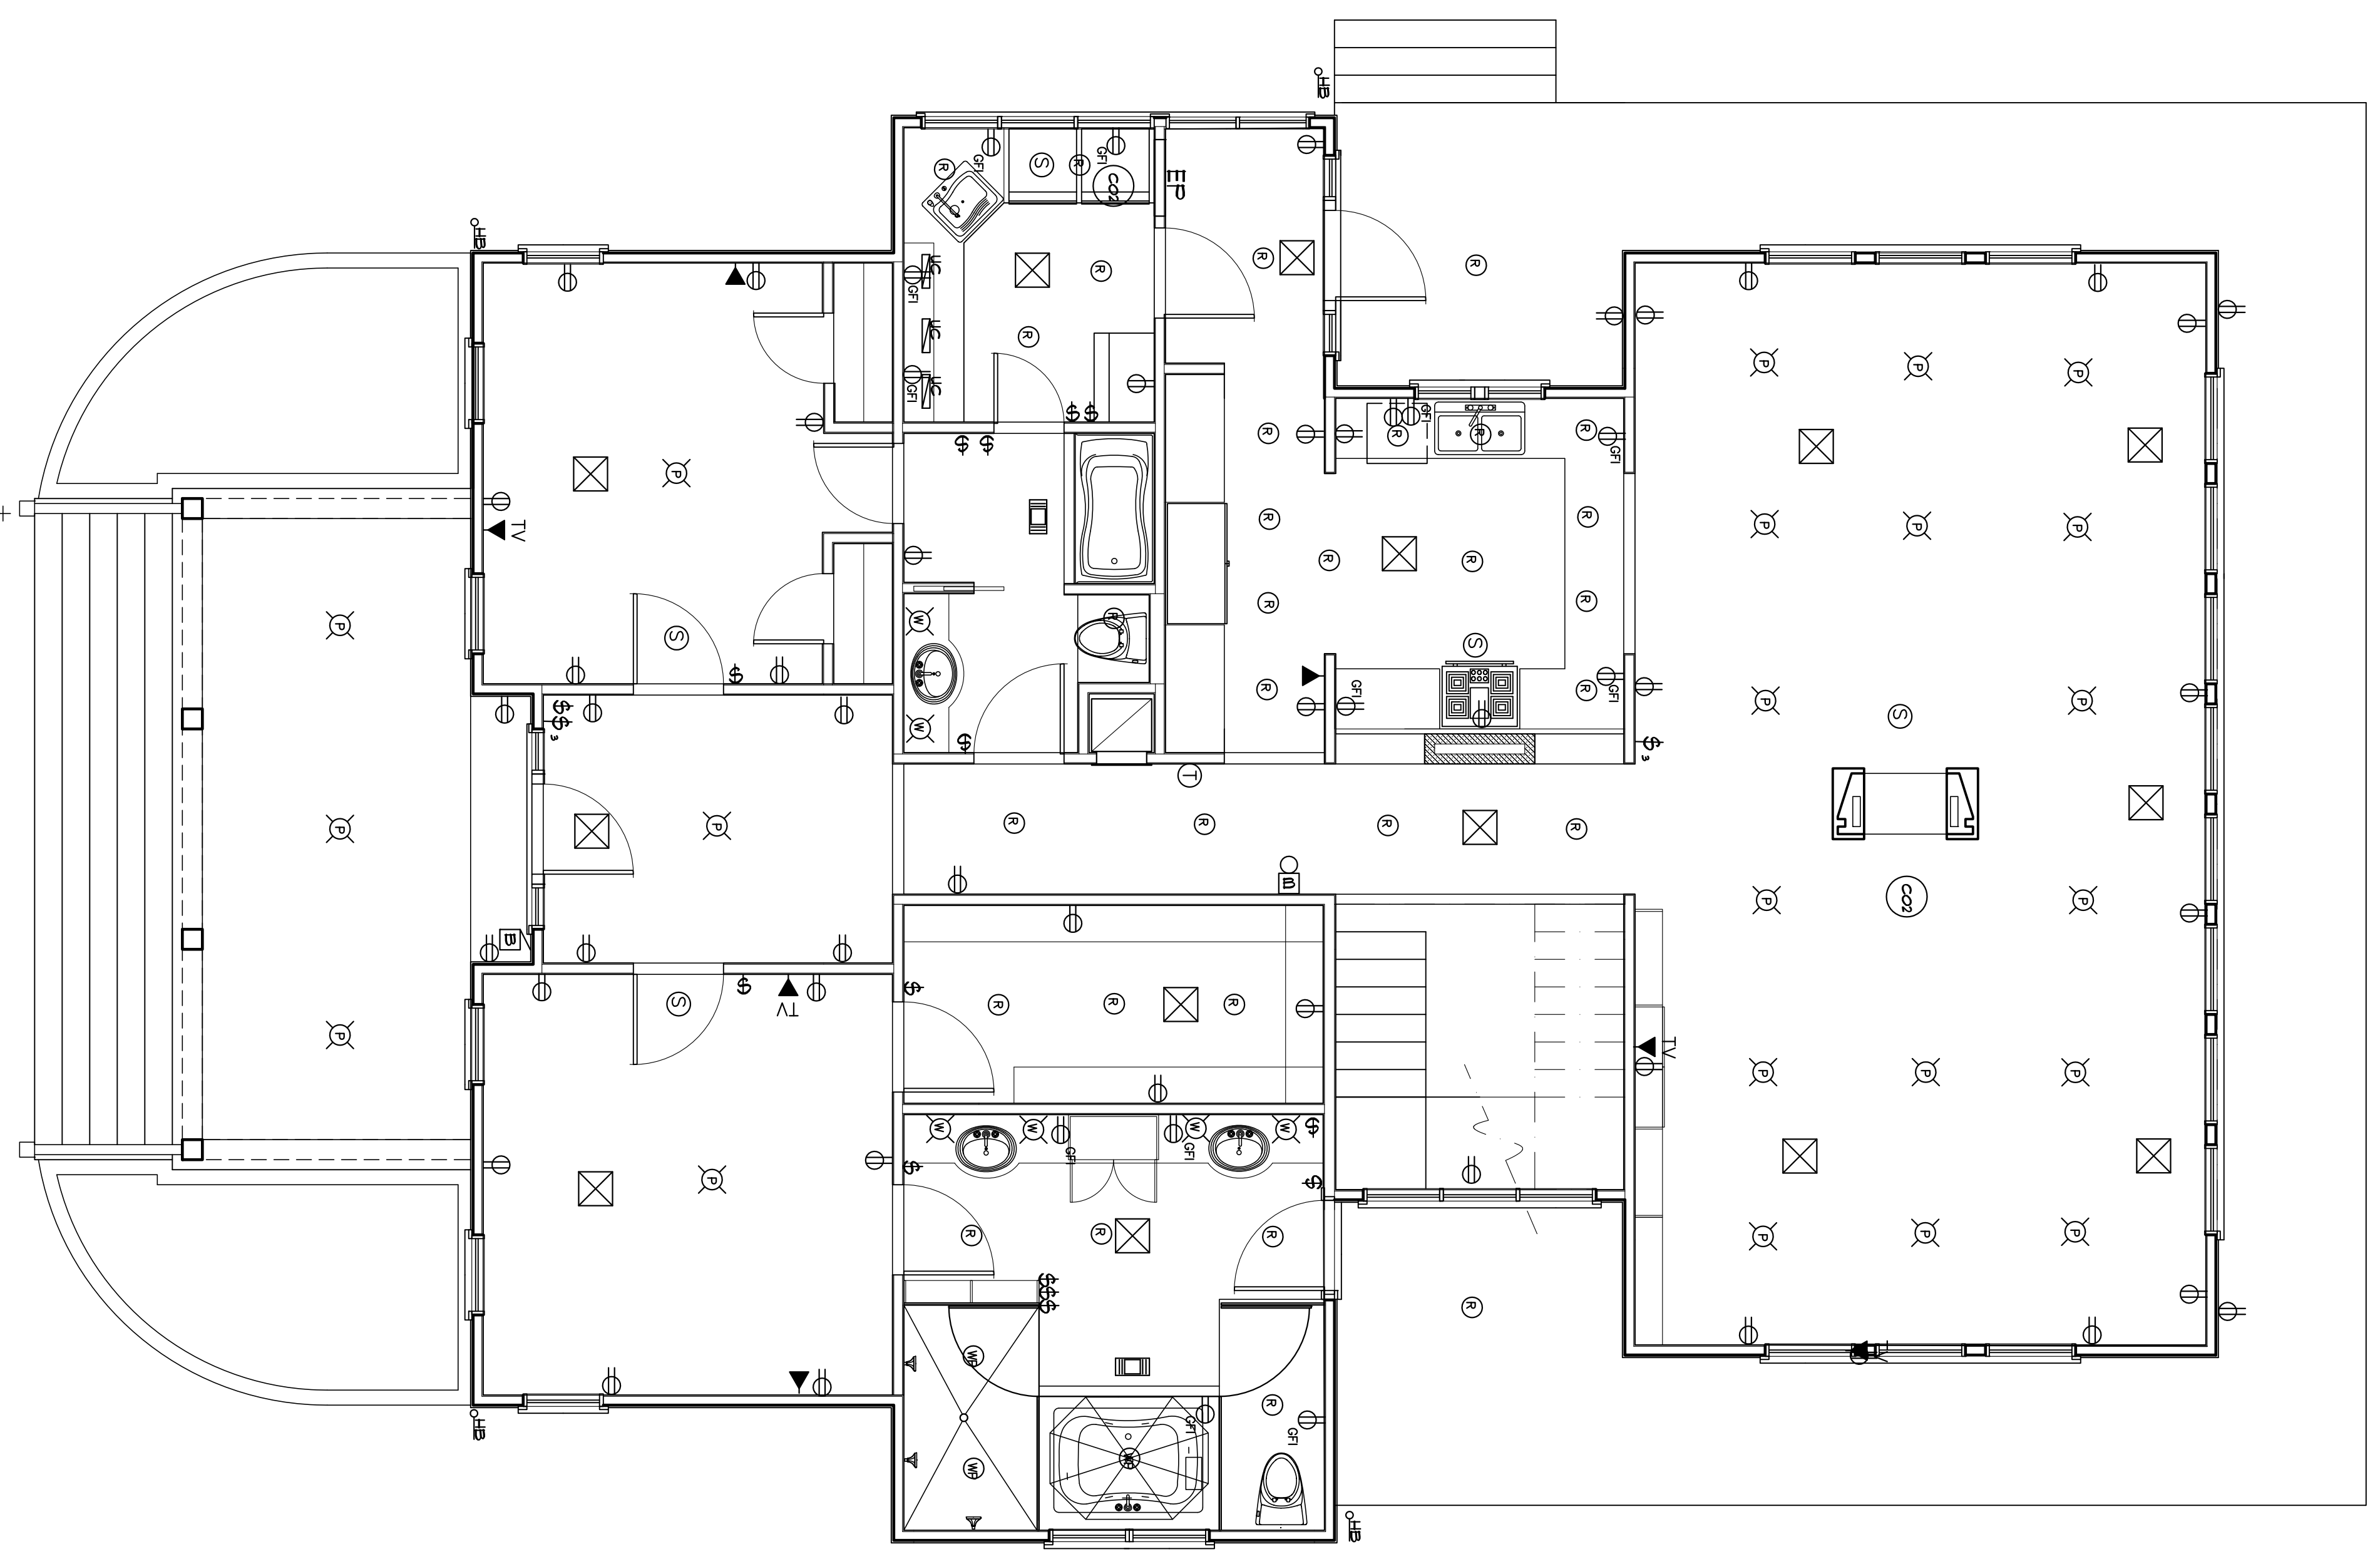

First Floor HVAC Plan  
Scale: 1/4" = 1'-0"

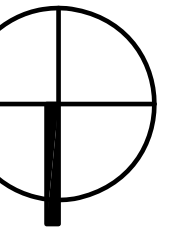

NORTH

These documents are the property of Bailey & Associates Architects LLC. Any duplication in whole or in part must be done with the written consent of Bailey & Associates Architects, LLC

© Bailey & Associates

PROFESSIONAL SEAL

PROJECT NUMBER  
0149.11.07

DATE: August 05, 2008

DRAWN BY: R.E.B.

CHECKED BY:

REVISIONS  
No. Date By

SHEET

M-1